

 
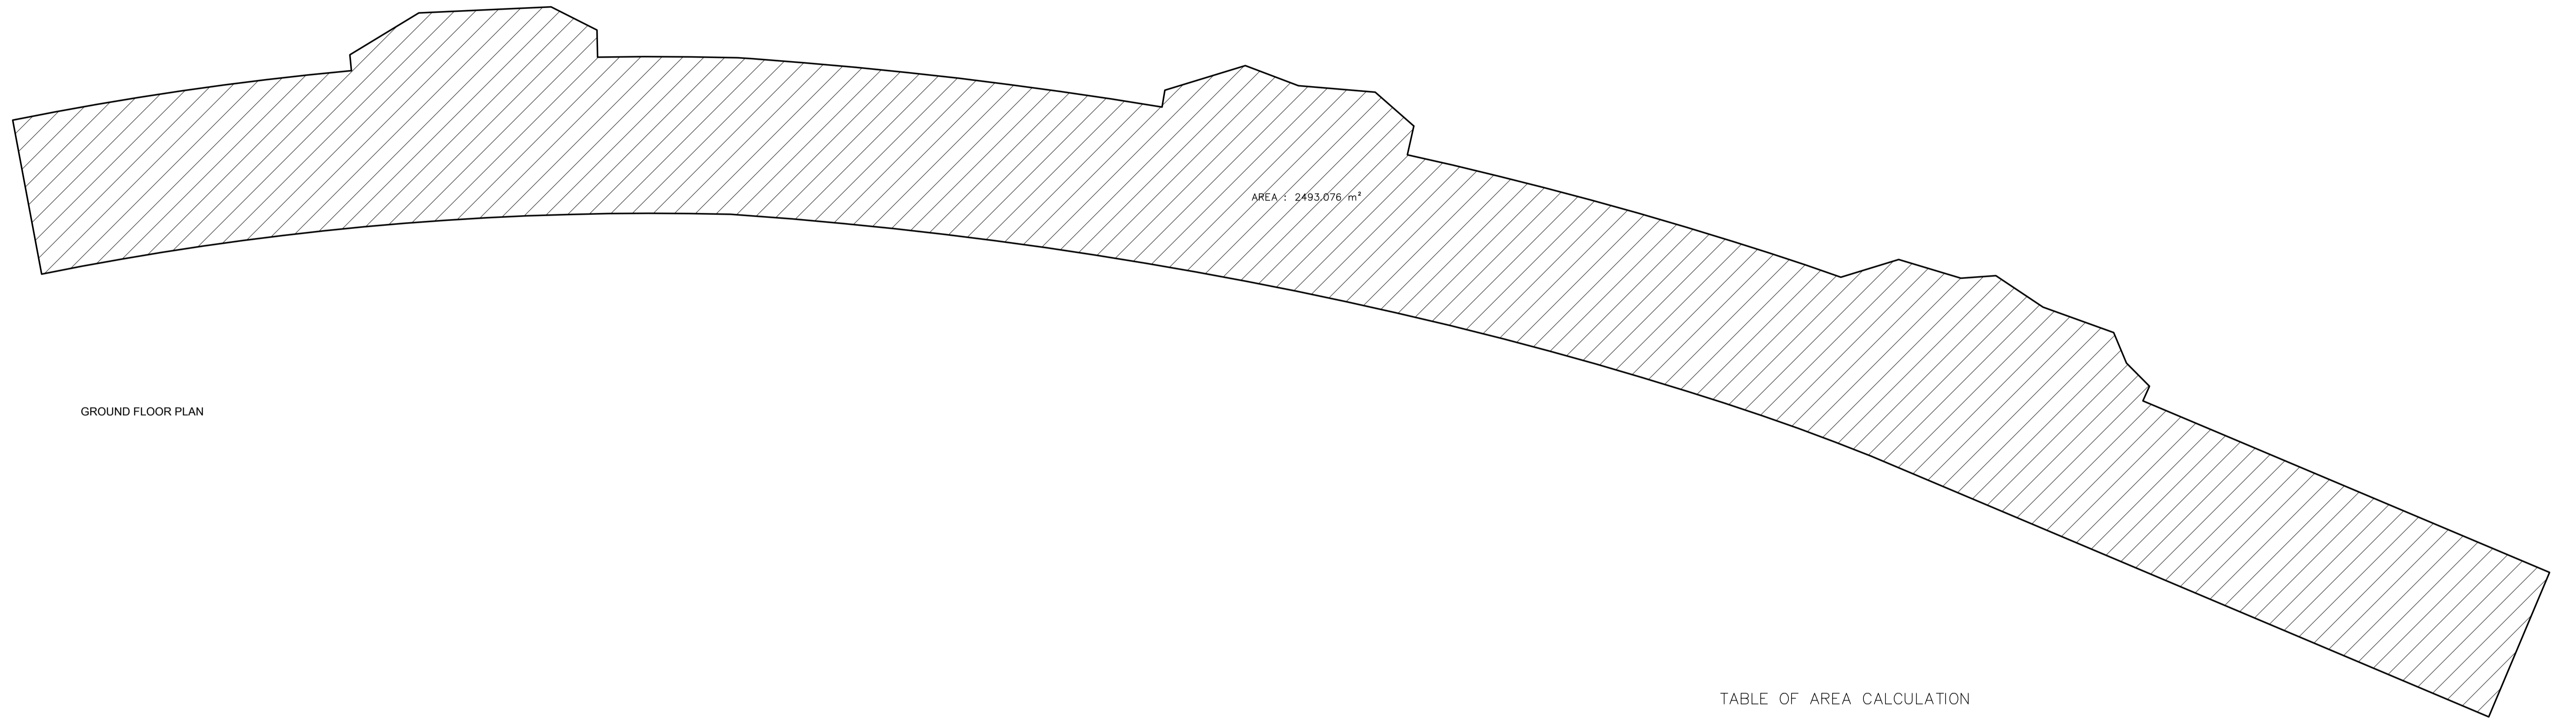


SHEET	DOCUMENT TITLE	SHEET	DOCUMENT TITLE	SHEET	DOCUMENT TITLE	SHEET	DOCUMENT TITLE	
	GENERAL & SITE				ZONE - B		ZONE - A - ROAD 04	
A-000	COVER		ROAD 04 -GROUND FLOOR PLAN - KEY PLAN		PLAZA		LIGHTING DRAWINGS	
A-001	LIST OF DRAWINGS	A-ZA-040	GROUND FLOOR PLAN - KEY PLAN		GENERAL & SITE	SCALE	ROAD 04 -MASTER PLAN	
A-002	MASTER SITE PLAN ZONING	A-ZA-041	GROUND FLOOR PLAN- KEY PLAN - FROM 400-480	A-ZB-005	DEMOLITION PLAN	1:300	A-ZA-010	MASTER SITE PLAN
		A-ZA-042	GROUND FLOOR PLAN- KEY PLAN - FROM 480-550	A-ZB-010	SITE PLAN ZONE B	1:400	A-ZA-011	MASTER SITE PLAN - FROM 400-480
	ZONE - A - ROAD 04	A-ZA-043	GROUND FLOOR PLAN - KEY PLAN- FROM 550-620	A-ZB-011	SITE PLAN TAGS & DIMENSION (PART 1)	1:200	A-ZA-012	MASTER SITE PLAN - FROM 480-550
A-ZA-005	AREA SCHEDULE	A-ZA-044	GROUND FLOOR PLAN - KEY PLAN- FROM 620-690	A-ZB-012	SITE PLAN TAGS & DIMENSION (PART 2)	1:200	A-ZA-013	MASTER SITE PLAN - FROM 550-620
	ROAD 04 -MASTER PLAN	A-ZA-045	GROUND FLOOR PLAN - KEY PLAN- FROM 380-450	A-ZB-013	SITE PLAN ZONE B (Key Plan)	1:400	A-ZA-014	MASTER SITE PLAN - FROM 620-690
A-ZA-010	MASTER SITE PLAN		ROAD 04 -RETAINING WALLS	A-ZB-014	SITE PLAN TAGS & DIMENSION (PART 1)	1:100	A-ZA-015	MASTER SITE PLAN - FROM 690-750
A-ZA-011	MASTER SITE PLAN - FROM 400-480	A-ZA-200	RETAINING WALLS DRAWINGS	A-ZB-015	SITE PLAN TAGS & DIMENSION (PART 2)	1:100	A-ZA-016	MASTER SITE PLAN - FROM 750-800
A-ZA-012	MASTER SITE PLAN - FROM 480-550			A-ZB-016	SITE PLAN TAGS & DIMENSION (PART 3)	1:100		
A-ZA-013	MASTER SITE PLAN - FROM 550-620		ROAD 04 -SECTIONS	A-ZB-017	SITE PLAN TAGS & DIMENSION (PART 4)	1:100		ROAD 04 -GROUND FLOOR PLAN
A-ZA-014	MASTER SITE PLAN - FROM 620-690	A-ZA-300	SECTIONS 450-530	A-ZB-018	SITE PLAN SLOPE ANALYSIS (PART 1)	1:200	A-ZA-030	GROUND FLOOR PLAN
A-ZA-015	MASTER SITE PLAN - FROM 690-750	A-ZA-301	SECTIONS 540-620	A-ZB-019	SITE PLAN SLOPE ANALYSIS (PART 2)	1:200	A-ZA-031	GROUND FLOOR PLAN - FROM 400-480
A-ZA-016	MASTER SITE PLAN - FROM 750-800	A-ZA-302	SECTIONS 630-710	A-ZB-020	SITE PLAN LIGHTING PLAN (PART 1)	1:200	A-ZA-032	GROUND FLOOR PLAN - FROM 480-550
		A-ZA-303	SECTIONS 720-800	A-ZB-021	SITE PLAN LIGHTING PLAN (PART 1)	1:200	A-ZA-033	GROUND FLOOR PLAN - FROM 550-620
	ROAD 04 -MASTER PLAN -KEY PLAN			A-ZB-022	LIGHTING SCHEDULE		A-ZA-034	GROUND FLOOR PLAN - FROM 620-690
A-ZA-020	MASTER SITE PLAN - KEY PLAN		ROAD 04 -ELEVATIONS				A-ZA-035	GROUND FLOOR PLAN - FROM 380-450
A-ZA-021	MASTER SITE PLAN - KEY PLAN - FROM 400-480	A-ZA-400	ELEVATIONS		PLAZA ELEVATIONS & SECTIONS		A-ZA-036	LIGHTING SCHEDULE
A-ZA-022	MASTER SITE PLAN - KEY PLAN - FROM 480-550	A-ZA-401	ELEVATIONS	A-ZB-030	ELEVATION & SECTIONS	1:100		
A-ZA-023	MASTER SITE PLAN - KEY PLAN - FROM 550-620			A-ZB-031	SECTIONS	1:100		
A-ZA-024	MASTER SITE PLAN - KEY PLAN - FROM 620-690		HARD LANDSCAPE DETAILS		SITE DETAILS			
A-ZA-025	MASTER SITE PLAN - KEY PLAN - FROM 690-750	A-ZA-700	HARD LANDSCAPE DETAILS	A-ZB-070	SITE DETAILS (1)	as shown		
A-ZA-026	MASTER SITE PLAN - KEY PLAN - FROM 750-800	A-ZA-701	RAILING DETAILS	A-ZB-071	SITE DETAILS (2)	as shown		
				A-ZB-072	SITE DETAILS (3)	as shown		
			STAIRS DETAILS	A-ZB-073	SITE DETAILS (4)	as shown		
	ROAD 04 -GROUND FLOOR PLAN	A-ZA-900	STAIRS DETAILS	A-ZB-074	FINISHES LAYOUT	as shown		
A-ZA-030	GROUND FLOOR PLAN	A901	STAIRS DETAILS		TOILETS ENLARGEMENT			
A-ZA-031	GROUND FLOOR PLAN - FROM 400-480	A902	STAIRS DETAILS	A-ZB-100	GROUND FLOOR - DIMENSION PLAN & AREA	1:50		
A-ZA-032	GROUND FLOOR PLAN - FROM 480-550			A-ZB-101	GROUND FLOOR - TILING PLAN	1:50		
A-ZA-033	GROUND FLOOR PLAN - FROM 550-620			A-ZB-200	TOILET ELEVATION & SECTIONS	1:50		
A-ZA-034	GROUND FLOOR PLAN - FROM 620-690			A-ZB-300	WALL SECTION & SINK DETAIL	as shown		
A-ZA-035	GROUND FLOOR PLAN - FROM 380-450							




ZONE - A	
ZONE - B	

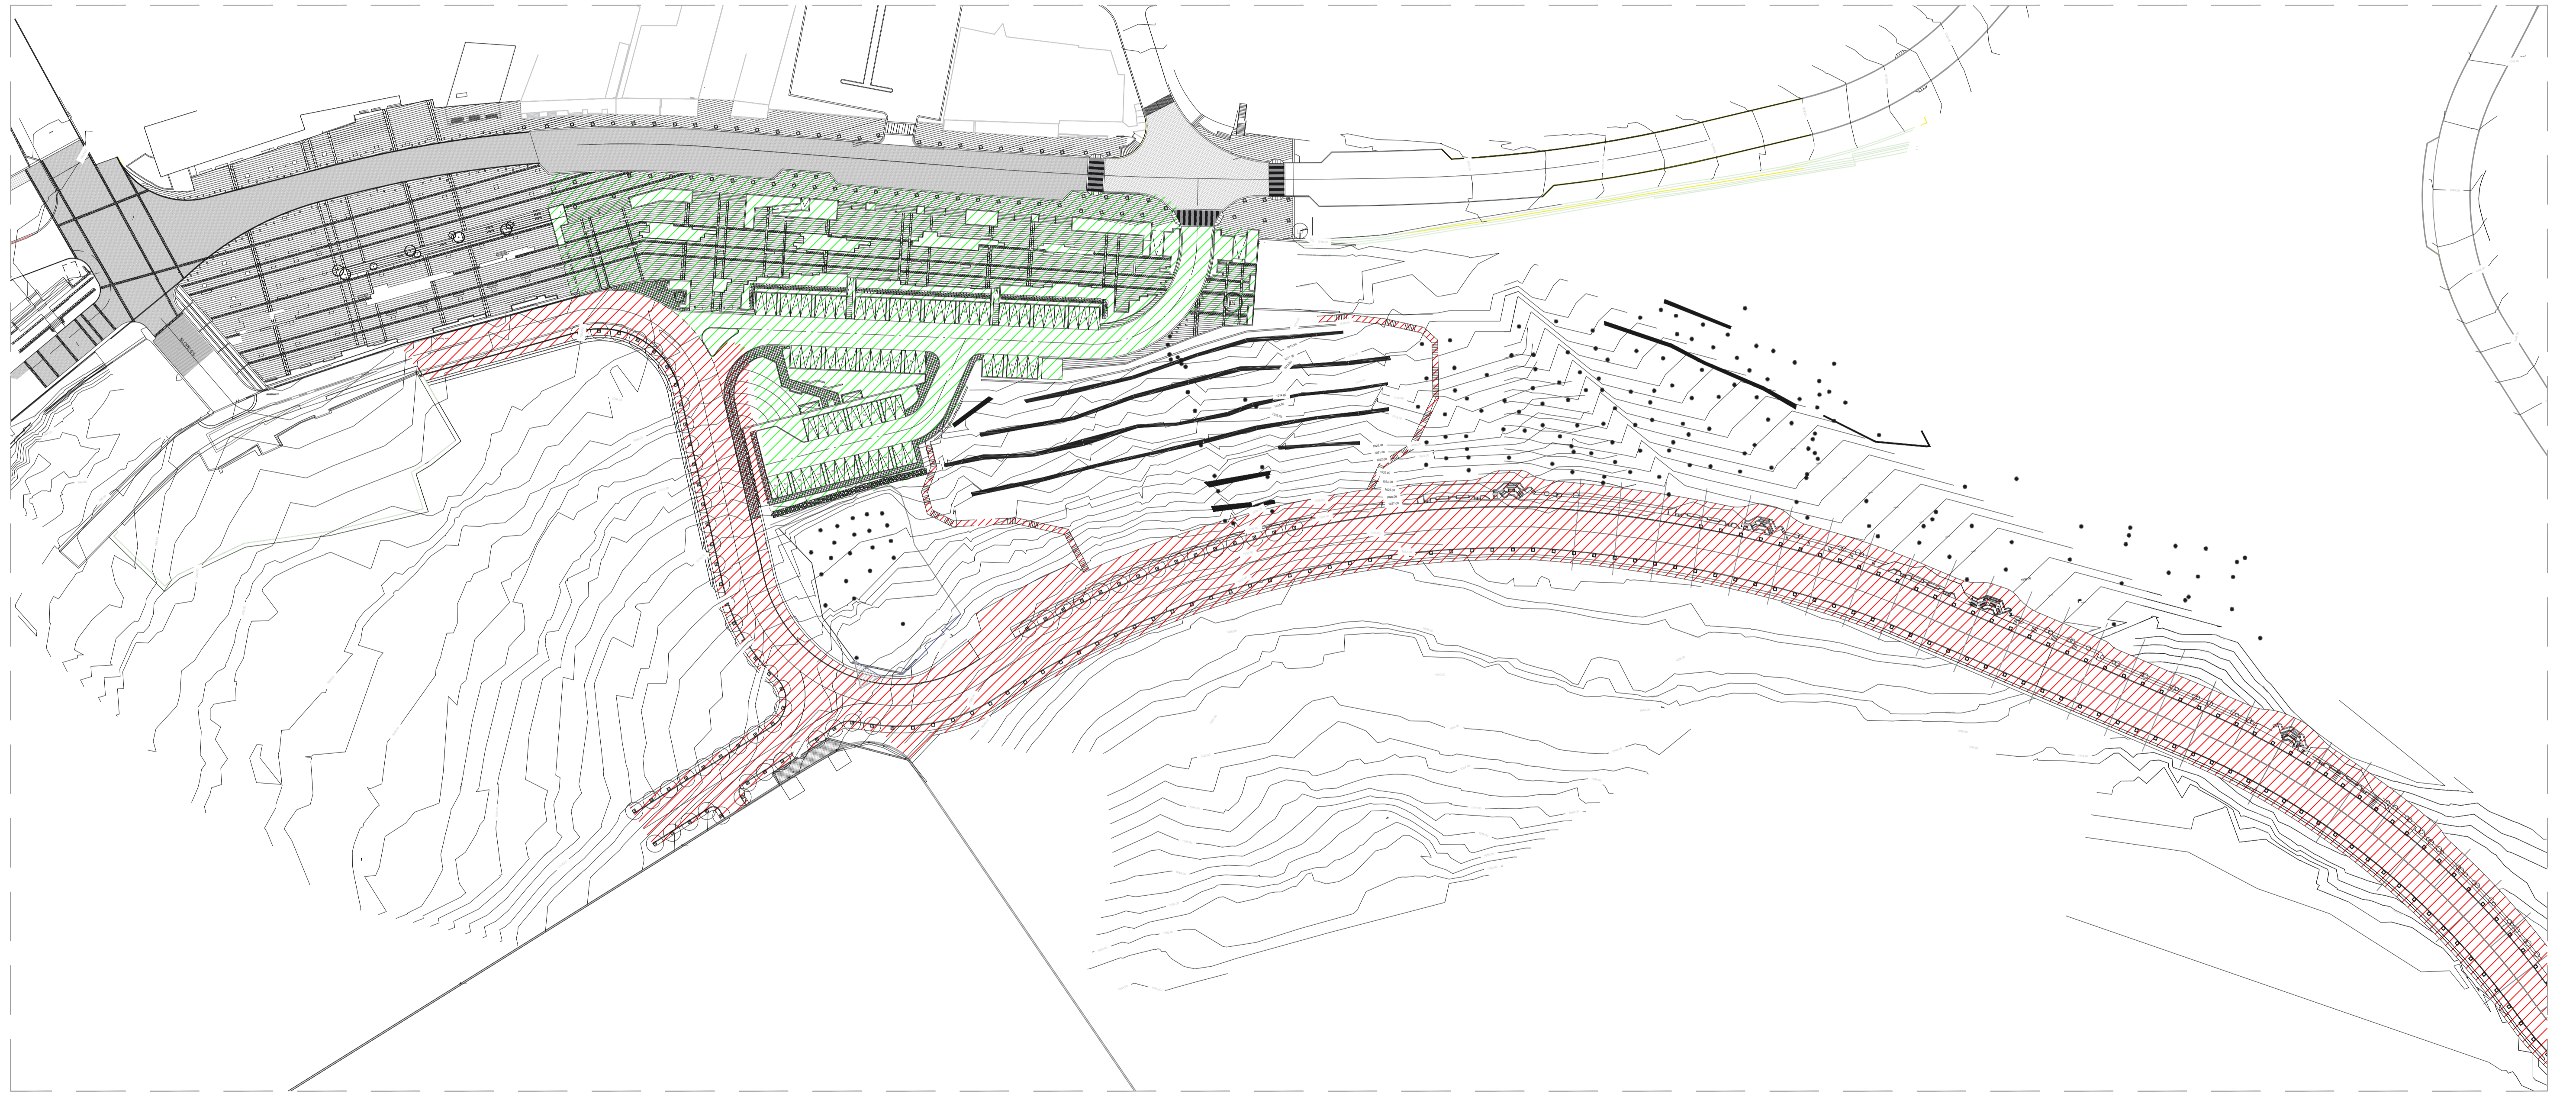



GROUND FLOOR PLAN


TABLE OF AREA CALCULATION

FLOOR	AREA/m ²
GROUND FLOOR	2493.07
TOTAL AREA :	2493.0700 m ²

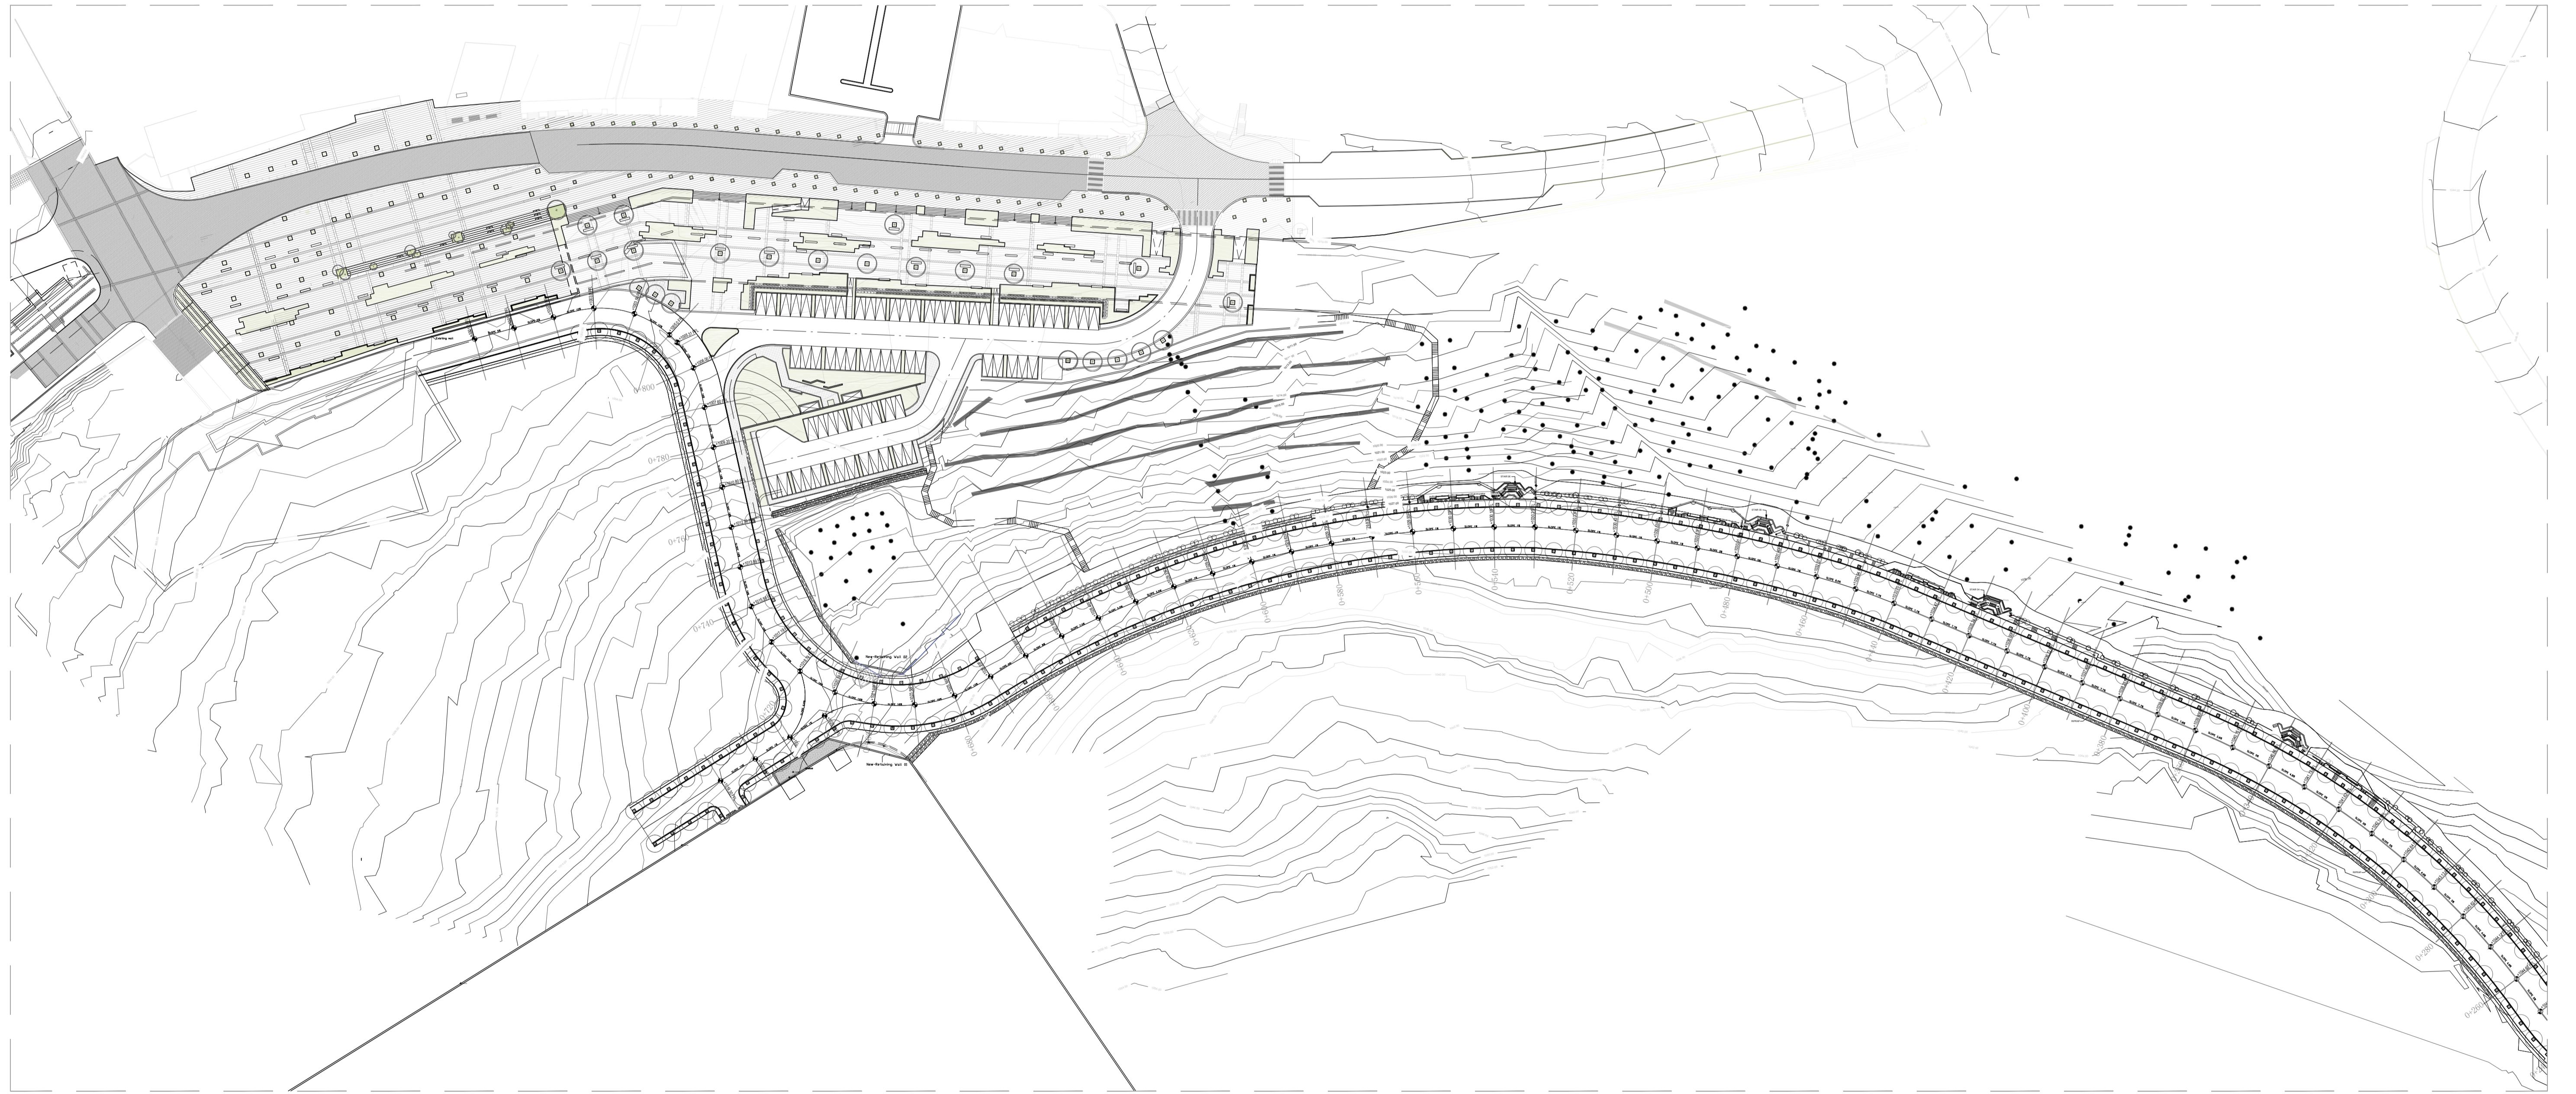

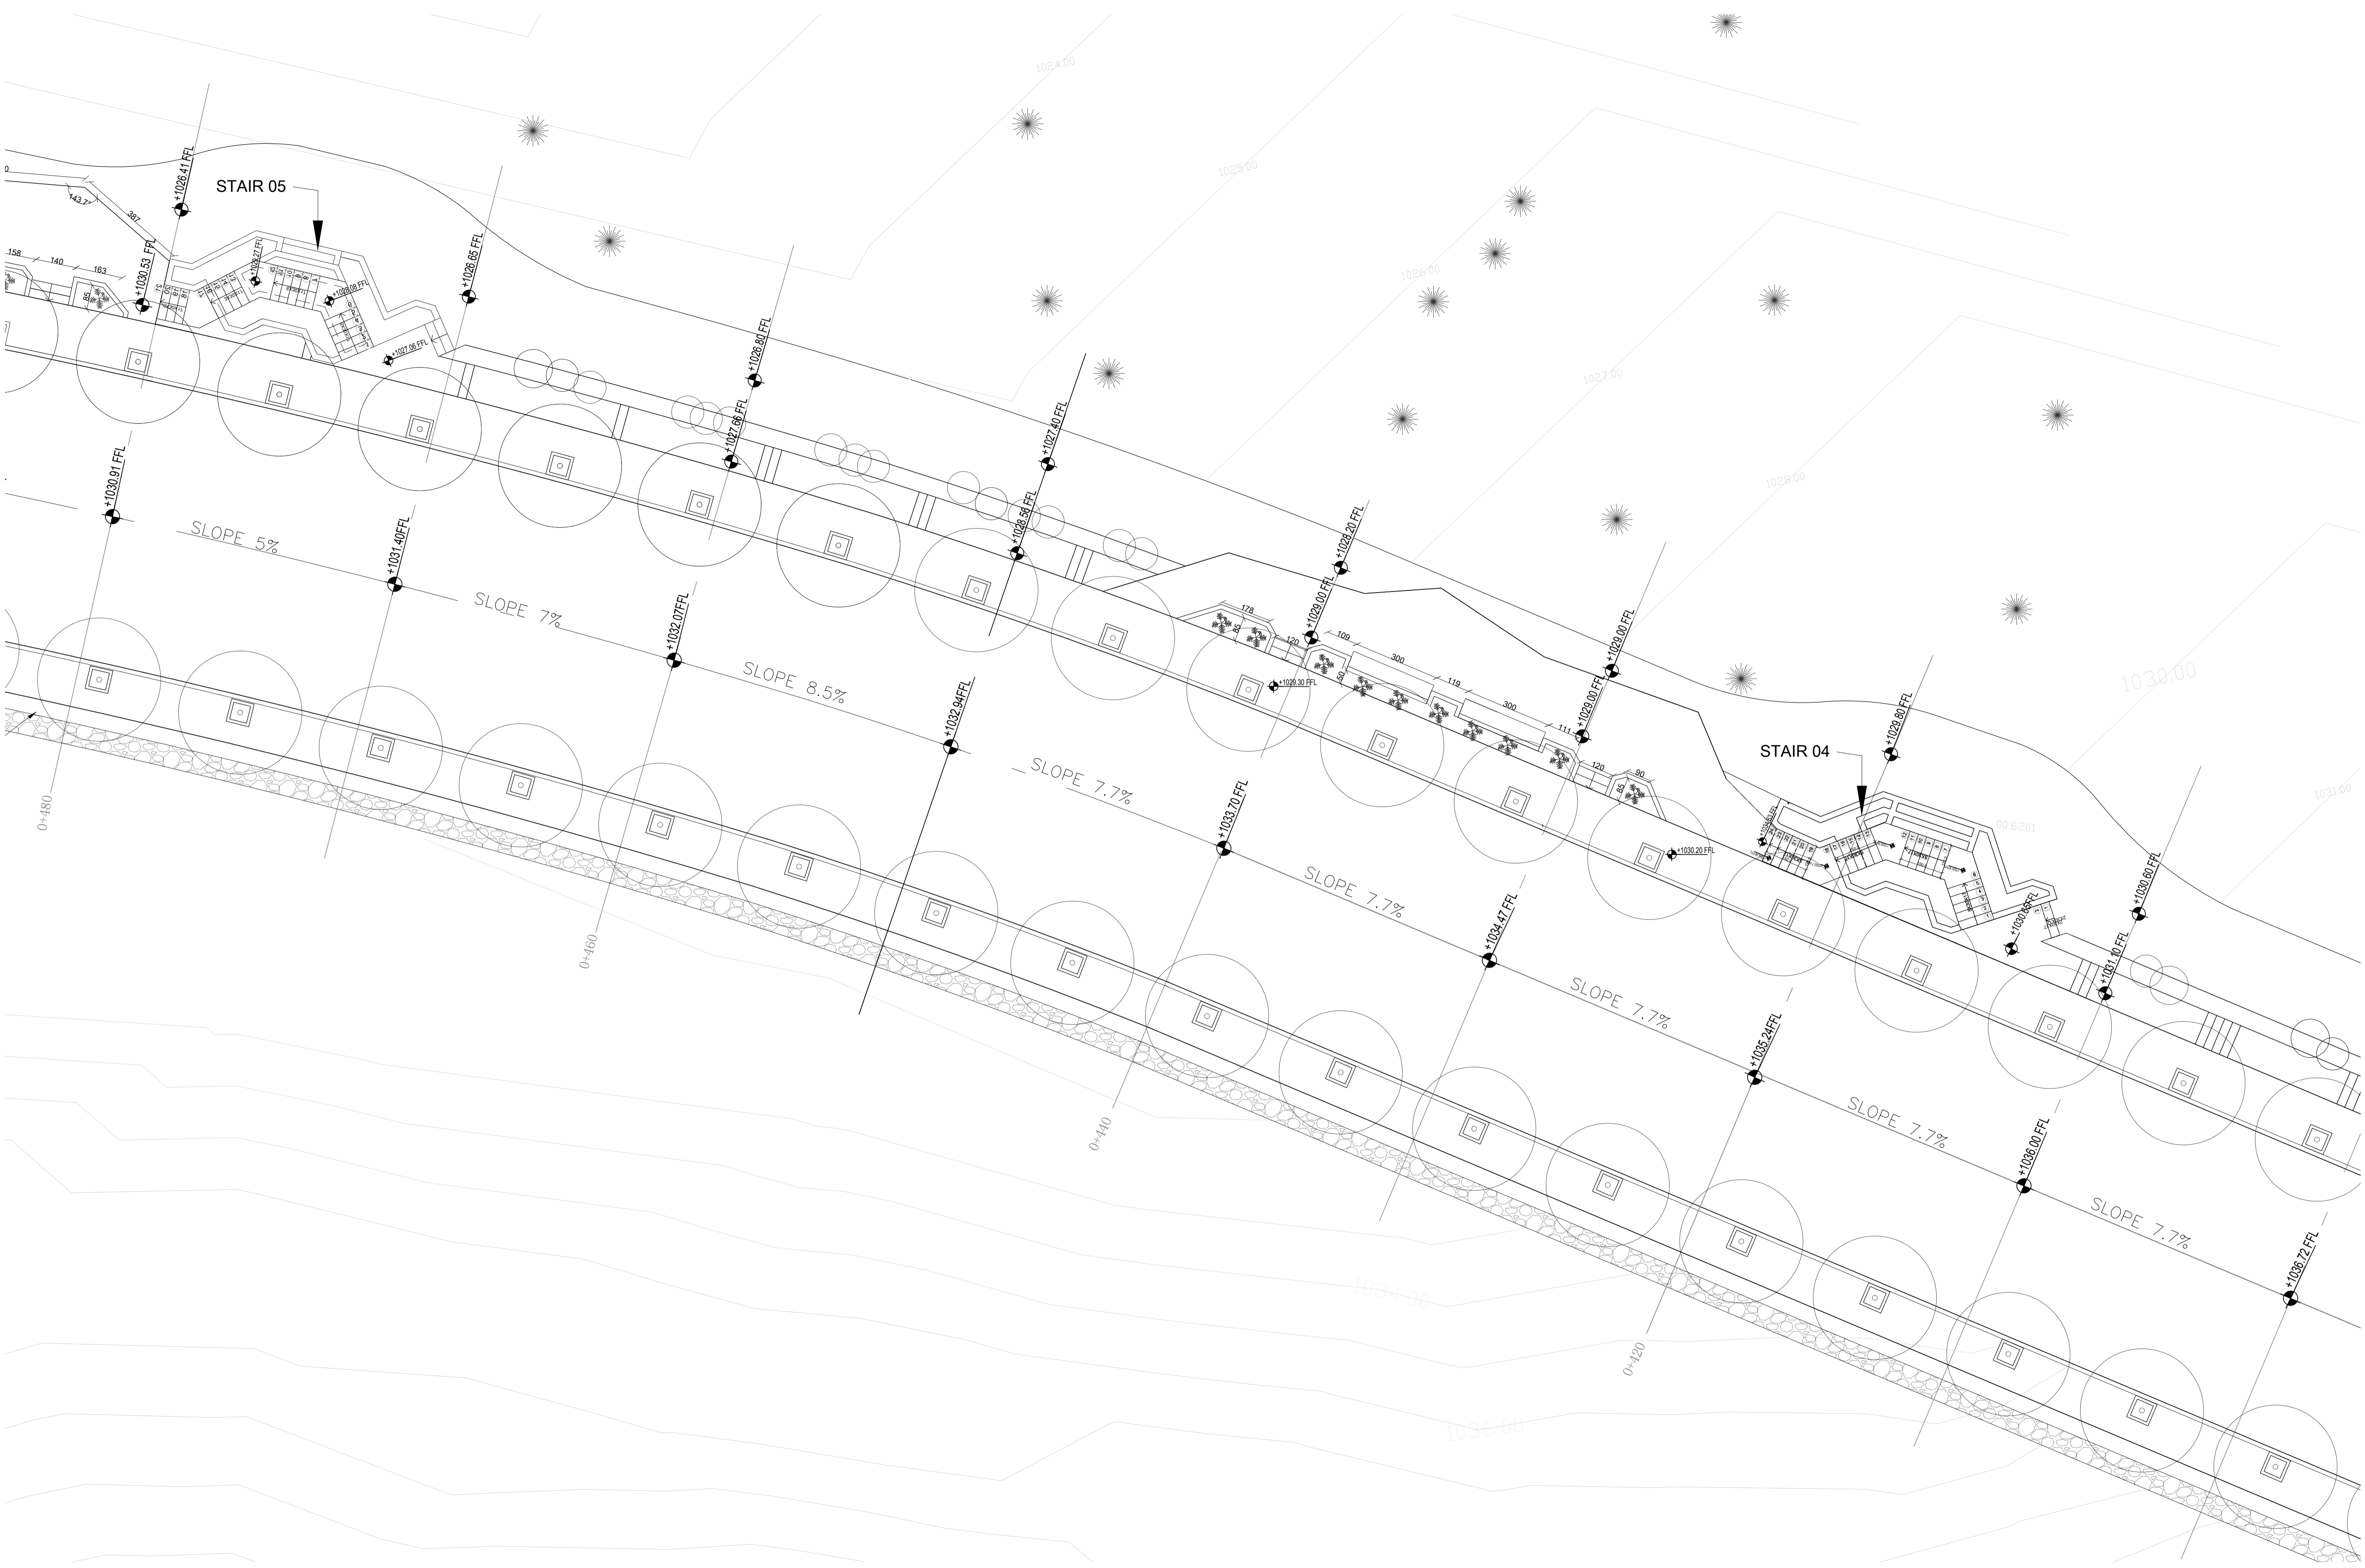


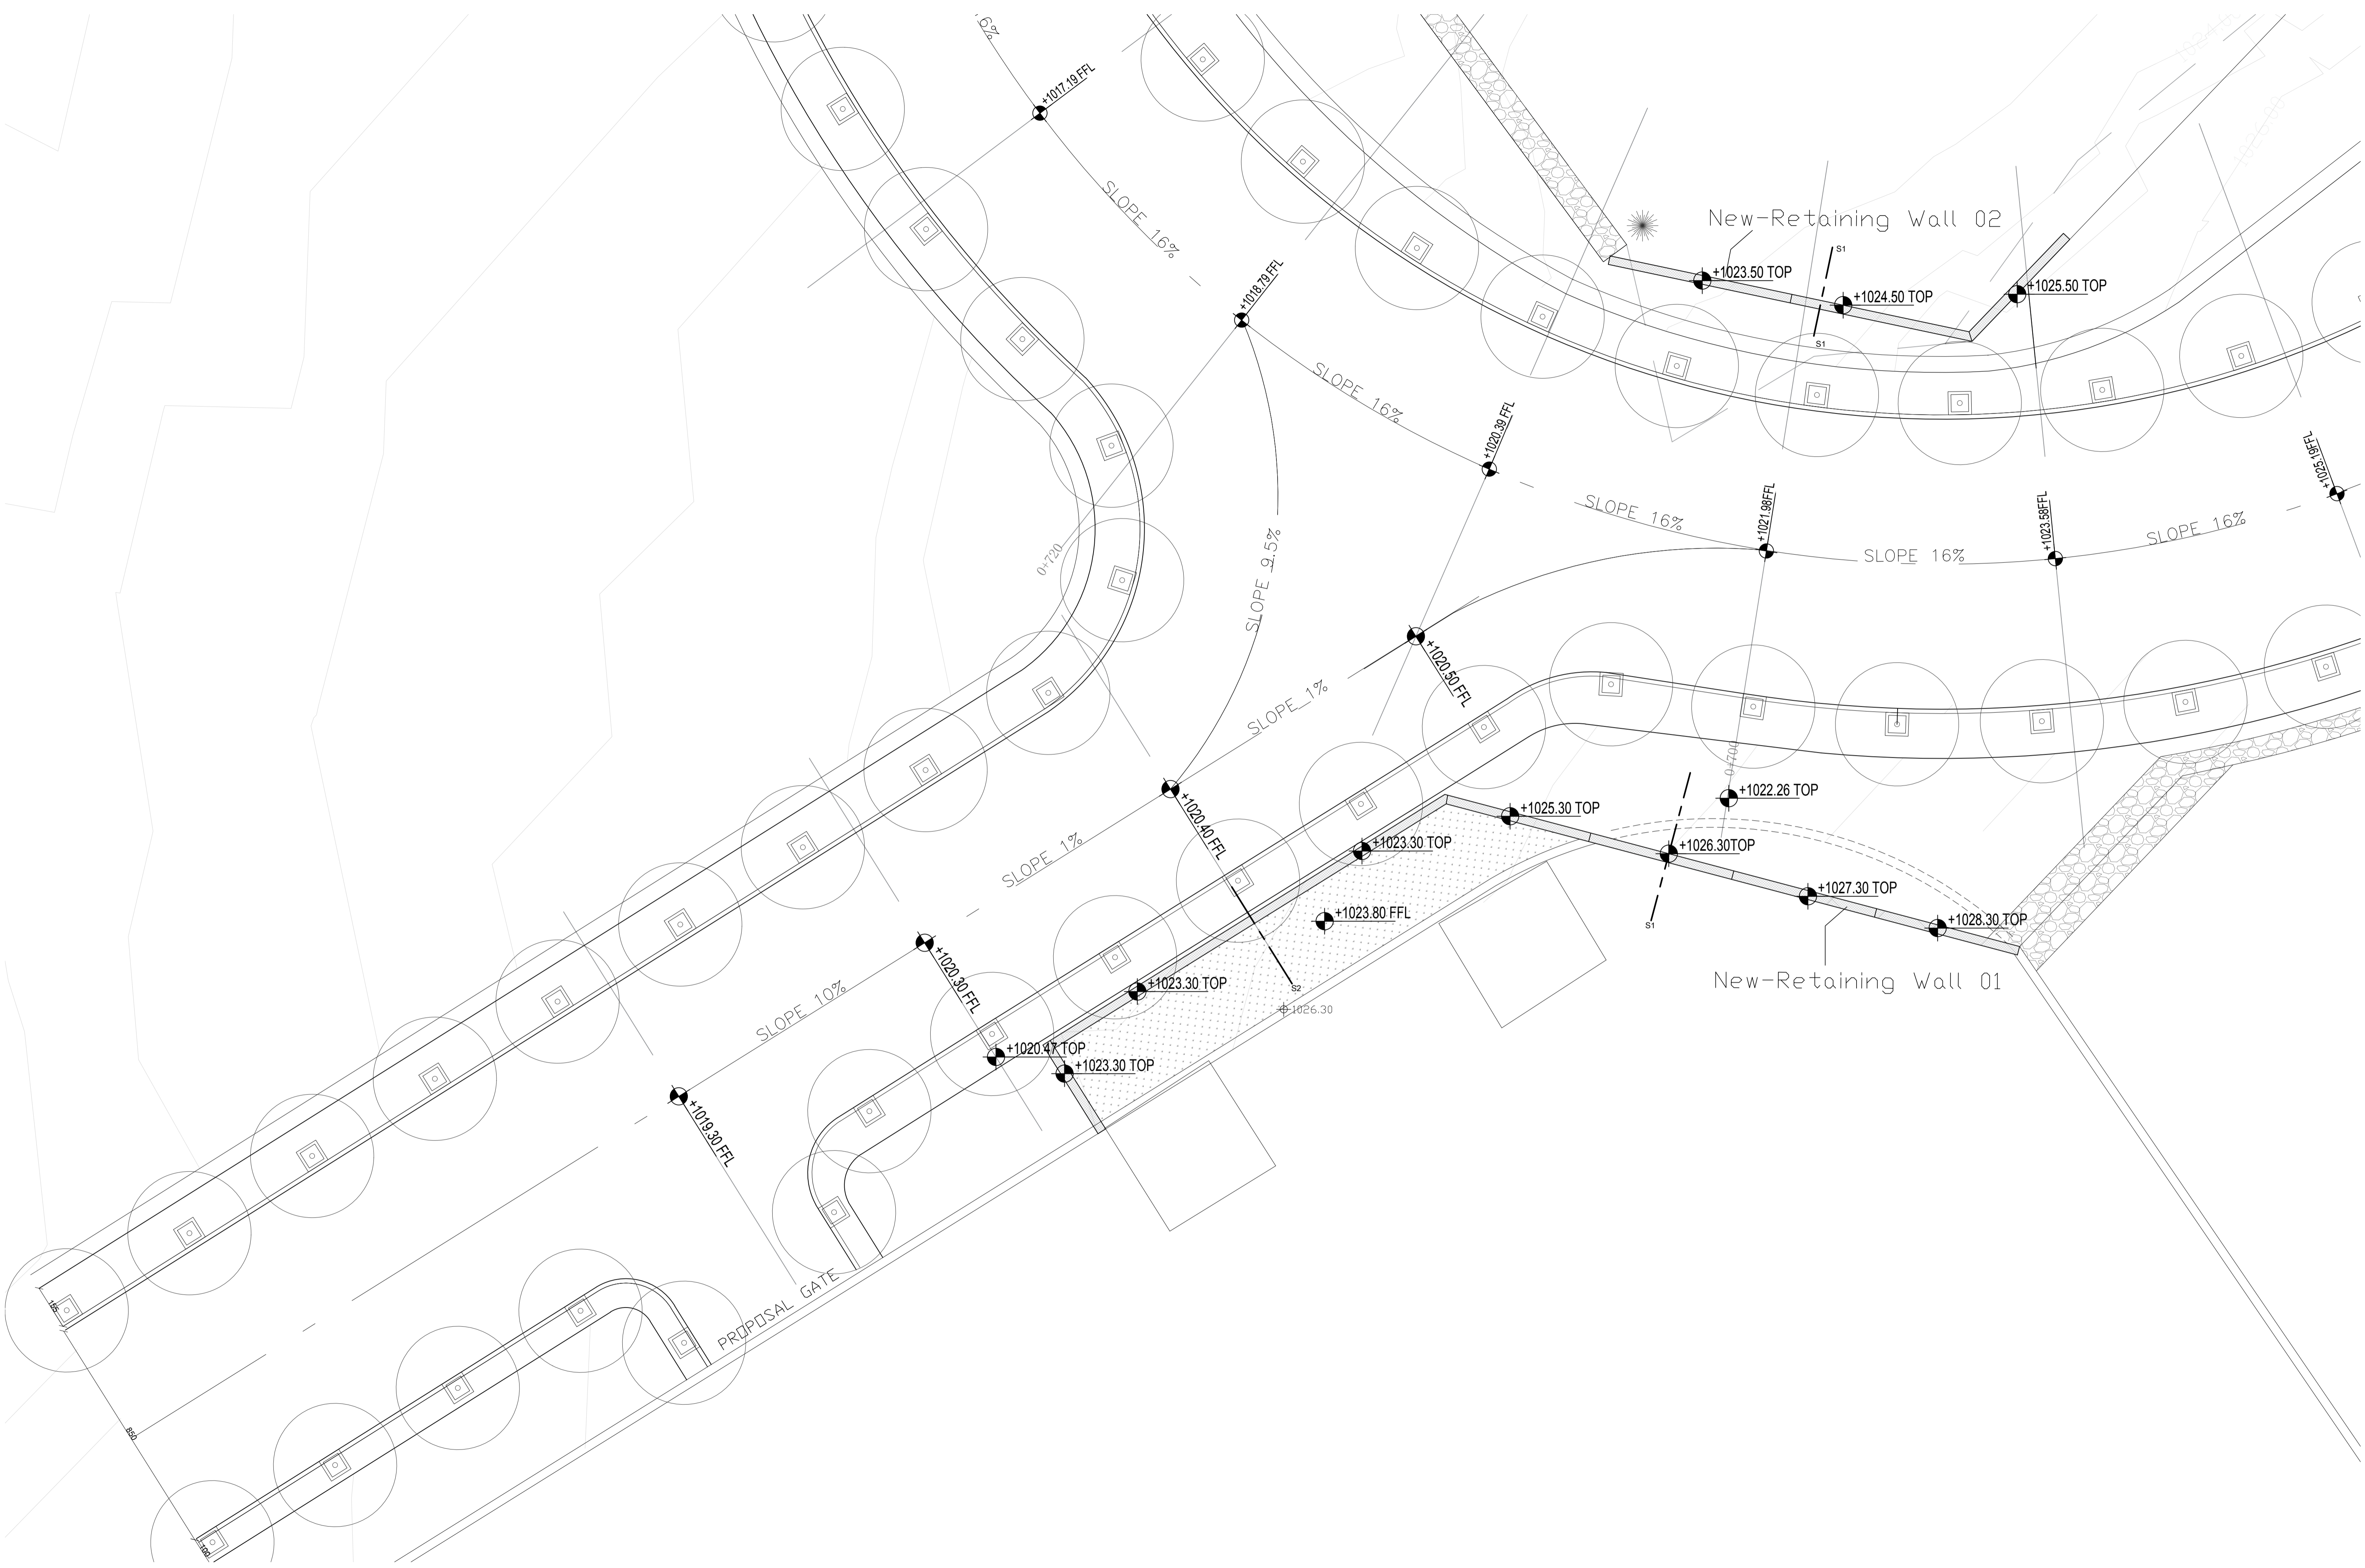

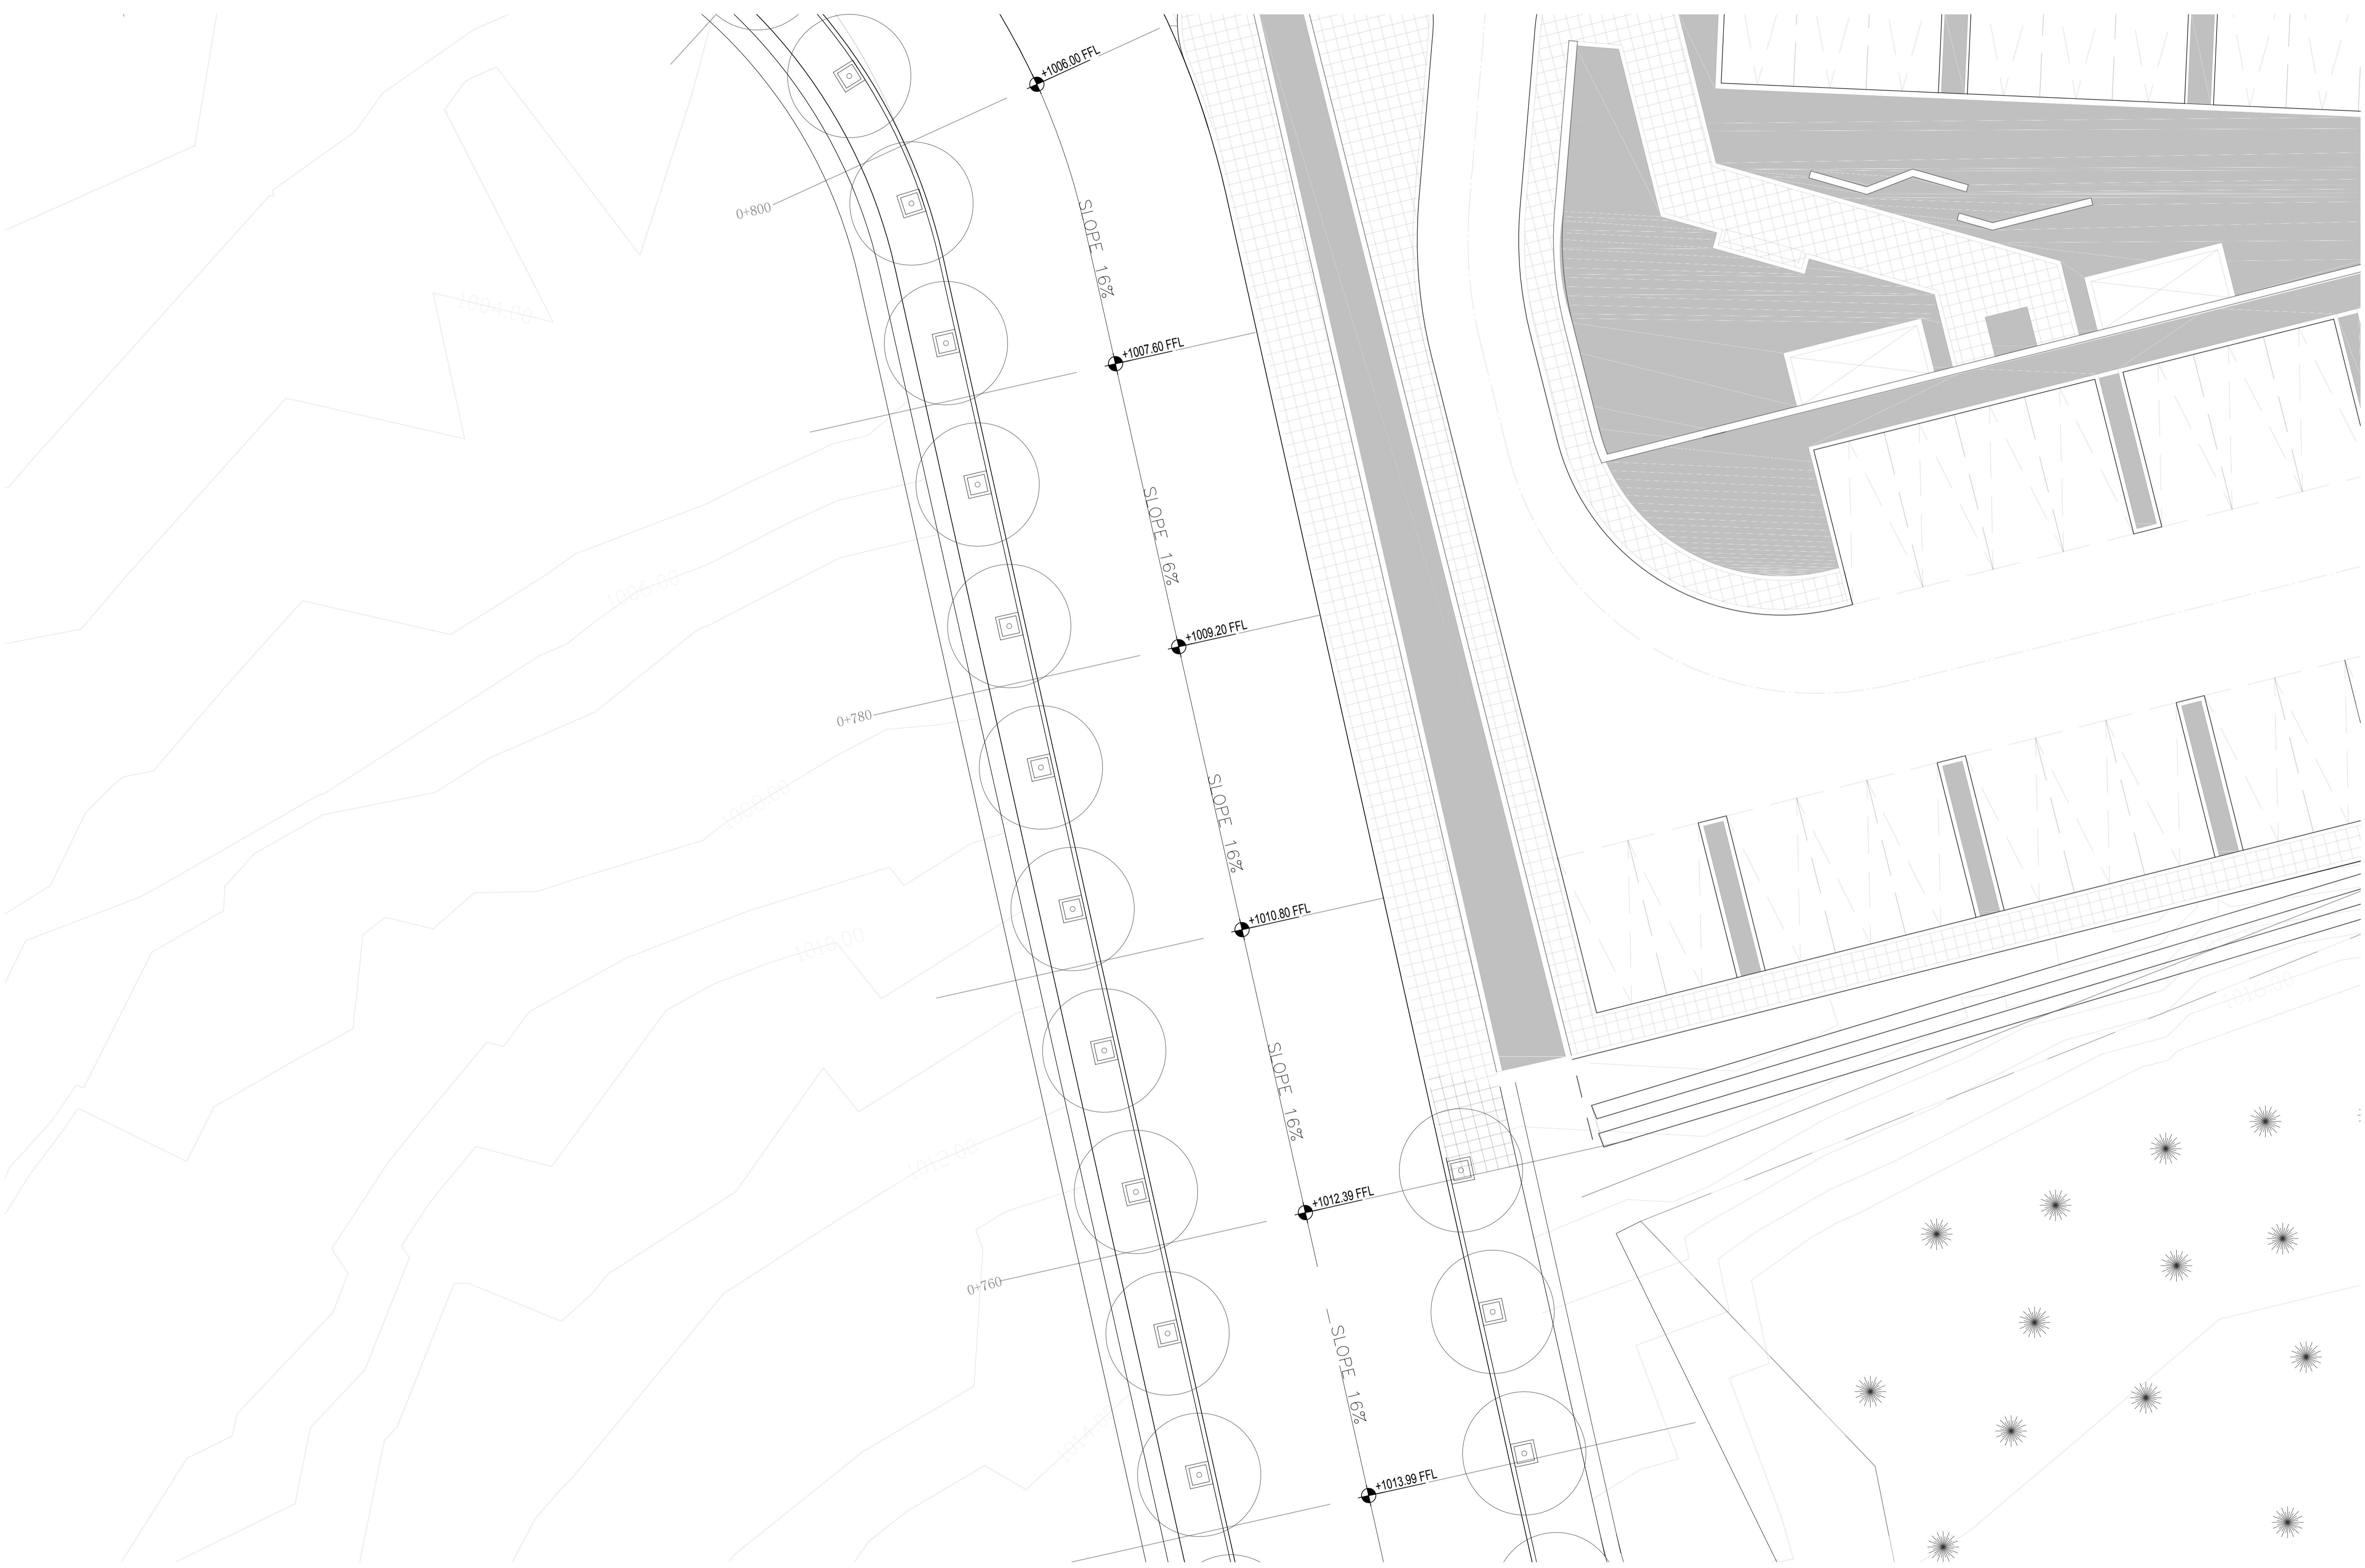





DESCRIPTION	HATCH COLOR
بلاط اسمنتي بحصة سيل 40X40X4cm	
AILOUN STONE STAIR TREADS-4cm STAIR RISERS- 2cm	
BENCHES	
PLANTERS 01	
PLANTERS 02	
RAILING 01	
RAILING 02	

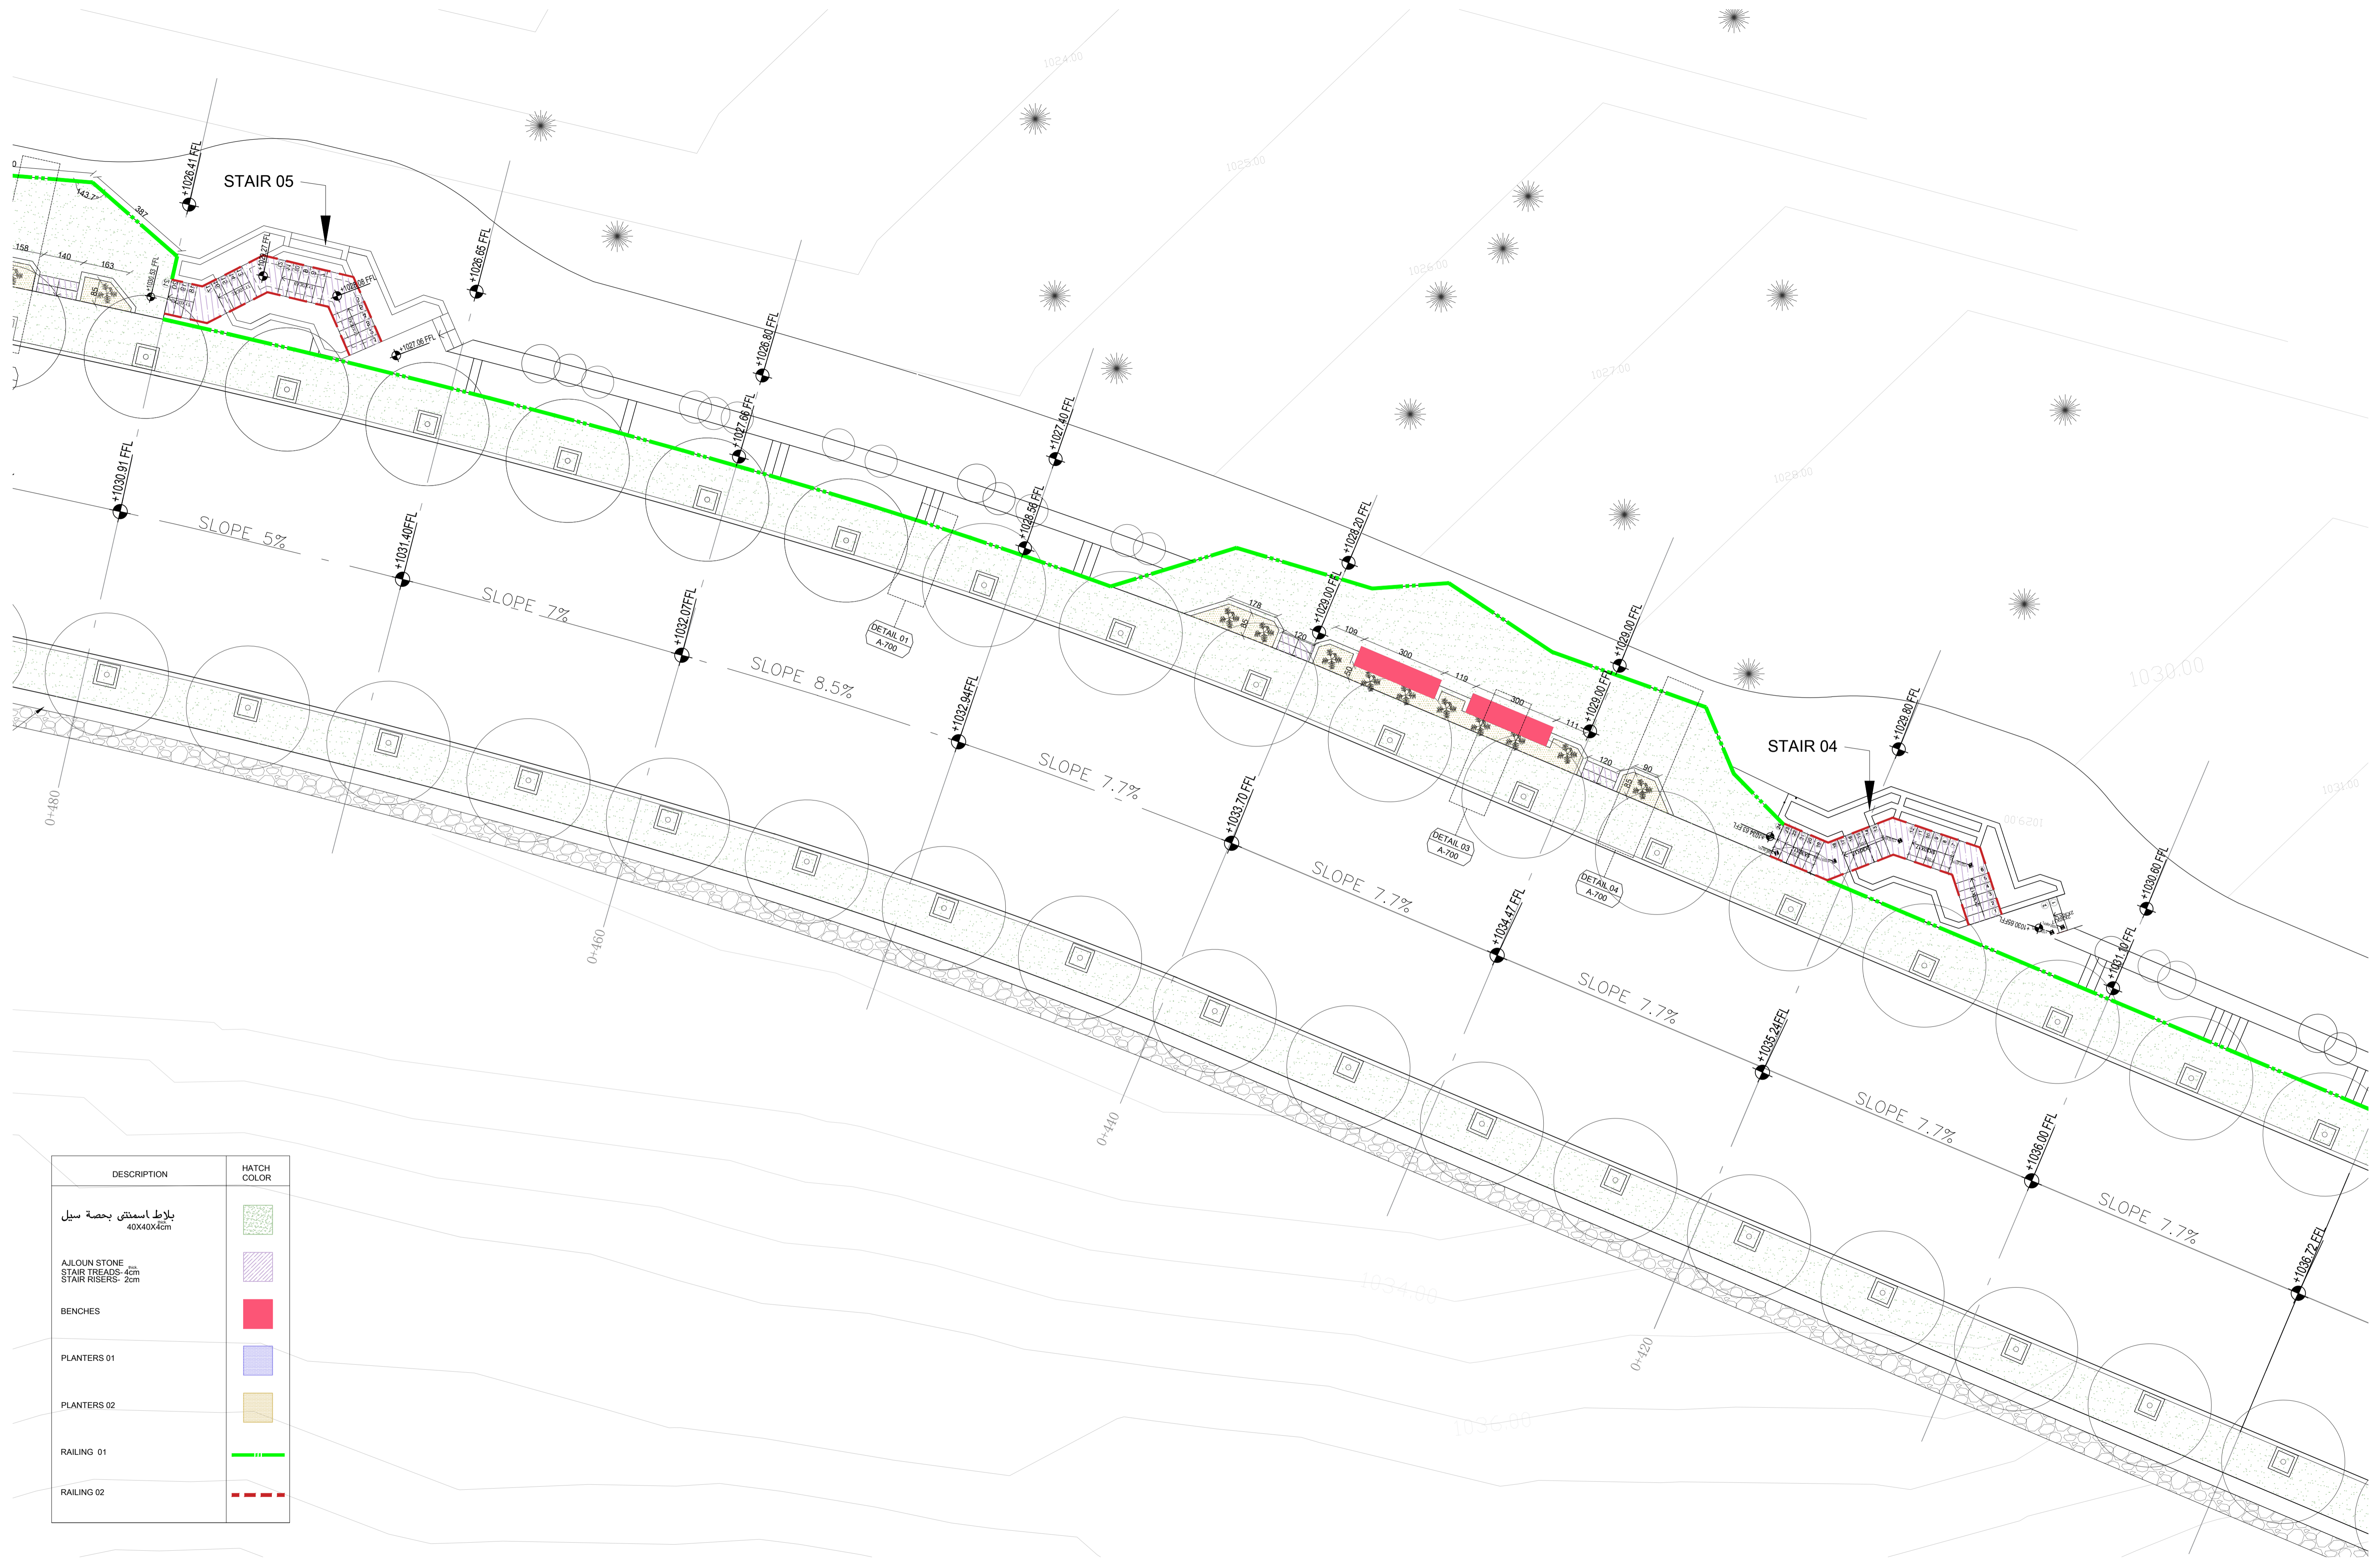


DESCRIPTION	HATCH COLOR
بلاط اسمنتية بحصة سيل 40x40x4cm	
AILOUN STONE STAIR TREADS-4cm STAIR RISERS- 2cm	
BENCHES	
PLANTERS 01	
PLANTERS 02	
RAILING 01	
RAILING 02	

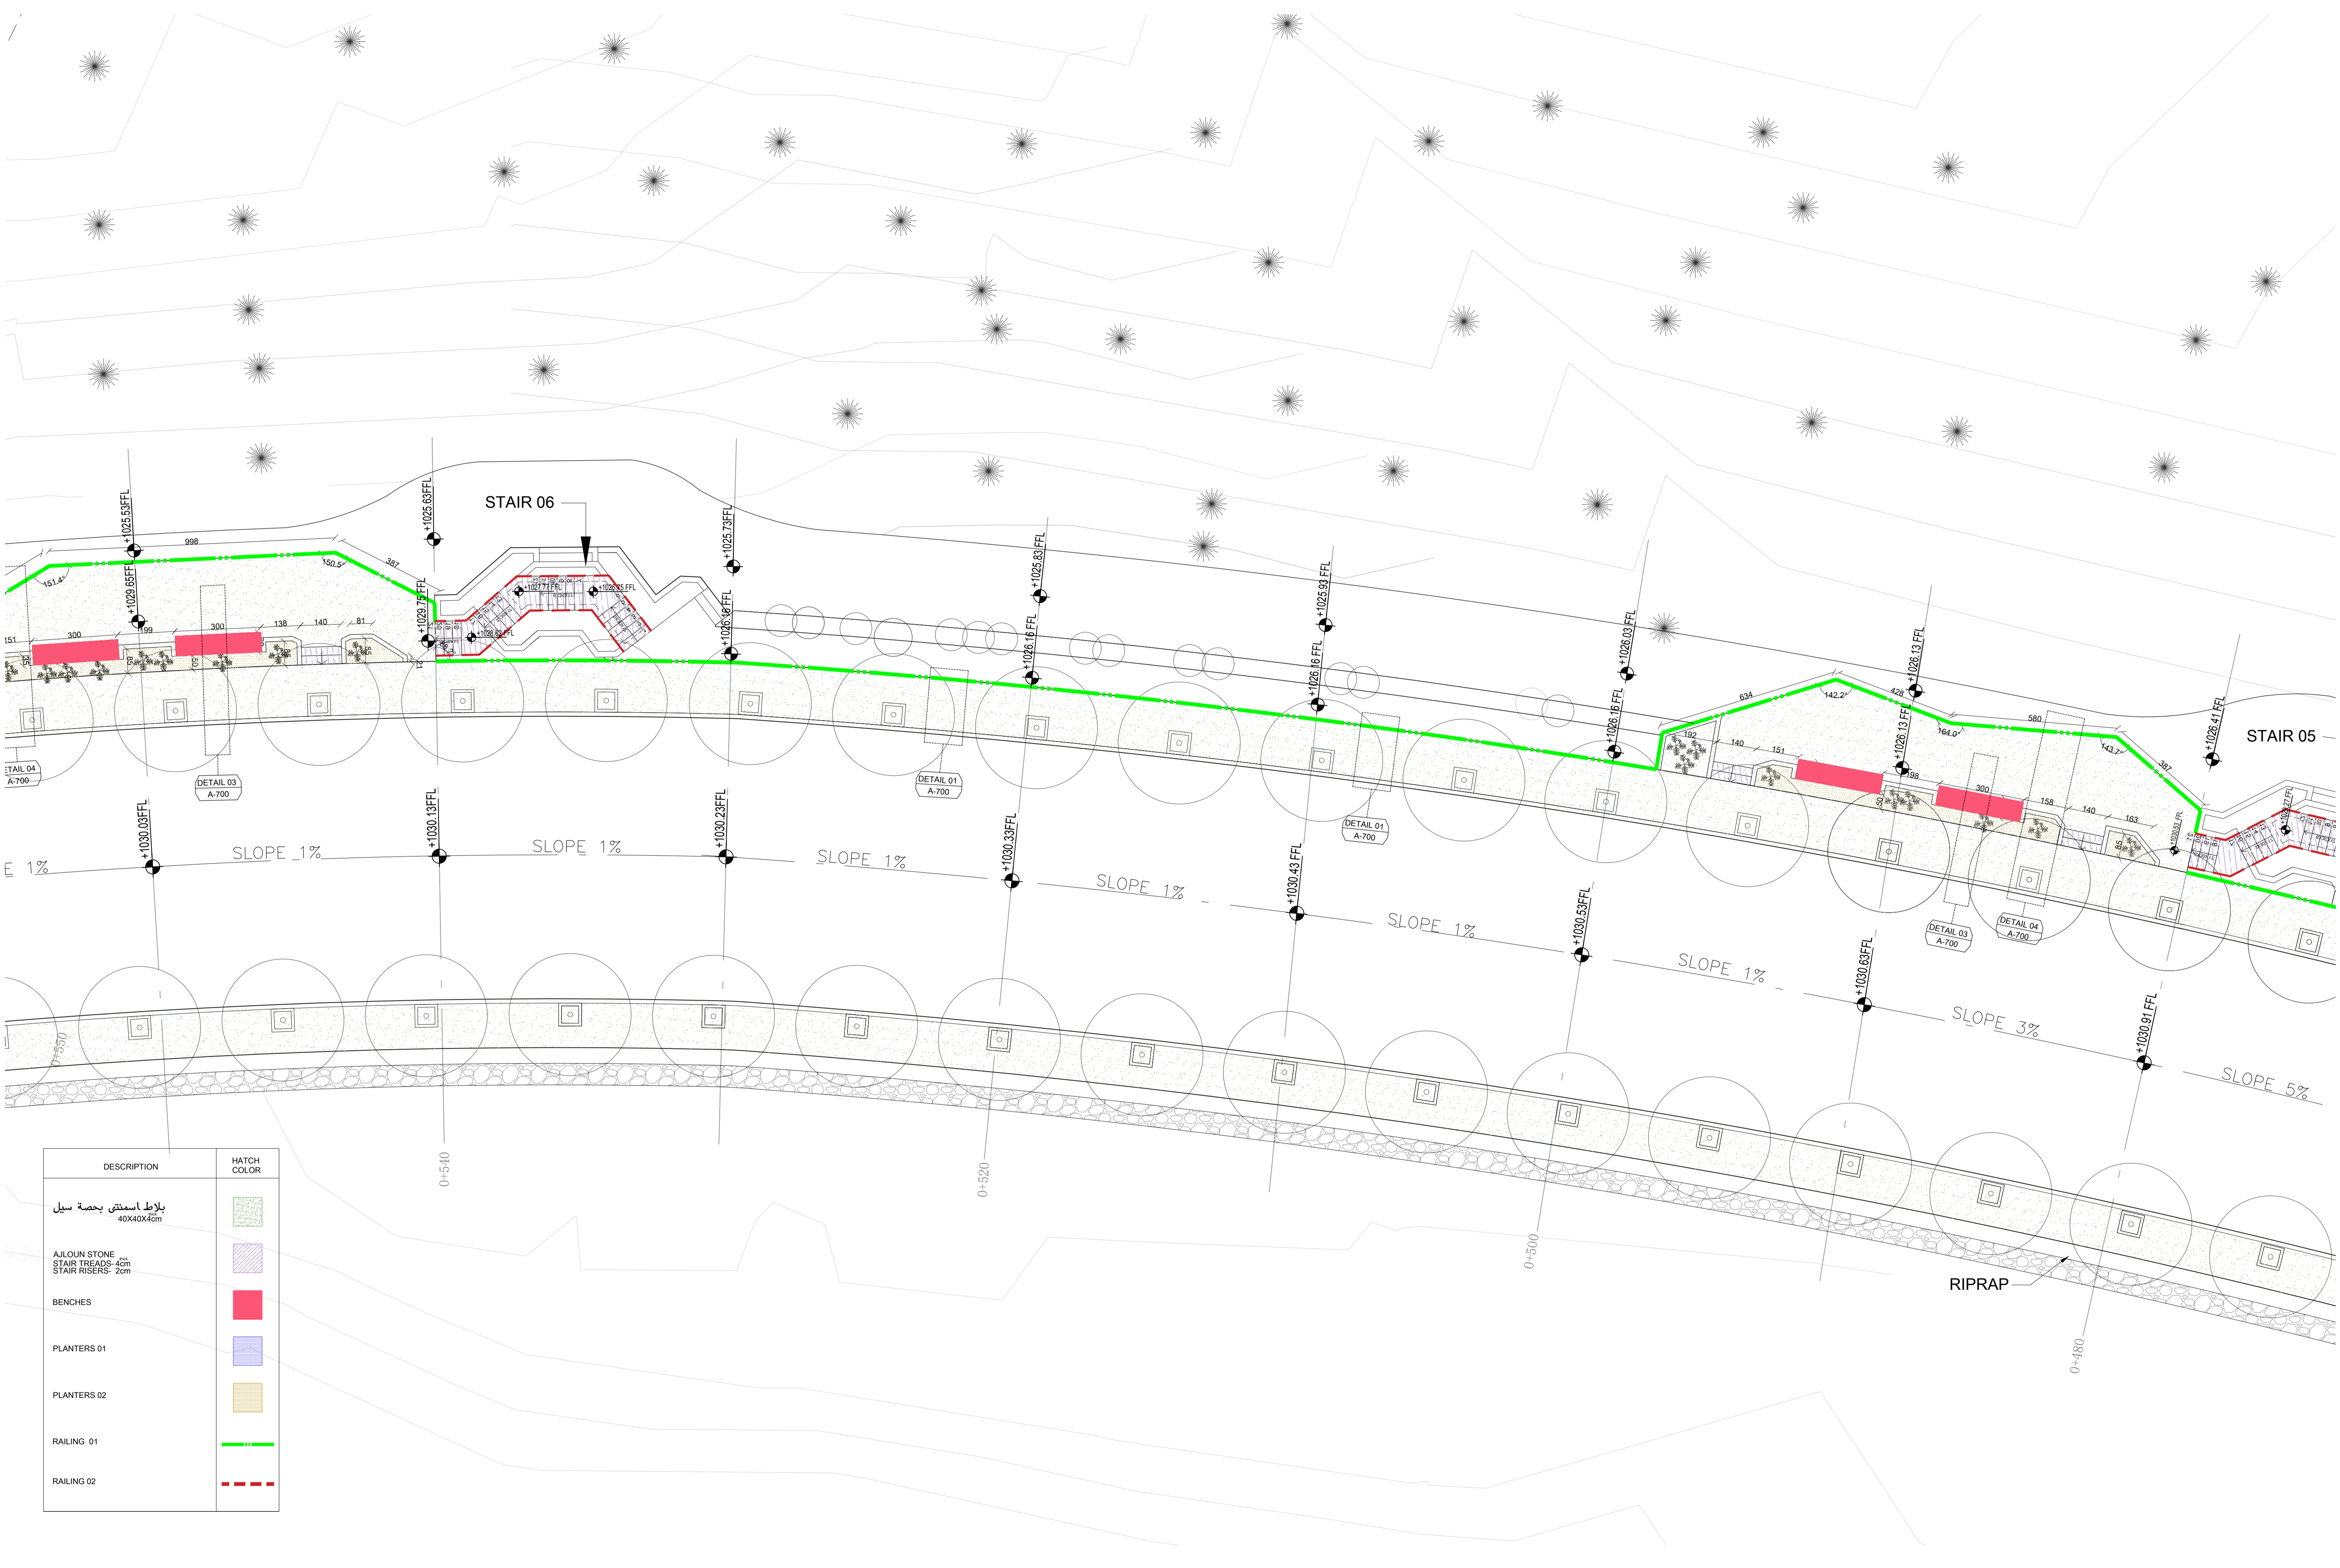

DESCRIPTION	HATCH COLOR
بلاط اسمنتي بحصة سيل 40x40x4cm	
AILOUN STONE STAIR TREADS-4cm STAIR RISERS- 2cm	
BENCHES	
PLANTERS 01	
PLANTERS 02	
RAILING 01	
RAILING 02	

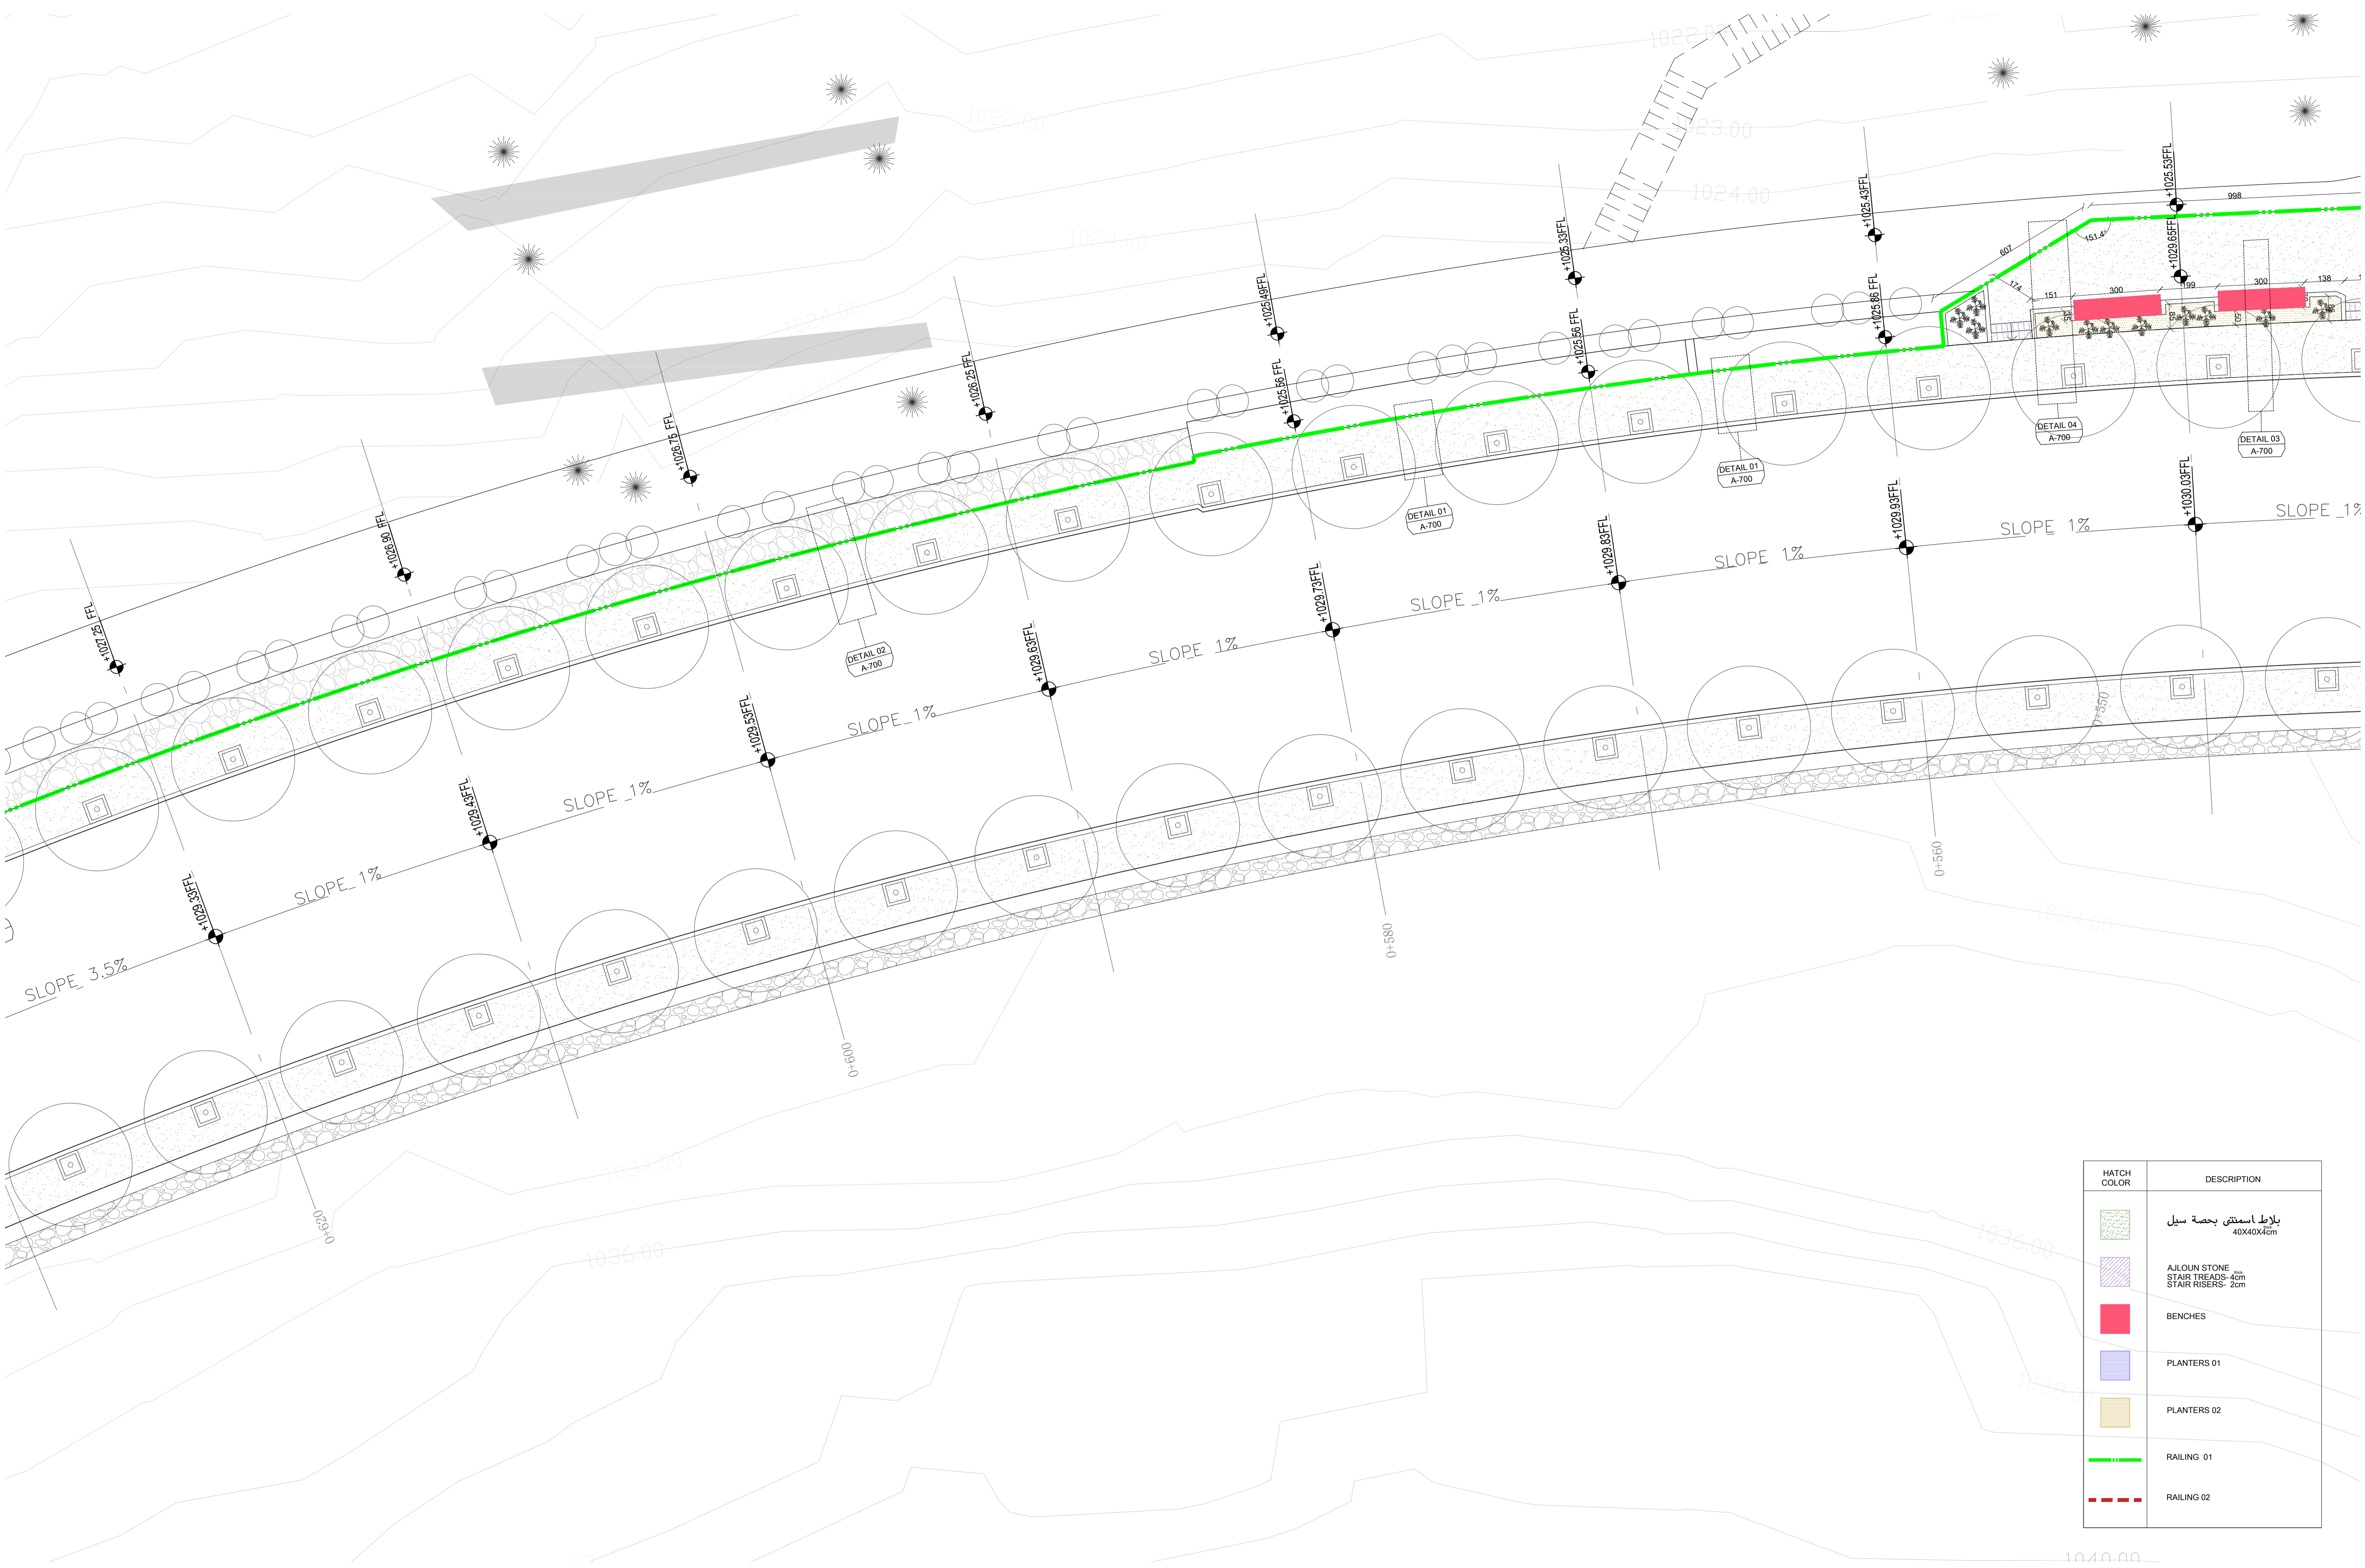

HATCH COLOR	DESCRIPTION
	بلاط اسمنتي بحصة سيل 40X40X4cm
	AJLOUN STONE STAIR TREADS- 4cm STAIR RISERS- 2cm
	BENCHES
	PLANTERS 01
	PLANTERS 02
	RAILING 01
	RAILING 02

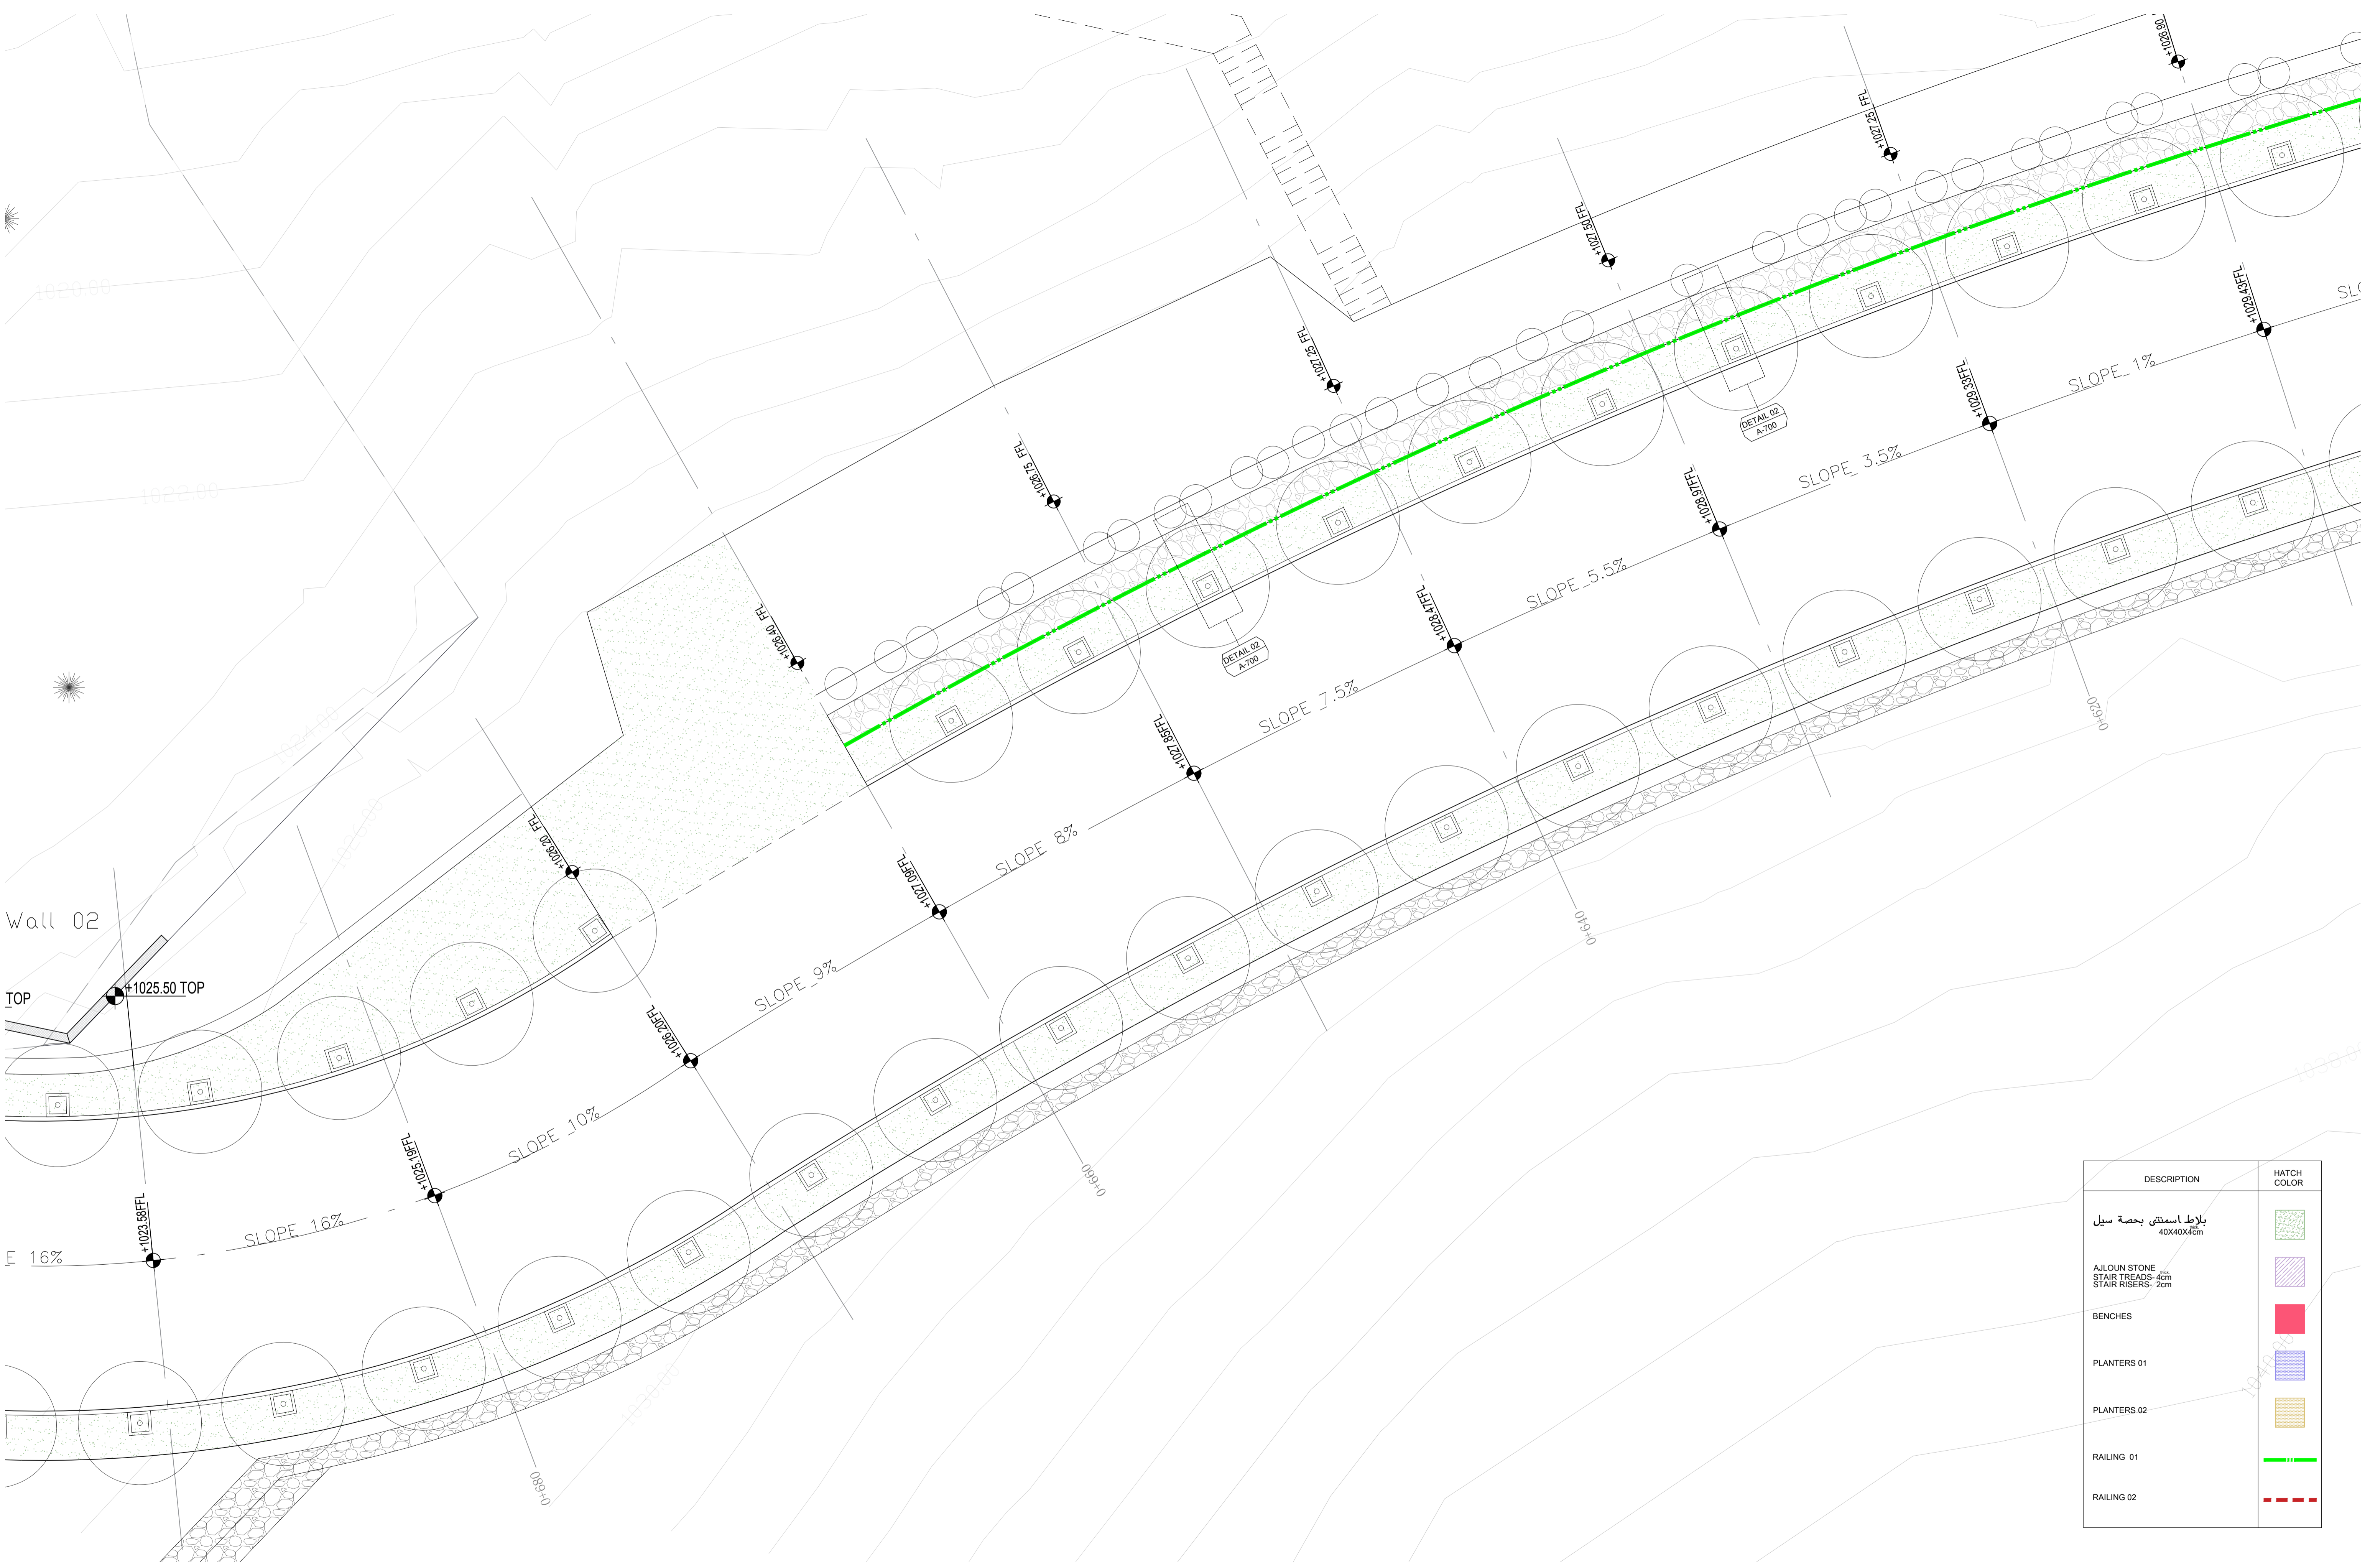


DESCRIPTION	HATCH COLOR
بلاط اسمنتي بحصة سيل 40x40x4cm	
AJLOUN STONE STAIR TREADS- 4cm STAIR RISERS- 2cm	
BENCHES	
PLANTERS 01	
PLANTERS 02	
RAILING 01	
RAILING 02	





DESCRIPTION	HATCH COLOR
رباط اسمنتي بحصة سيل 40x40x4cm	
AJLOUN STONE STAIR TREADS-4cm STAIR RISERS- 2cm	
BENCHES	
PLANTERS 01	
PLANTERS 02	
RAILING 01	
RAILING 02	



DESCRIPTION	HATCH COLOR
بلاط اسمنتي بحصة سيل 40X40X4cm	
AJLOUN STONE STAIR TREADS- 4cm STAIR RISERS- 2cm	
BENCHES	
PLANTERS 01	
PLANTERS 02	
RAILING 01	
RAILING 02	

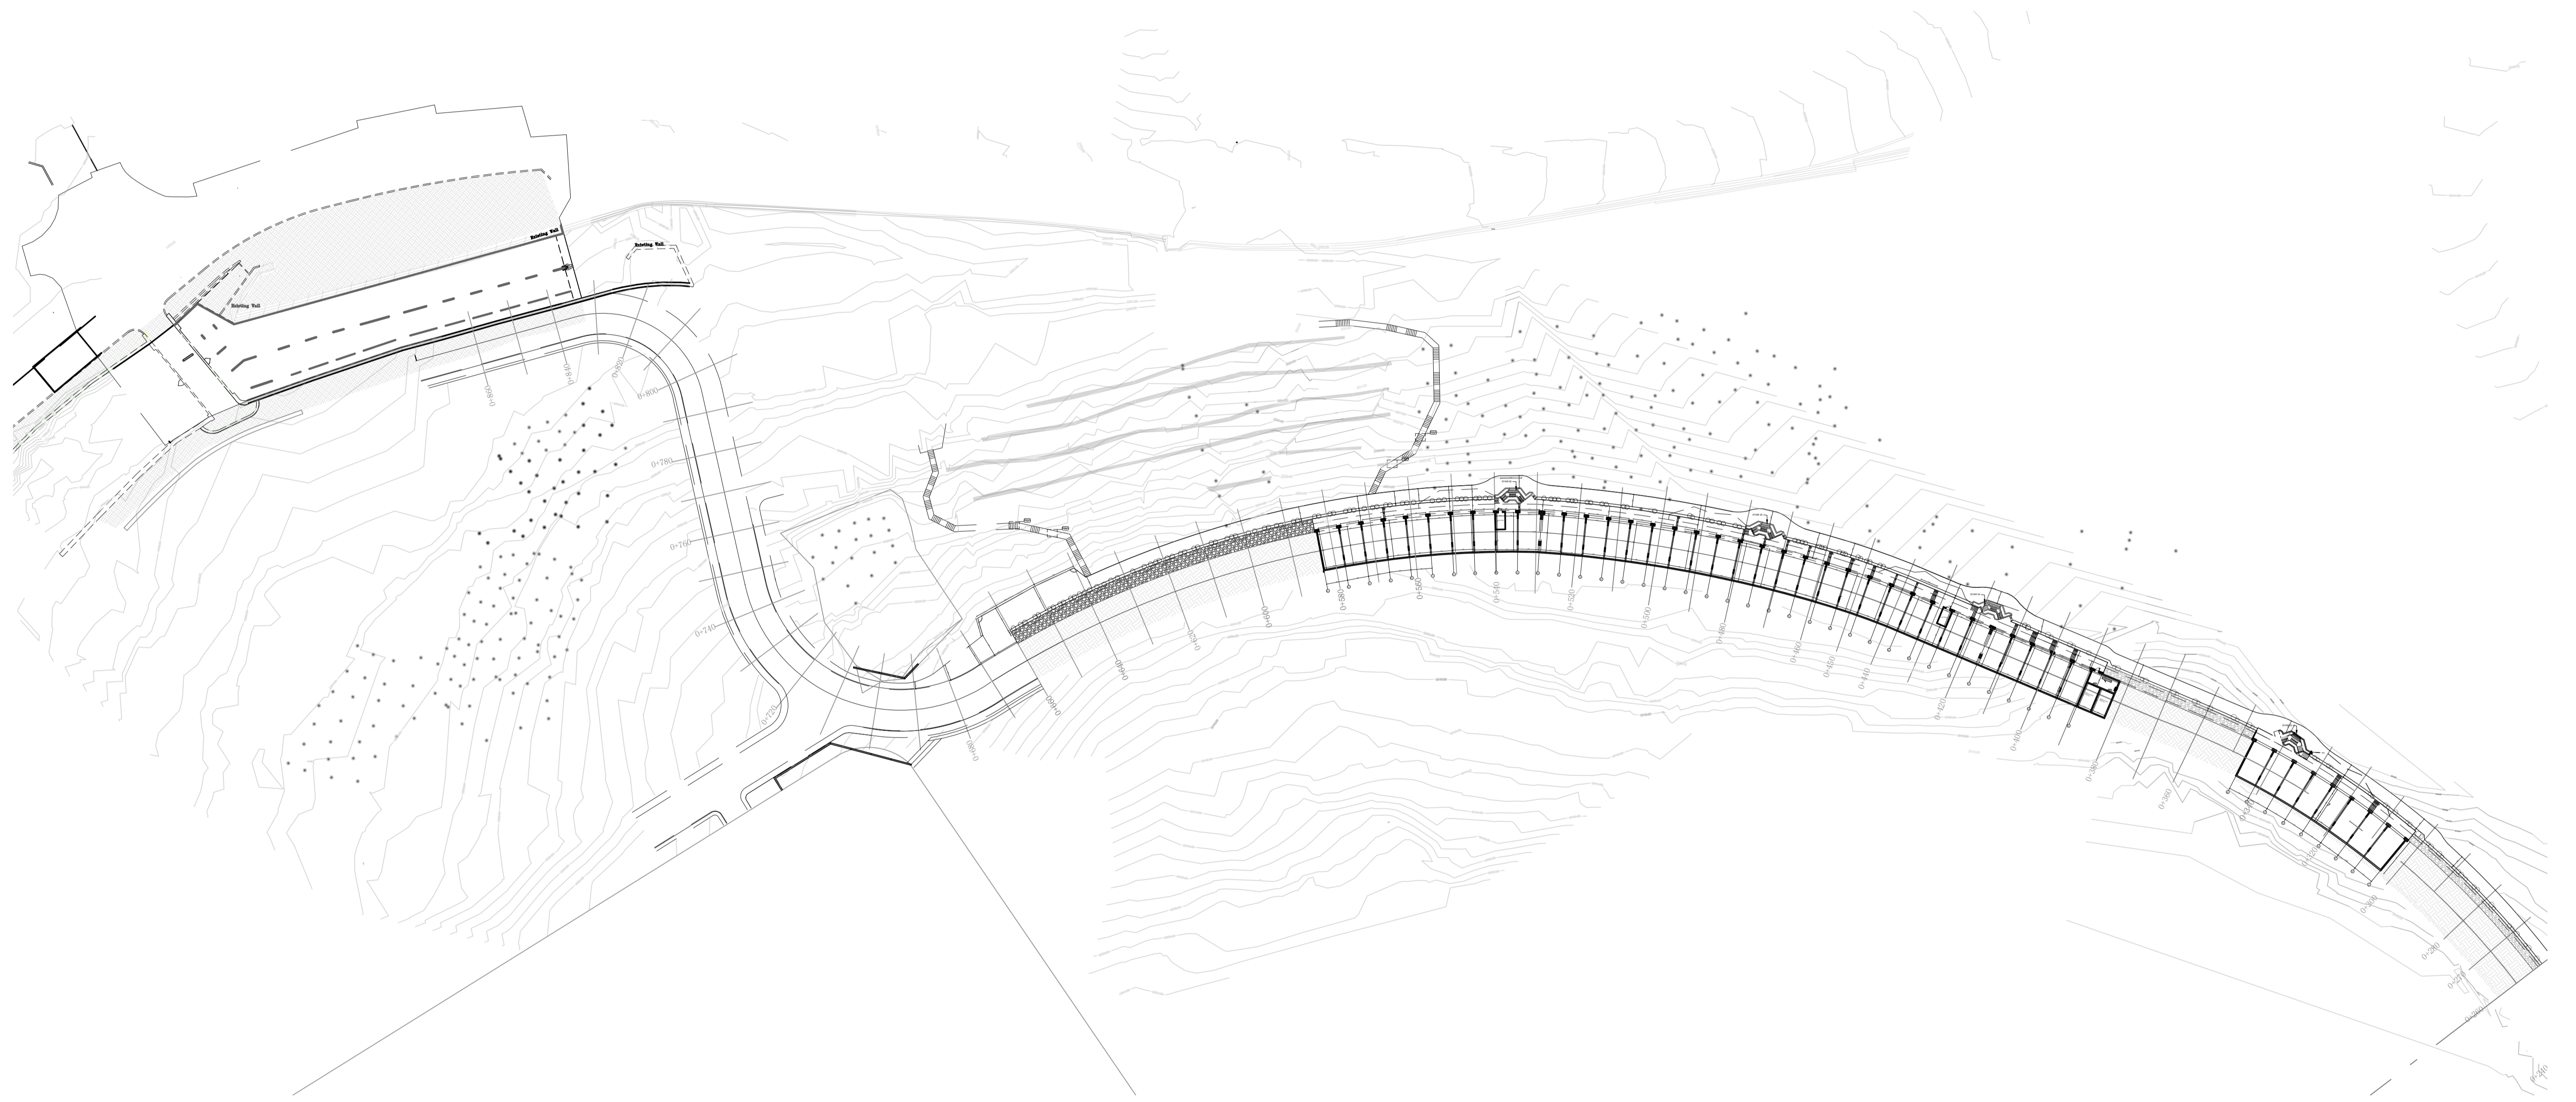

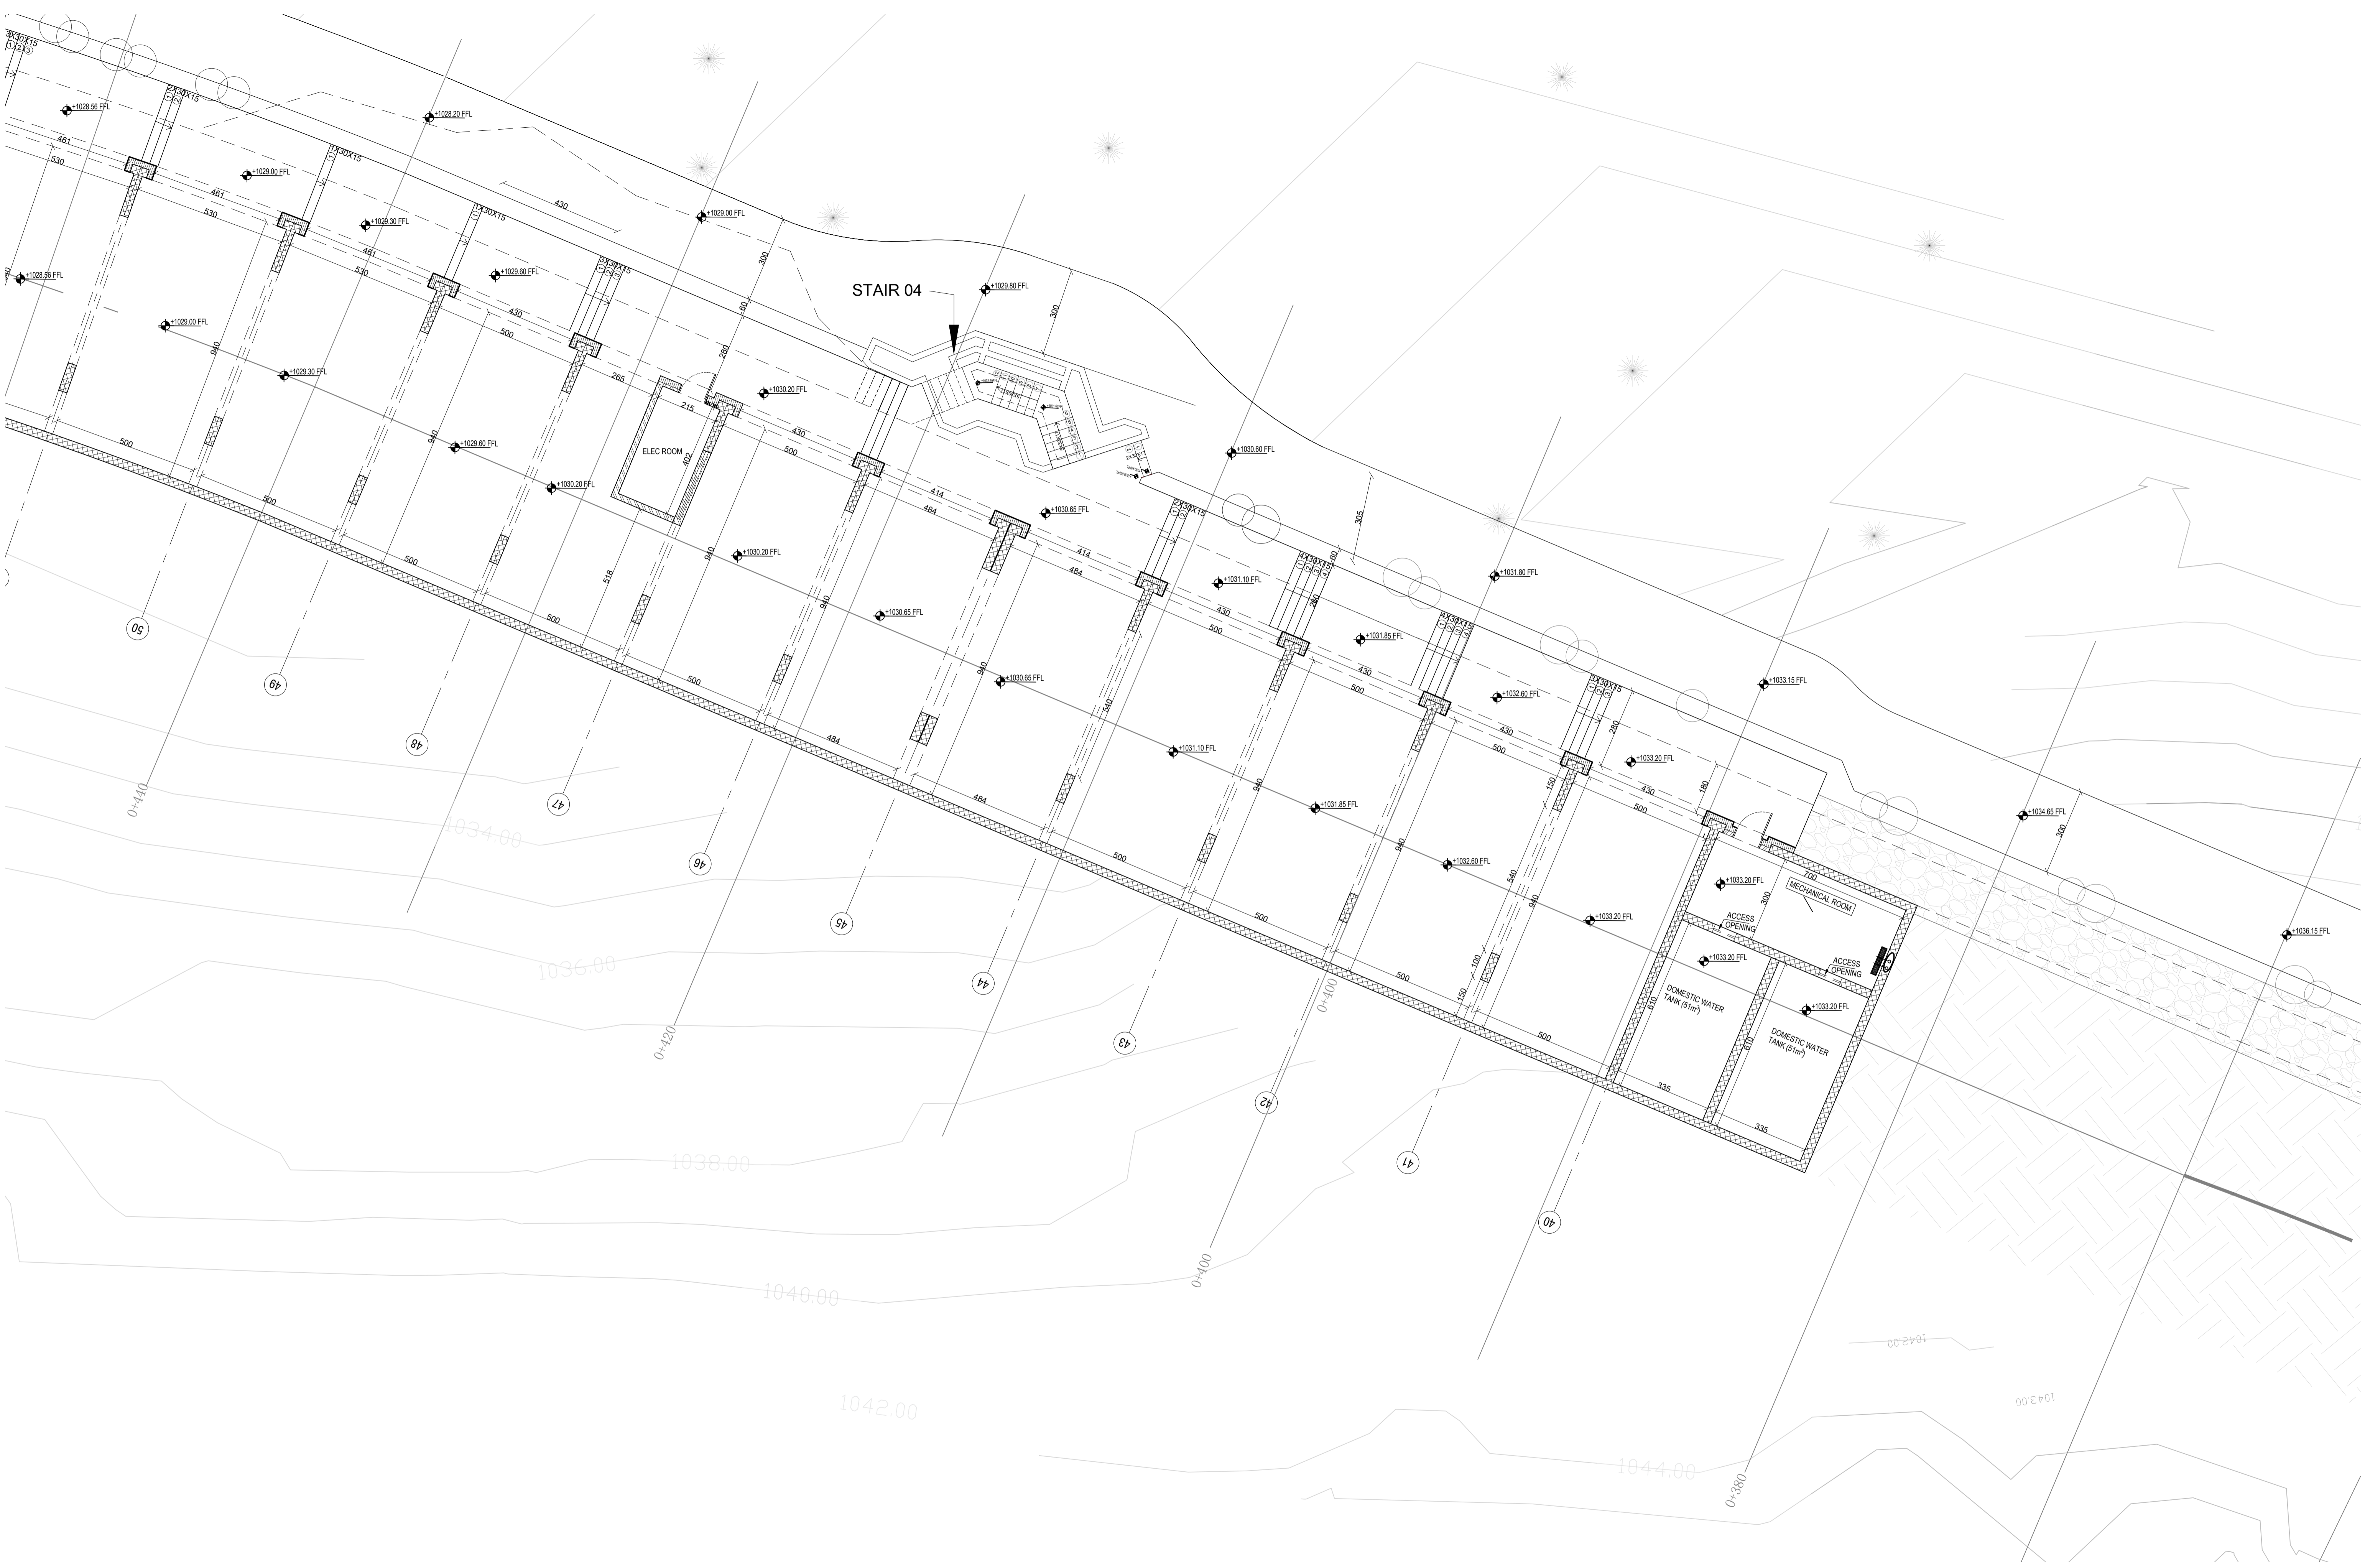


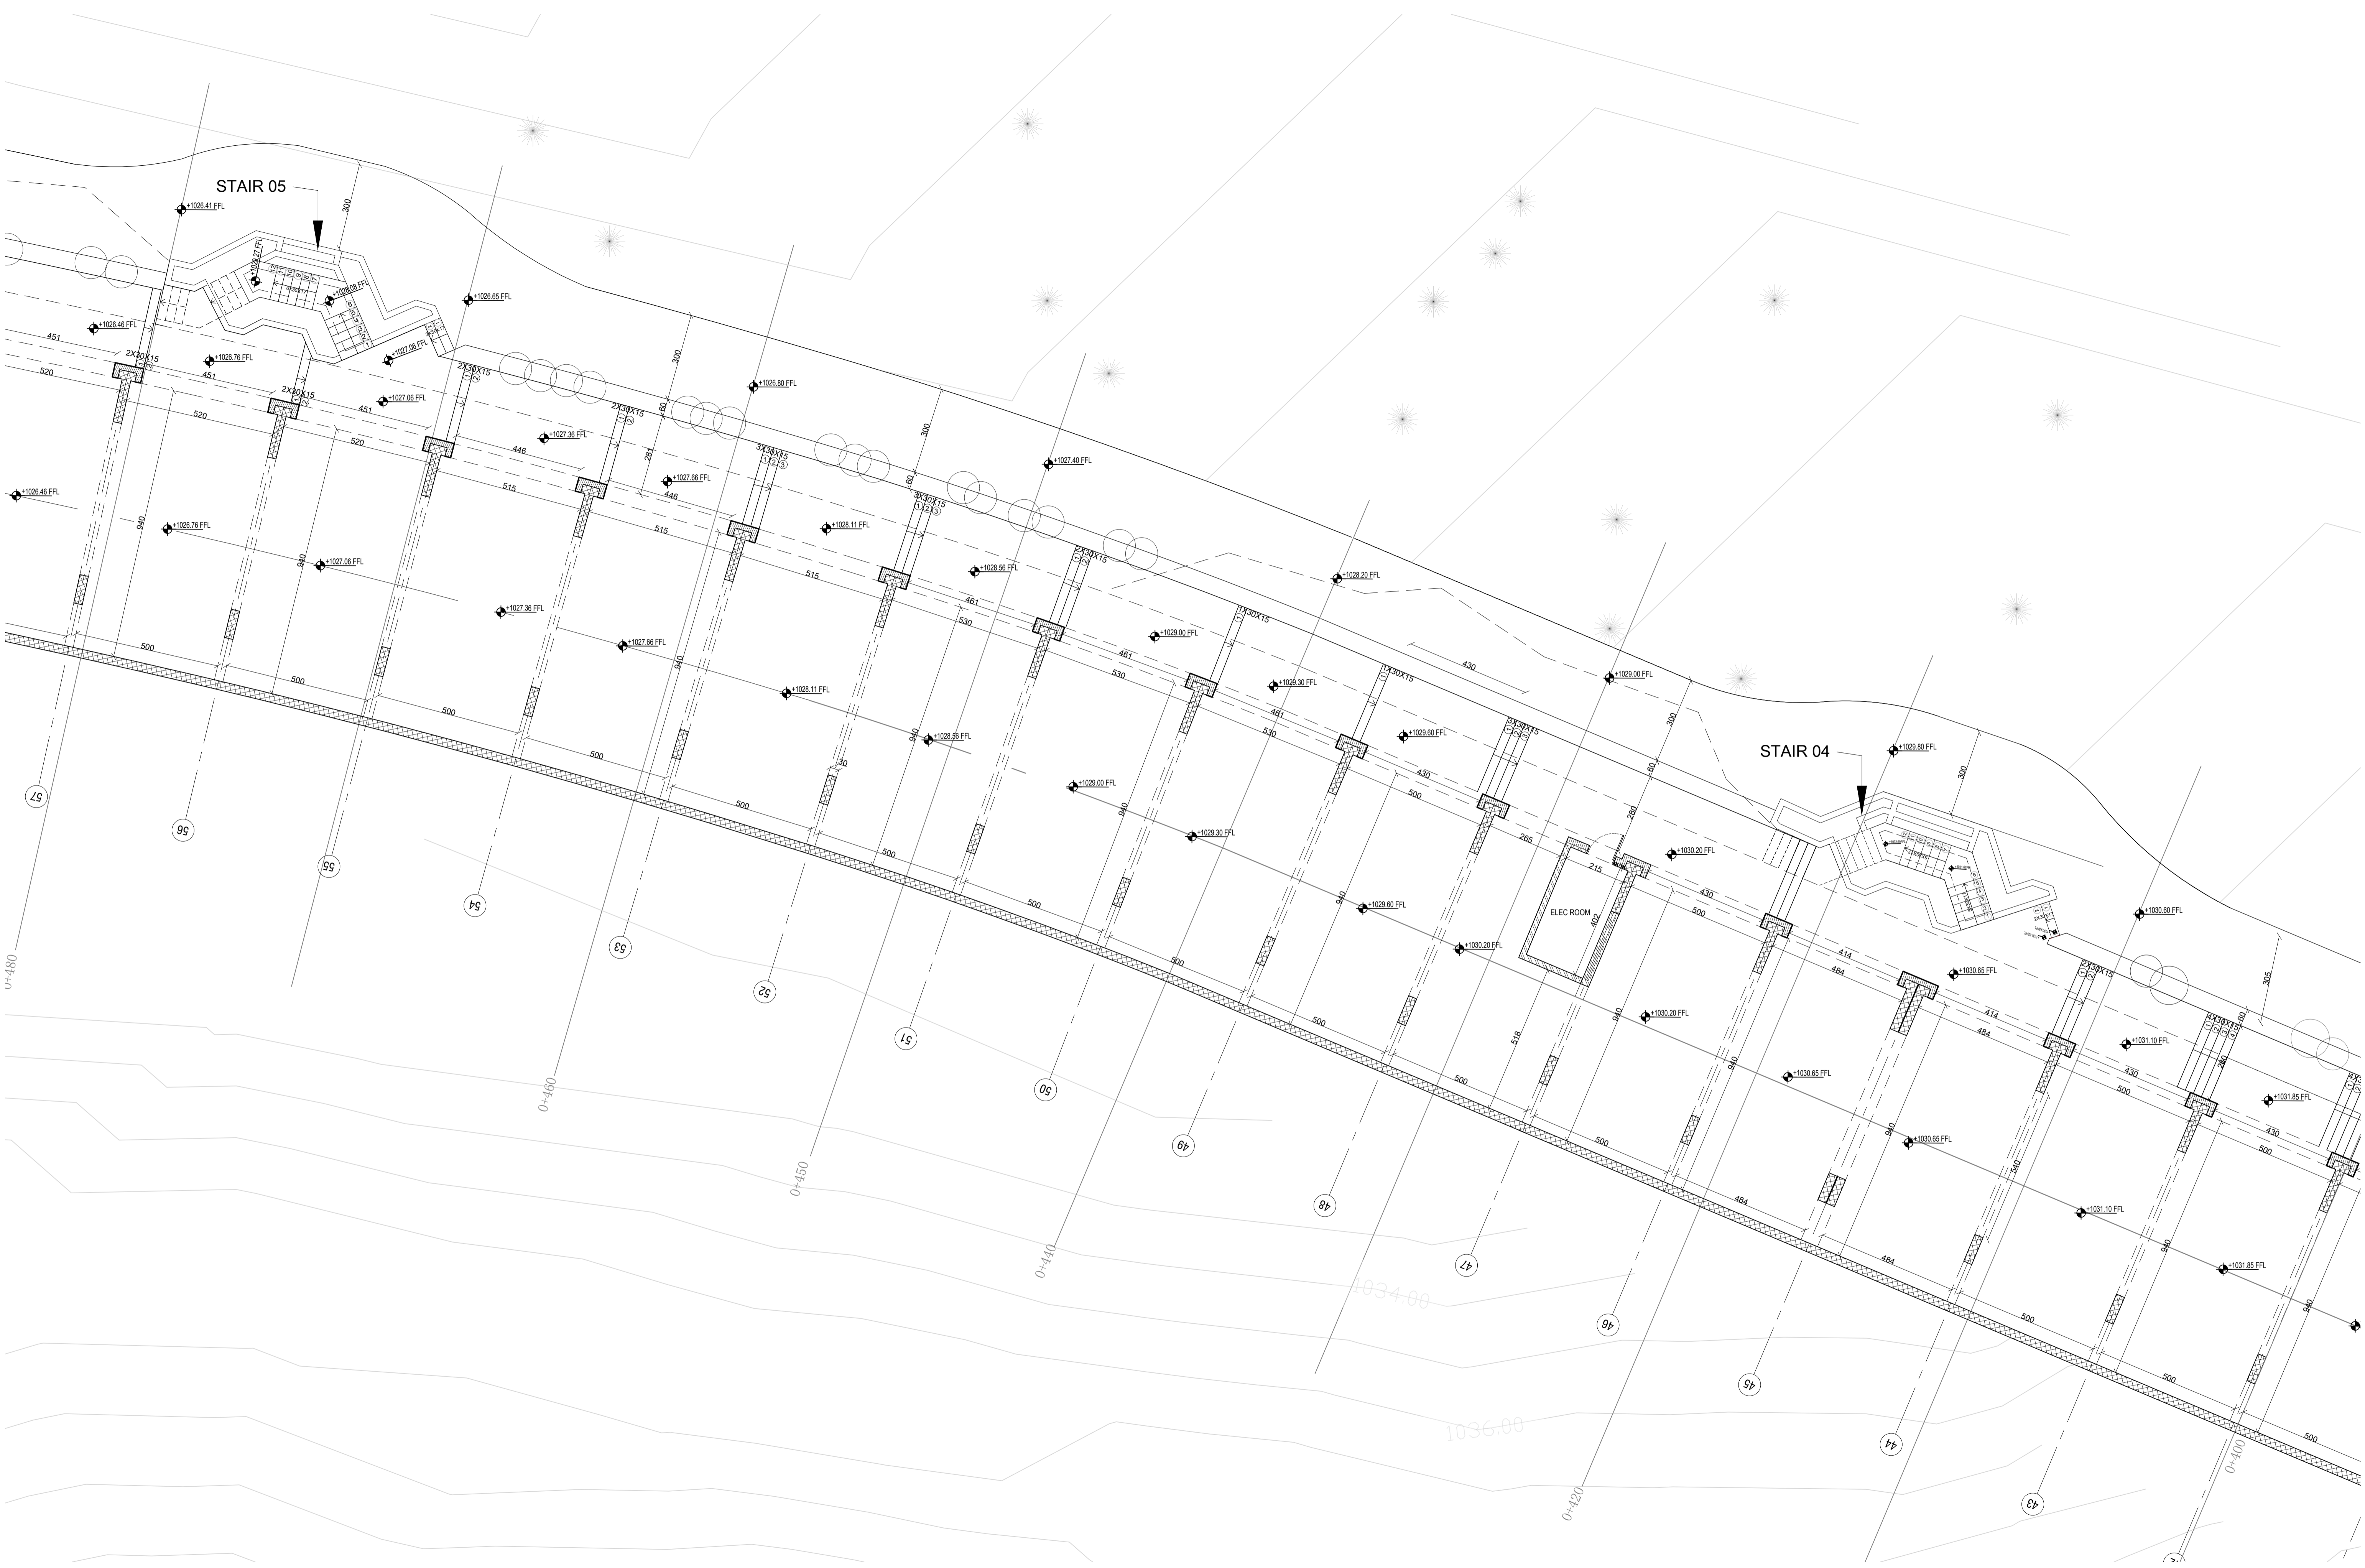

STAIR 05

STAIR 04

ELEC ROOM

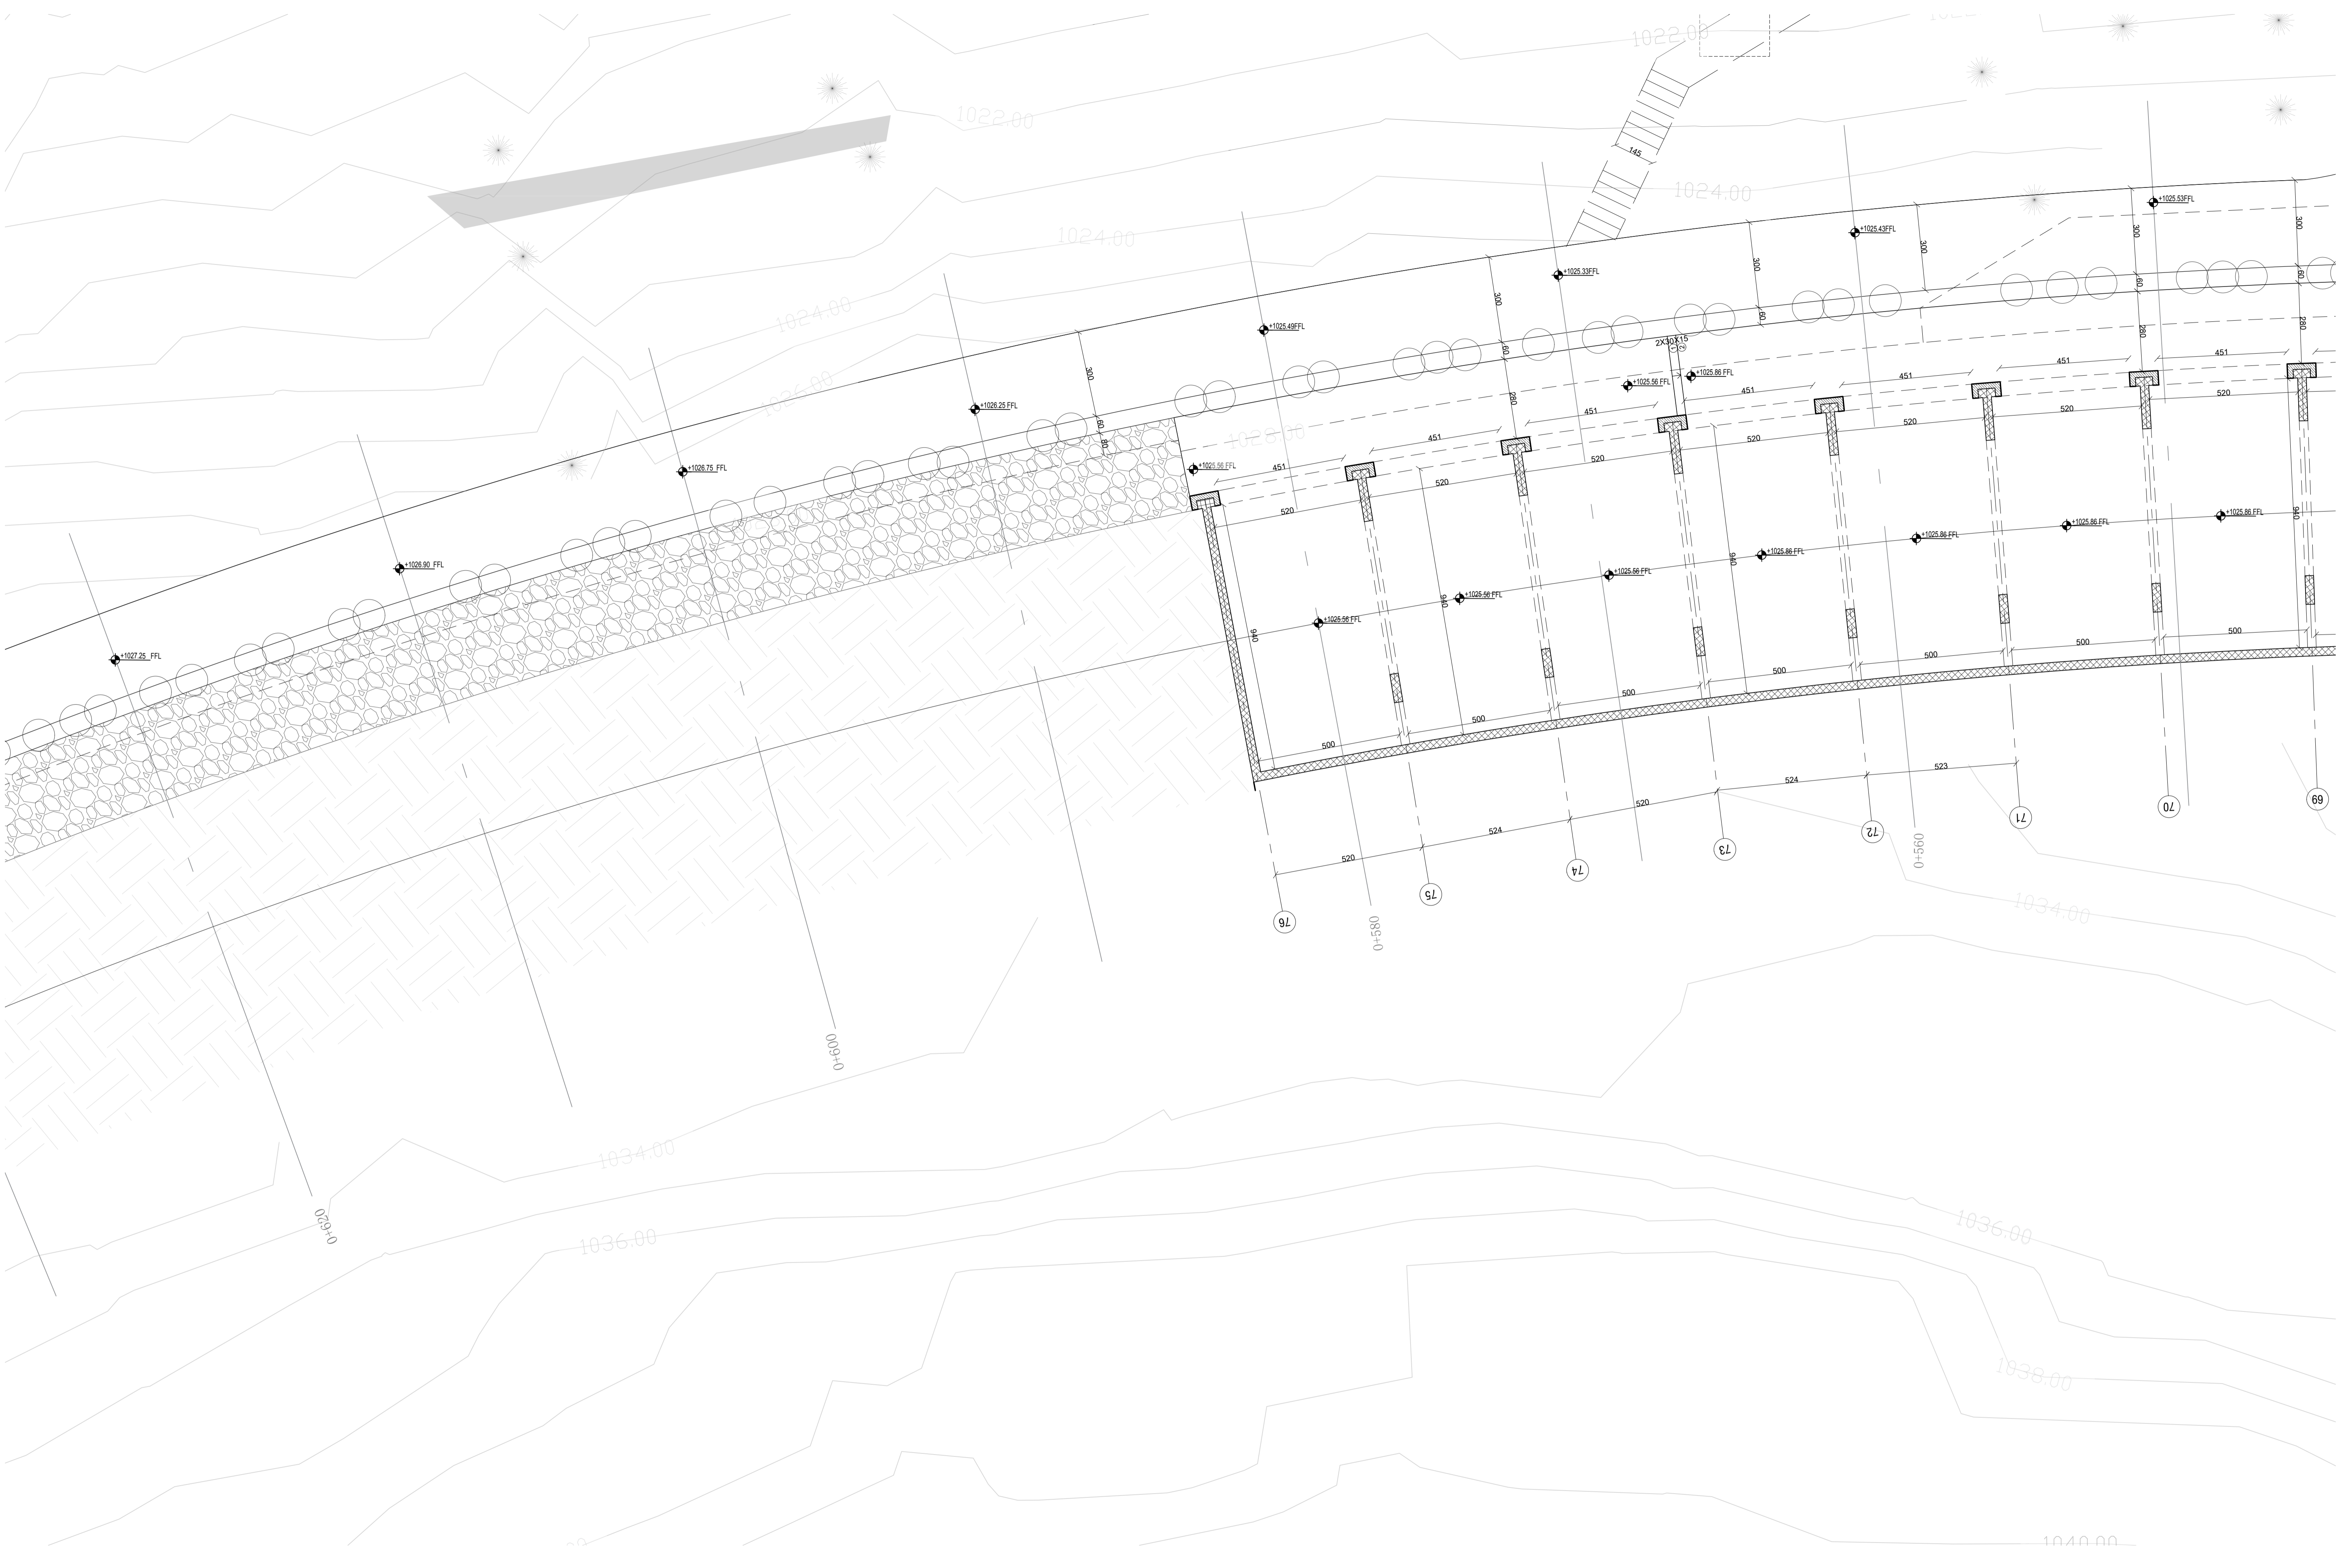

KHAMMASH ARCHITECTS

P.O. Box 921474, Amman - 11192, Jordan. Tel: +962 6 9696134, Fax: +962 6 9622366
E-mail: info@khammash.com

CLIENT

Petra Development & Tourism Region Authority

PROJECT

Road 4

ADDRESS

Wadi Musa, JORDAN

STATUS

TENDER

Copyright © Khammash Architects

THIS DRAWING IS AND IN ALL TIMES REMAINS THE EXCLUSIVE PROPERTY OF KHAMMASH ARCHITECTS. ALL MEASUREMENTS MUST BE CHECKED BY THE CONTRACTOR ON SITE BEFORE THE COMMENCEMENT OF ANY WORKS.

NOTES

DRAWN	NORTH	SCALE
CHECKED	APPROVED	1:100@A1
ISSUE	DATE	AMENDMENT
		CHECKED

AK

DRAWING TITLE

GROUND FLOOR PLAN - FROM 550 - 620

SHEET NUMBER

A-ZA-033

ISSUE

DATE

May, 2022



DESCRIPTION	HATCH COLOR
بلاط اسمنتي بحصة سيل 40X40X4cm	
AJLOUN STONE STAIR TREADS- 4cm STAIR RISERS- 2cm	
RAILING 02	


KHAMMASH ARCHITECTS
 P.O. Box 52474, Amman - 11192, Jordan, Tel: +962 6 5695134, Fax: +962 6 5622395
 E-mail: info@khammash.com

CLIENT
Petra Development & Tourism Region Authority
 PROJECT
Road 4
 ADDRESS
Wadi Musa, JORDAN

STATUS
TENDER
 Copyright © Khammash Architects
 THIS DRAWING IS AND AT ALL TIMES REMAINS THE EXCLUSIVE PROPERTY OF KHAMMASH ARCHITECTS. ALL MEASUREMENTS MUST BE CHECKED BY THE CONTRACTOR ON SITE BEFORE THE COMMENCEMENT OF ANY WORKS.

NOTES

DRAWN	NORTH	SCALE	DRAWING TITLE
CHECKED	APPROVED		GROUND FLOOR PLAN - KEY PLAN
ISSUE	DATE	AMENDMENT	SHEET NUMBER
			A-ZA-040
			ISSUE DATE
			- May.2022

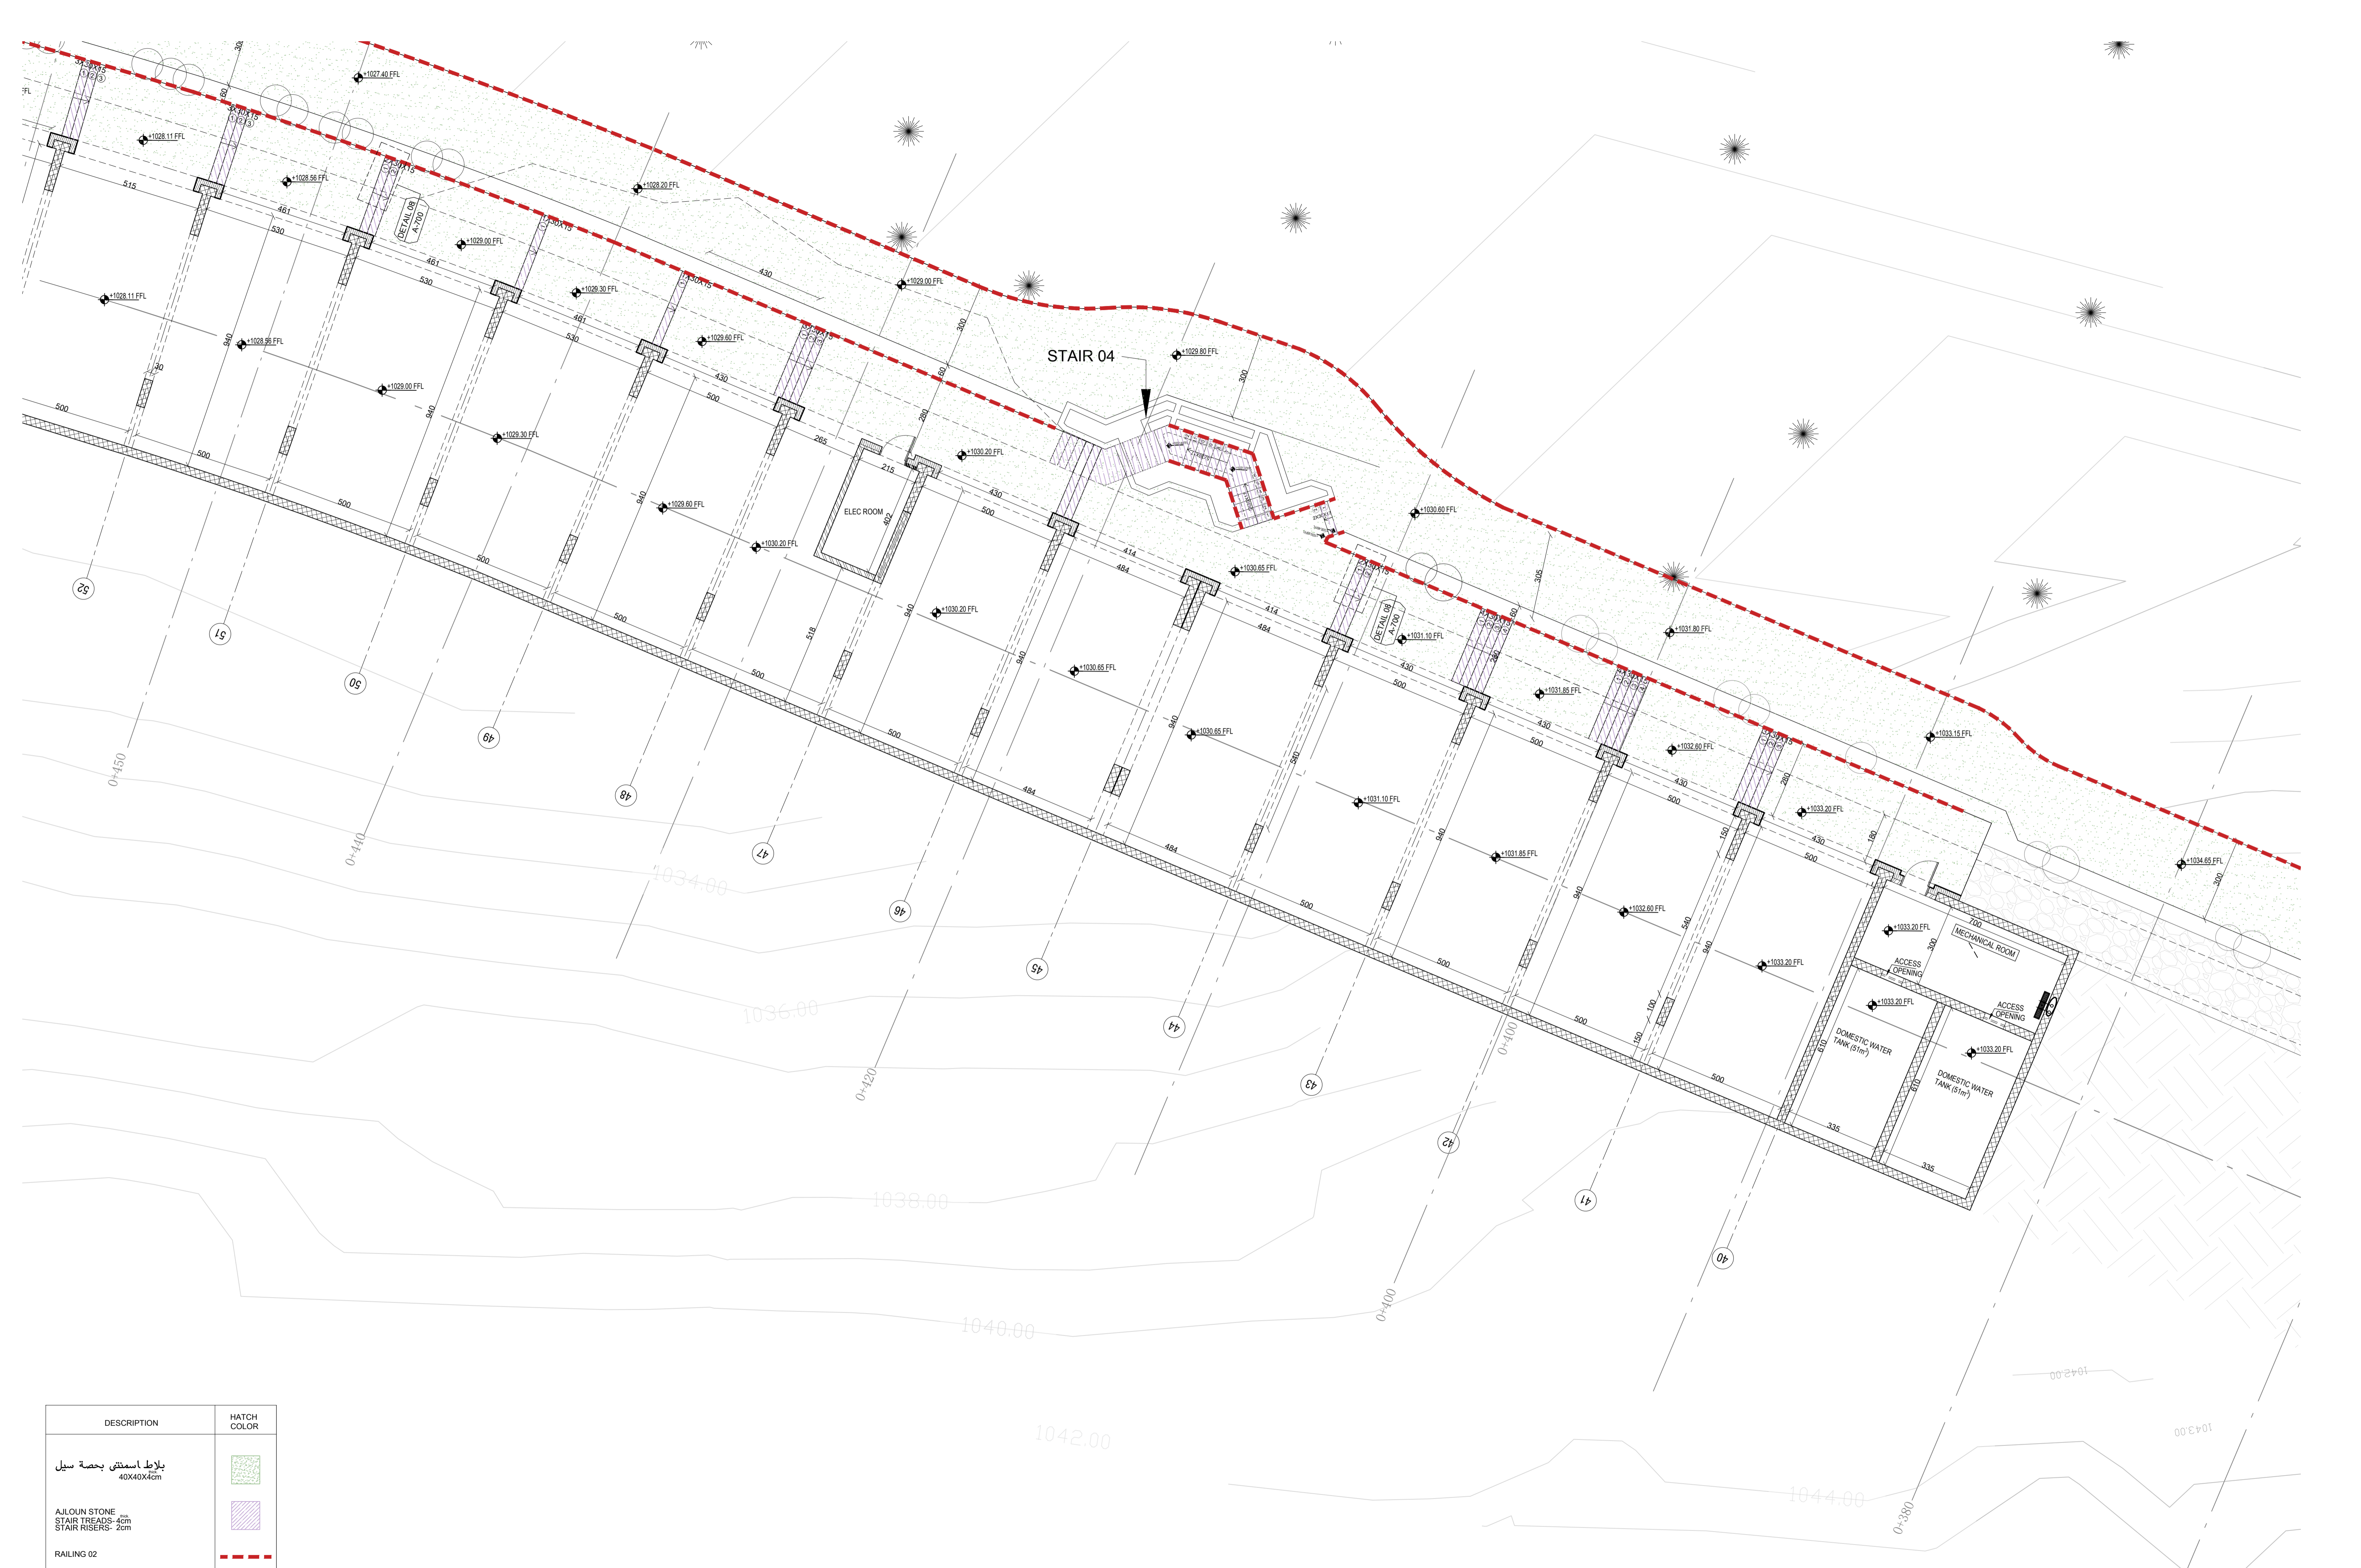

DESCRIPTION	HATCH COLOR
بلاط اسمنتي بحصة سيل 40X40X4cm	
AJLOUN STONE STAIR TREADS- 4cm STAIR RISERS- 2cm	
RAILING 02	

KHAMMASH ARCHITECTS
 P.O. Box 92474, Amman - 11192, Jordan, Tel: +962 6 5696154, Fax: +962 6 5622386
 Email: info@khammash.com

CLIENT
Petra Development & Tourism Region Authority

PROJECT
Road 4

ADDRESS
Wadi Musa, JORDAN

STATUS
TENDER

Copyright © Khammash Architects
 THIS DRAWING IS AND AT ALL TIMES REMAINS THE EXCLUSIVE PROPERTY OF KHAMMASH ARCHITECTS. ALL MEASUREMENTS MUST BE CHECKED BY THE CONTRACTOR ON SITE BEFORE THE COMMENCEMENT OF ANY WORKS.


NOTES

DRAWN	NORTH	SCALE
CHECKED	APPROVED	1:100 A1
	AK	

DRAWING TITLE
GROUND FLOOR PLAN-KEY PLAN-FROM 380-450

SHEET NUMBER
A-ZA-041

ISSUE DATE
May.2022

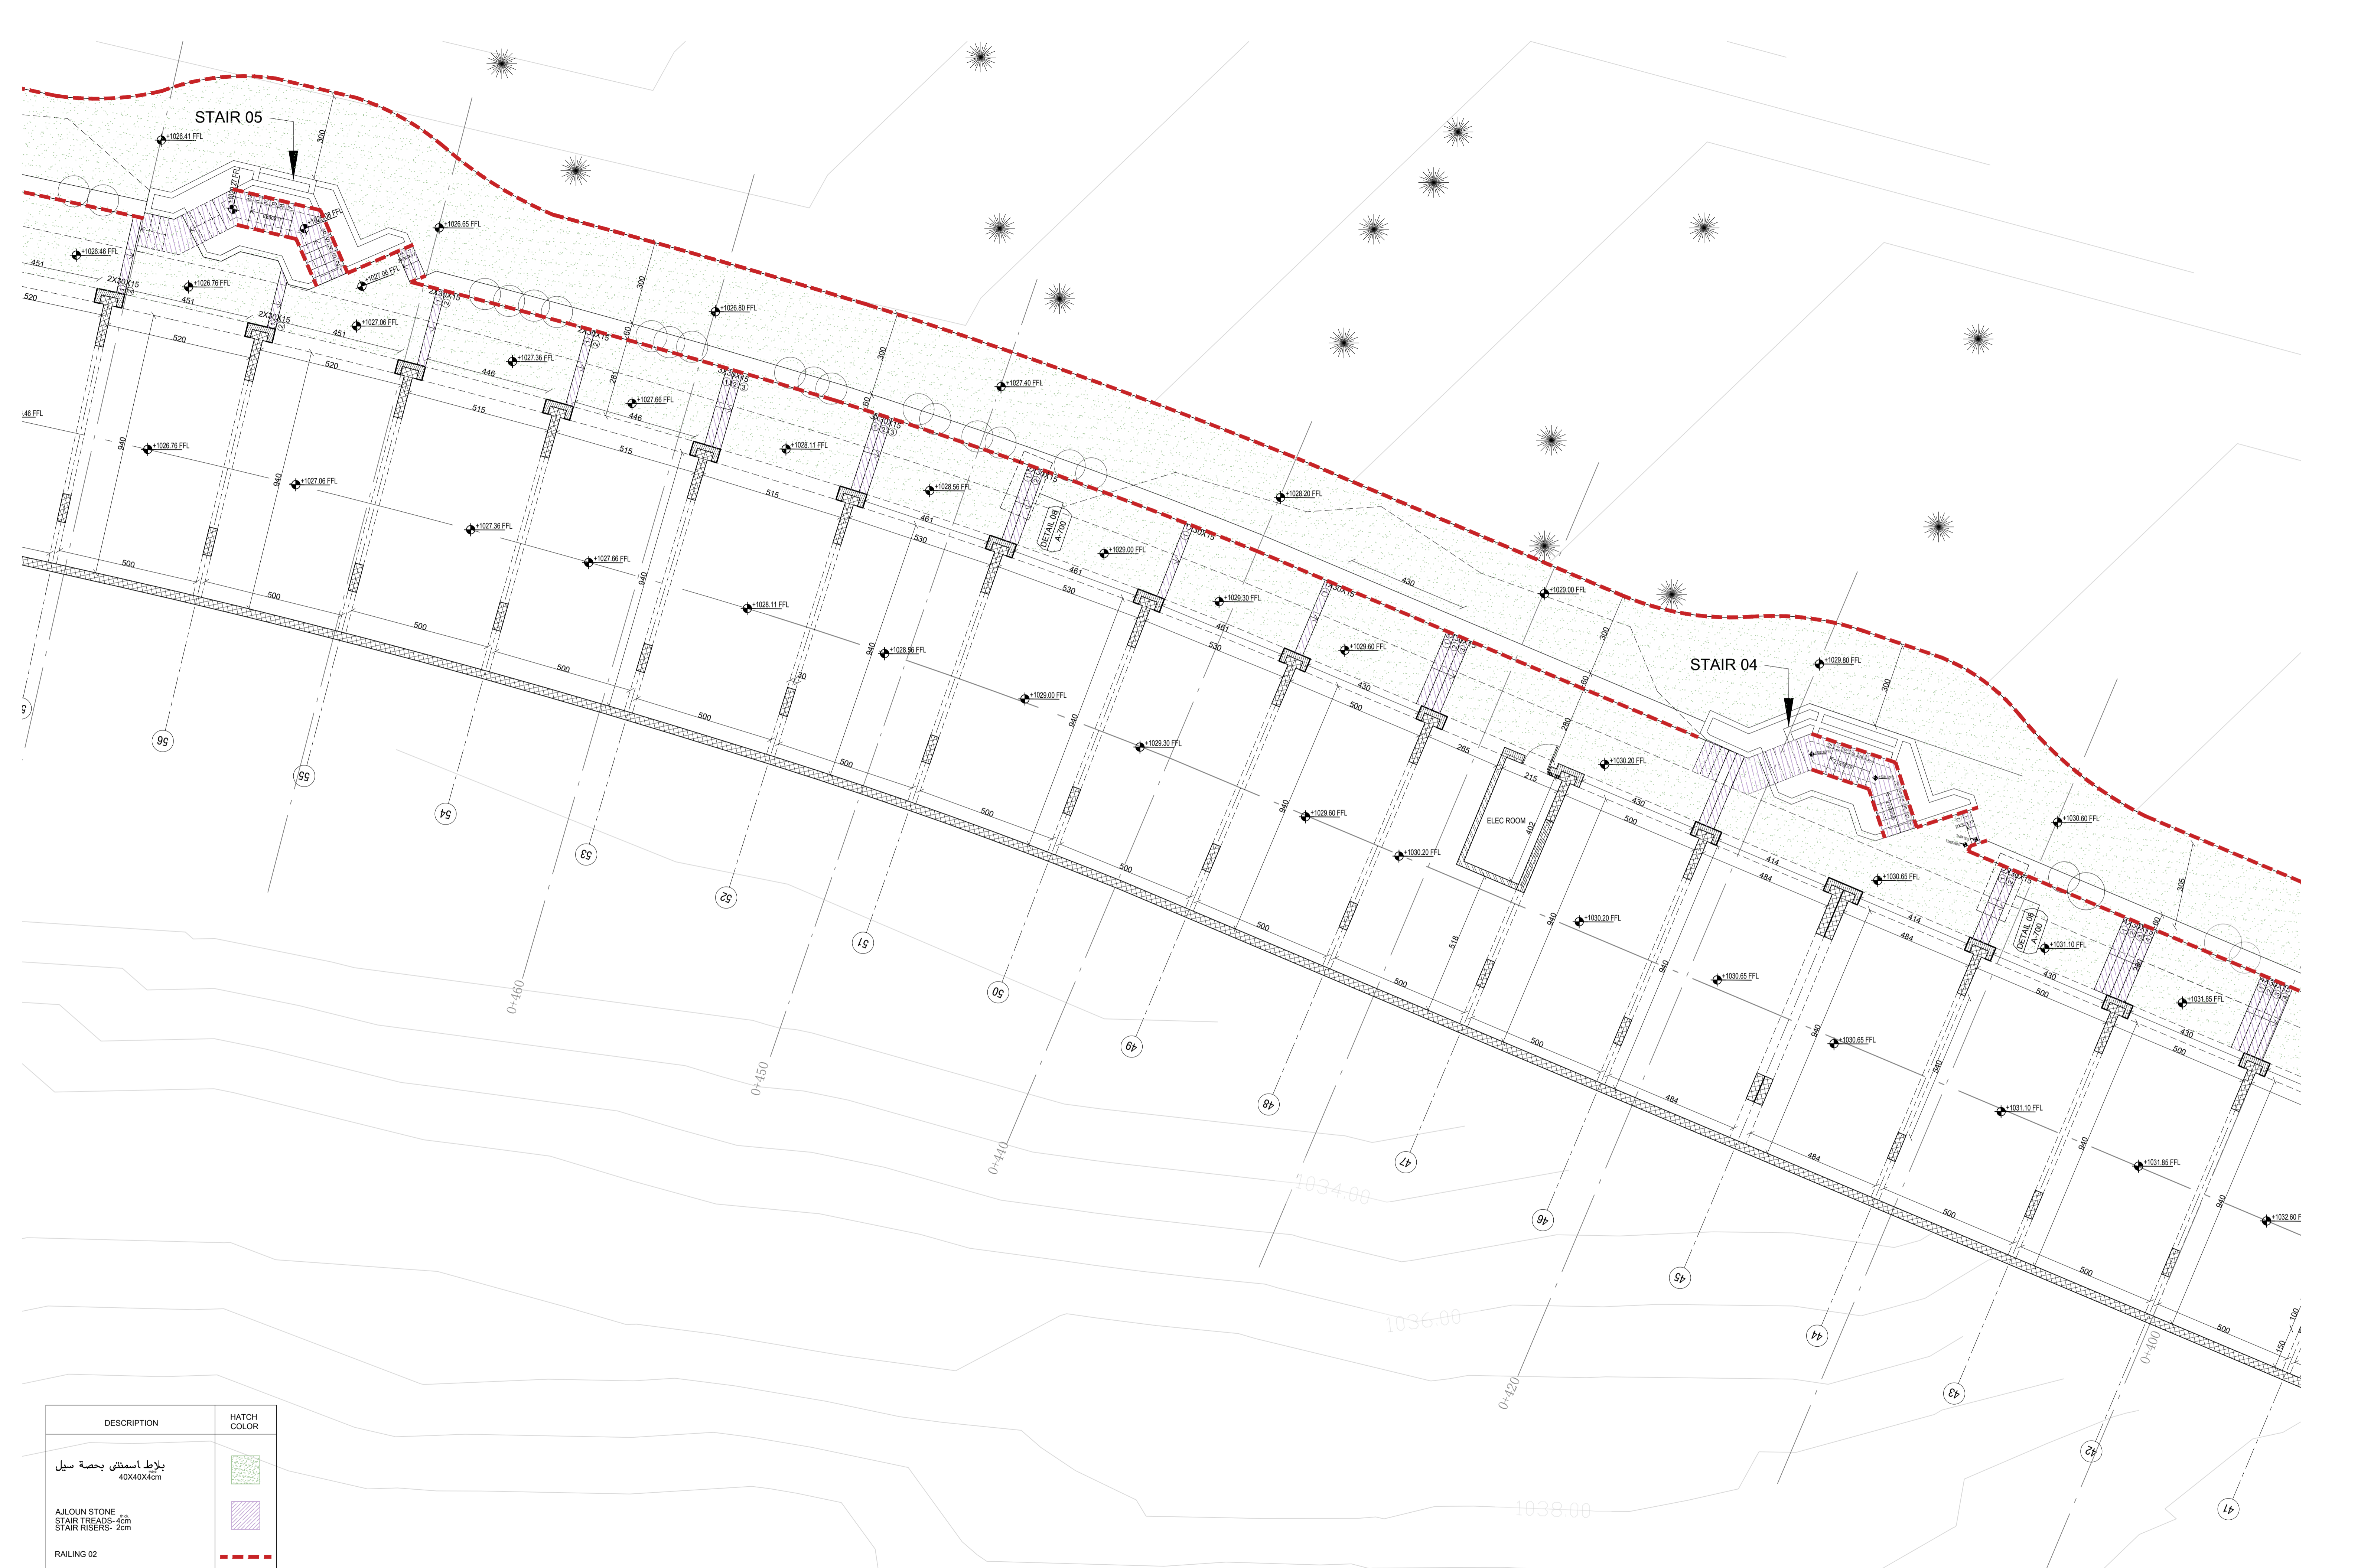

DESCRIPTION	HATCH COLOR
بلاط اسمنتي بحصة سيل 40X40X4cm	
AJLOUN STONE STAIR TREADS- 4cm STAIR RISERS- 2cm	
RAILING 02	

KHAMMASH ARCHITECTS
 P.O. Box 92474, Amman - 11192, Jordan. Tel: +962 6 5696154. Fax: +962 6 5622396
 Email: info@khammash.com

CLIENT
Petra Development & Tourism Region Authority

PROJECT
Road 4
 ADDRESS
Wadi Musa, JORDAN

STATUS
TENDER
 Copyright © Khammash Architects
 THIS DRAWING IS AND AT ALL TIMES REMAINS THE EXCLUSIVE PROPERTY OF KHAMMASH ARCHITECTS. ALL MEASUREMENTS MUST BE CHECKED BY THE CONTRACTOR ON SITE BEFORE THE COMMENCEMENT OF ANY WORKS.


NOTES

DRAWN
 CHECKED
 APPROVED
 AK

NORTH
 SCALE
 1:100 A1

DRAWING TITLE
GROUND FLOOR PLAN-KEY PLAN-FROM 4.00-4.80
 SHEET NUMBER
A-ZA-041
 ISSUE DATE
May.2022

ISSUE DATE AMENDMENT CHECKED

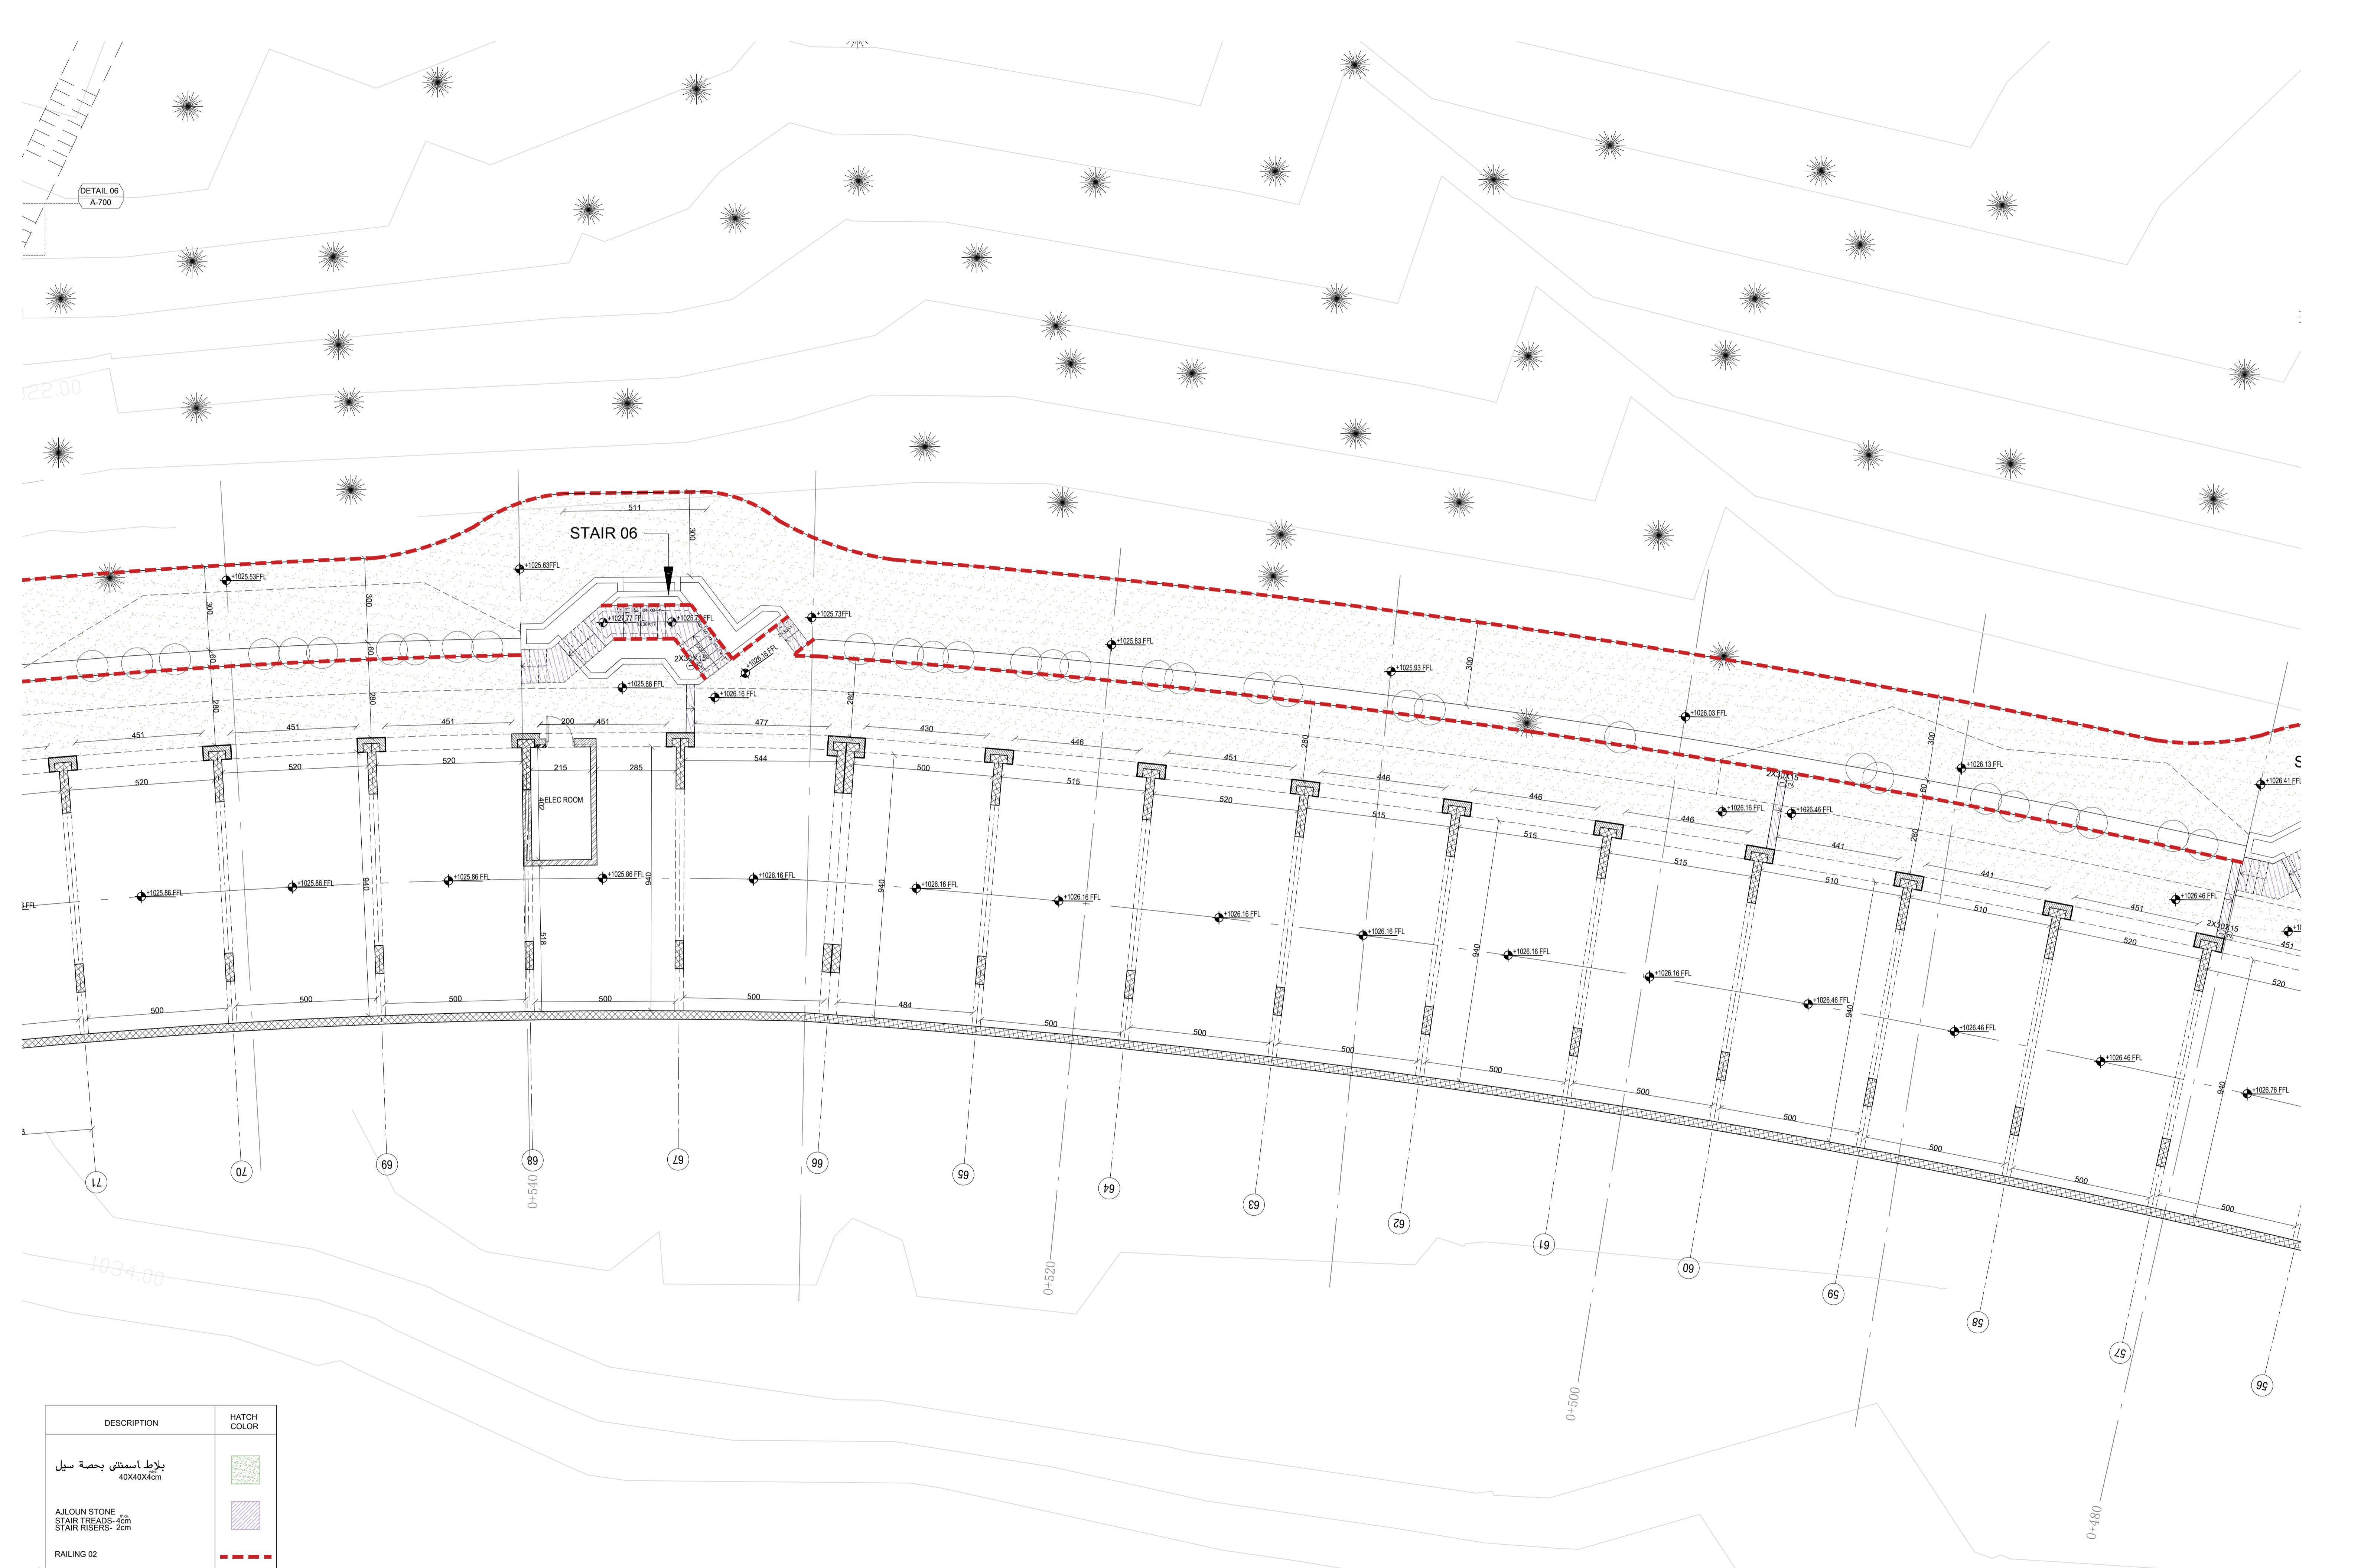

DETAIL 06
A-700

STAIR 06

ELEC ROOM

DESCRIPTION	HATCH COLOR
بلاط اسمنتية بحصة سيل 40x40x4cm	
AJLOUN STONE STAIR TREADS- 4cm STAIR RISERS- 2cm	
RAILING 02	

KHAMMASH ARCHITECTS

CLIENT
Petra Development & Tourism Region Authority

PROJECT
Road 4

ADDRESS
Wadi Musa, JORDAN

STATUS
TENDER

Copyright © Khammash Architects
THIS DRAWING IS AND AT ALL TIMES REMAINS THE EXCLUSIVE PROPERTY OF KHAMMASH ARCHITECTS. ALL MEASUREMENTS MUST BE CHECKED BY THE CONTRACTOR ON SITE BEFORE THE COMMENCEMENT OF ANY WORKS.

NOTES

DRAWN
CHECKED

APPROVED
AK


NORTH
SCALE
1:100 A1

DATE
AMENDMENT
CHECKED

DRAWING TITLE
GROUND FLOOR PLAN- KEY PLAN-FROM 480-550

SHEET NUMBER
A-ZA-042

ISSUE DATE
- May.2022

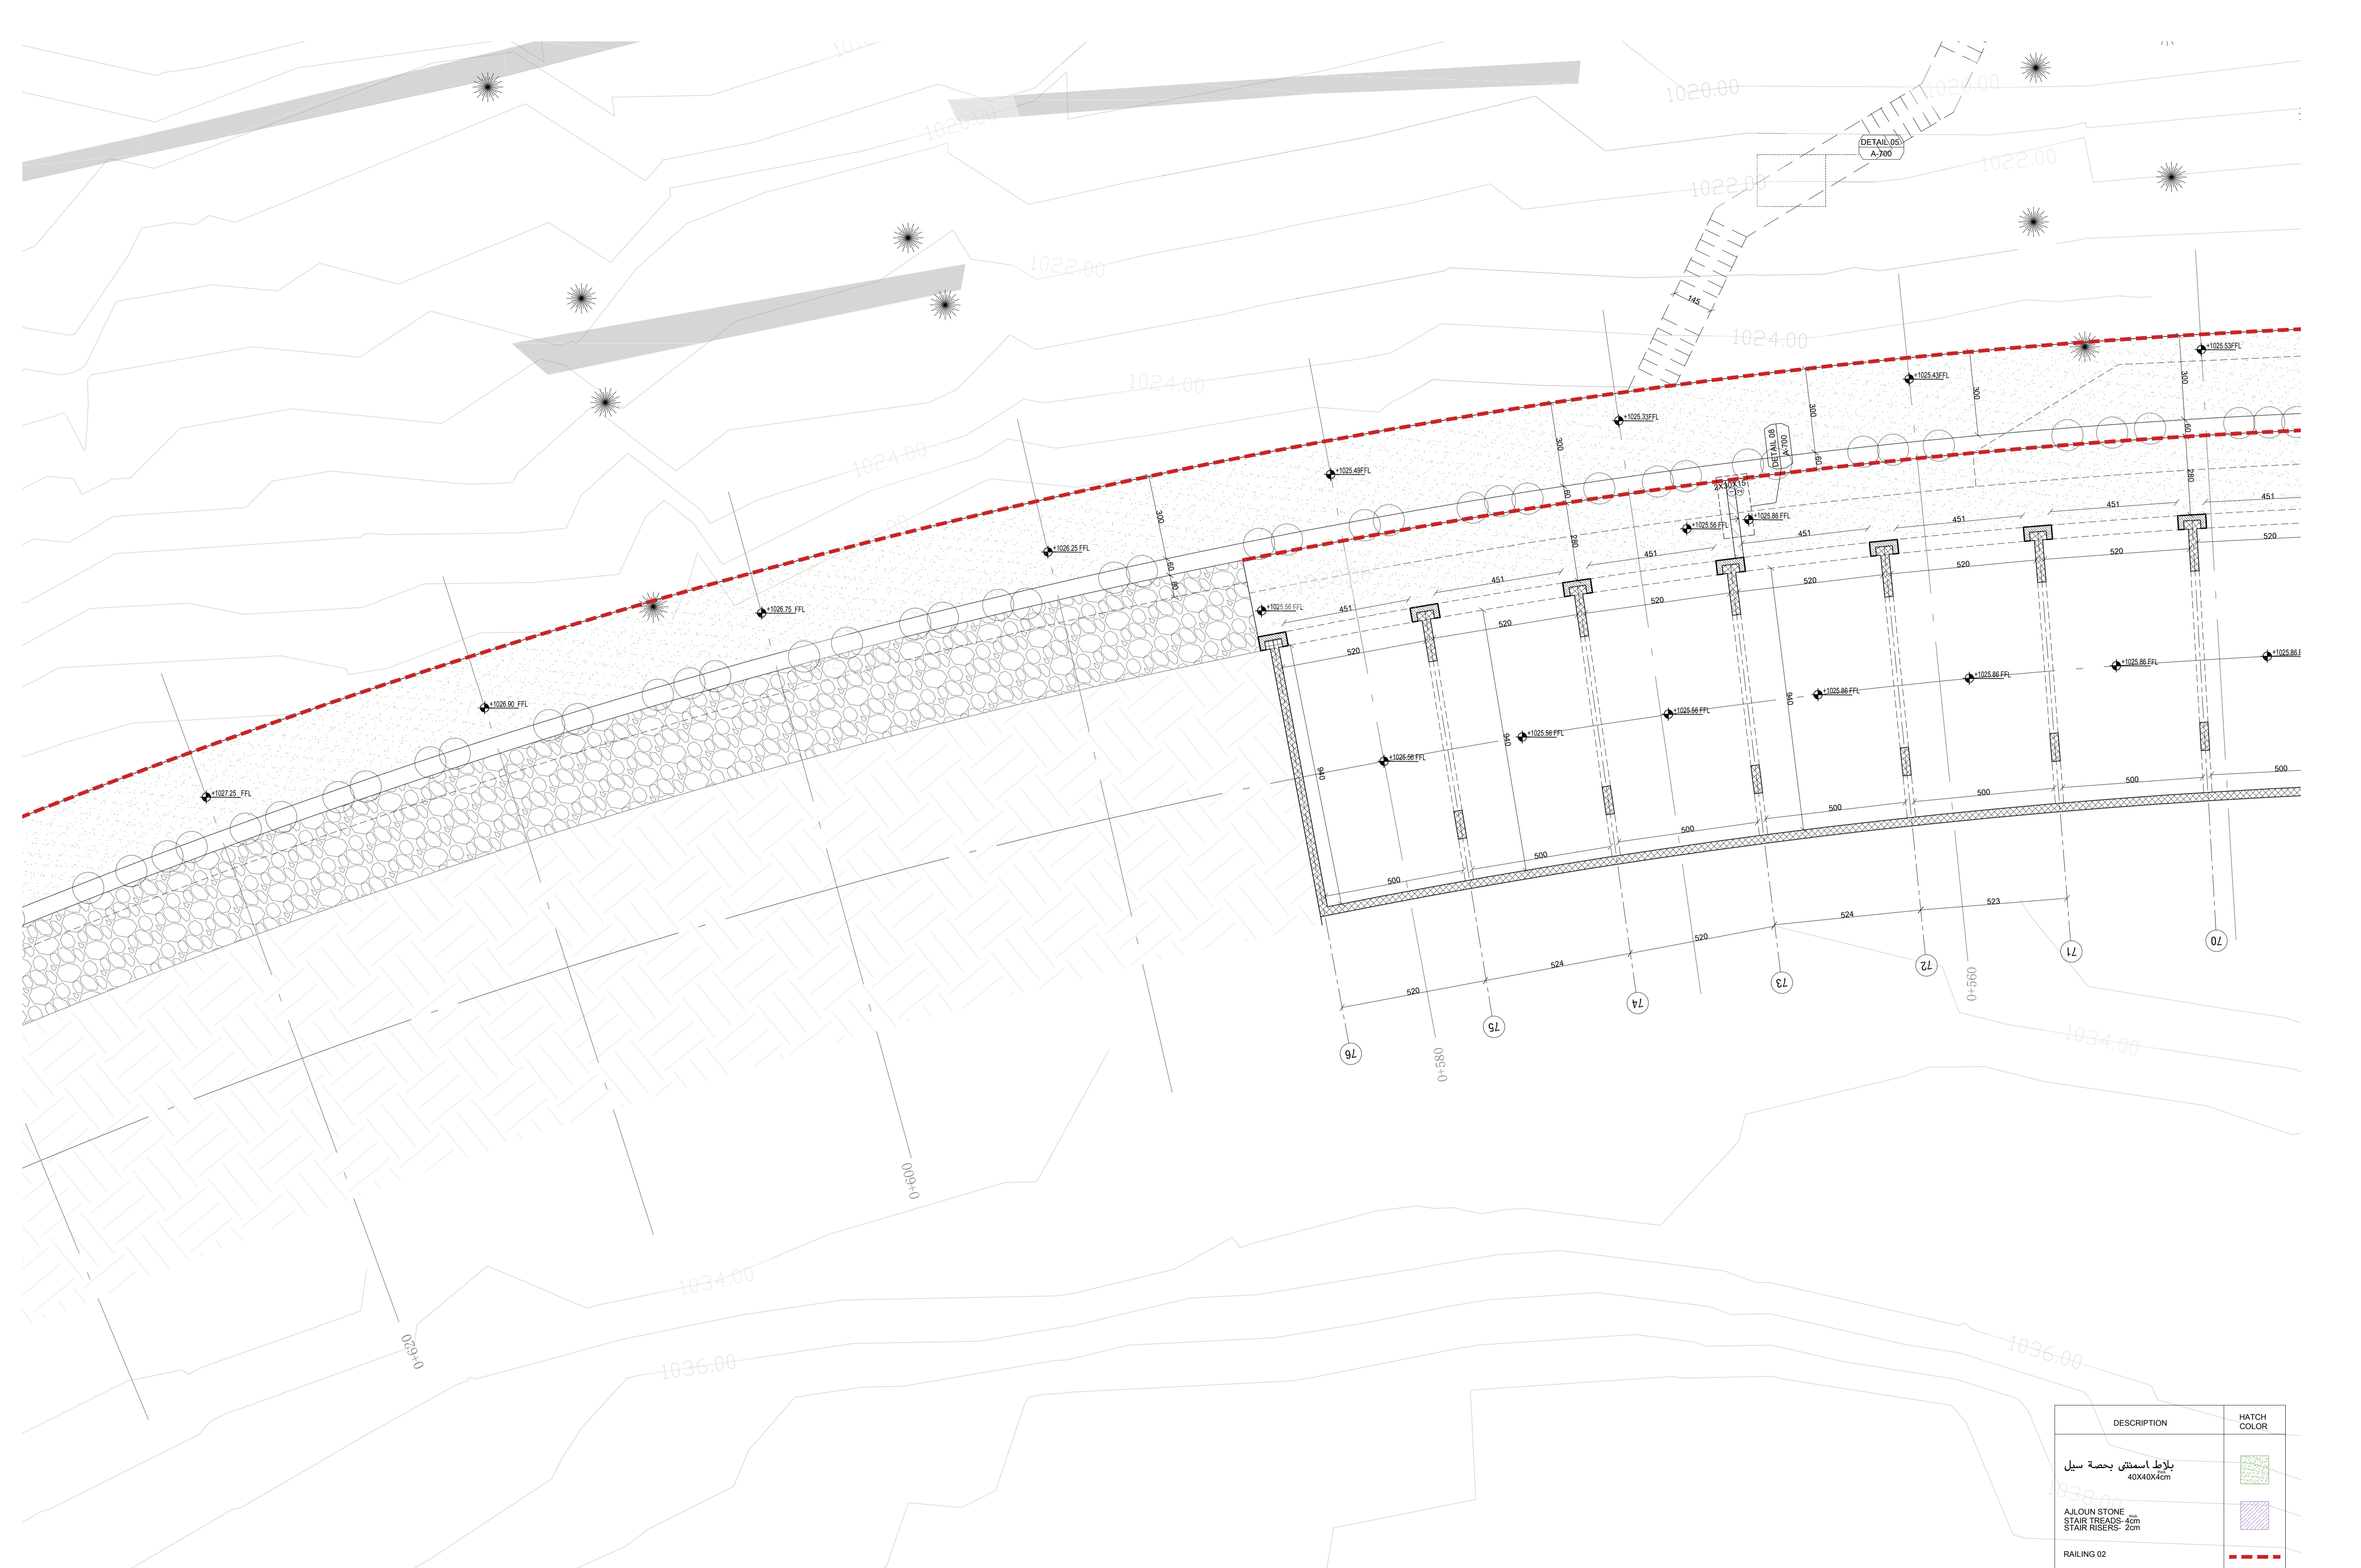

DESCRIPTION	HATCH COLOR
بلاط اسمنتي بحصة ميل 40X40X4cm	
AJLOUN STONE STAIR TREADS- 4cm STAIR RISERS- 2cm	
RAILING 02	

KHAMMASH ARCHITECTS

CLIENT
Petra Development & Tourism Region Authority

PROJECT
Road 4

STATUS
TENDER

NOTES

P.O. Box 52474, Amman - 11192, Jordan. Tel: +962 6 5696154. Fax: +962 6 5622396
Email: info@khammash.com

P.O. Box 7693, Amman 11118, Jordan | T +962 6 5005555 | F +962 6 4650839 | W www.hbf.com

Wadi Musa, JORDAN

Copyright © Khammash Architects
THIS DRAWING IS AND AT ALL TIMES REMAINS THE EXCLUSIVE PROPERTY OF KHAMMASH ARCHITECTS. ALL MEASUREMENTS MUST BE CHECKED BY THE CONTRACTOR ON SITE BEFORE THE COMMENCEMENT OF ANY WORKS.

DRAWN	NORTH	SCALE
CHECKED	APPROVED	1:100 A1
ISSUE	DATE	AMENDMENT
	AK	

DRAWING TITLE	ISSUE	DATE
GROUND FLOOR PLAN-KEY PLAN-FROM 550-620		
SHEET NUMBER	ISSUE	DATE
A-ZA-043		May.2022



KHAMMASH ARCHITECTS
 P.O. Box 52474, Amman - 11192, Jordan, Tel: +962 6 5695154, Fax: +962 6 5622395
 E-mail: info@khammash.com

CLIENT
Petra Development & Tourism Region Authority
 PROJECT
Road 4
 ADDRESS
Wadi Musa, JORDAN


STATUS
TENDER
 Copyright © Khammash Architects
 THIS DRAWING IS AND AT ALL TIMES REMAINS THE EXCLUSIVE PROPERTY OF KHAMMASH ARCHITECTS. ALL MEASUREMENTS MUST BE CHECKED BY THE CONTRACTOR ON SITE BEFORE THE COMMENCEMENT OF ANY WORKS.

NOTES


DRAWN	NORTH	SCALE
CHECKED	APPROVED	1:100 A1
ISSUE	DATE	AMENDMENT
	AK	

DESCRIPTION	HATCH COLOR
بلاطة اسمنتي بحصة ميل 40X40X4cm	
AJLOUN STONE STAIR TREADS- 4cm STAIR RISERS- 2cm	
RAILING 02	


DRAWING TITLE
GROUND FLOOR PLAN-KEY PLAN-FROM 620-690
 SHEET NUMBER
A-ZA-044
 ISSUE | DATE
 - | May.2022

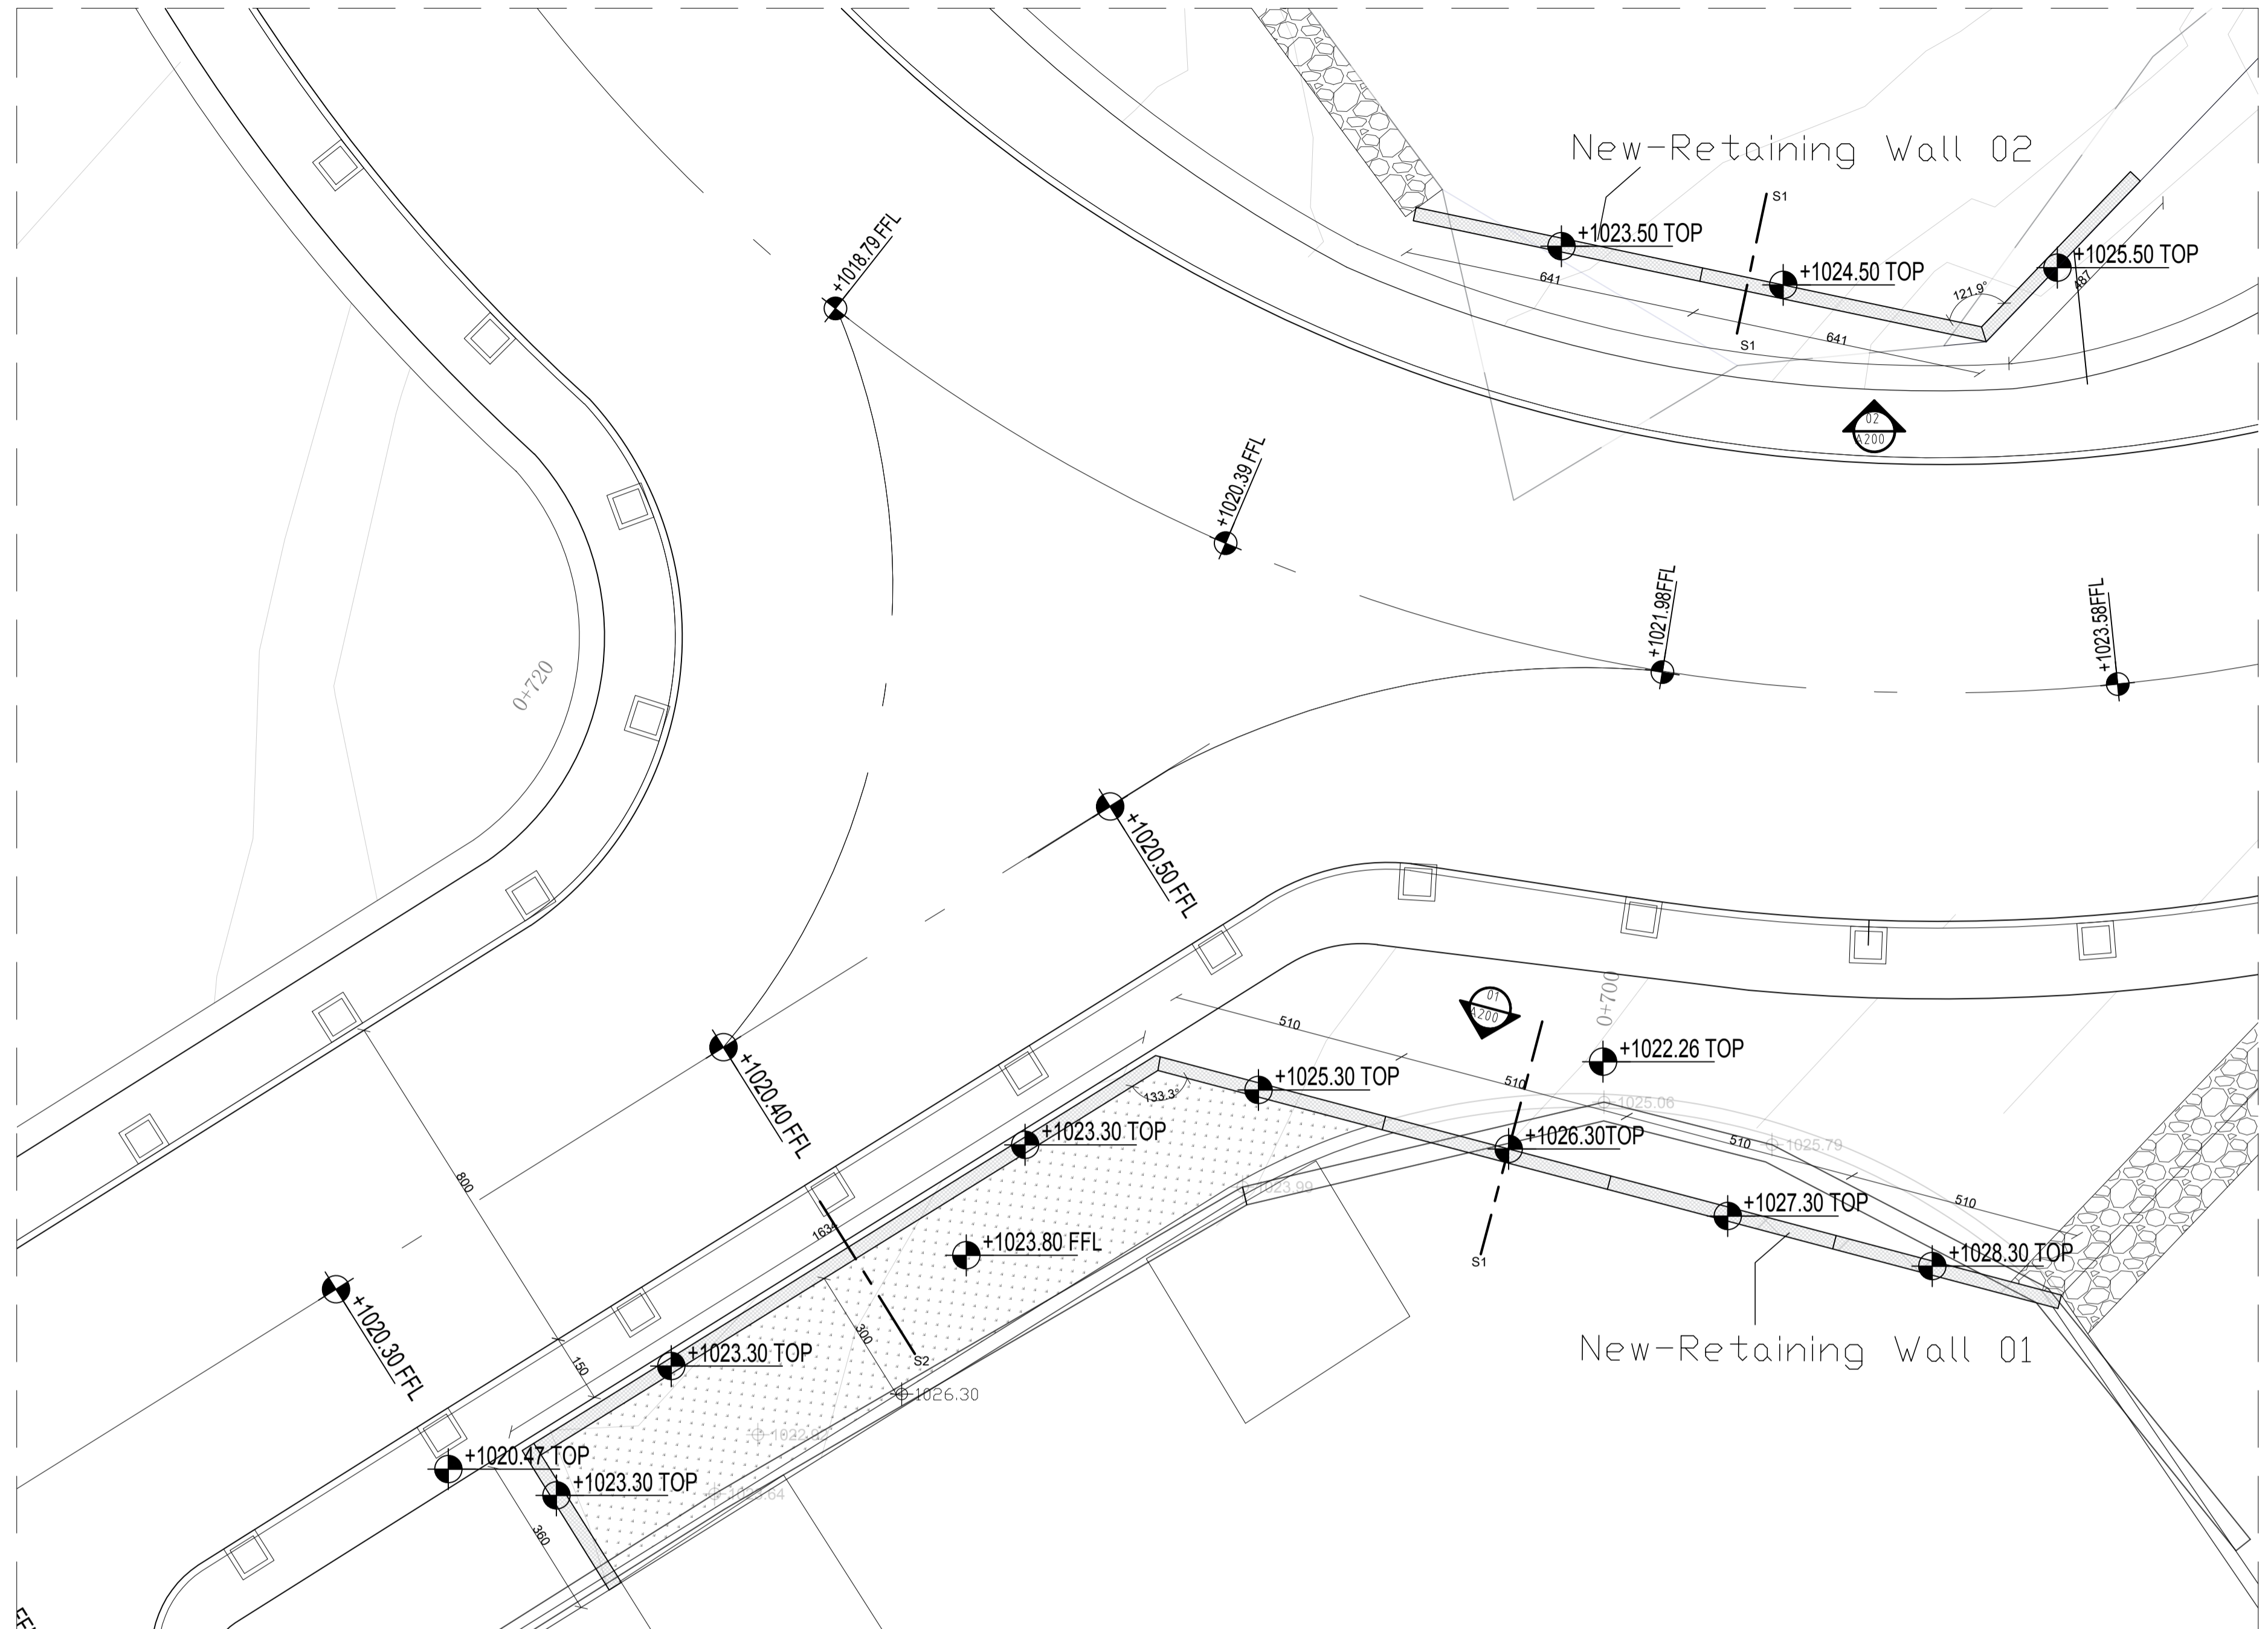


TOP VIEW
SCALE:1-100

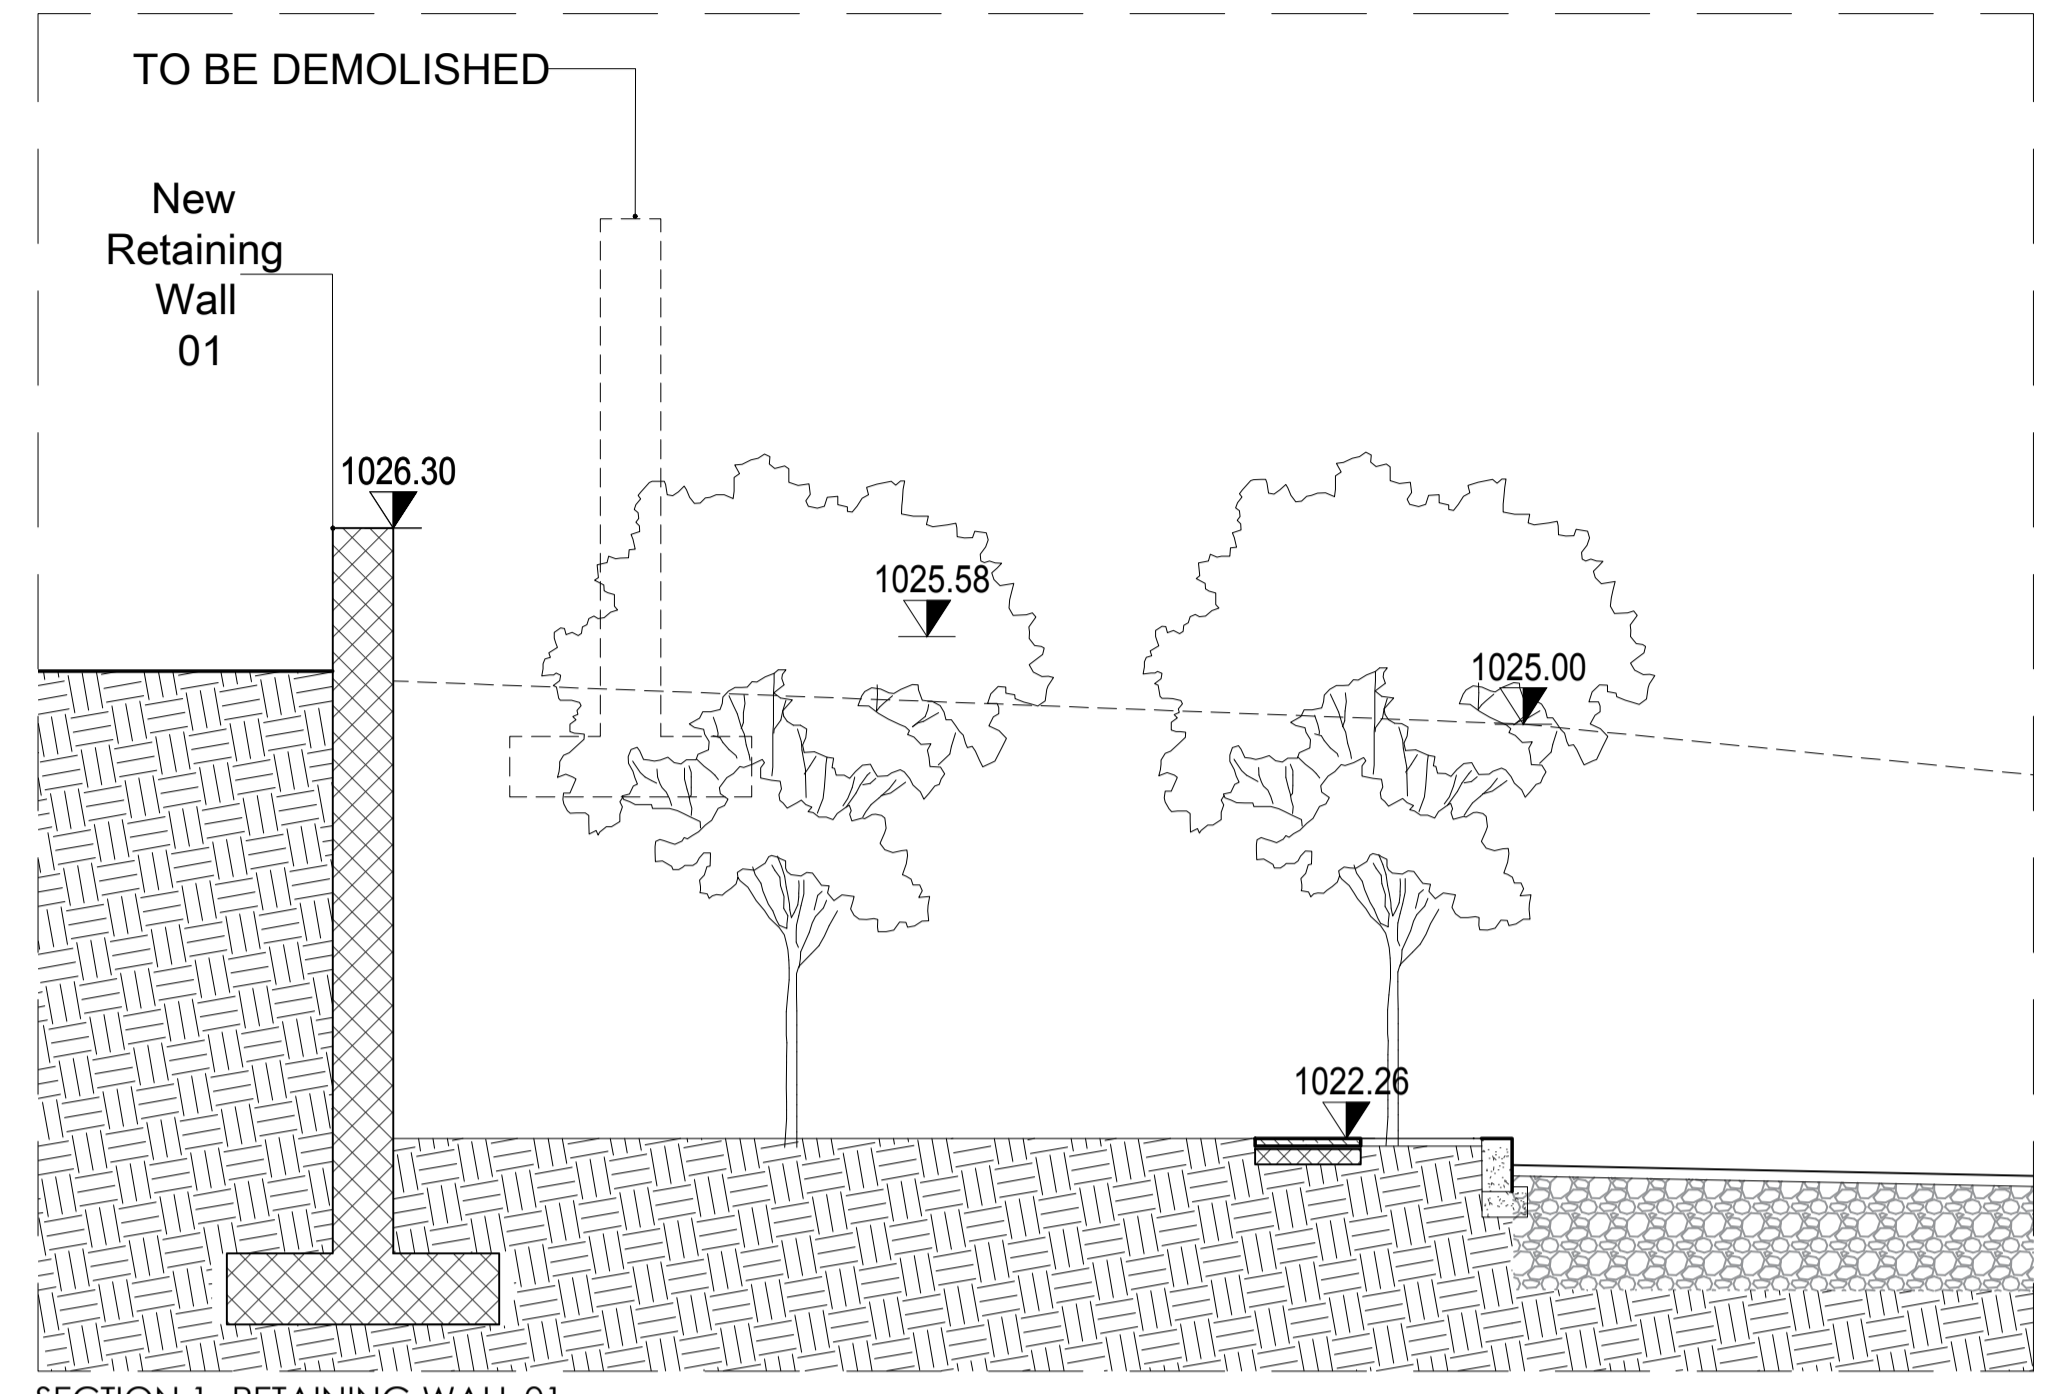


SECTION 1 - RETAINING WALL 01
SCALE:1-50

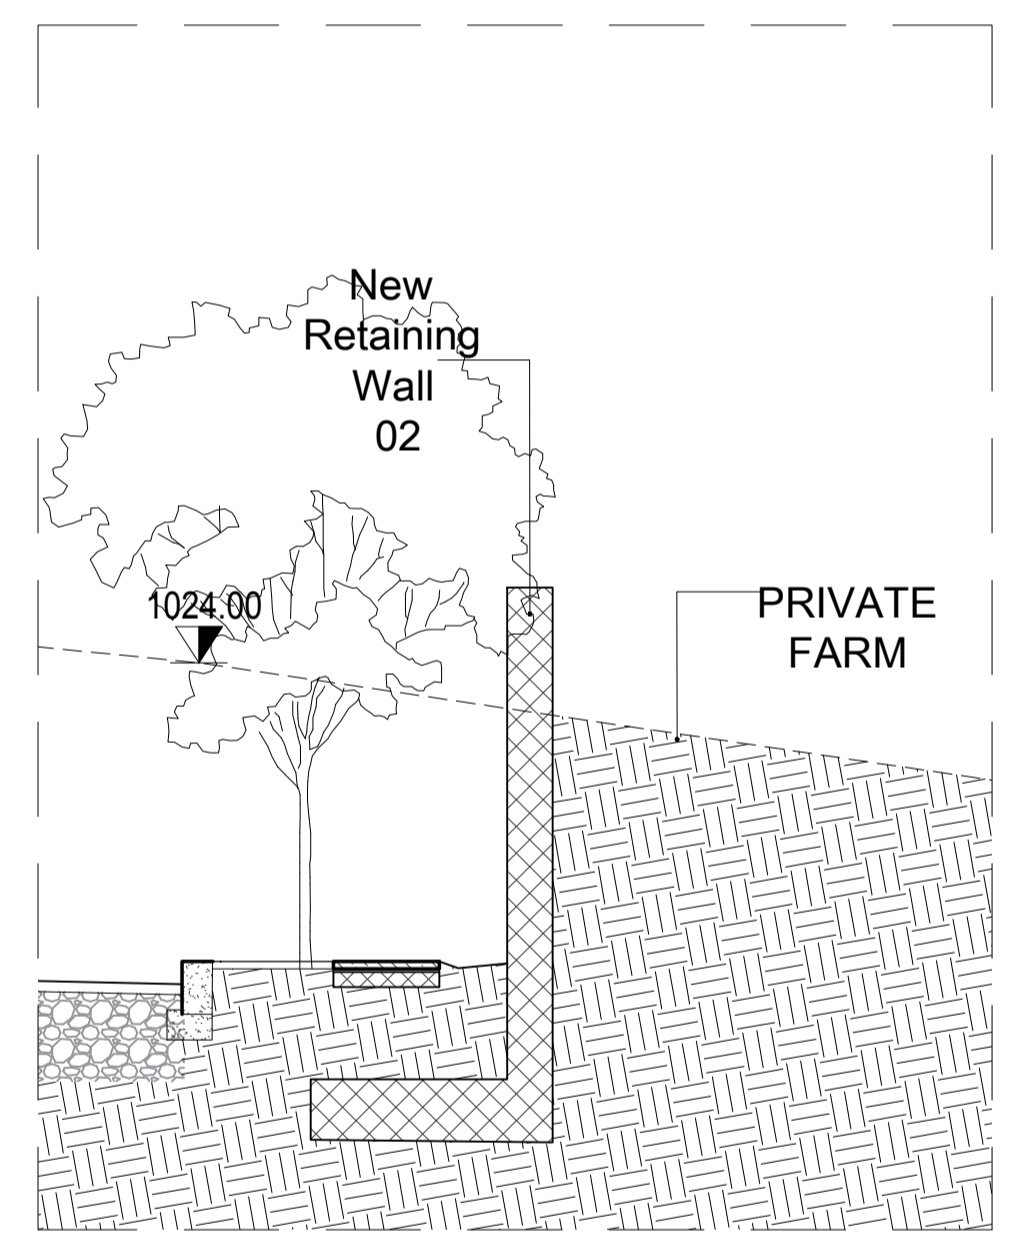


SECTION 1 - RETAINING WALL 02
SCALE:1-50

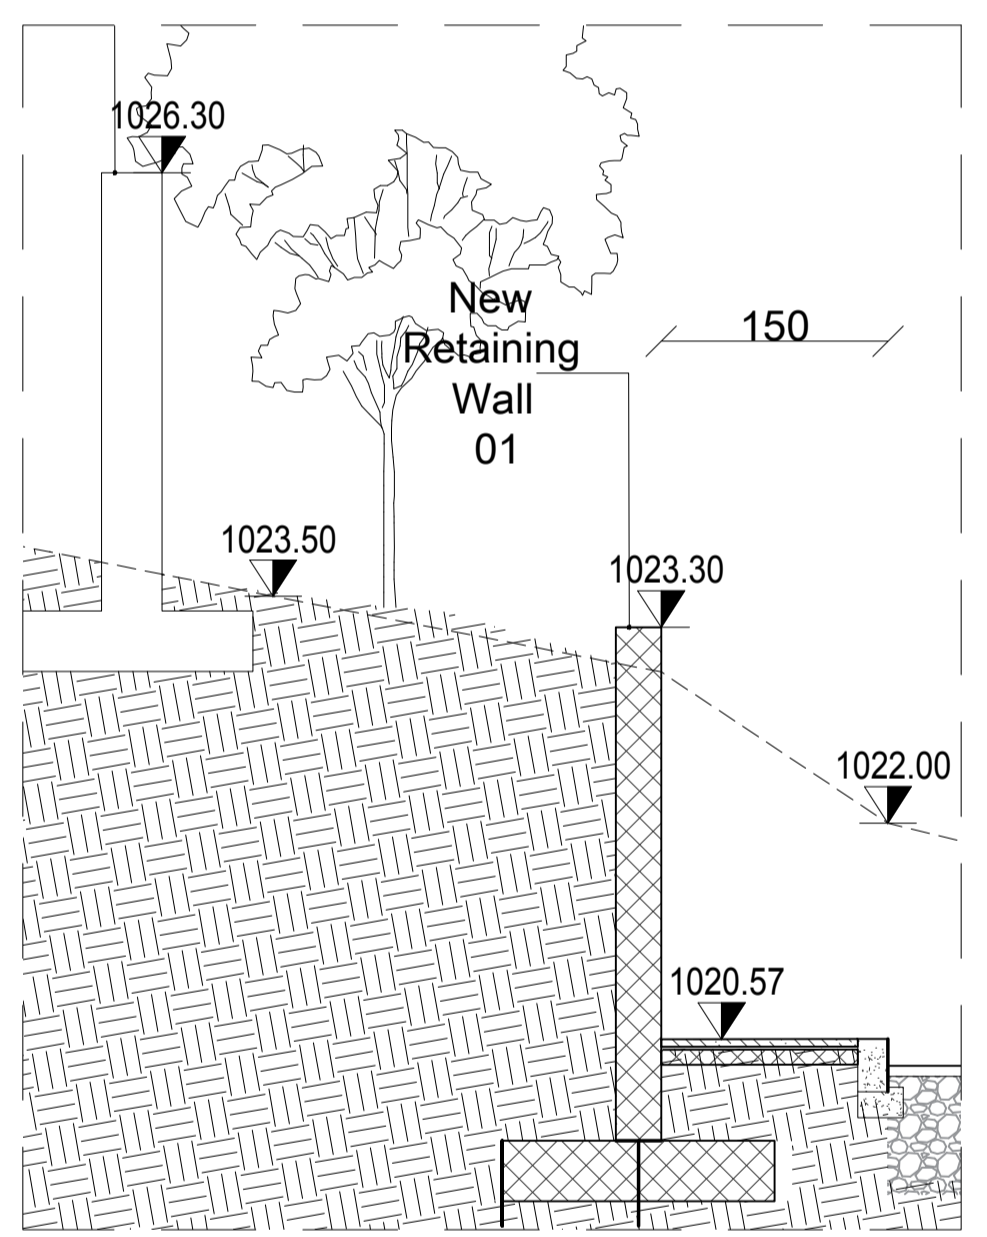


SECTION 2 - RETAINING WALL 01
SCALE:1-50









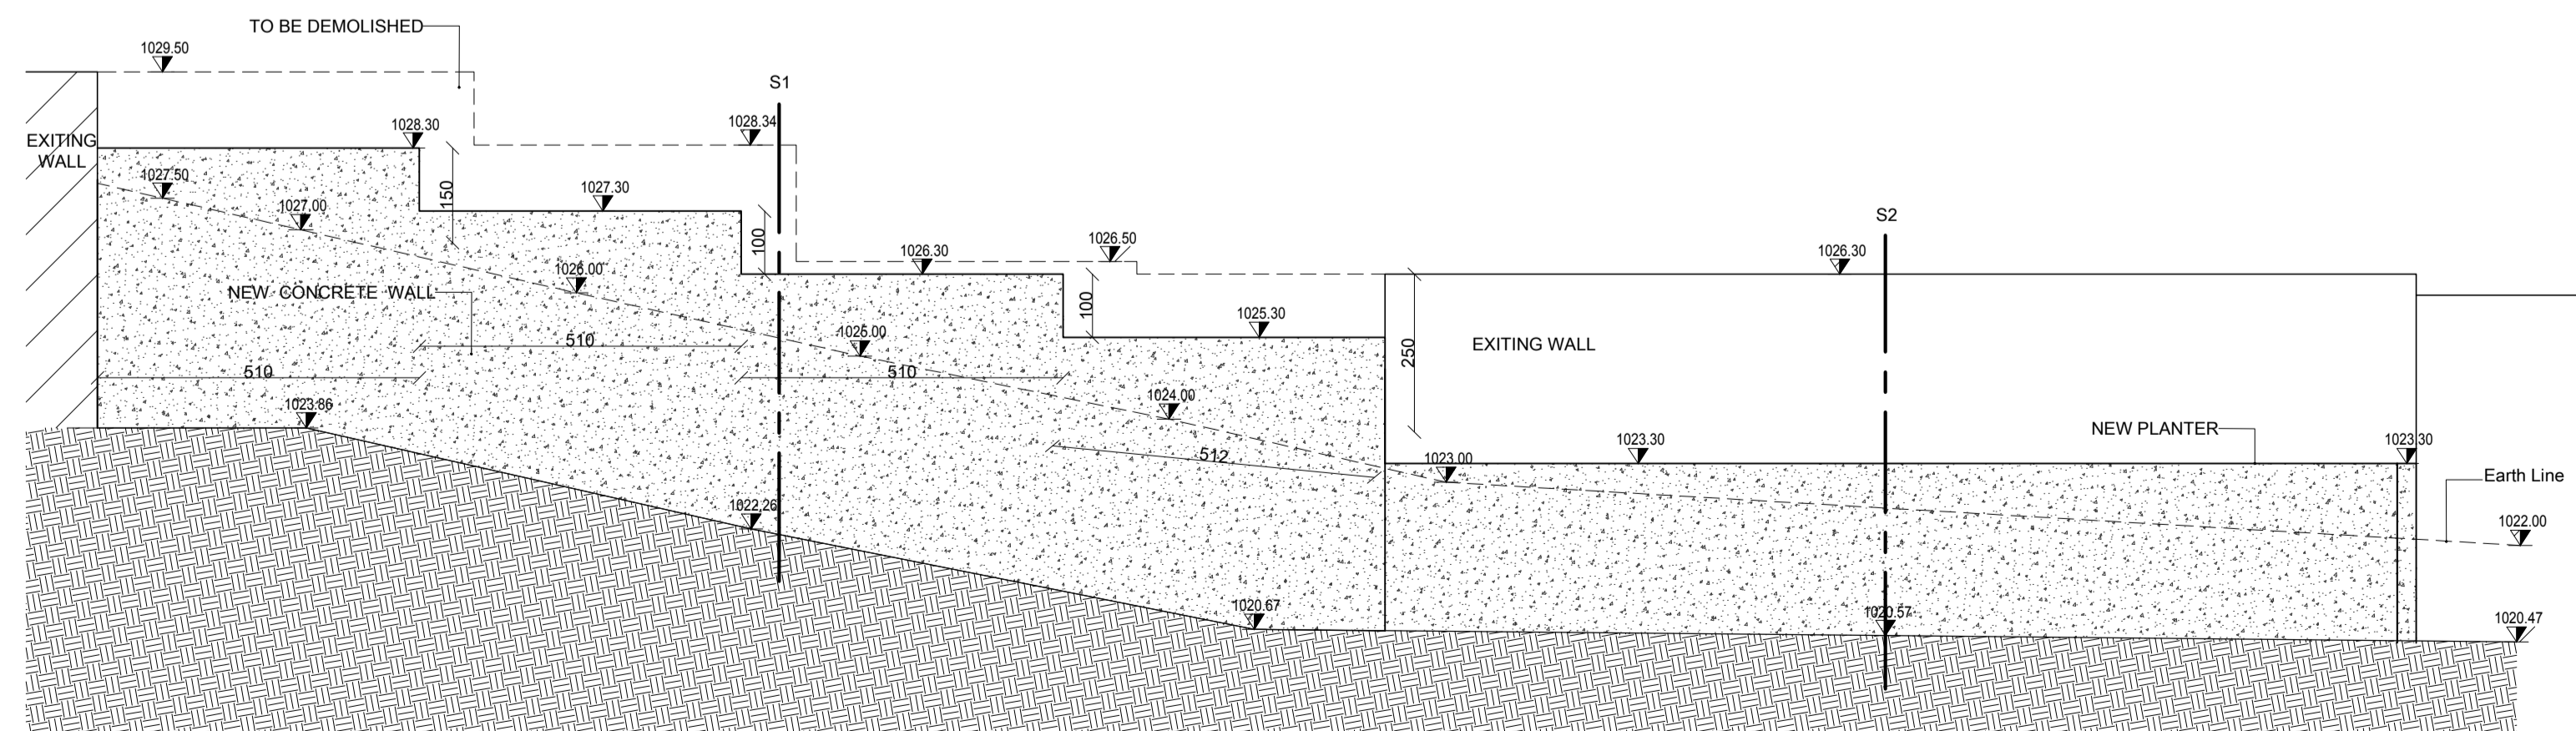





ELEVATION - RETAINING WALL 01
SCALE:1-100

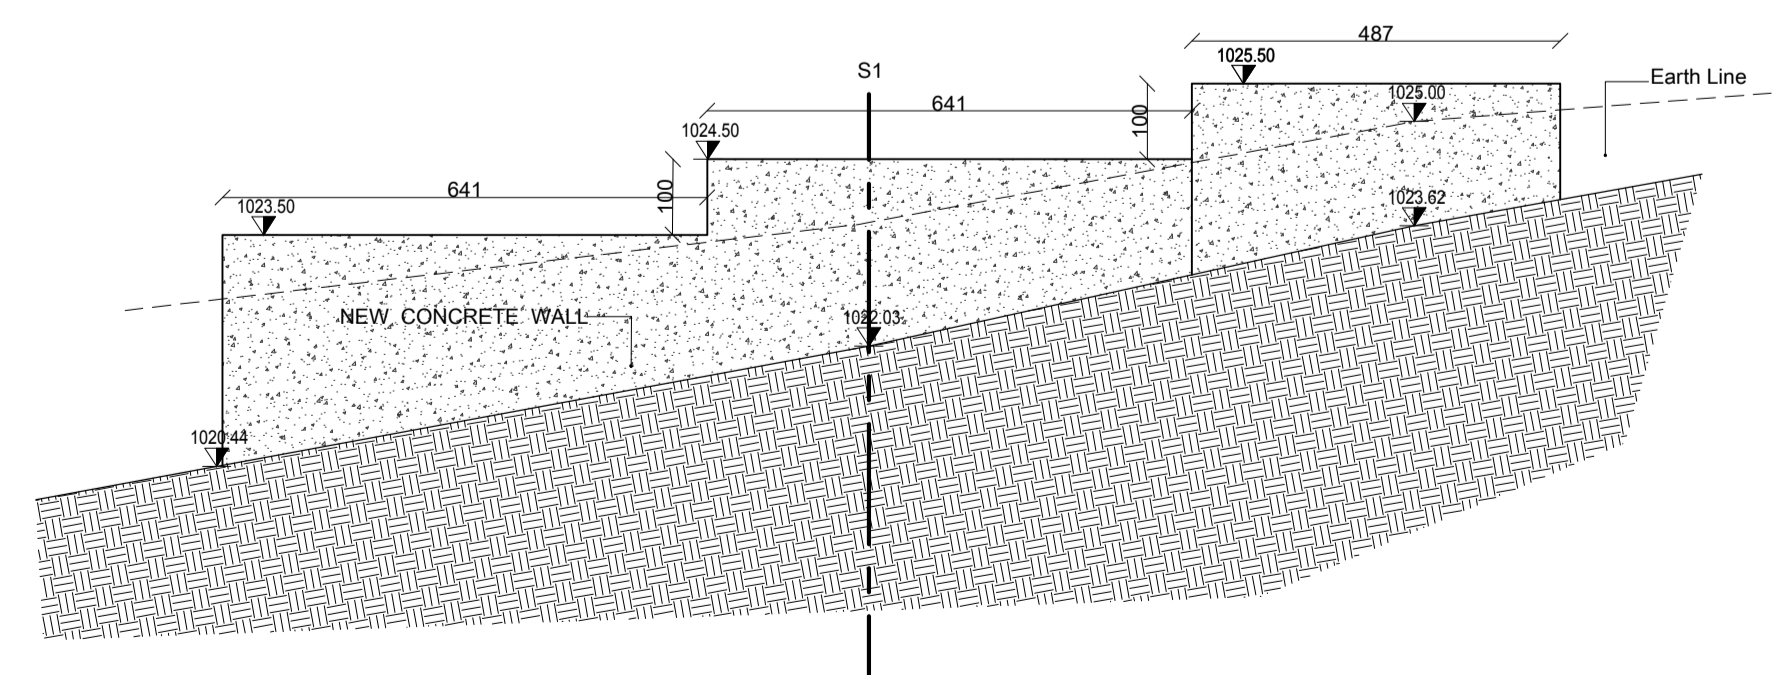

ELEVATION - RETAINING WALL 02
SCALE:1-100

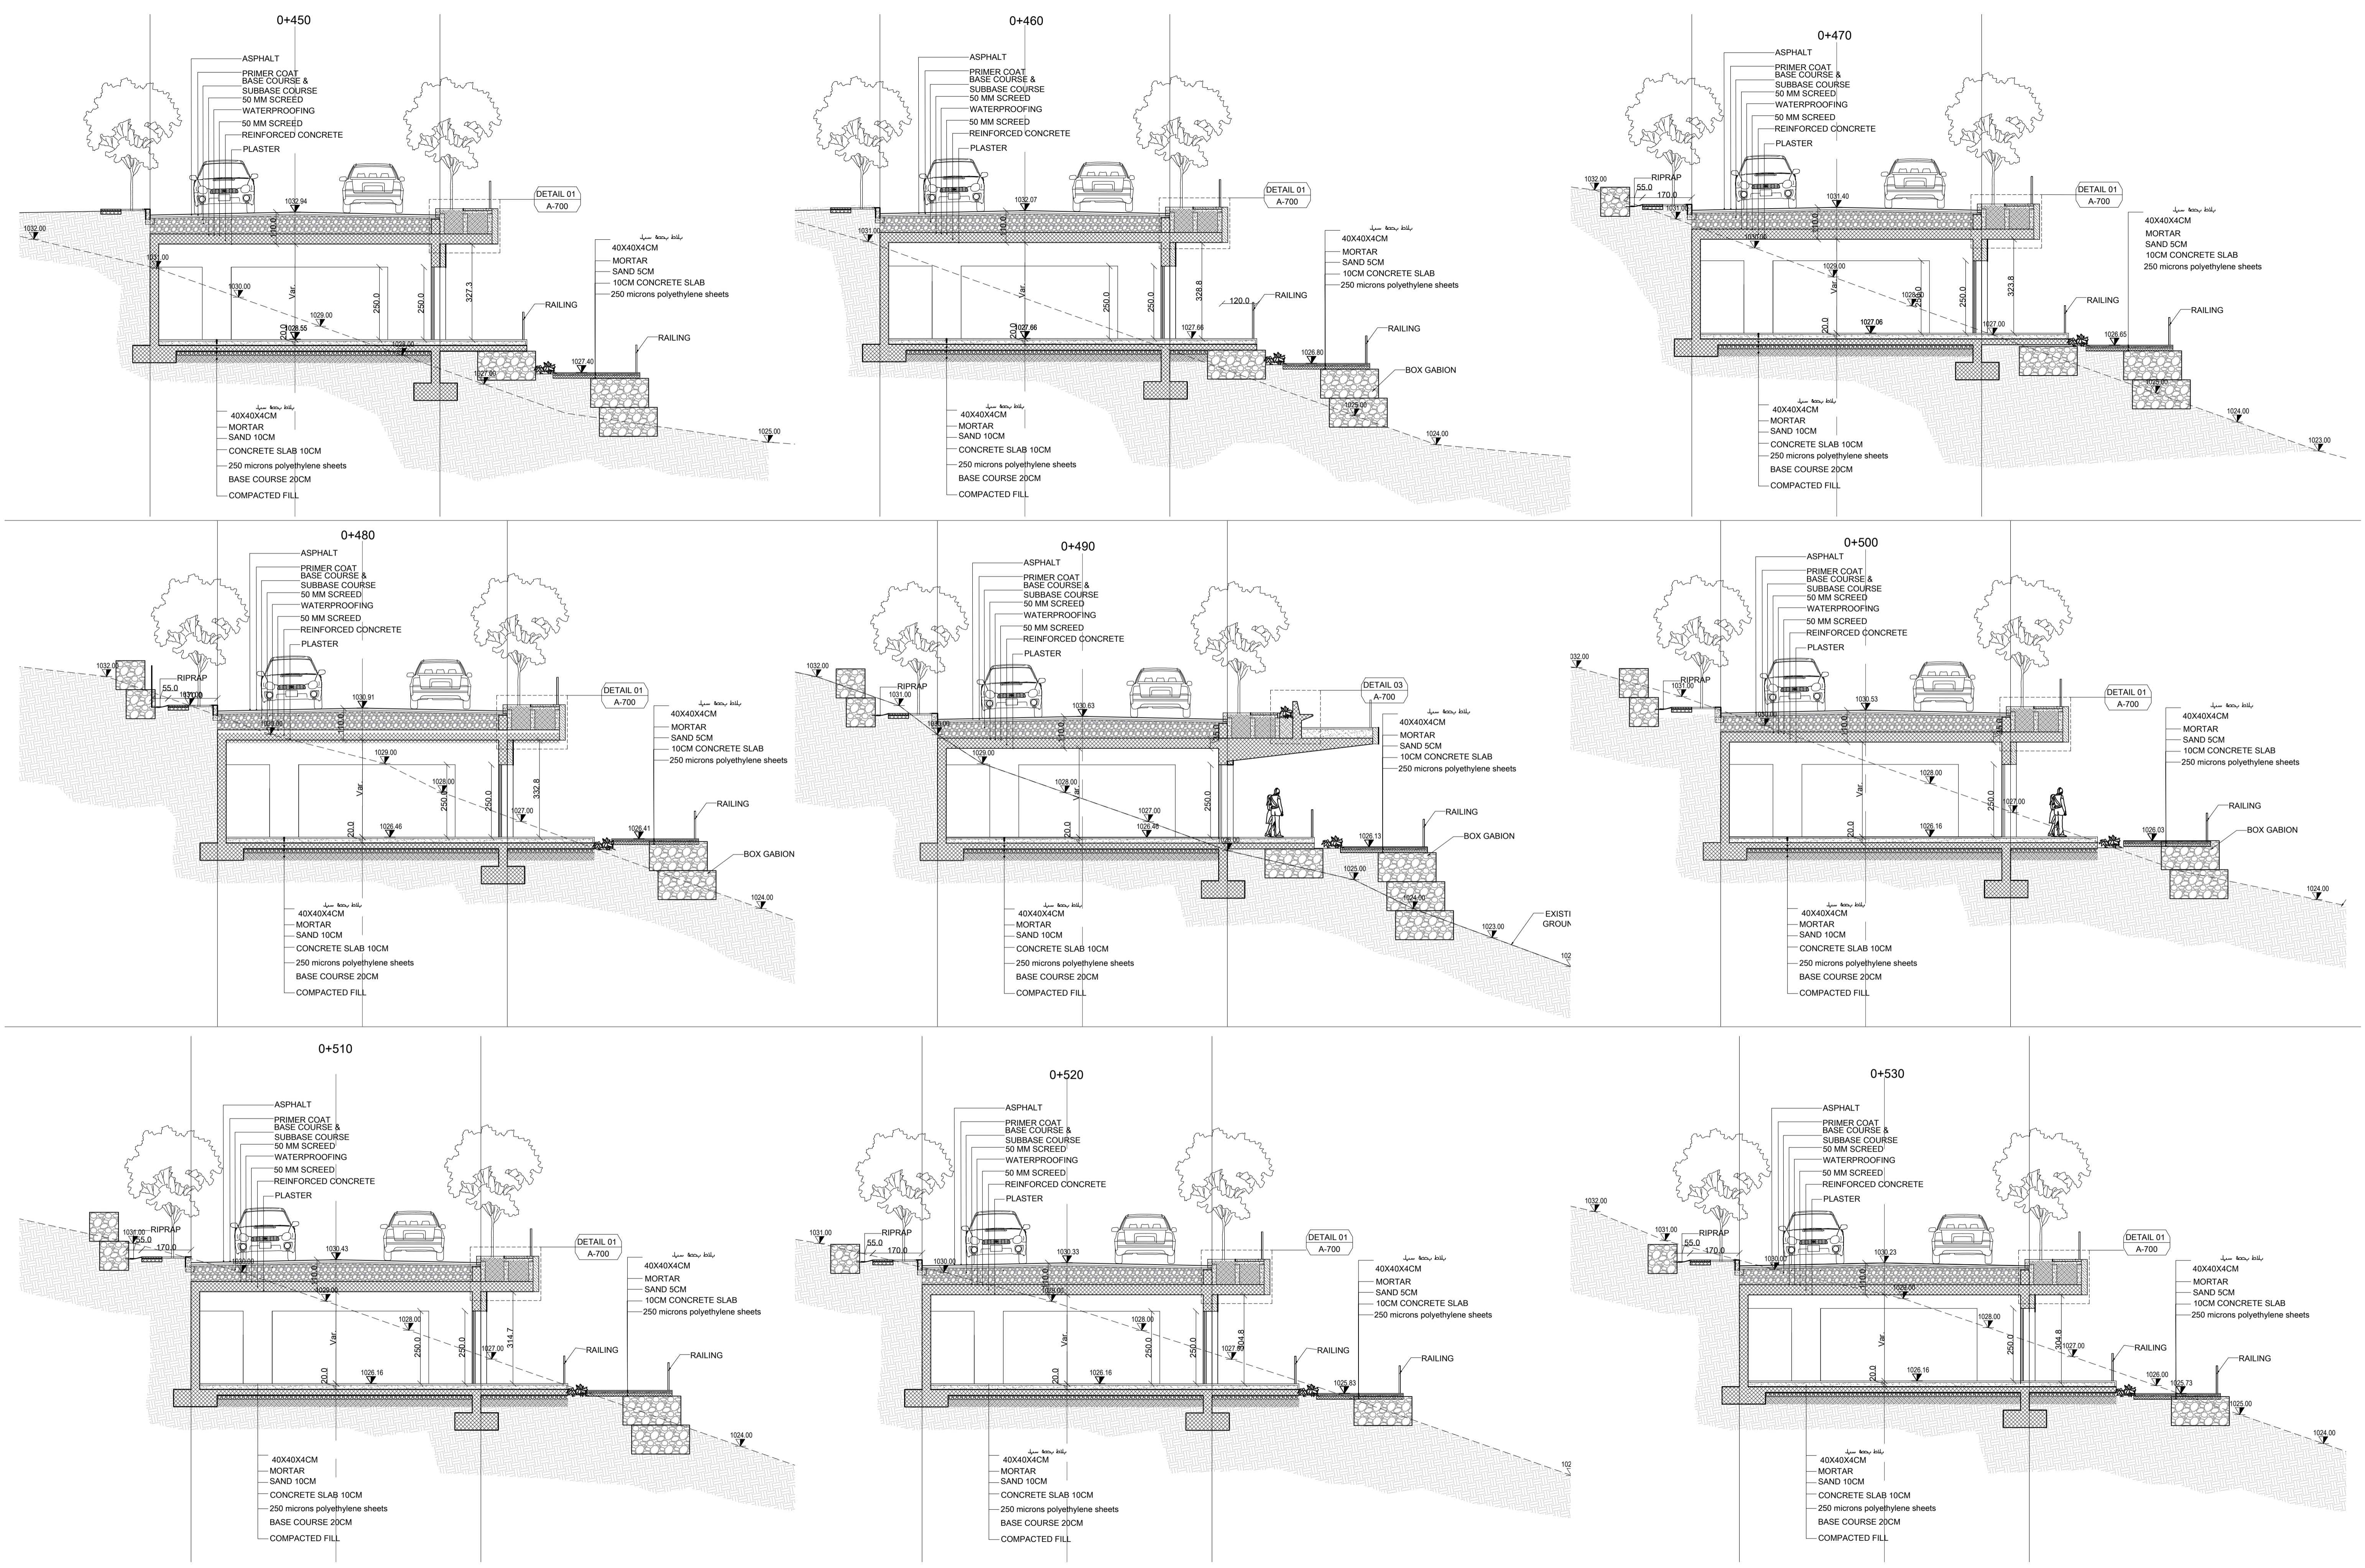

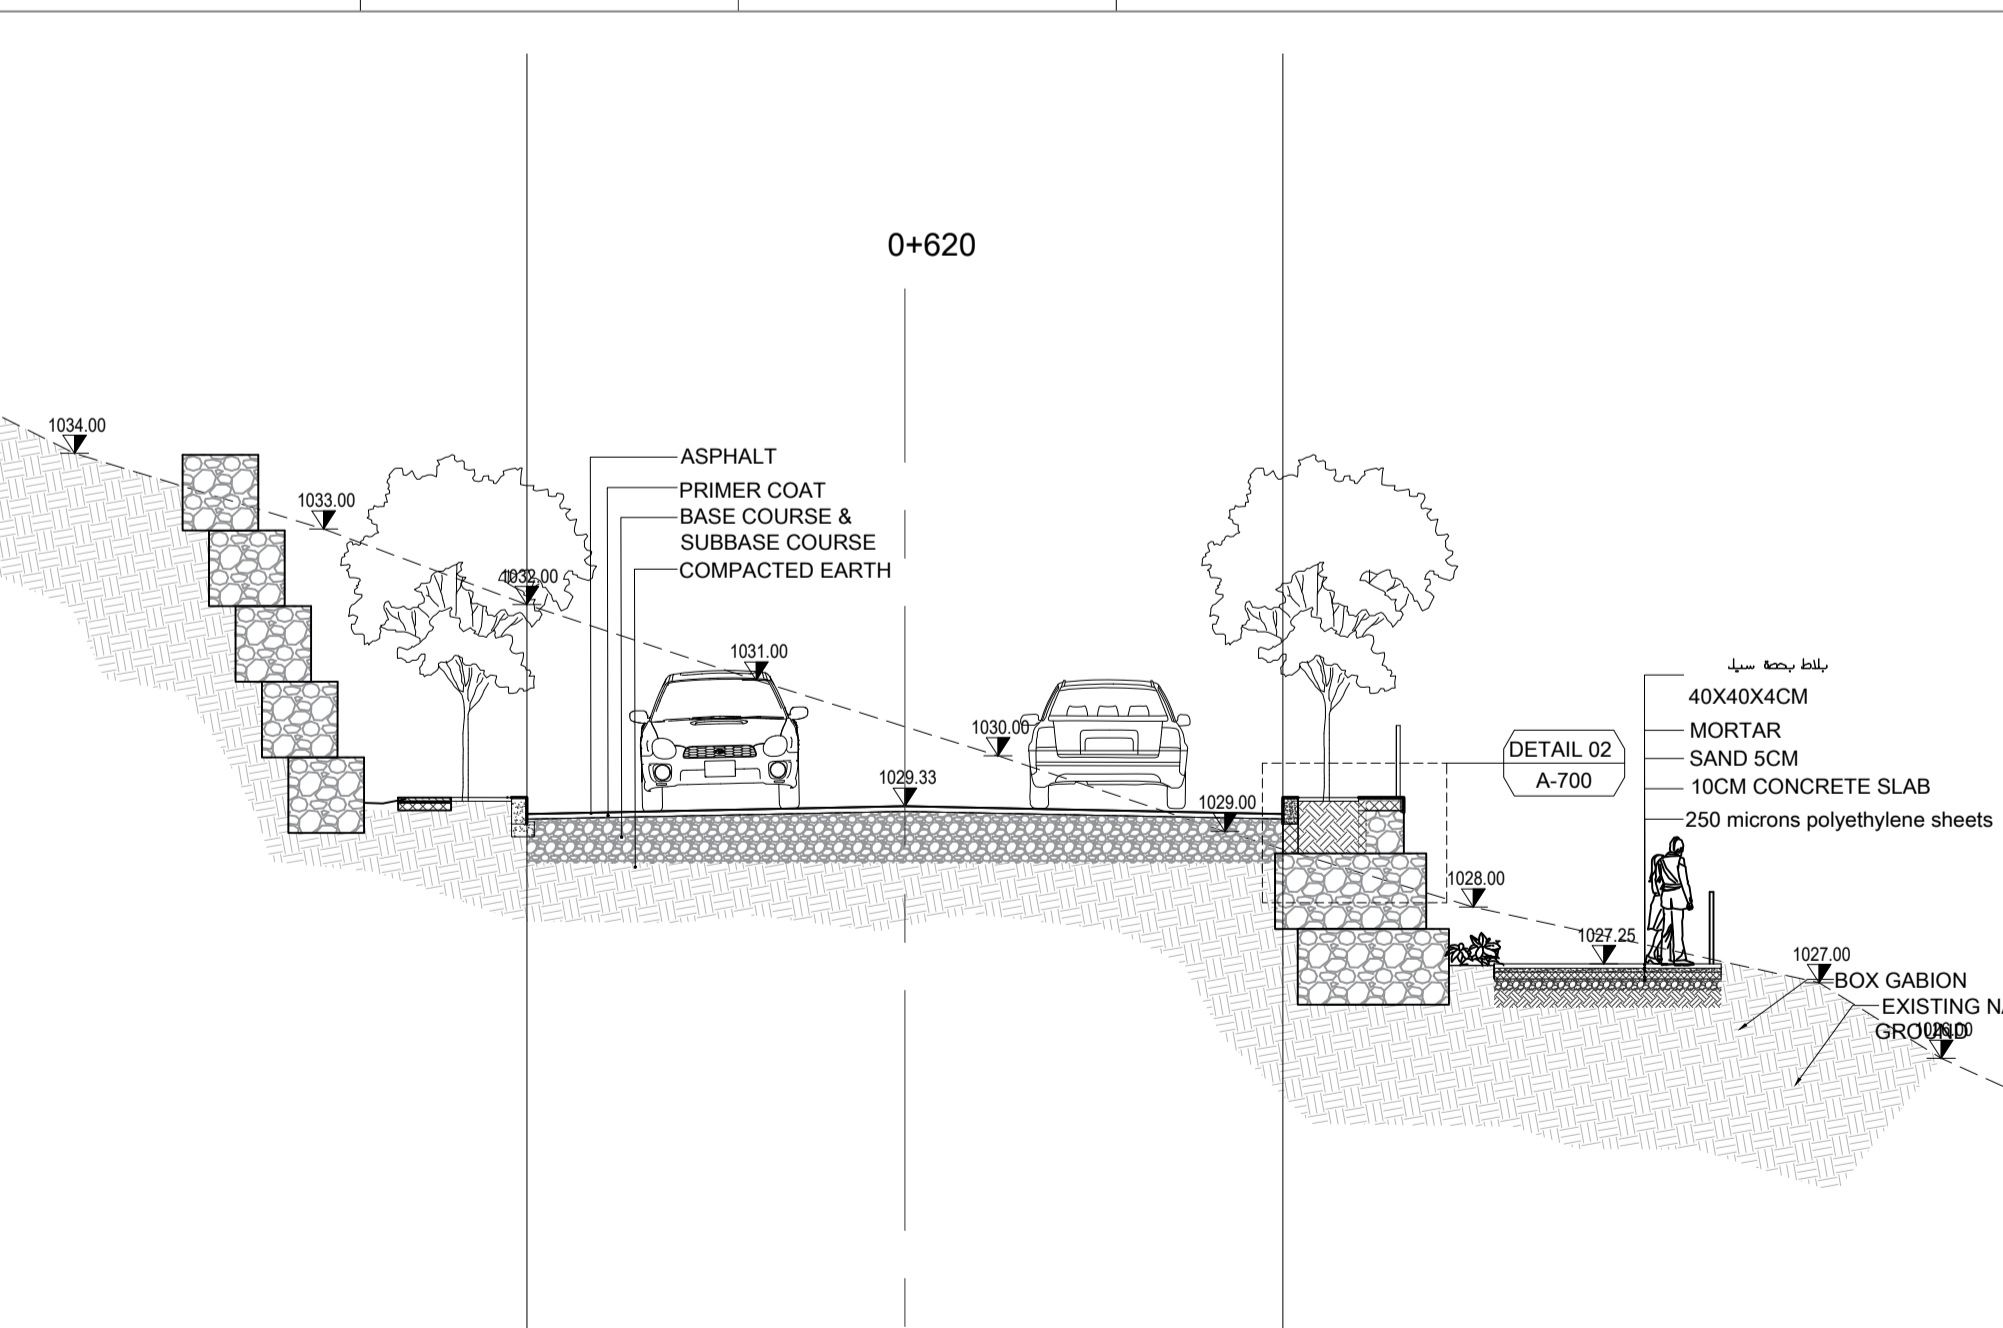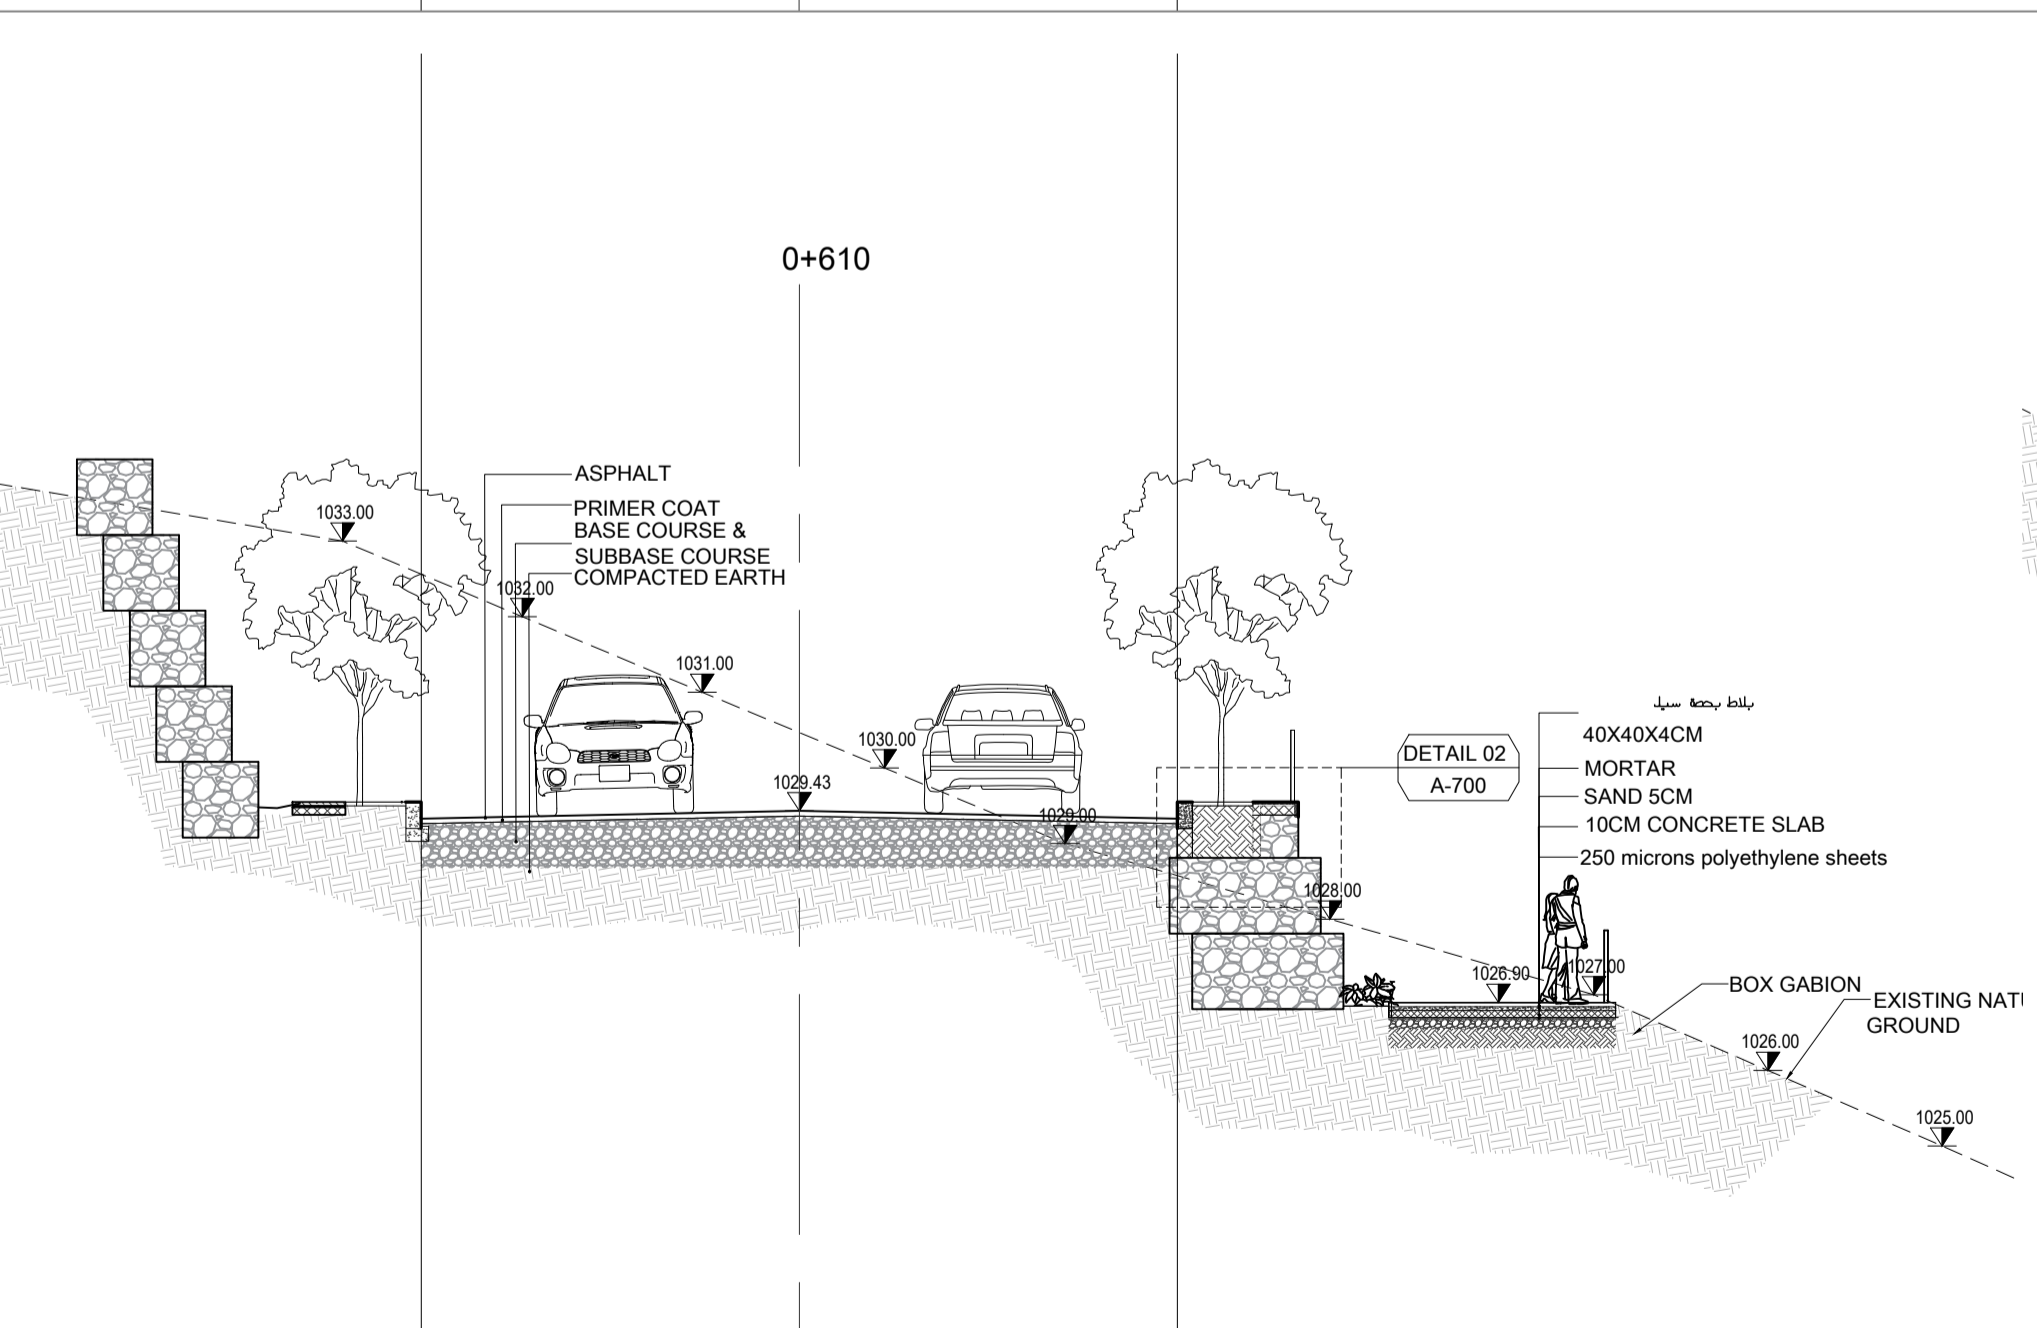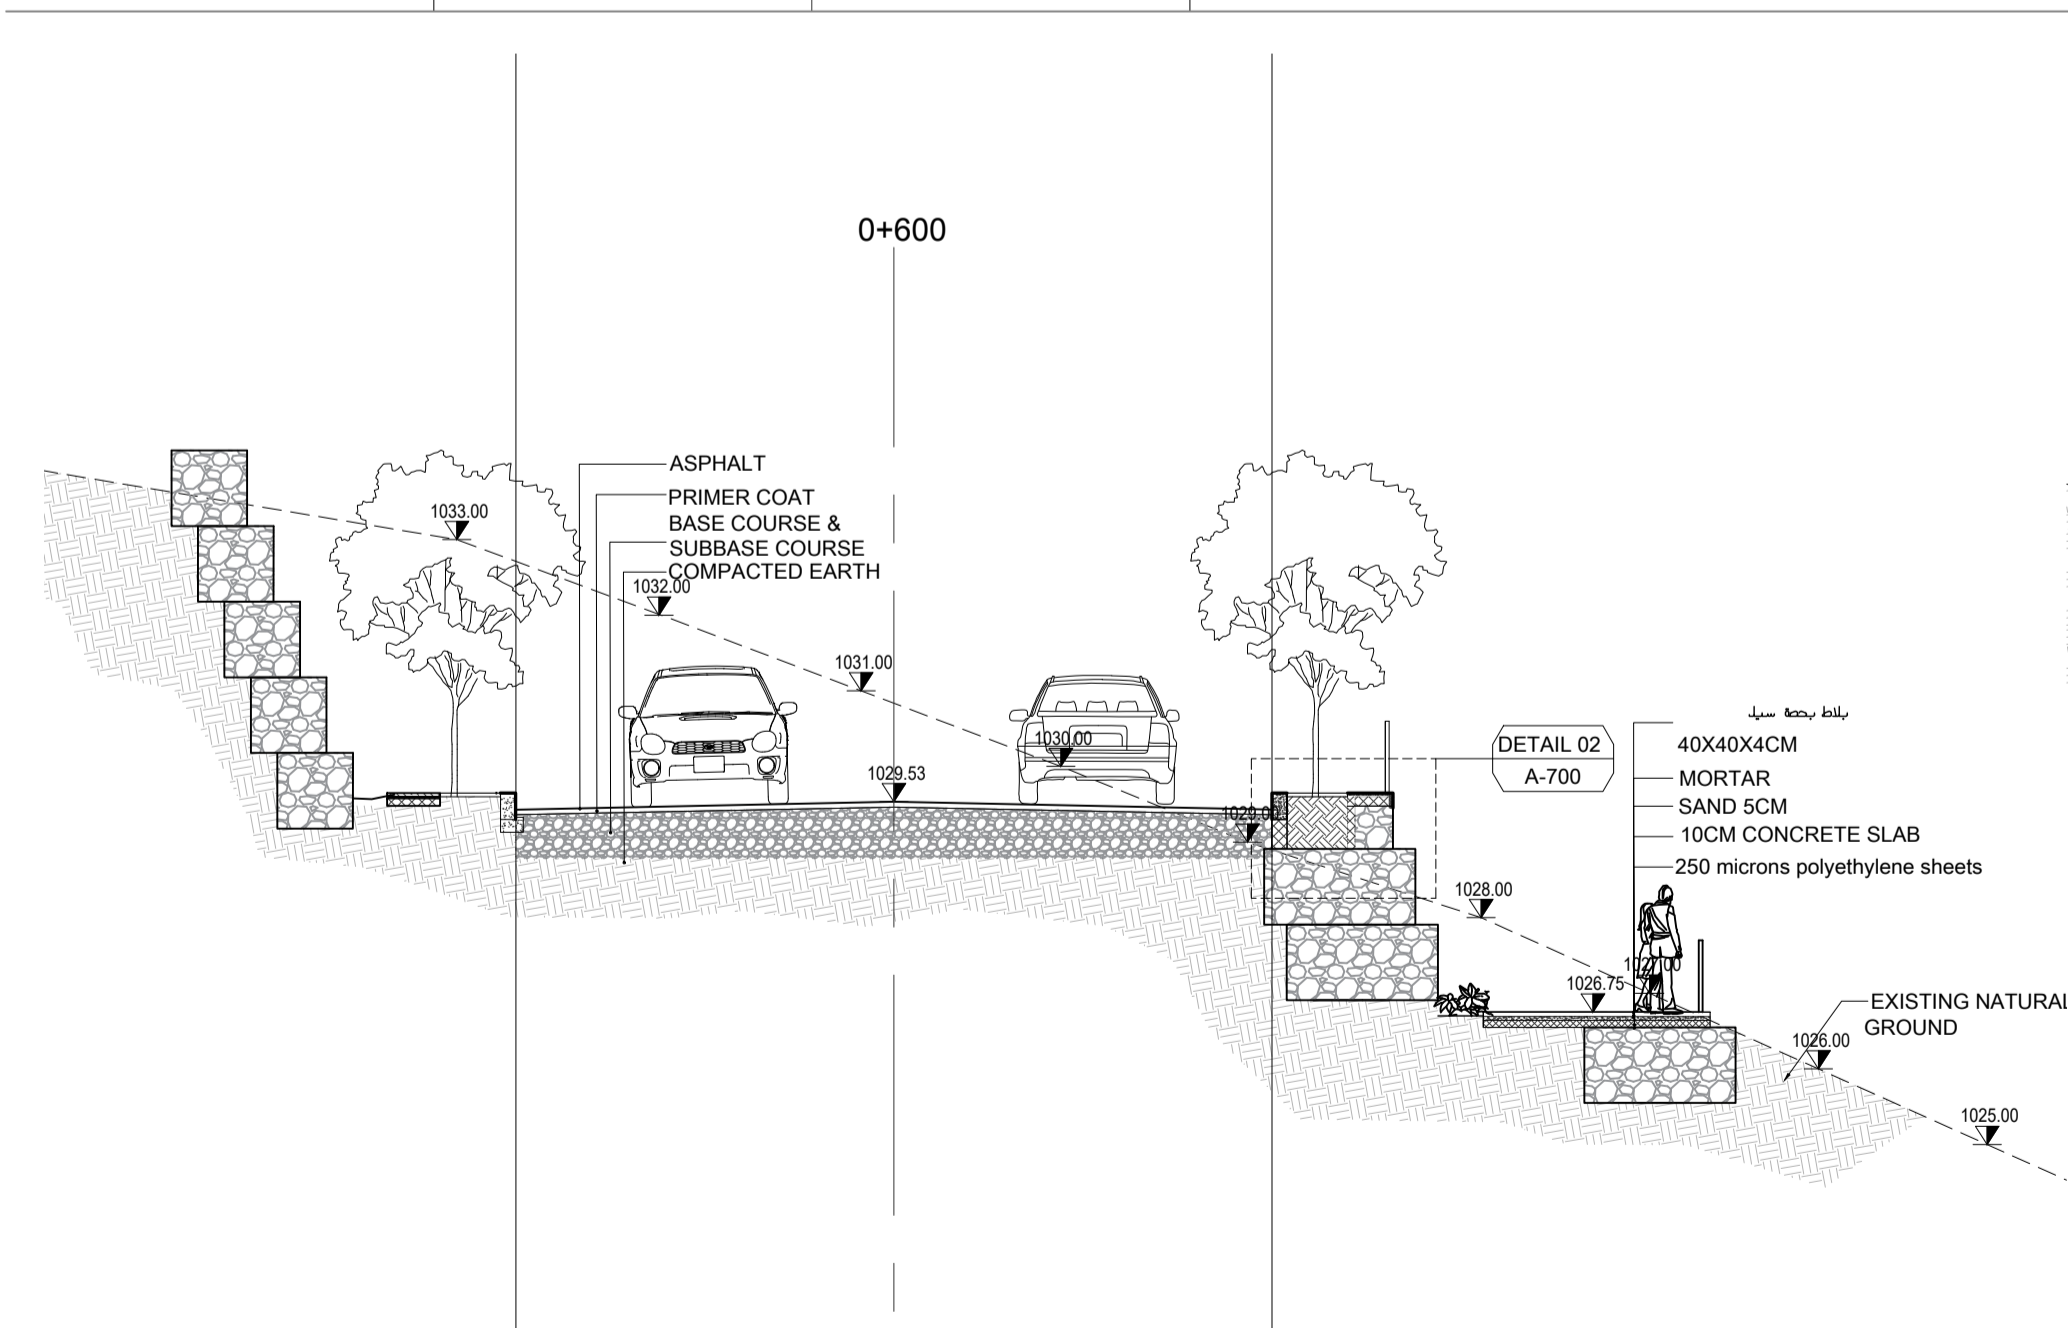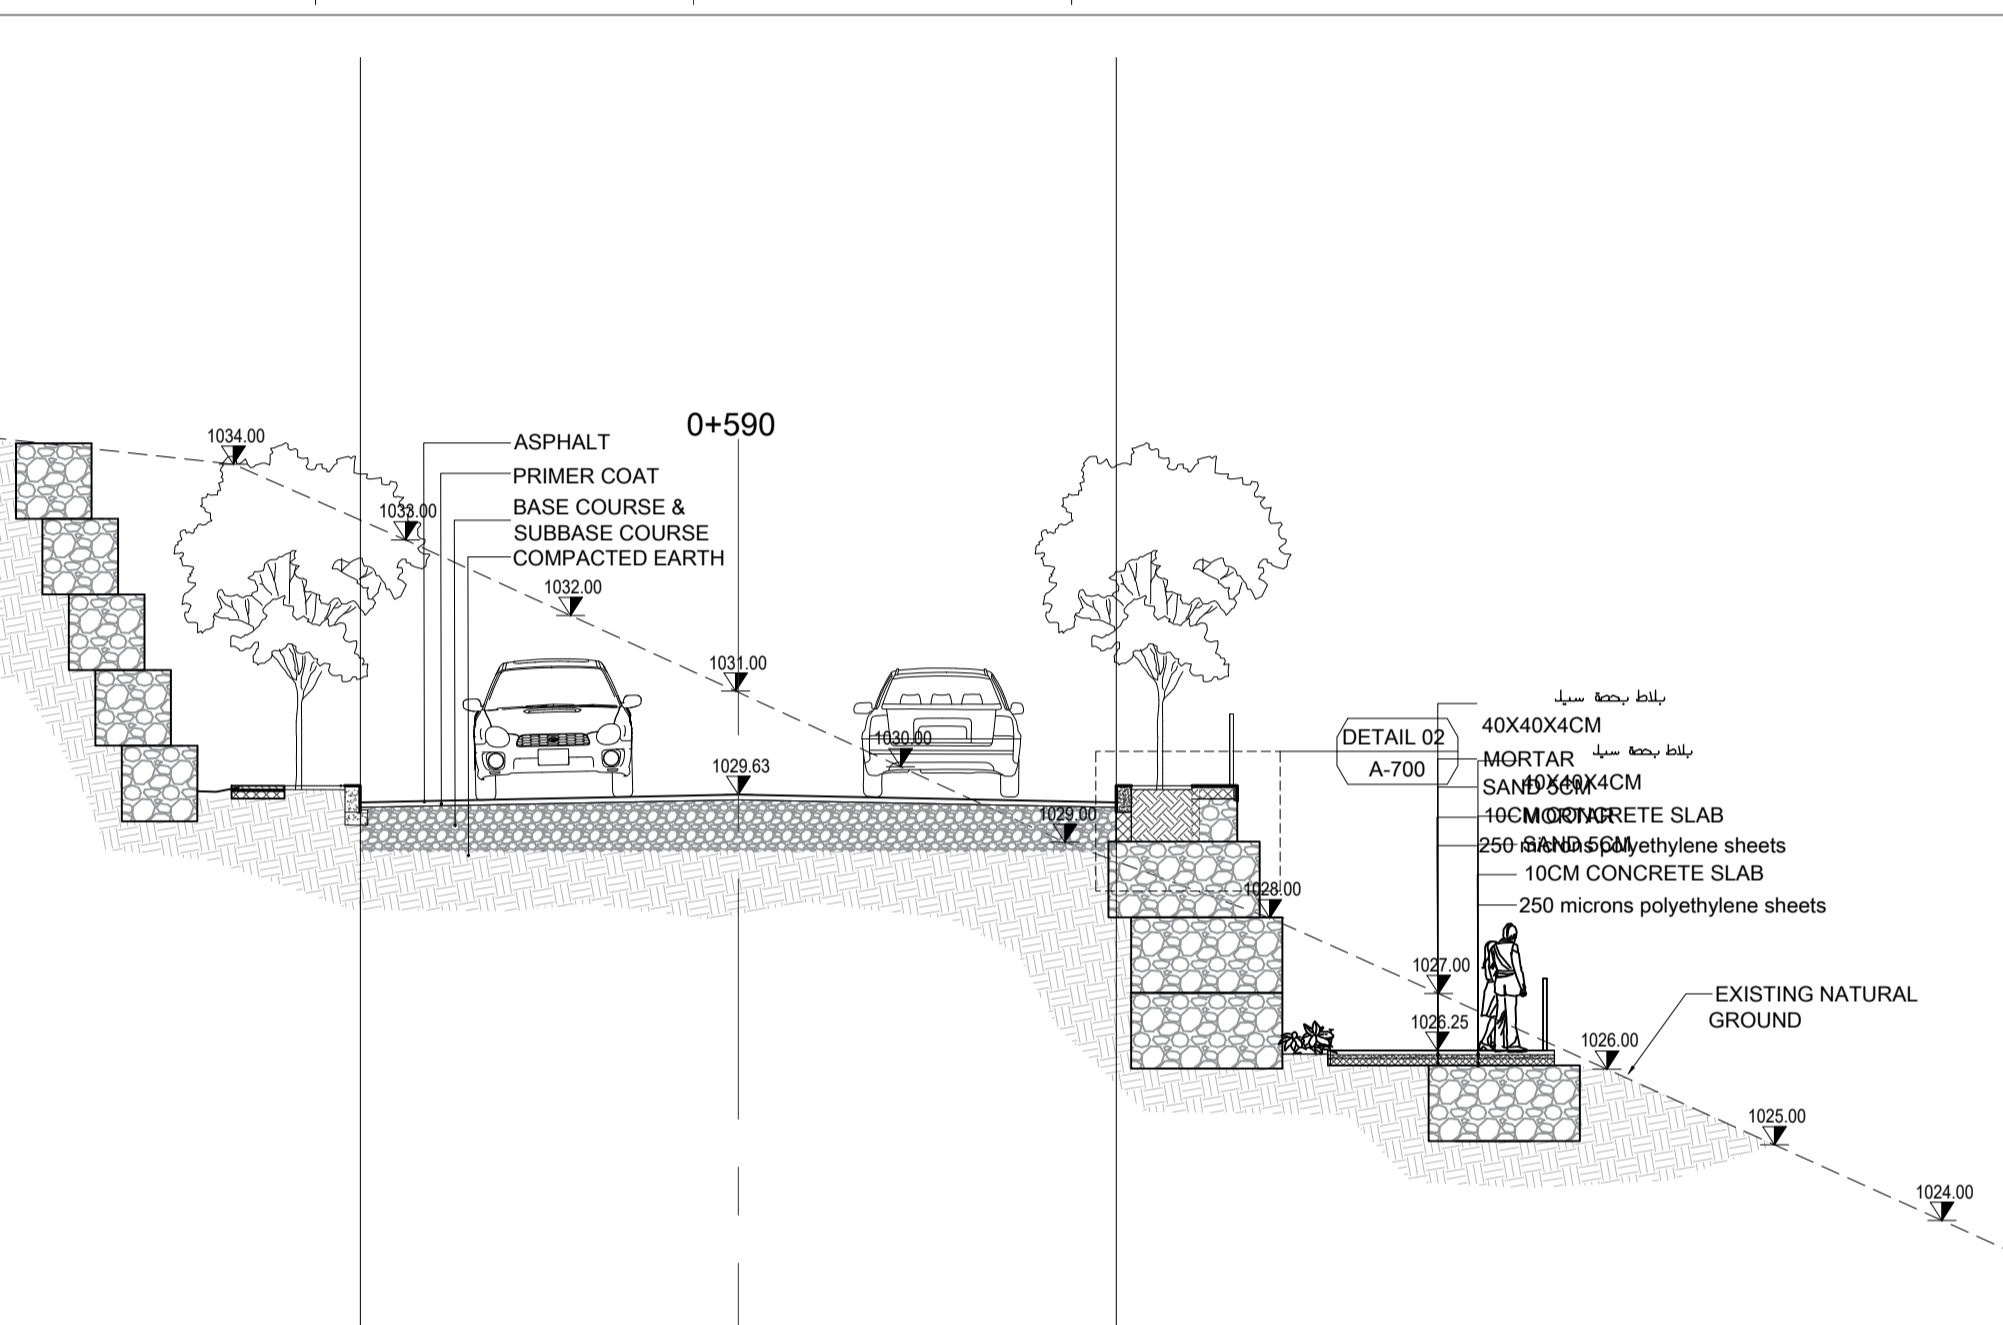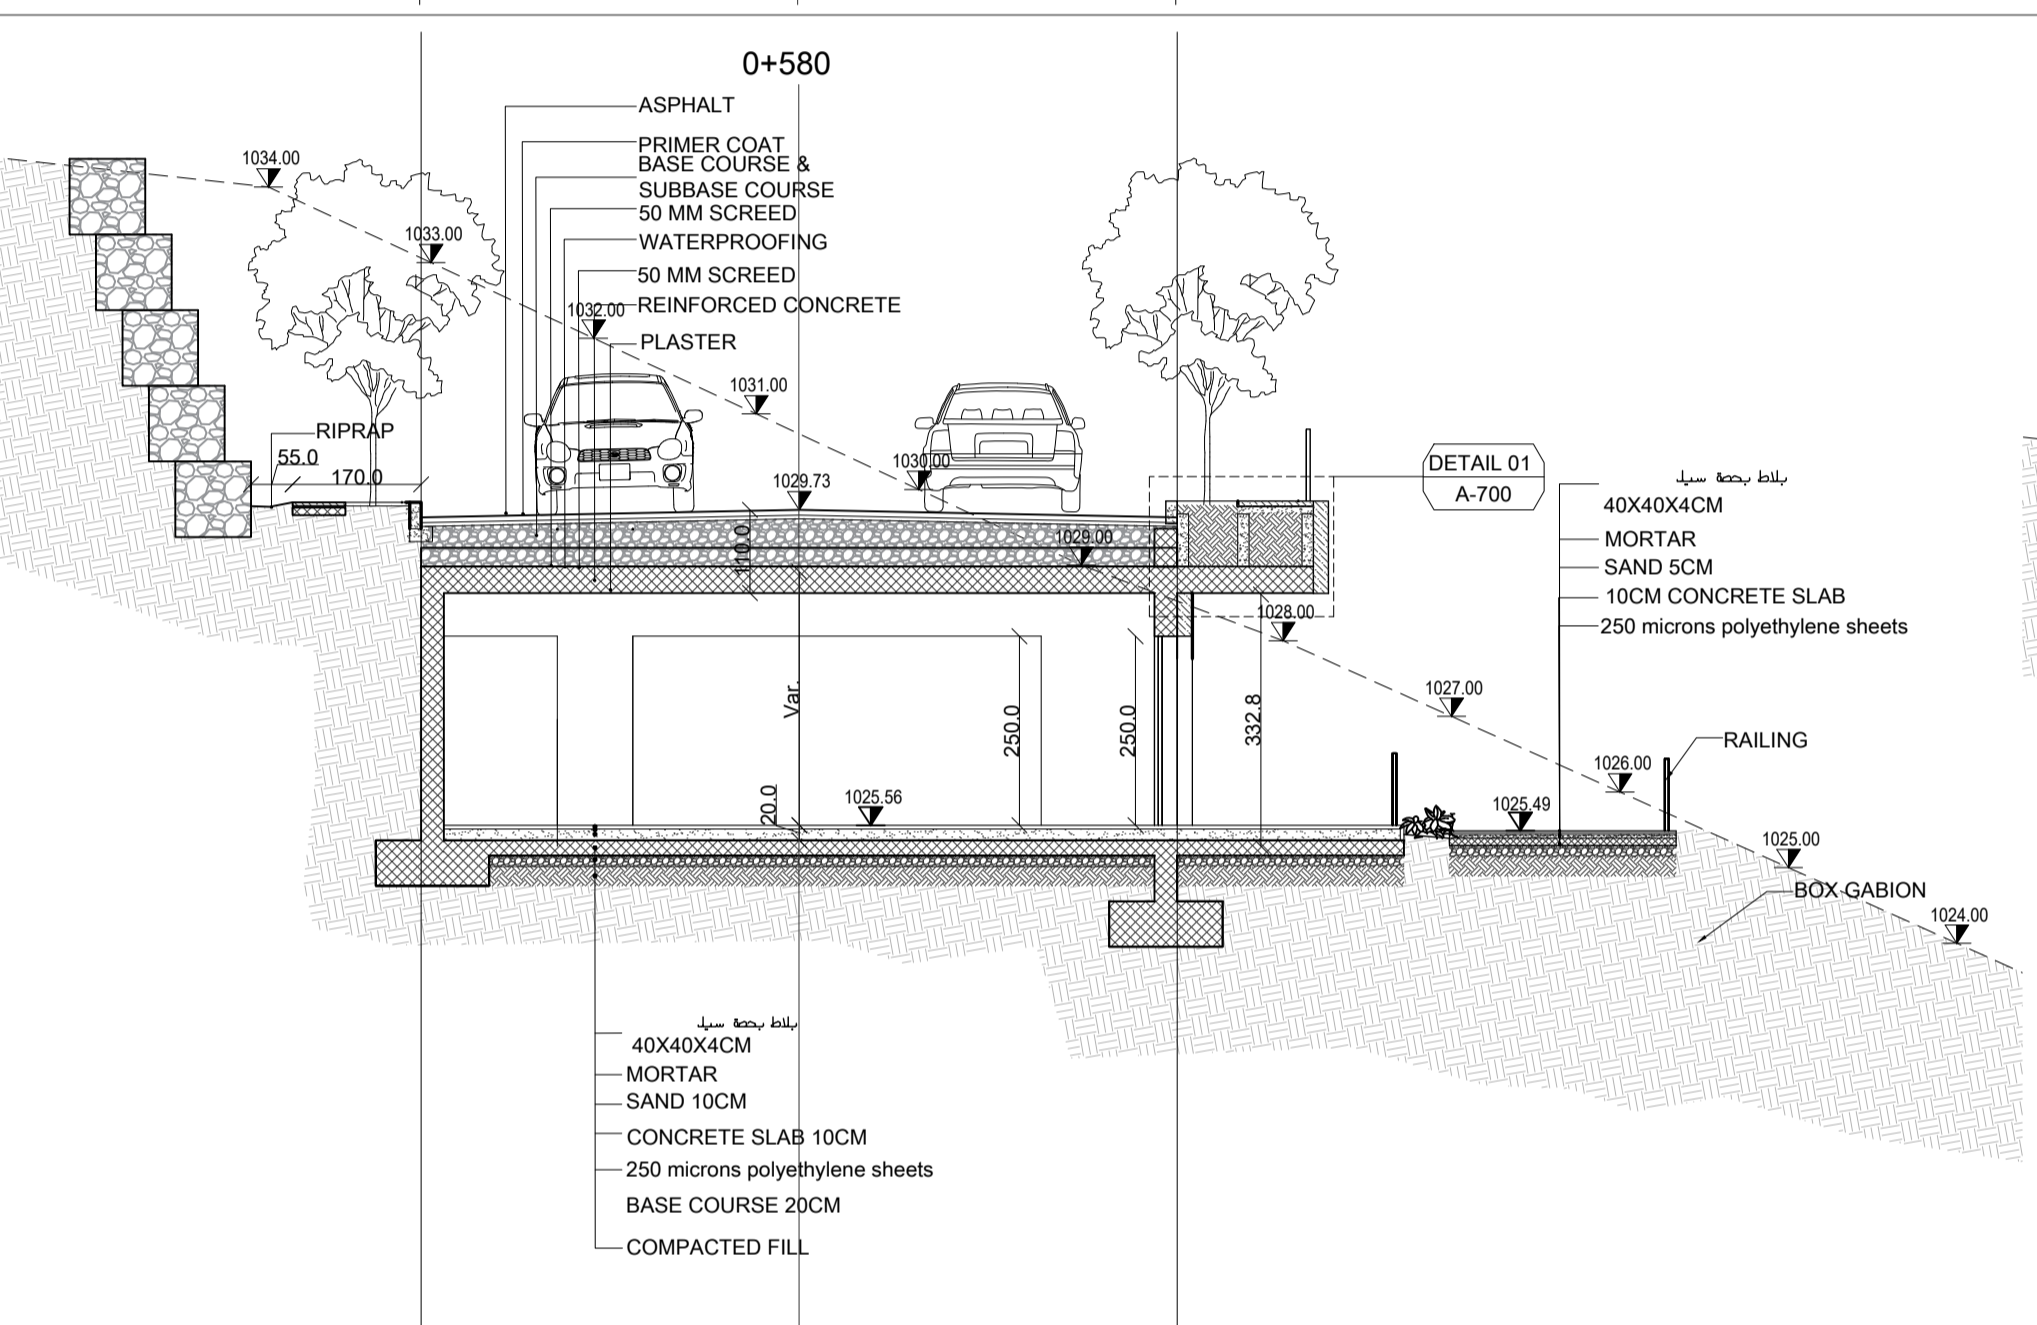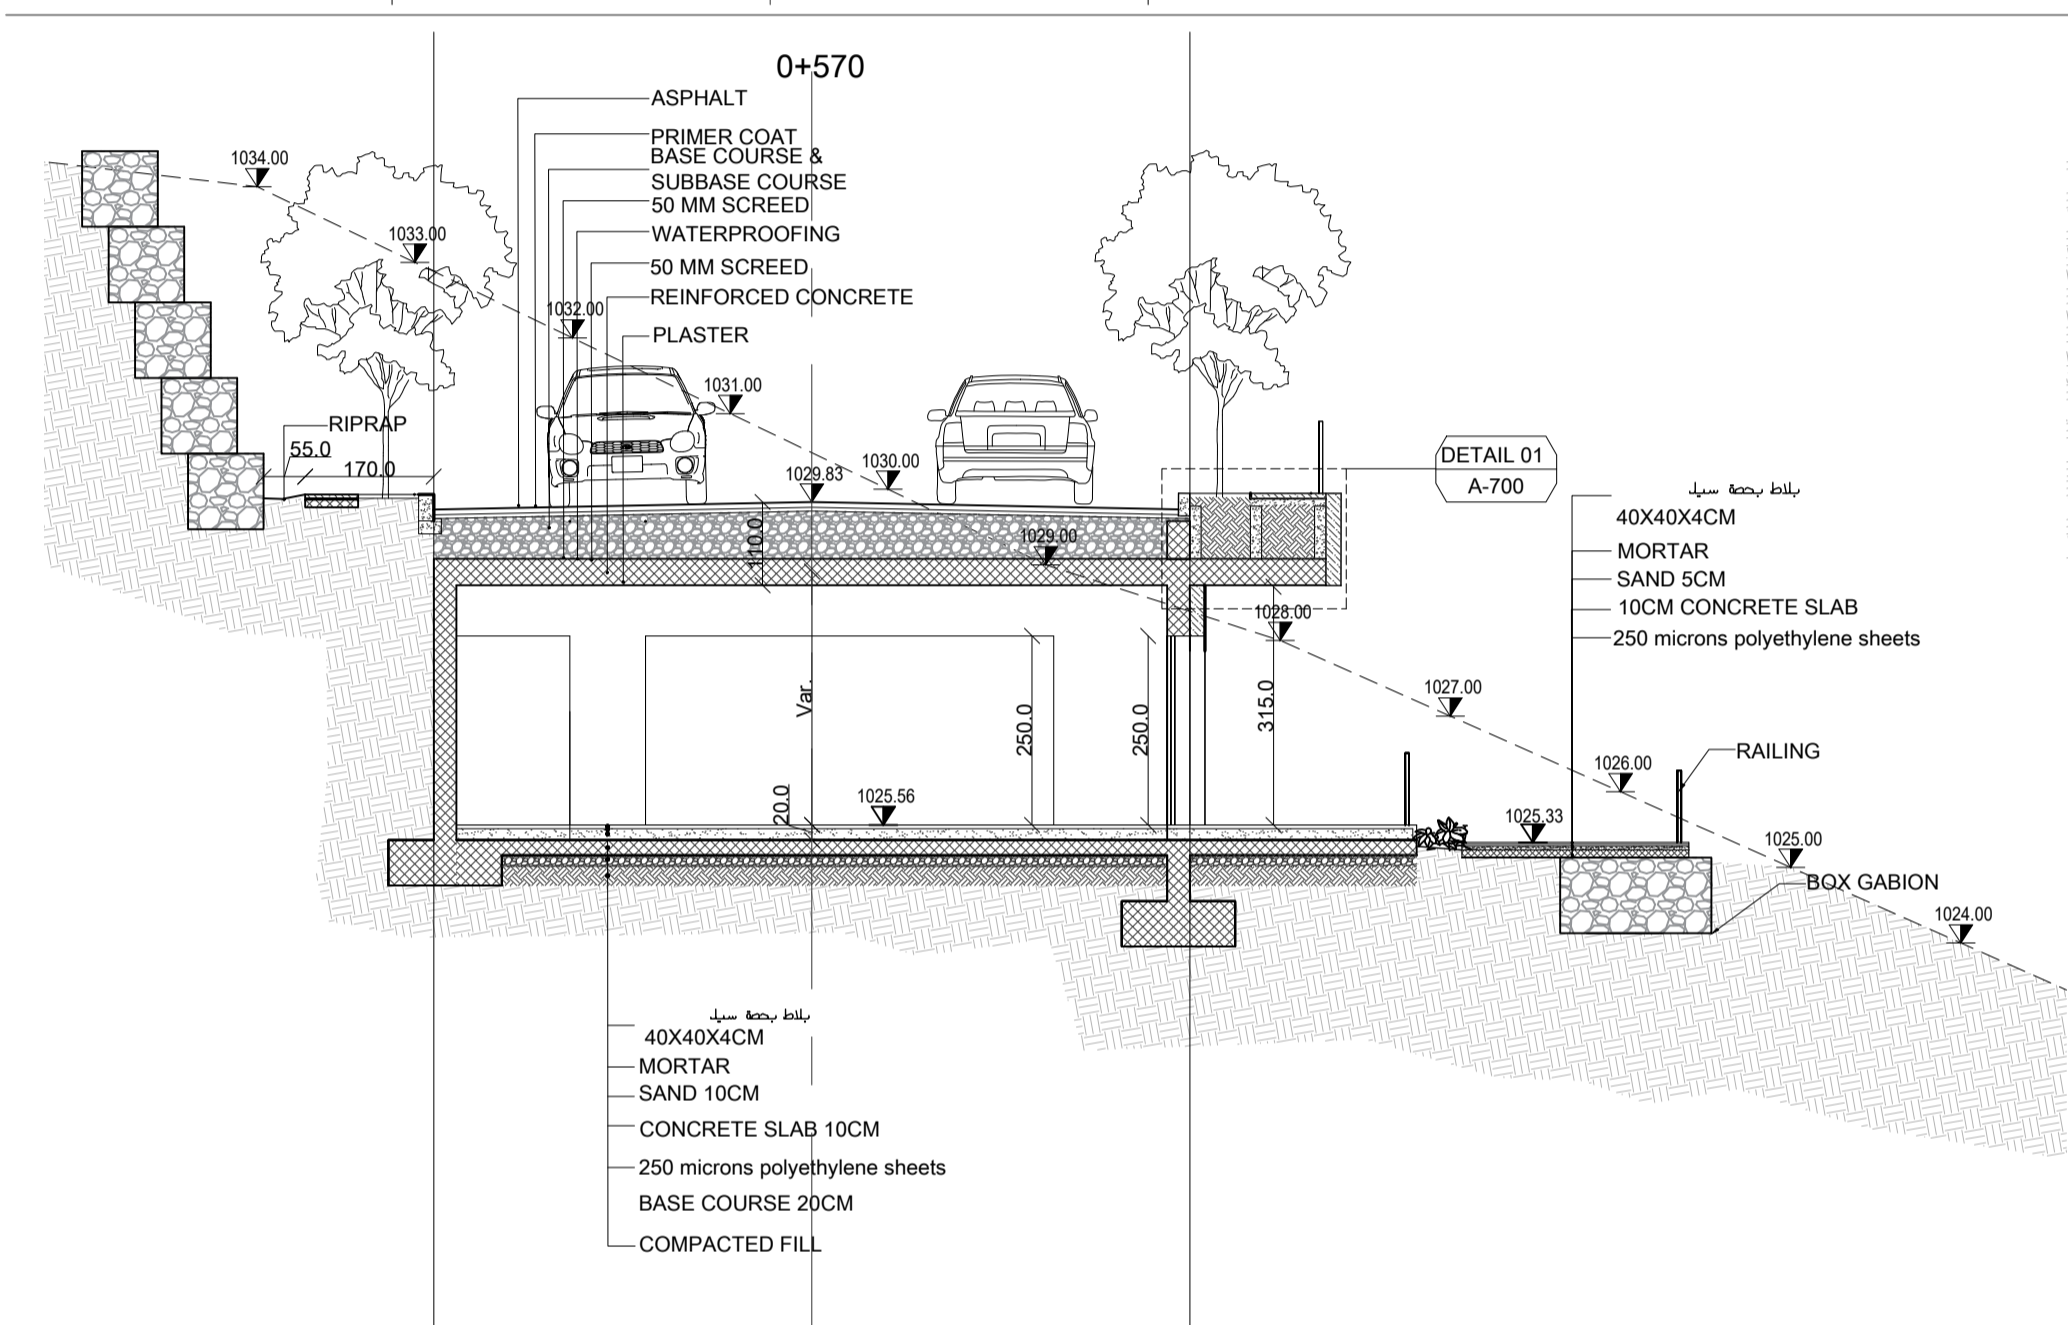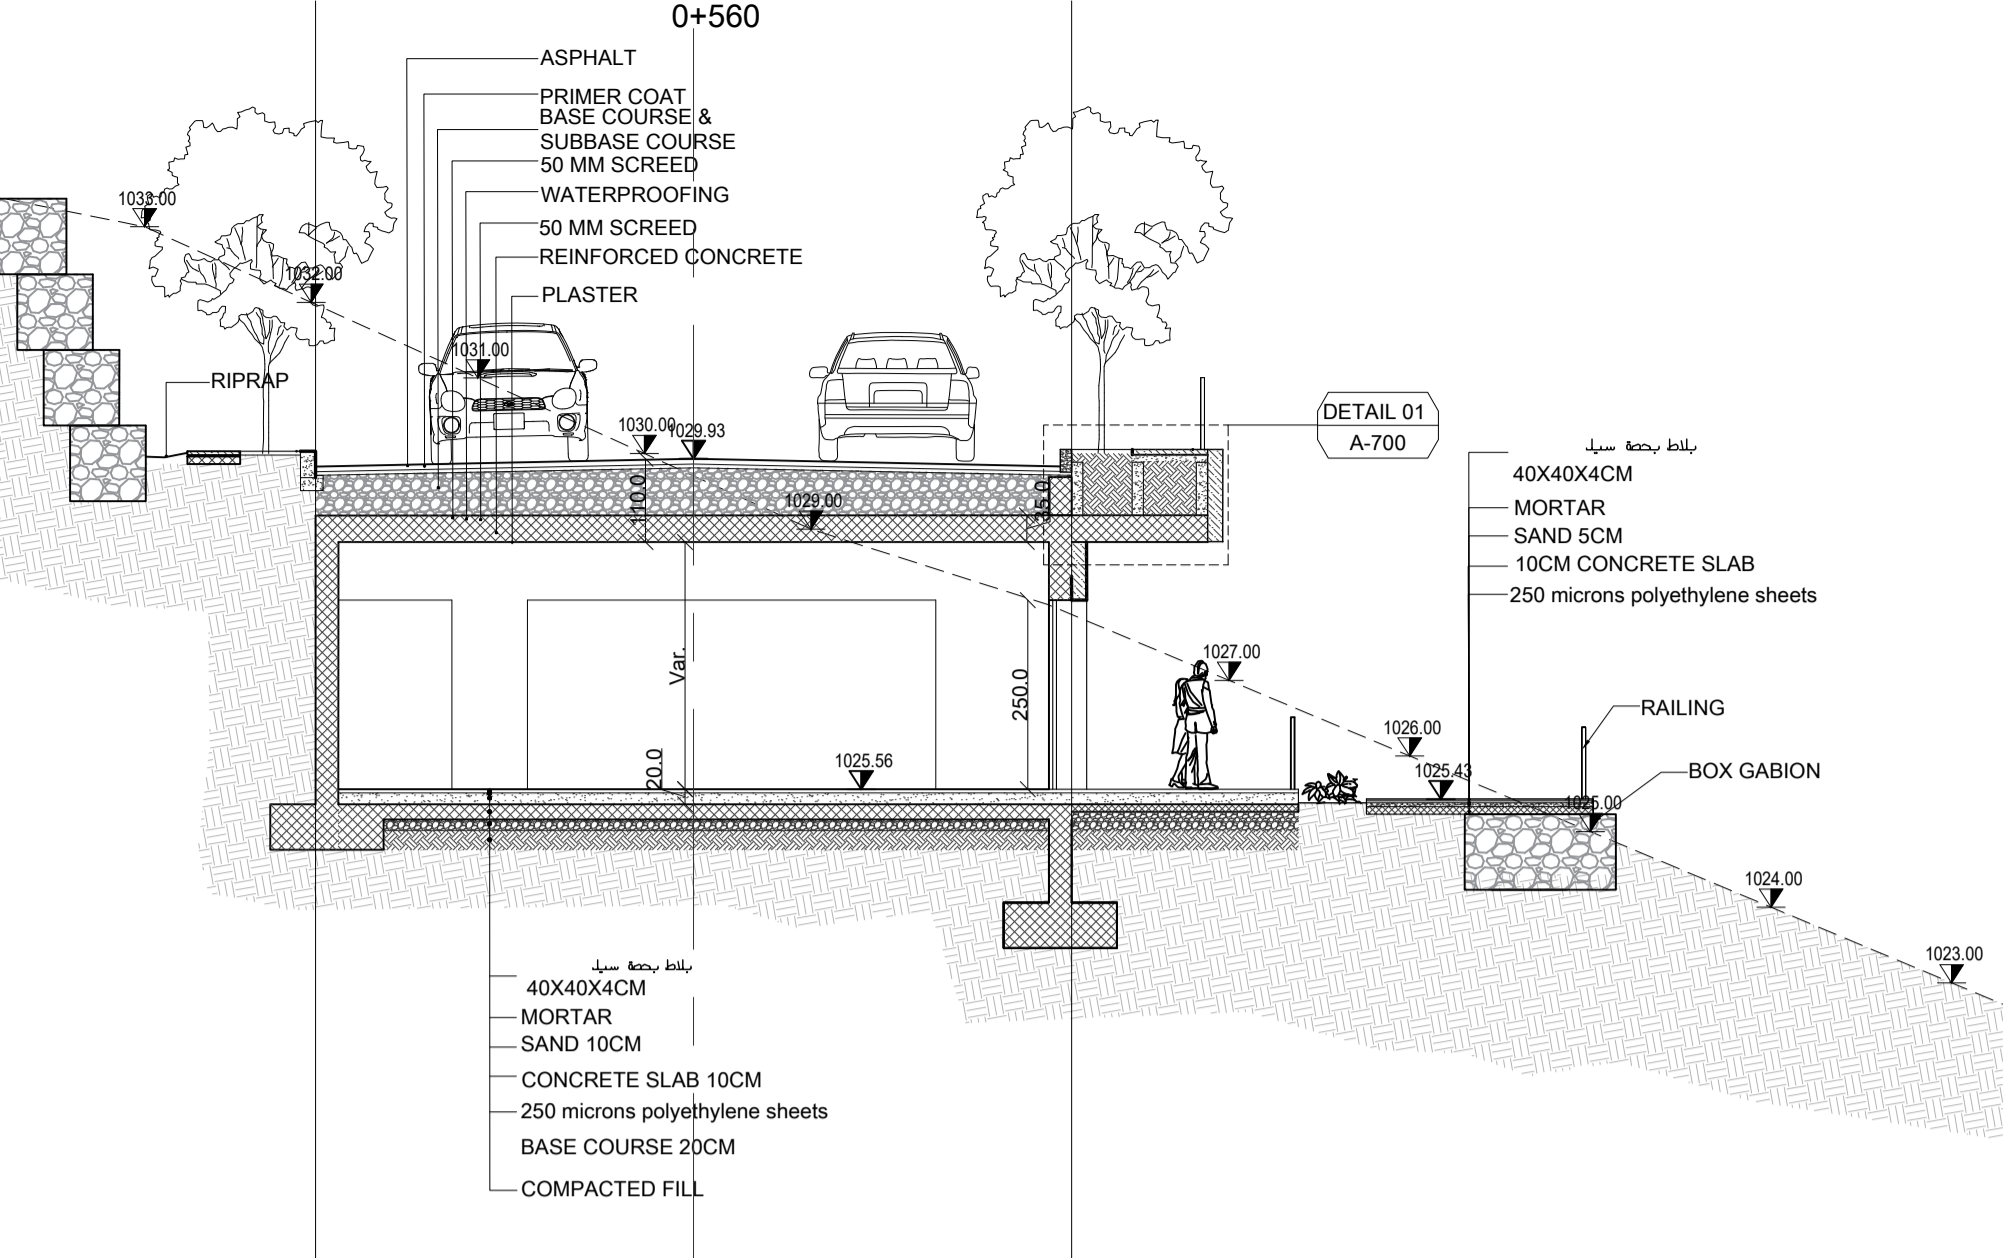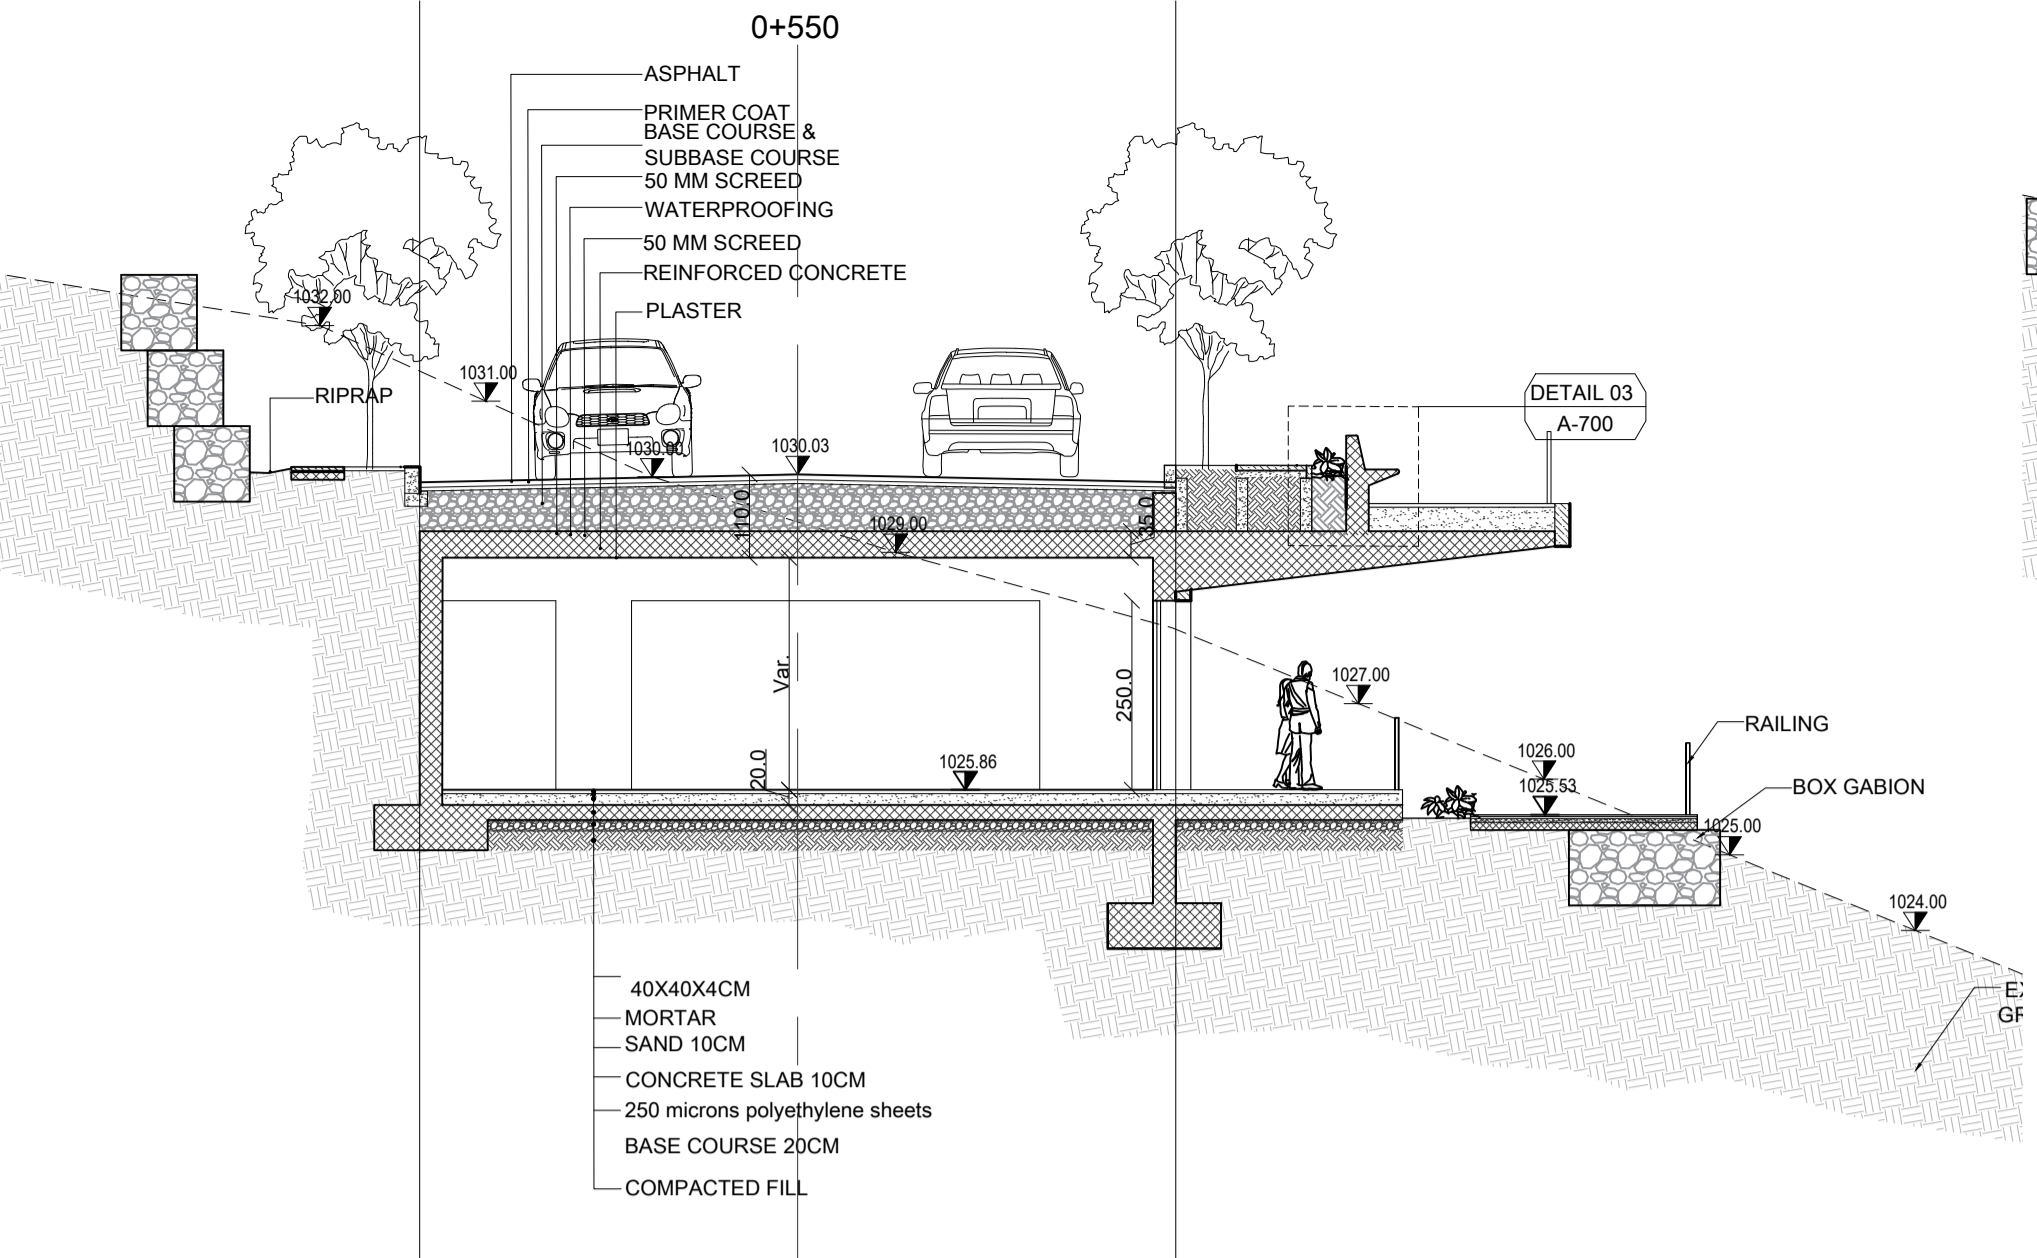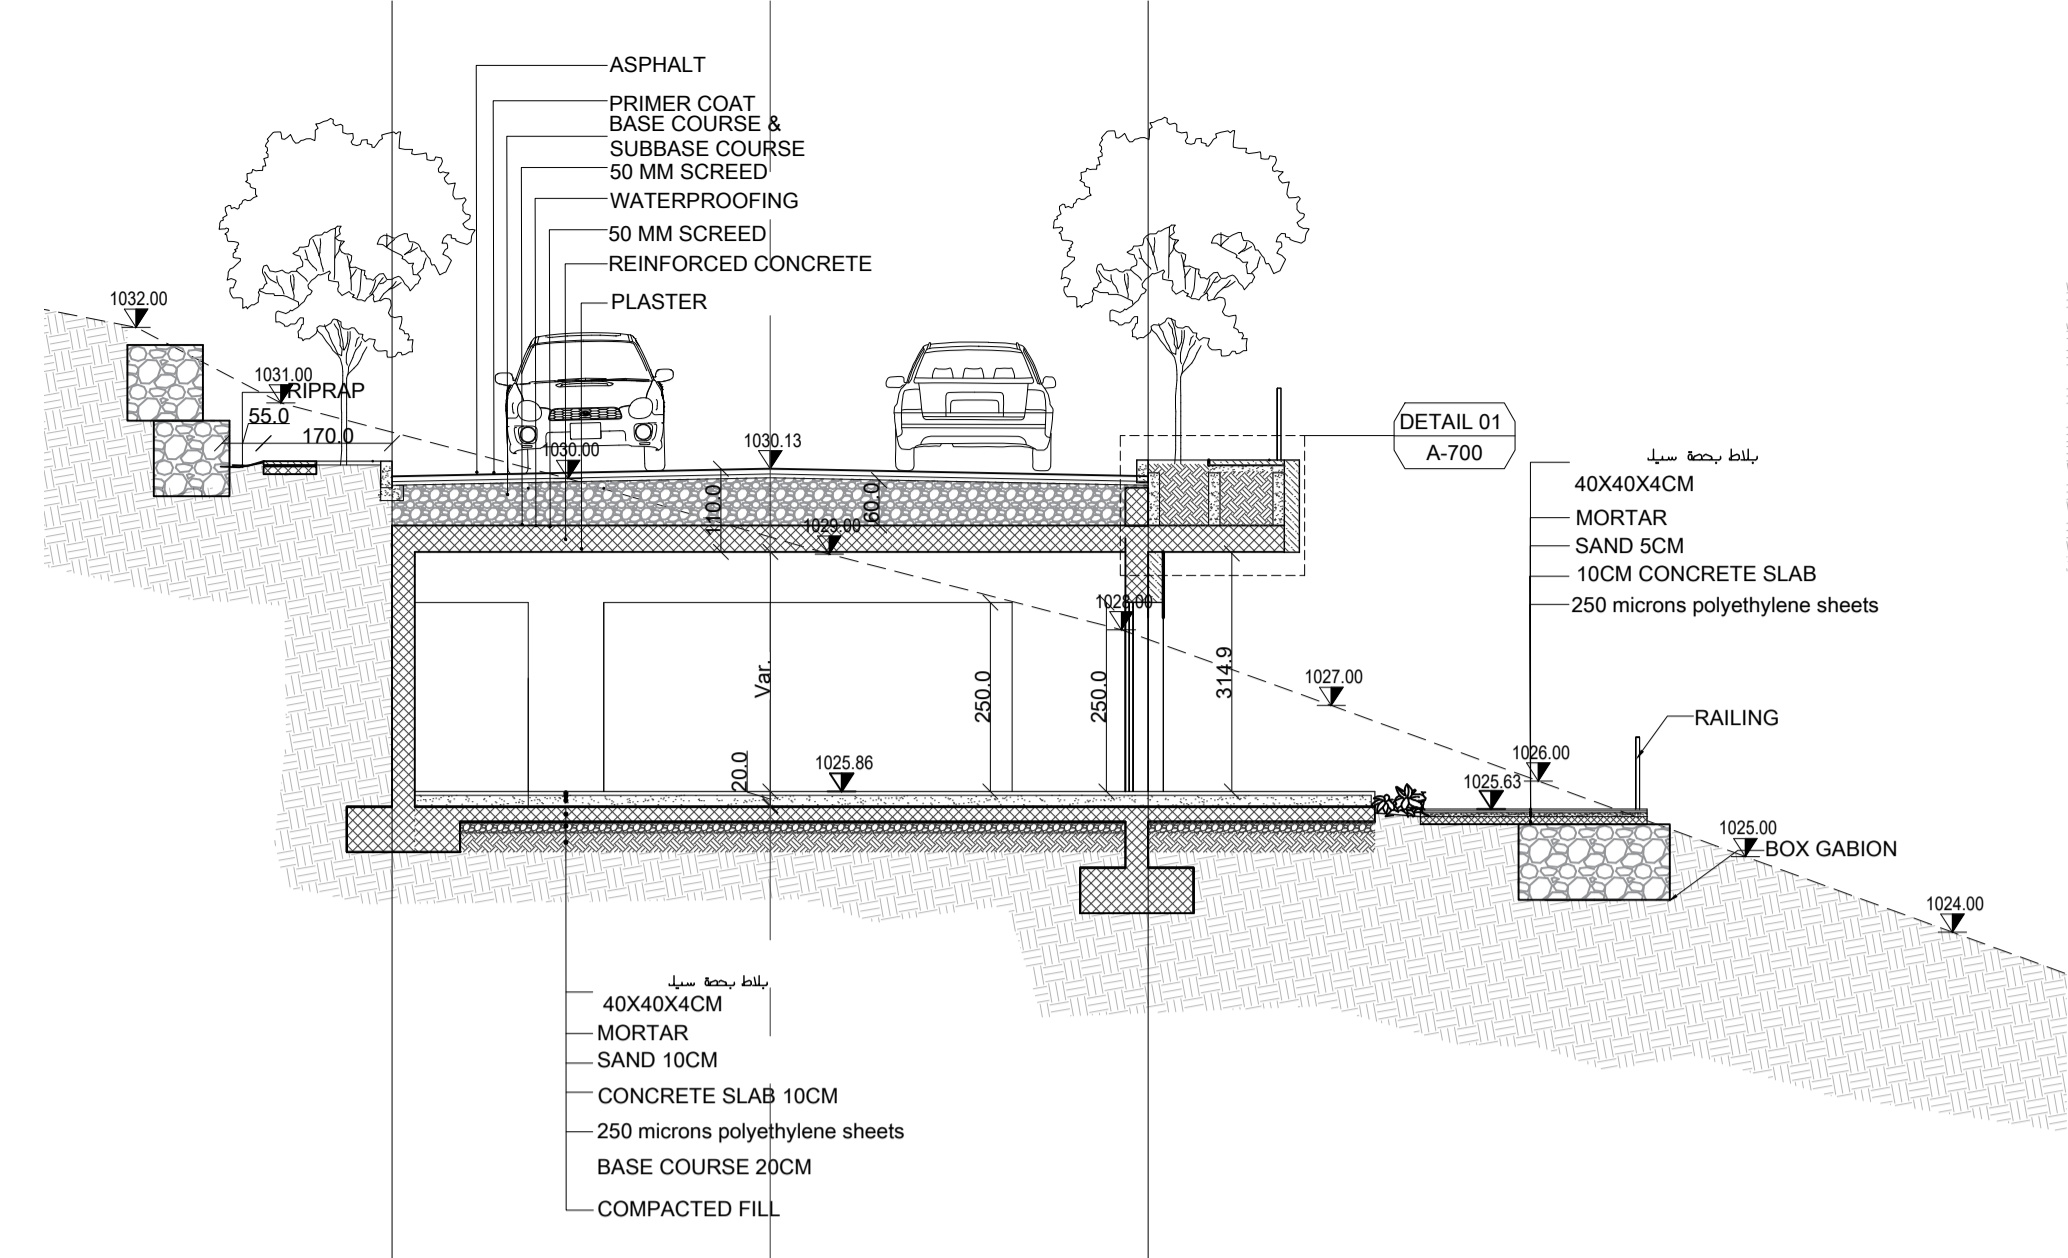

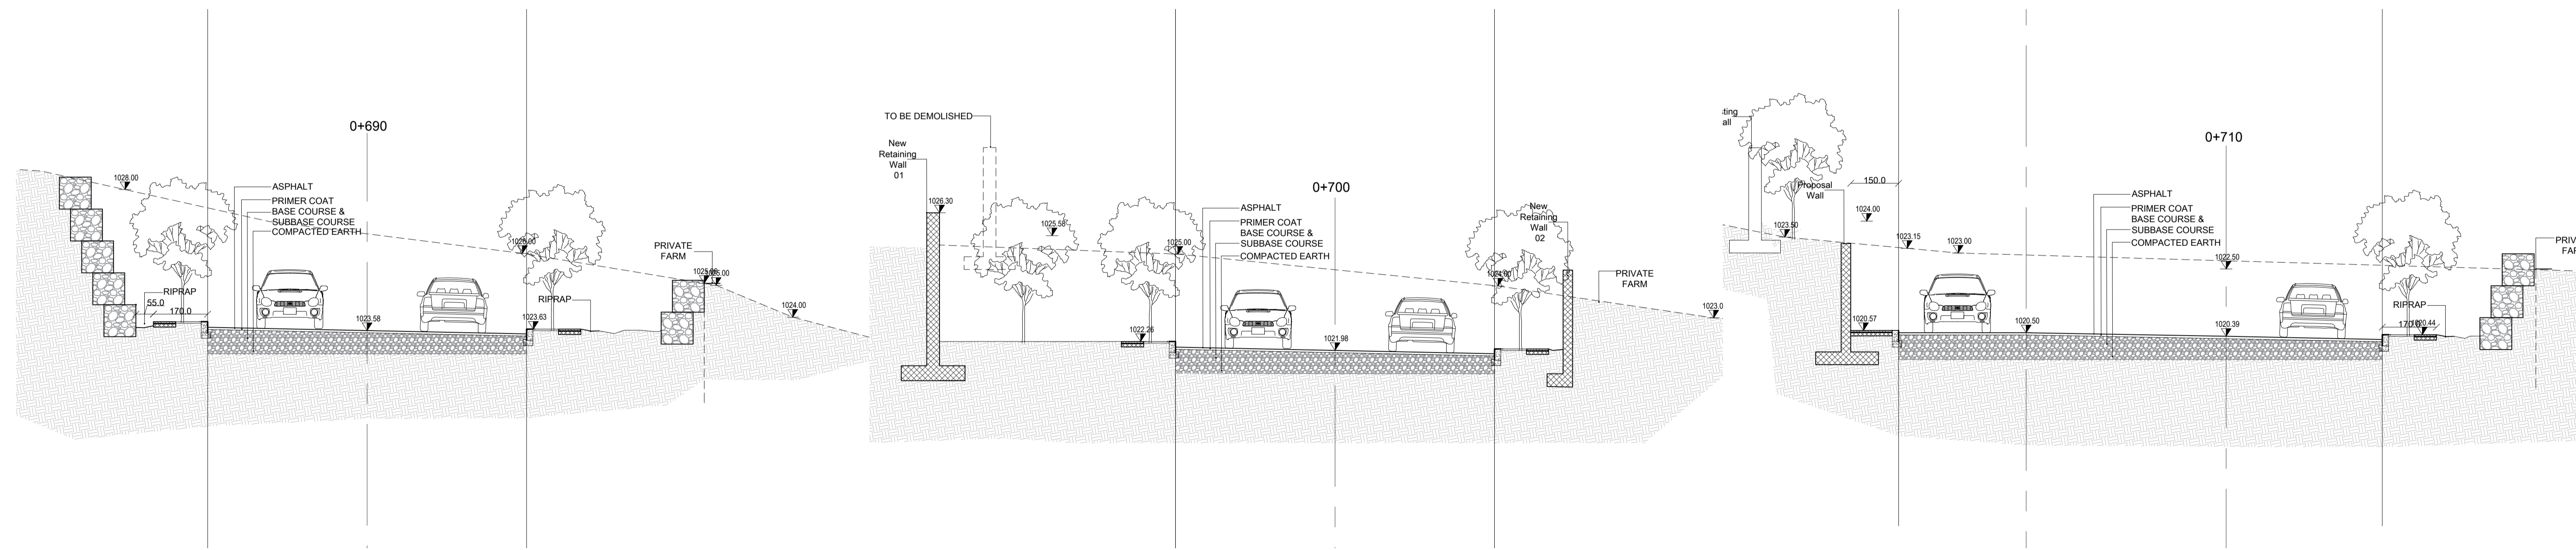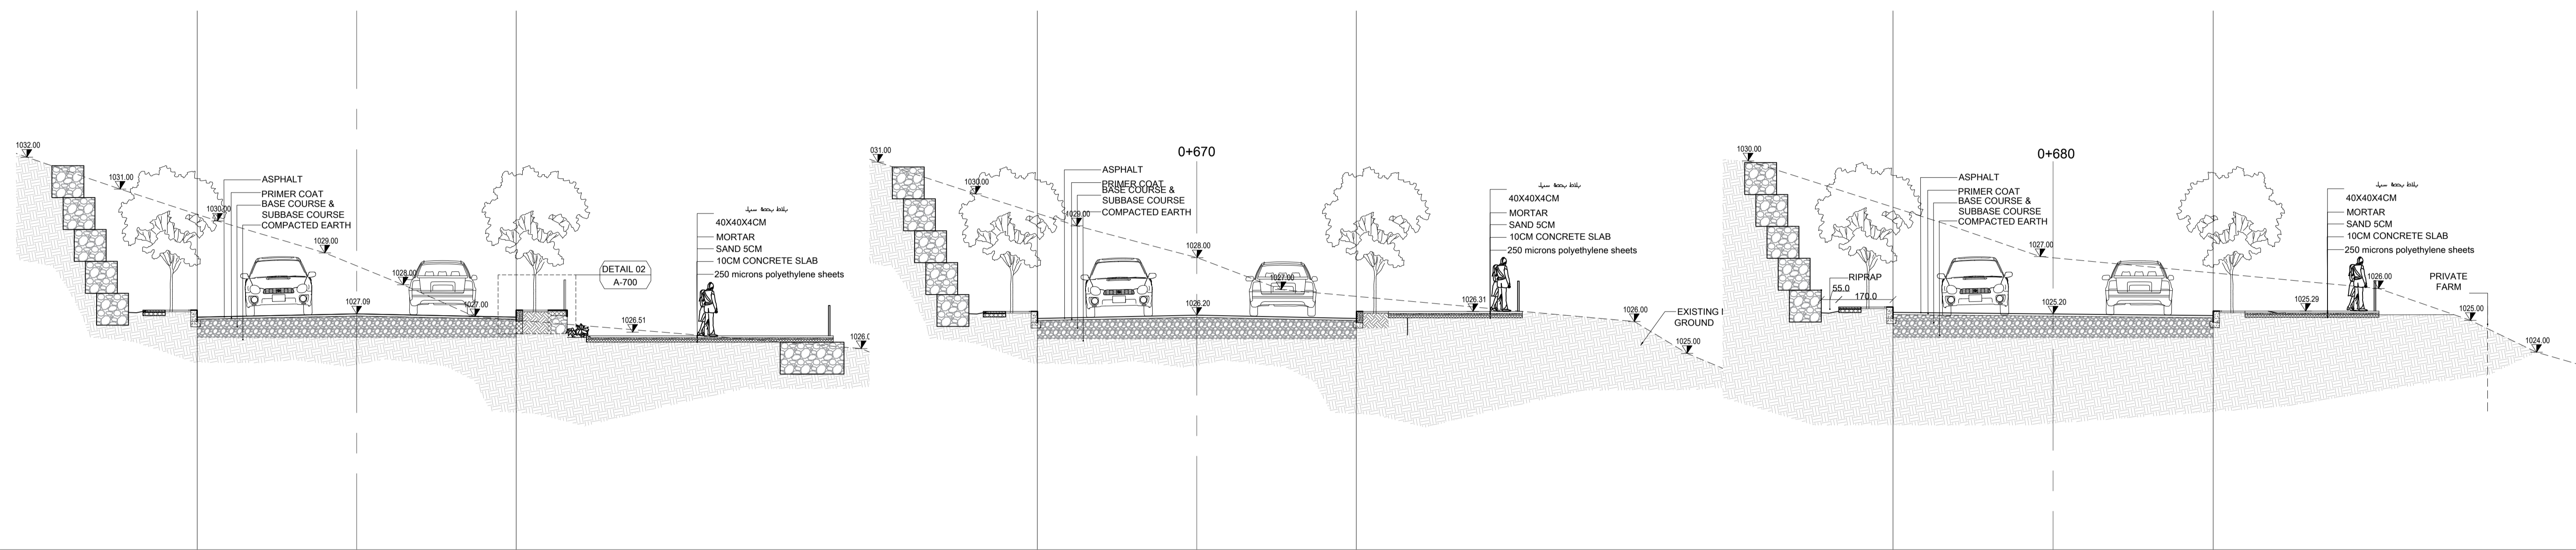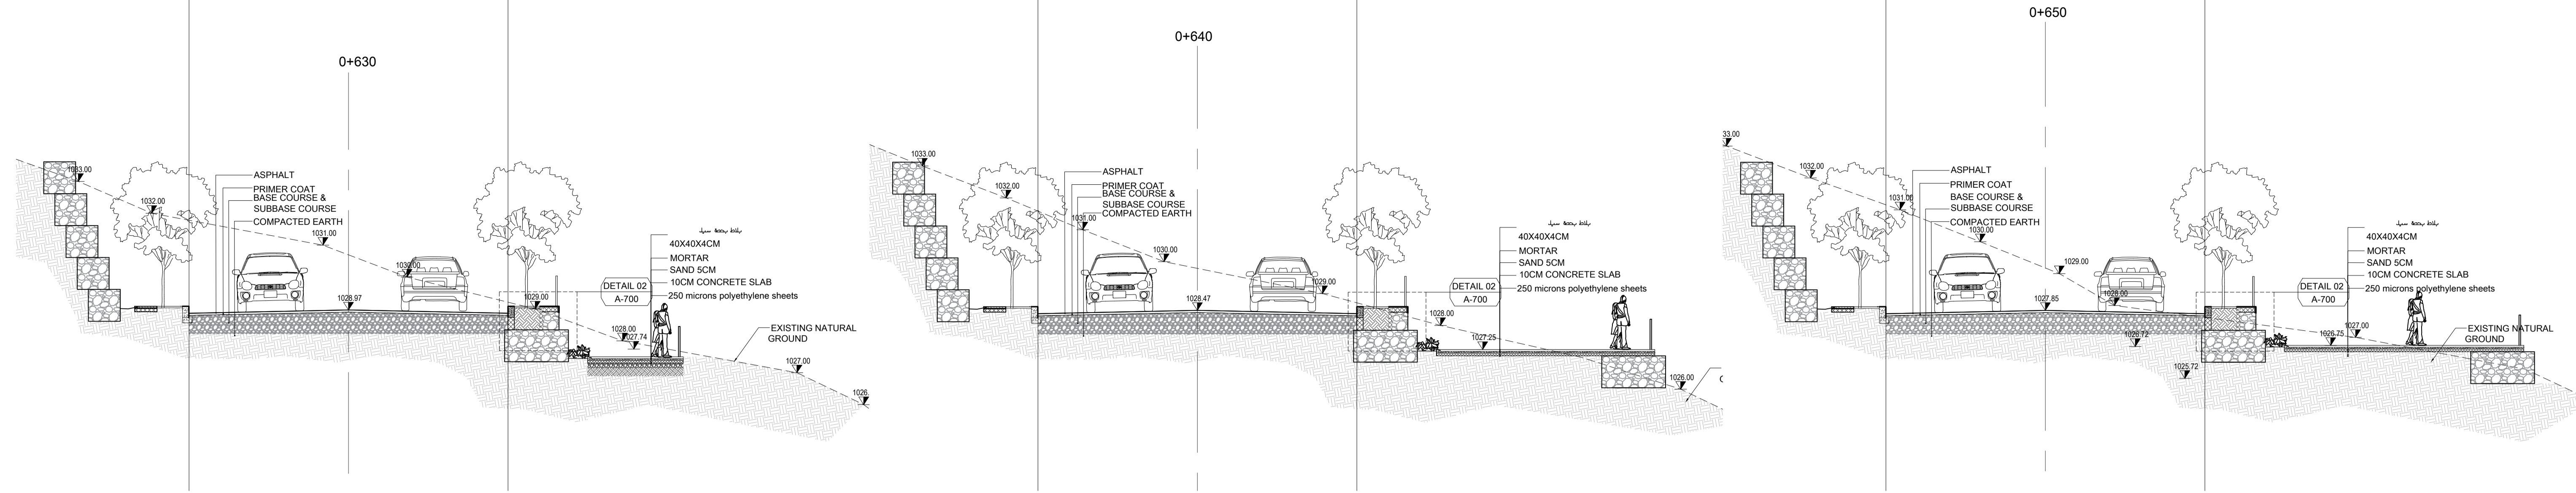

KHAMMASH ARCHITECTS

P.O. Box 921474, Amman - 11192, Jordan | Tel: +962 6 5669134, Fax: +962 6 5622386
E-mail: khammash.com

CLIENT

Petra Development & Tourism Region Authority

P.O. Box 7693, Amman 11118, Jordan | T: +962 6 5055551 | F: +962 6 4550639 | W: www.hrbf.com

PROJECT

Road 4

ADDRESS

Wadi Musa, JORDAN

STATUS

TENDER

Copyright © Khammash Architects

THIS DRAWING IS AND AT ALL TIMES REMAINS THE EXCLUSIVE PROPERTY OF KHAMMASH ARCHITECTS. ALL MEASUREMENTS MUST BE CHECKED BY THE CONTRACTOR ON SITE BEFORE THE COMMENCEMENT OF ANY WORKS.

NOTES

DRAWN

CHECKED

APPROVED

AK

NORTH

SCALE

1:100@A1

AK

DRAWING TITLE

SECTIONS (0 +630.0 +710)

SHEET NUMBER




A-ZA-302

ISSUE | DATE

— Mar. 2022

ISSUE | DATE | AMENDMENT

CHECKED

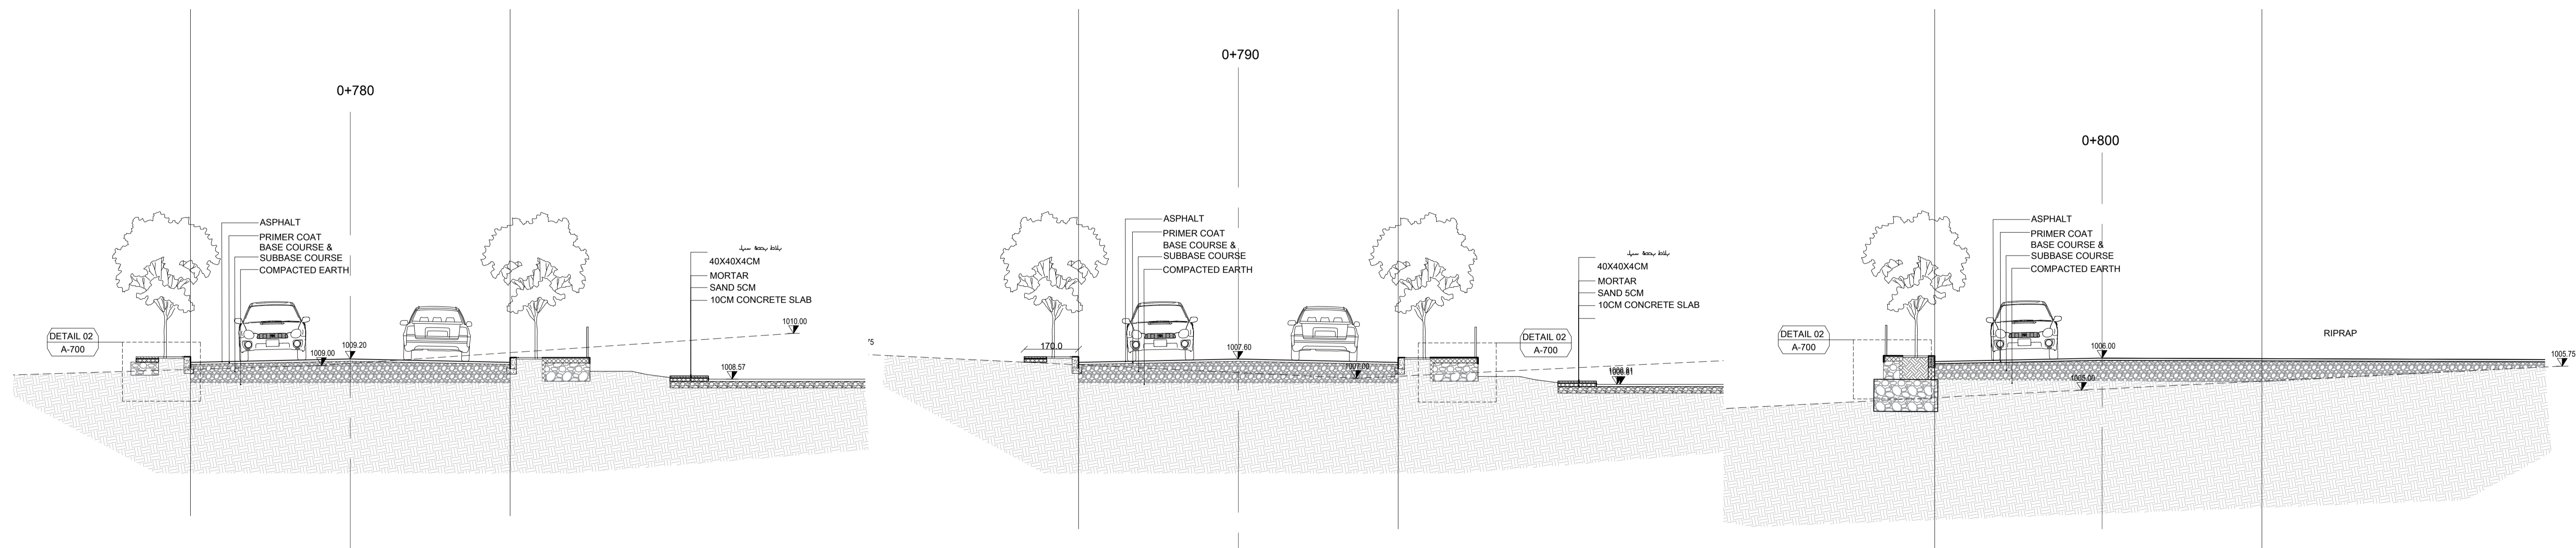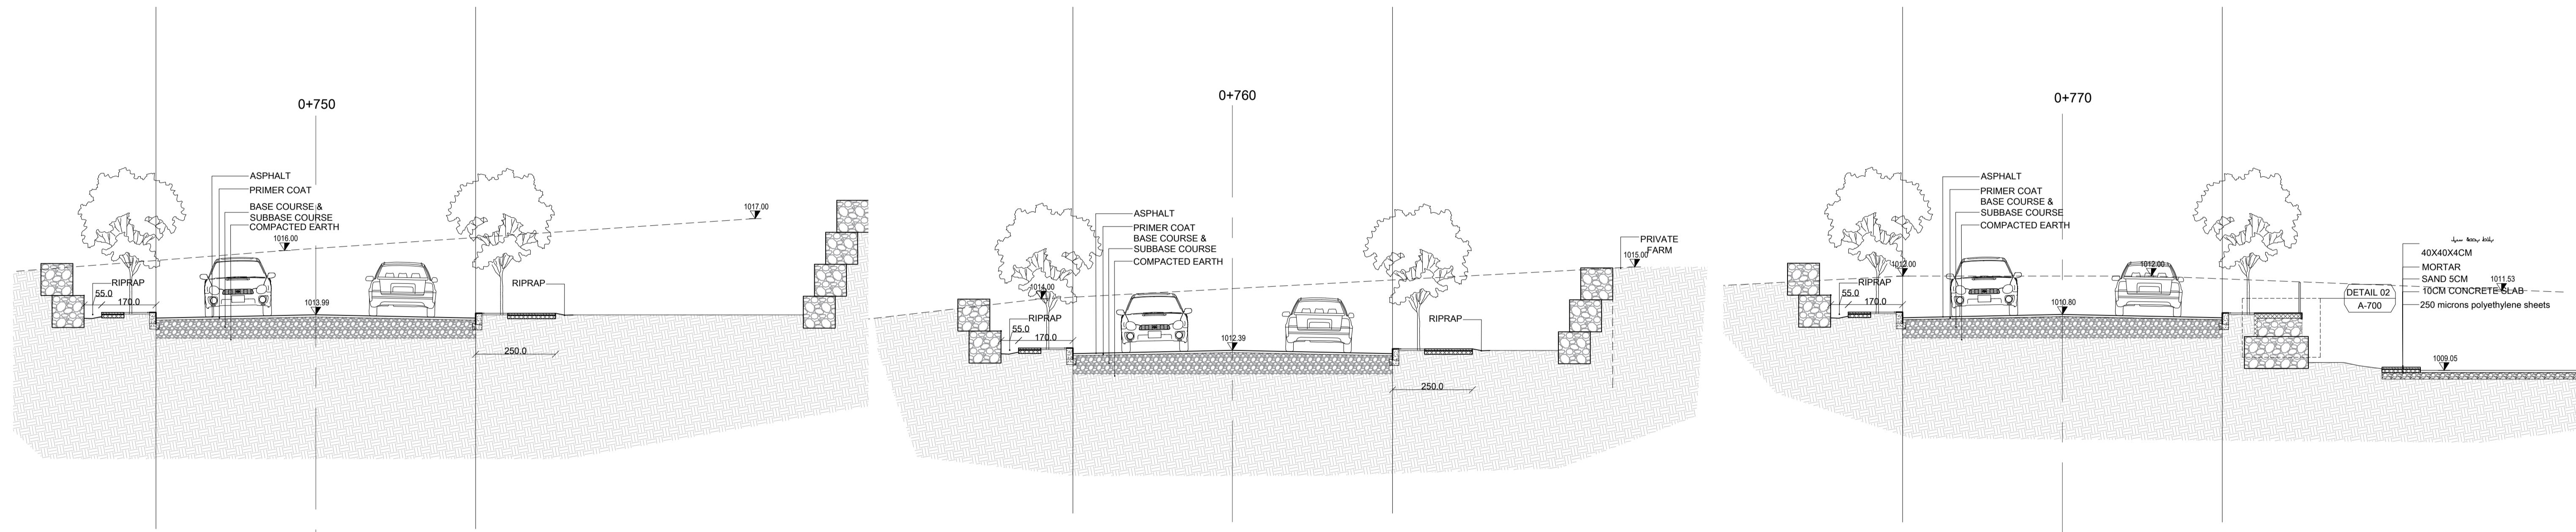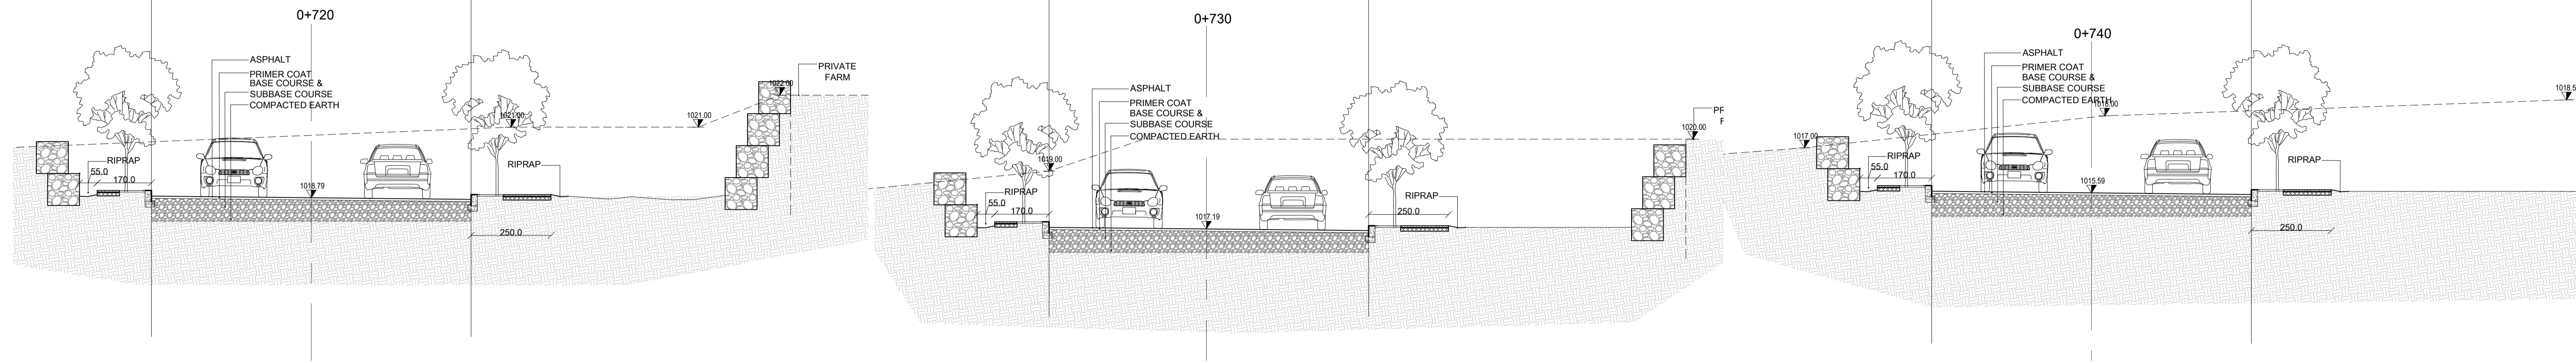

KHAMMASH ARCHITECTS

P.O. Box 921474, Amman - 11192, Jordan | T +962 6 5669134, Fax +962 6 5622386
E-mail: khammash@khammash.com

CLIENT

Petra Development & Tourism Region Authority

PROJECT

Road 4

ADDRESS

Wadi Musa, JORDAN

STATUS

TENDER

Copyright © Khammash Architects.

THIS DRAWING IS AND AT ALL TIMES REMAINS THE EXCLUSIVE PROPERTY OF KHAMMASH ARCHITECTS. ALL MEASUREMENTS MUST BE CHECKED BY THE CONTRACTOR ON SITE BEFORE THE COMMENCEMENT OF ANY WORKS.

NOTES

DRAWN

CHECKED

APPROVED

AK

NORTH

SCALE

1:100@A1

AK

DRAWING TITLE

SECTIONS (0 +720_0 +800)

SHEET NUMBER

A-ZA-303

ISSUE | DATE



—

—


Mar. 2022

ISSUE | DATE | AMENDMENT


CHECKED

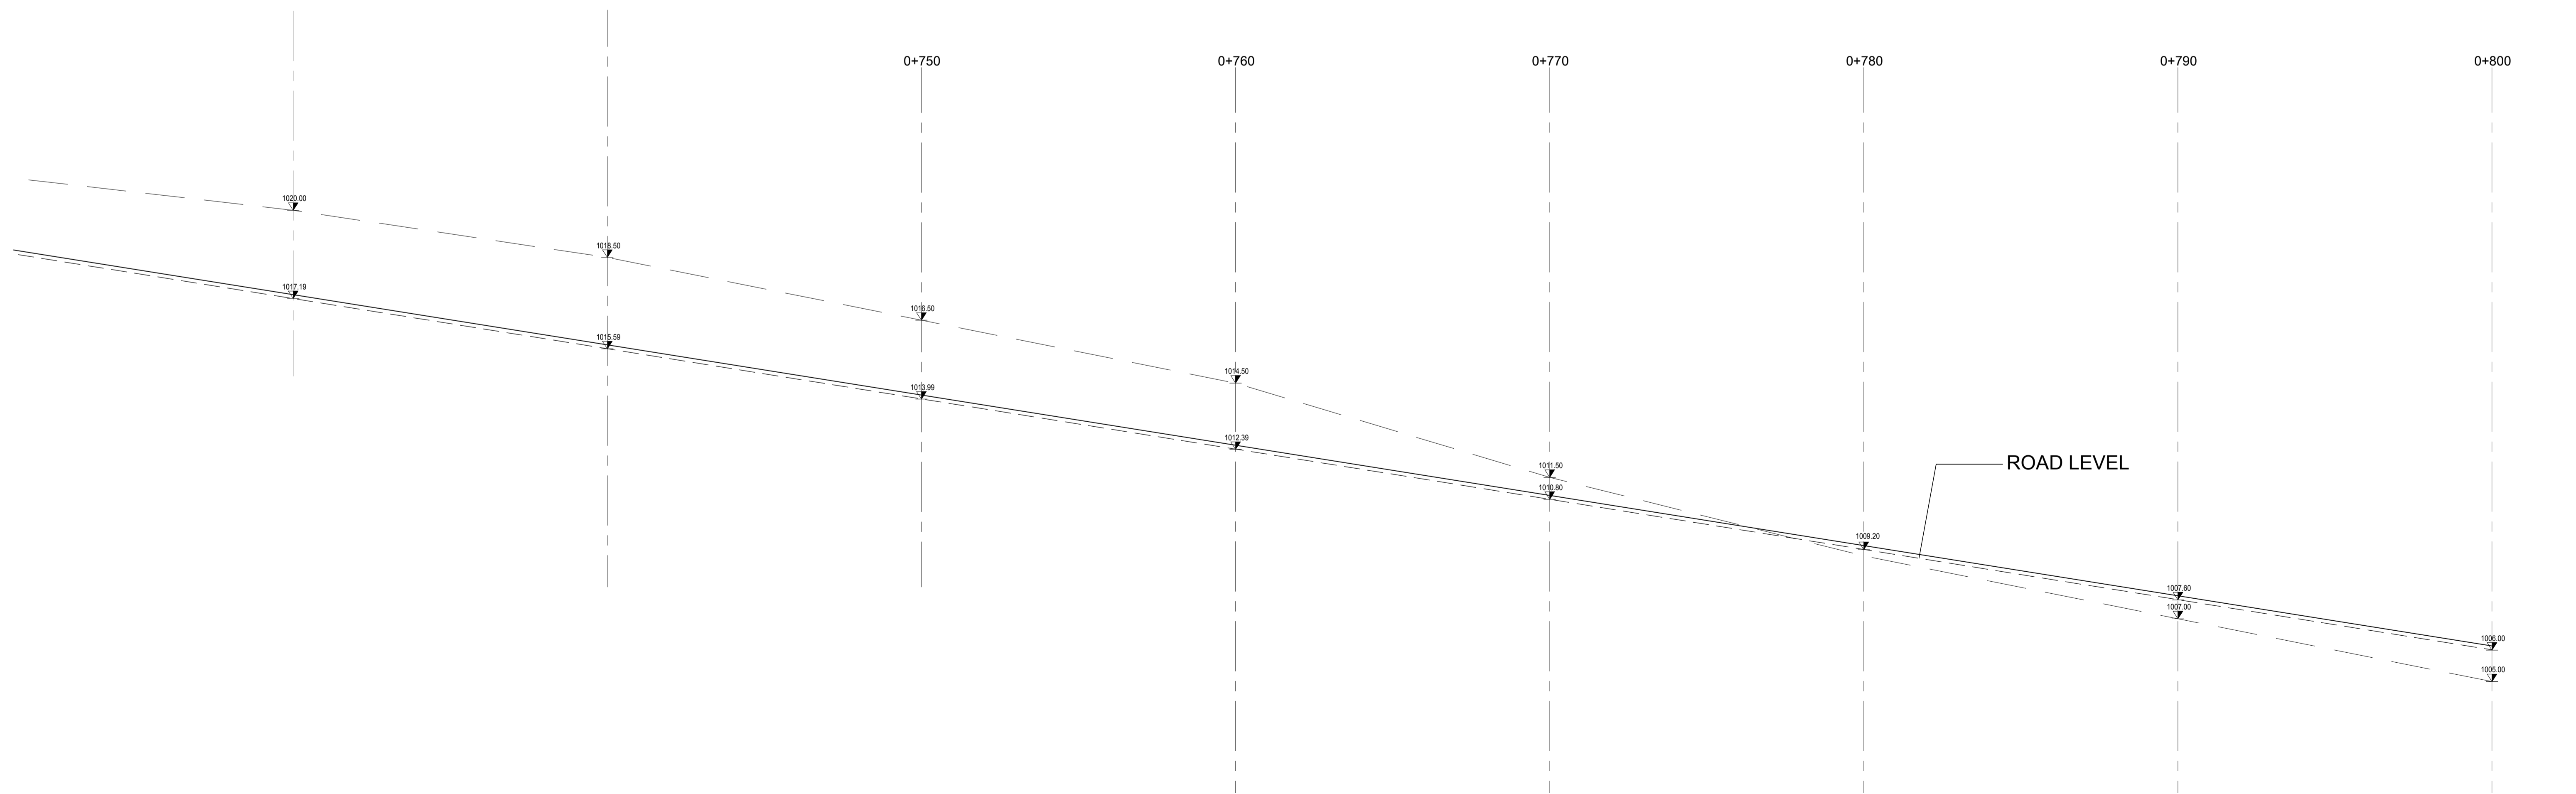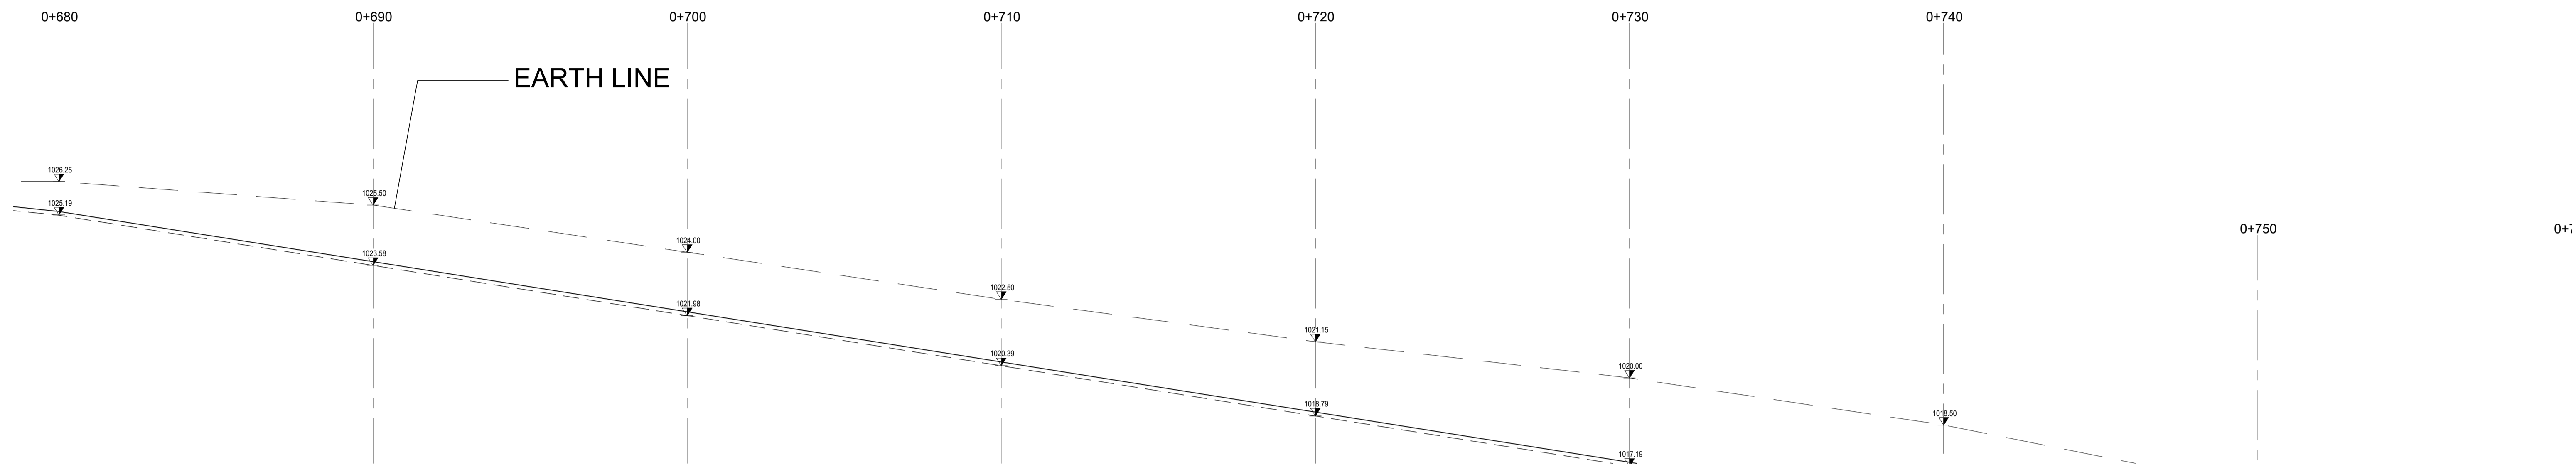


(A)	Gabion
(B)	Rubble stone
(C)	Glass
(D)	Concrete

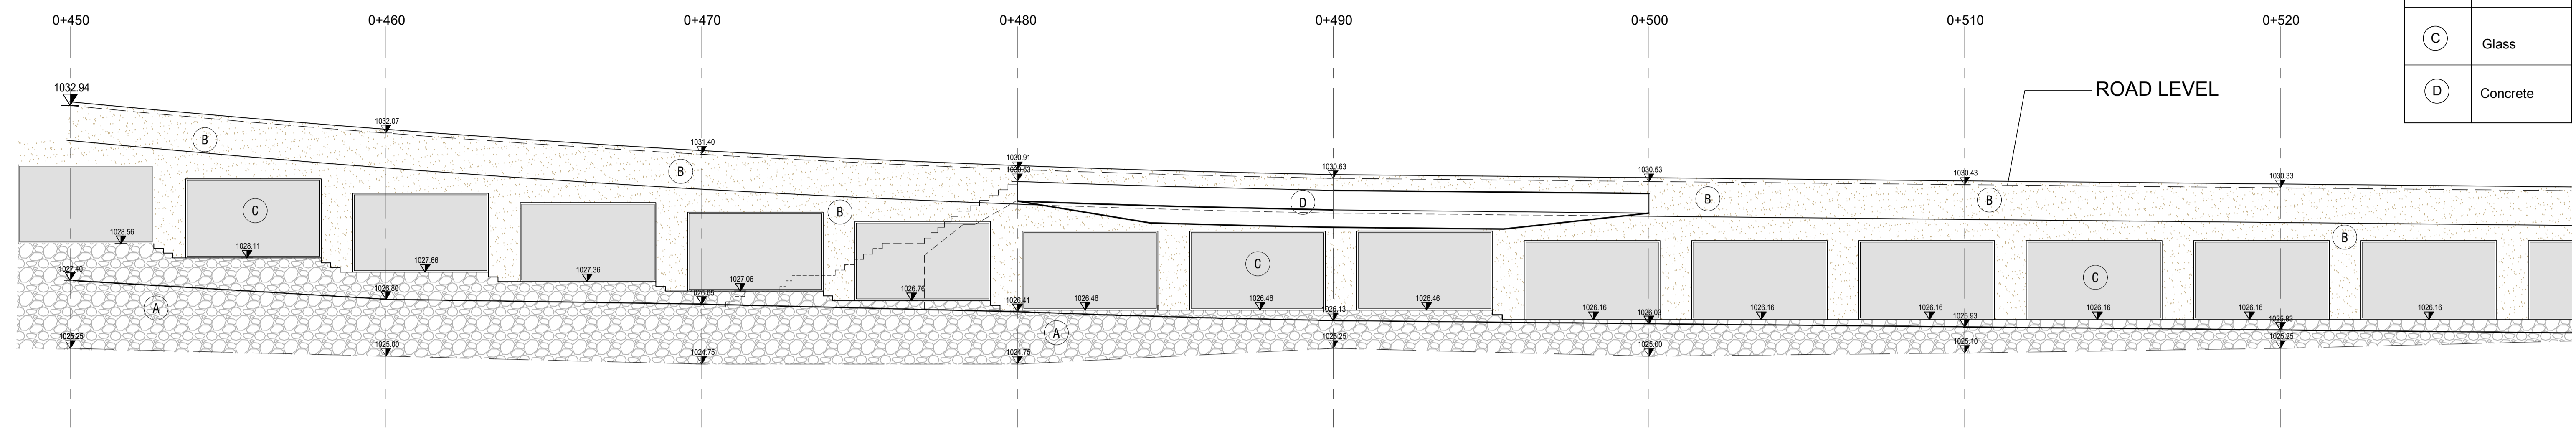


(A)	Gabion
(B)	Rubble stone
(C)	Glass
(D)	Concrete

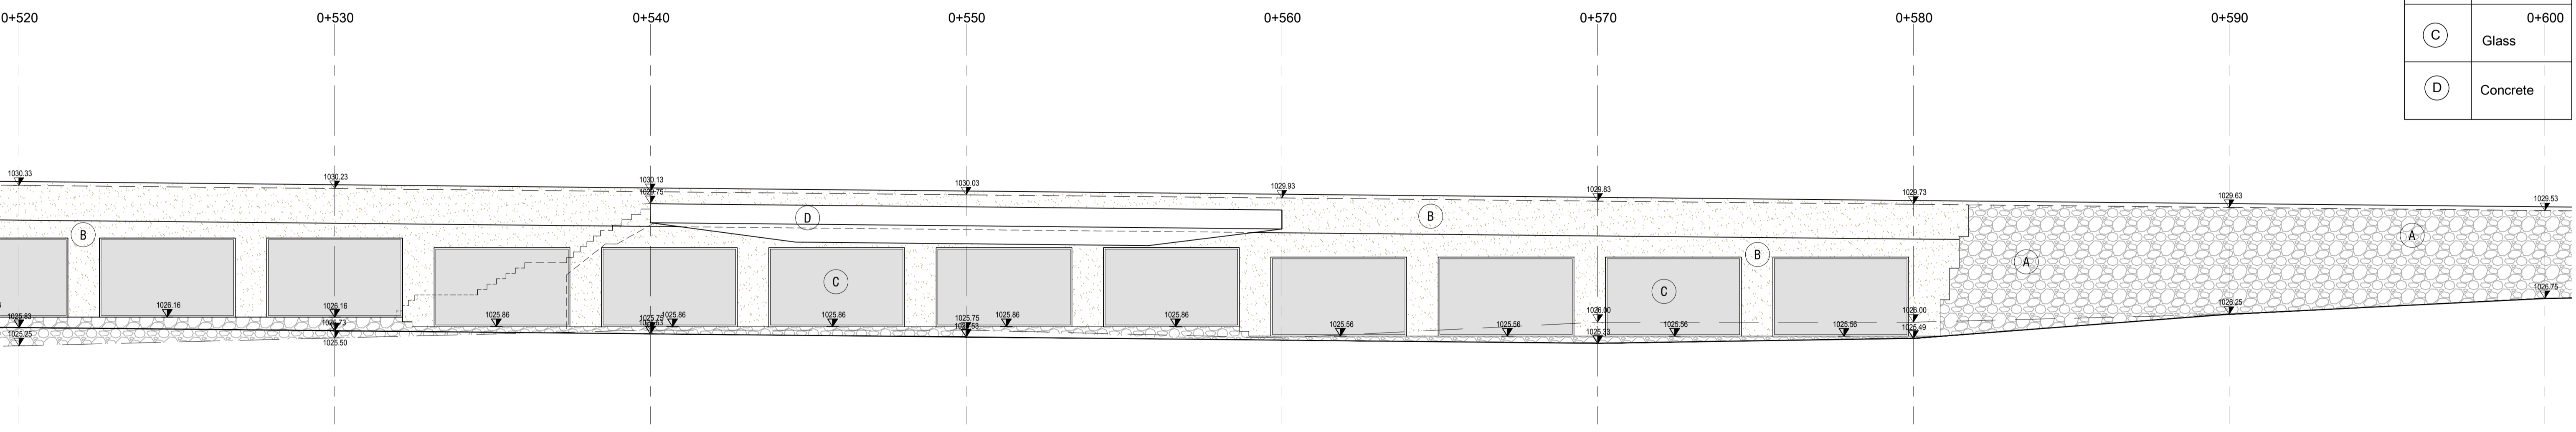


(A)	Gabion
(B)	Rubble stone
(C)	Glass
(D)	Concrete

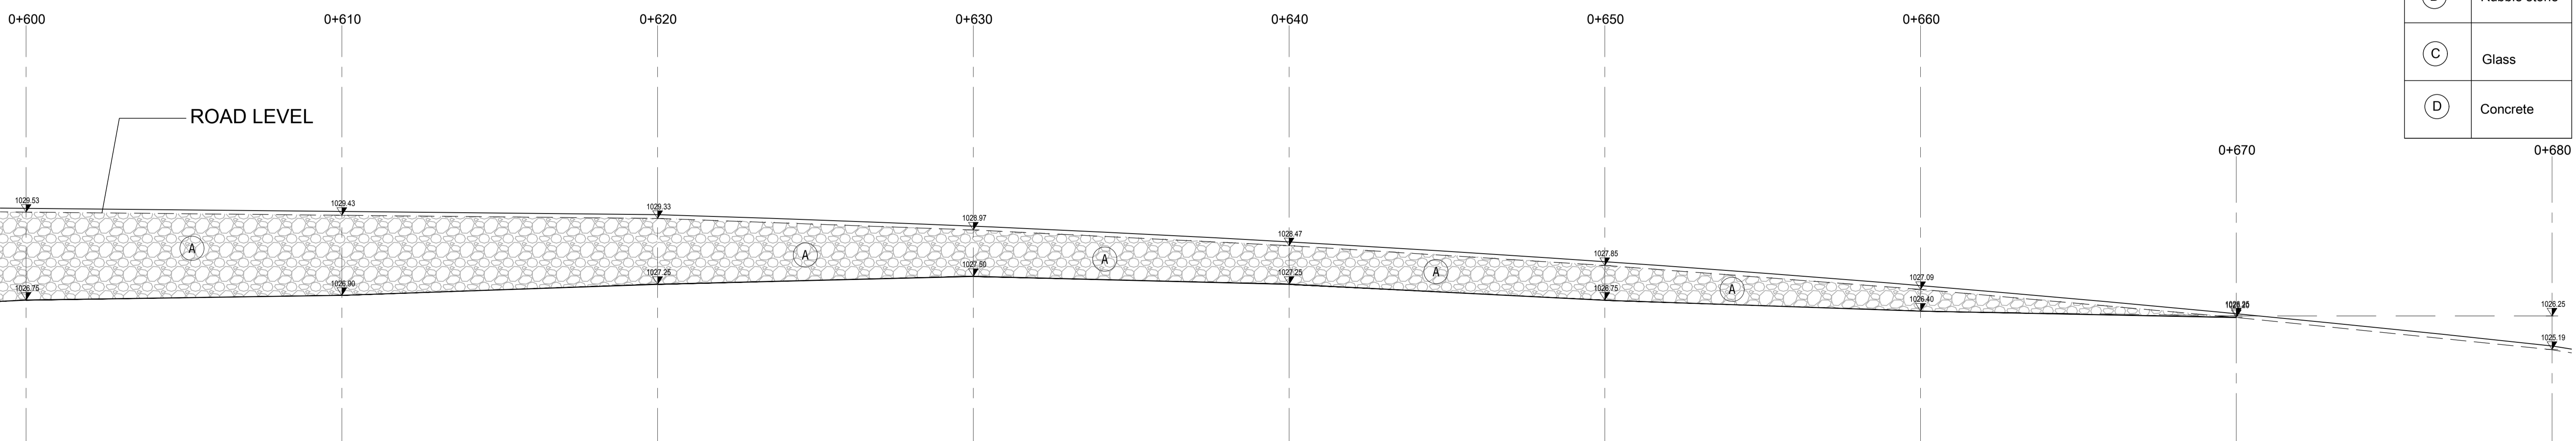


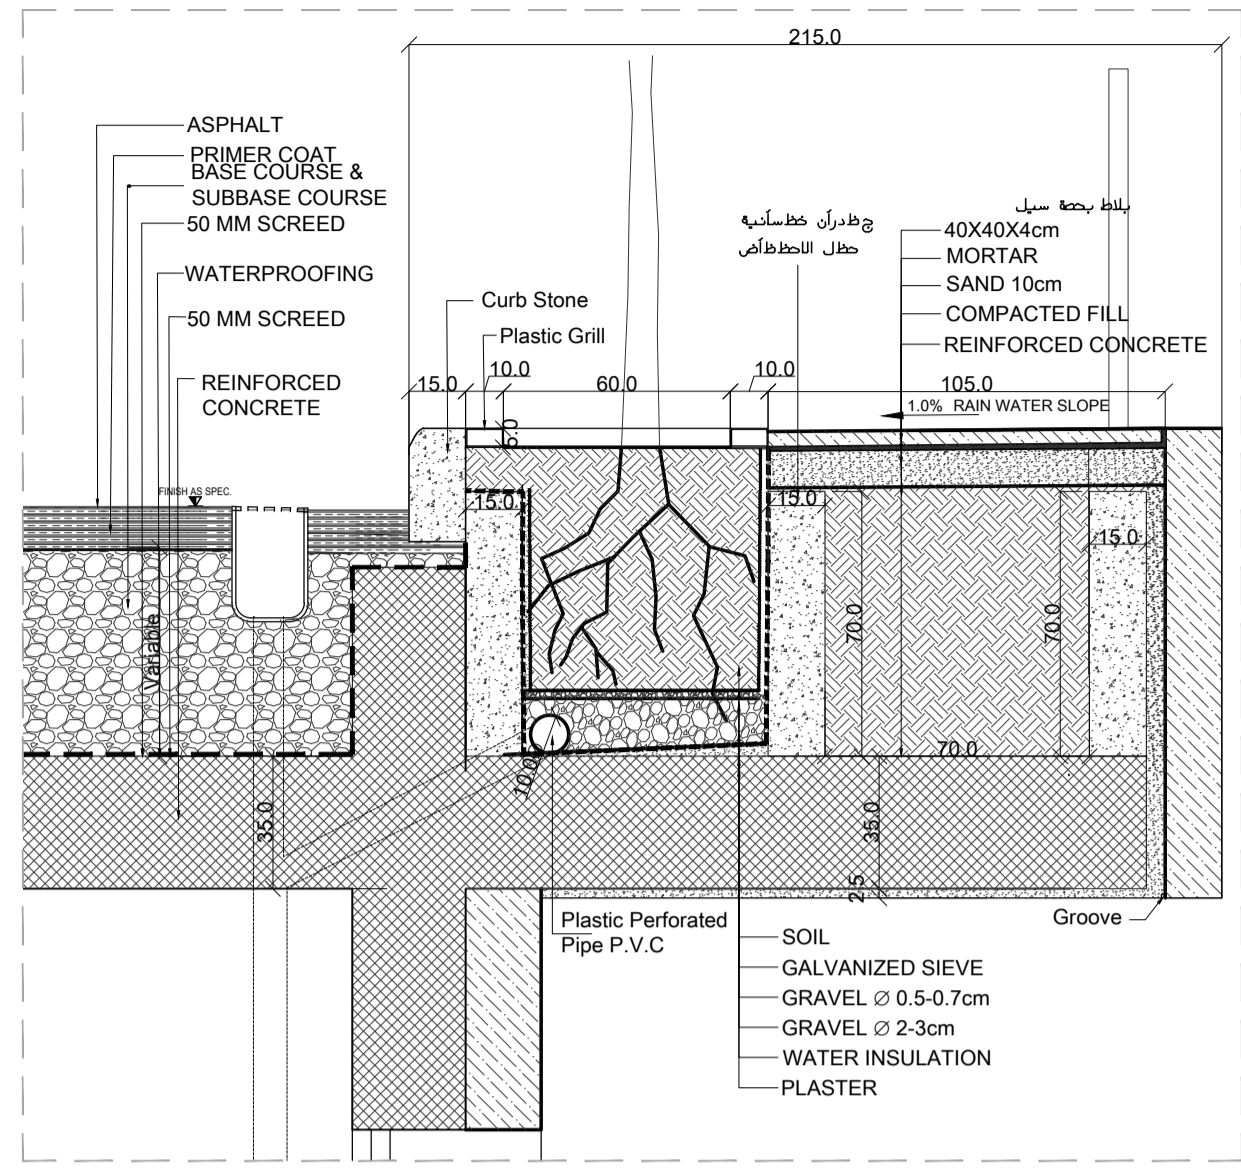



DETAIL 01
SCALE:1-20

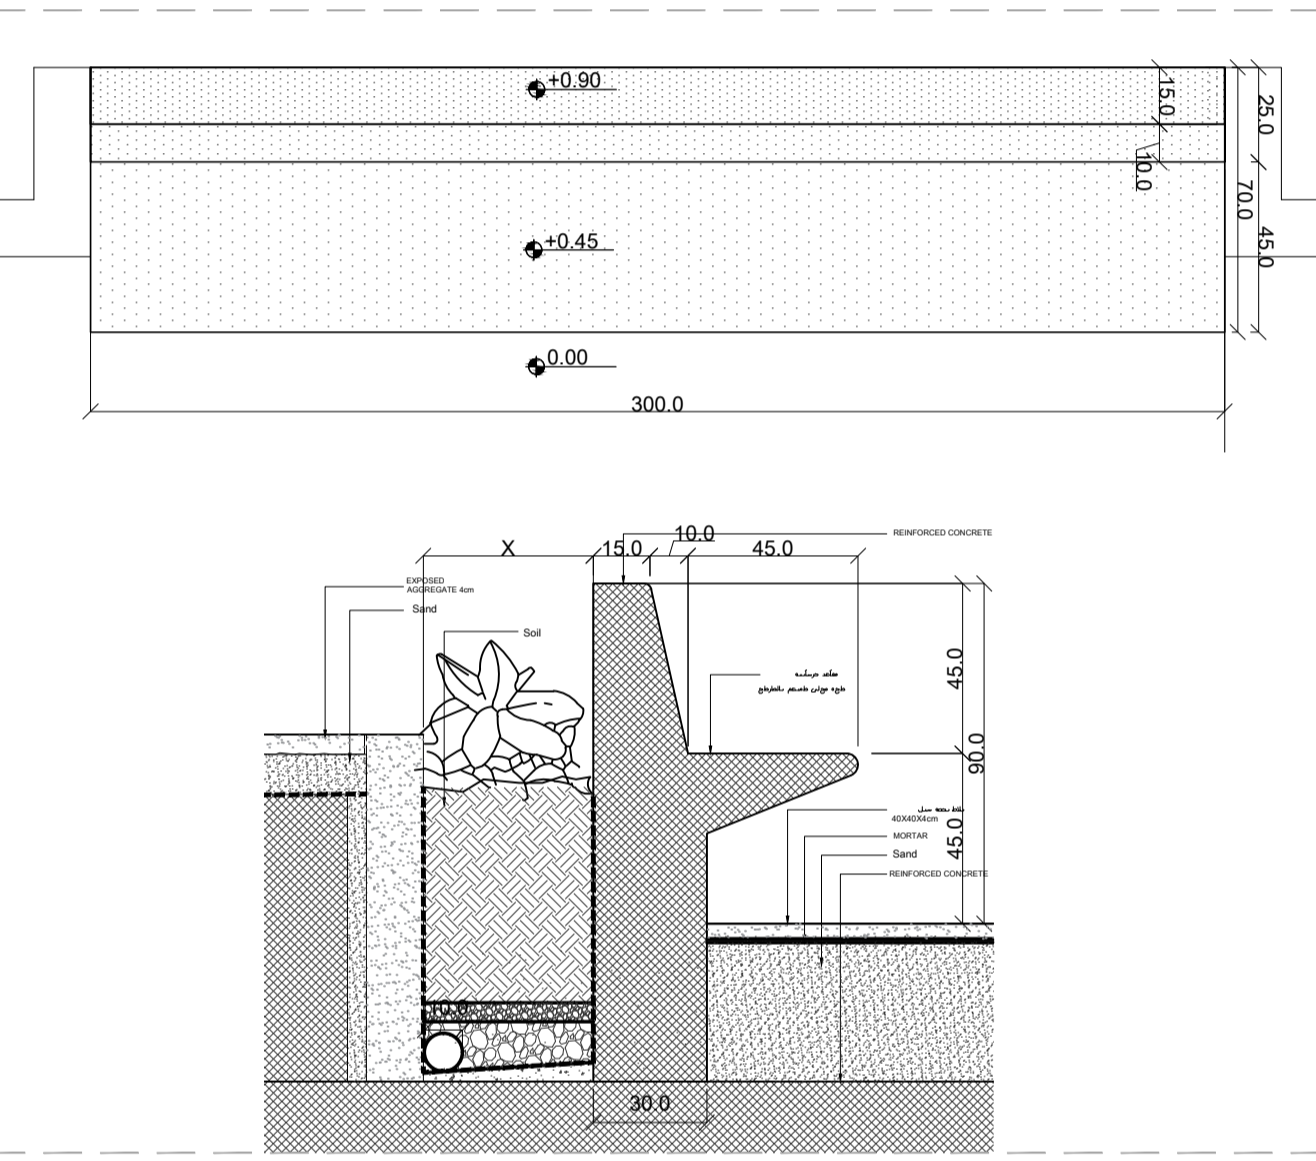


DETAIL 03
SCALE:1-20

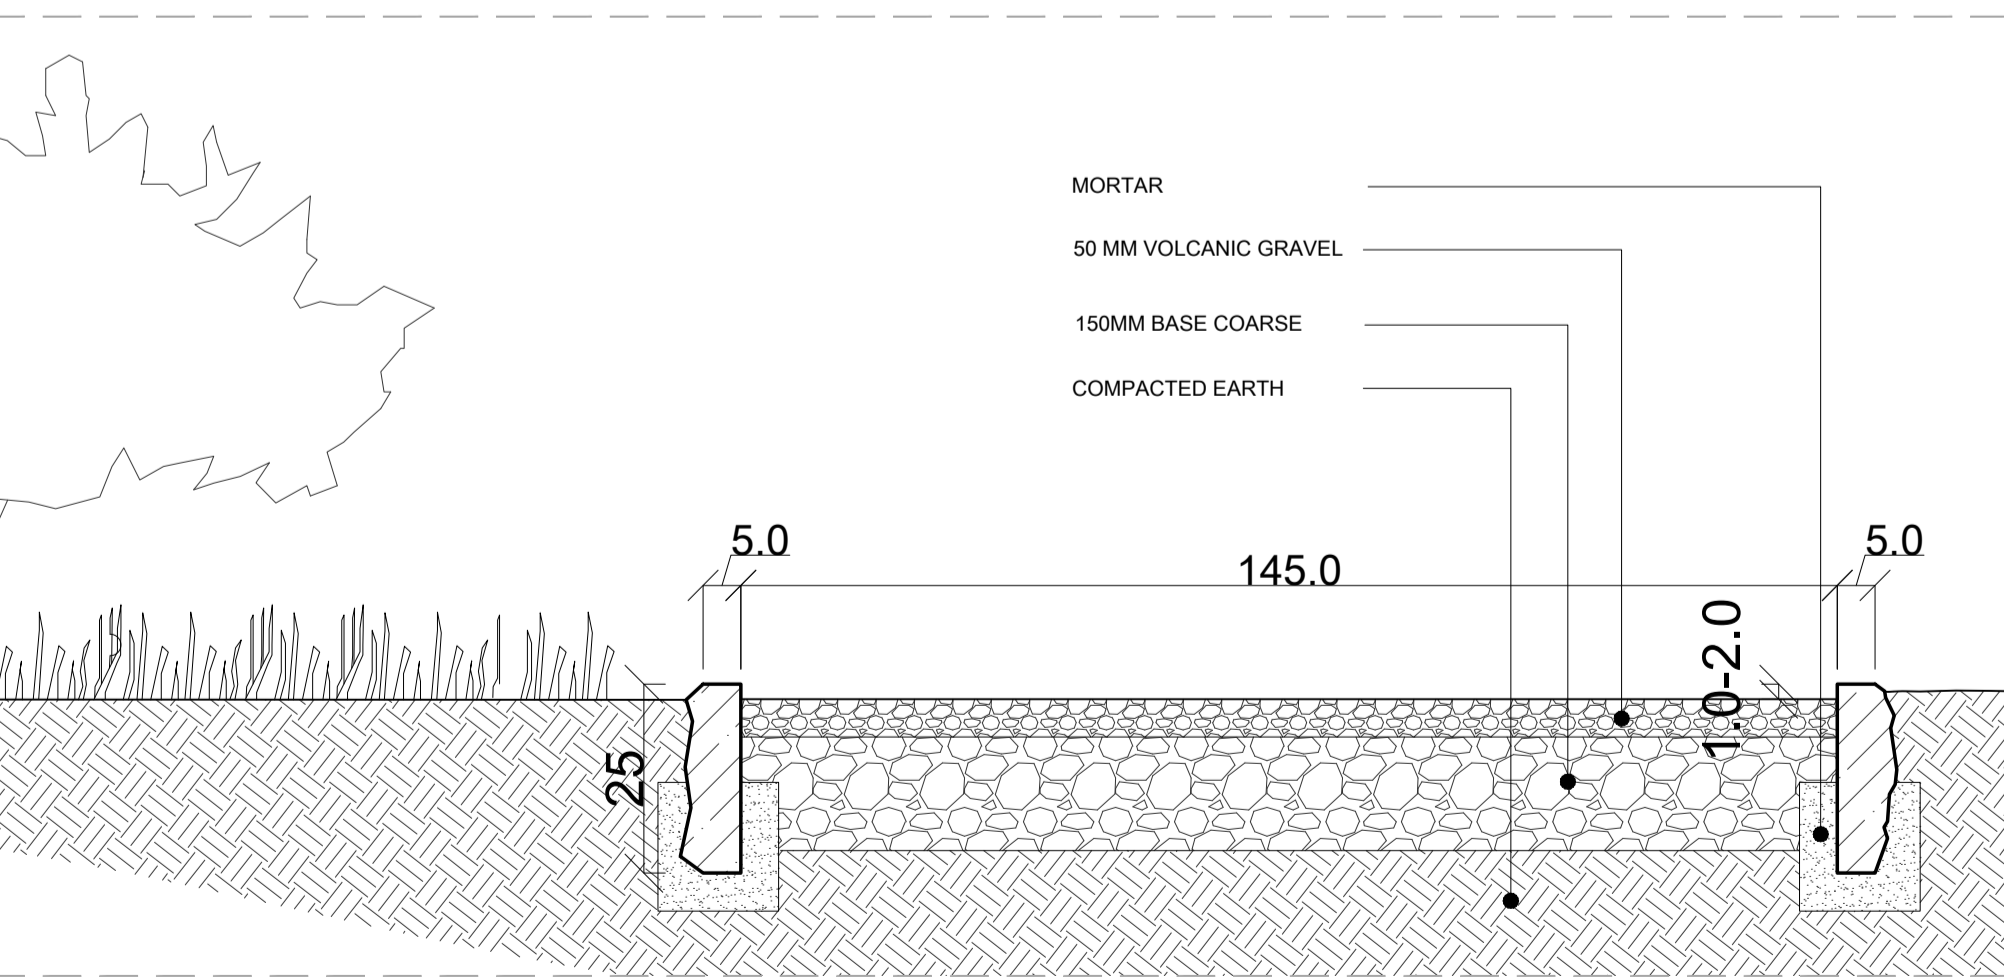

DETAIL 05
SCALE:1-10

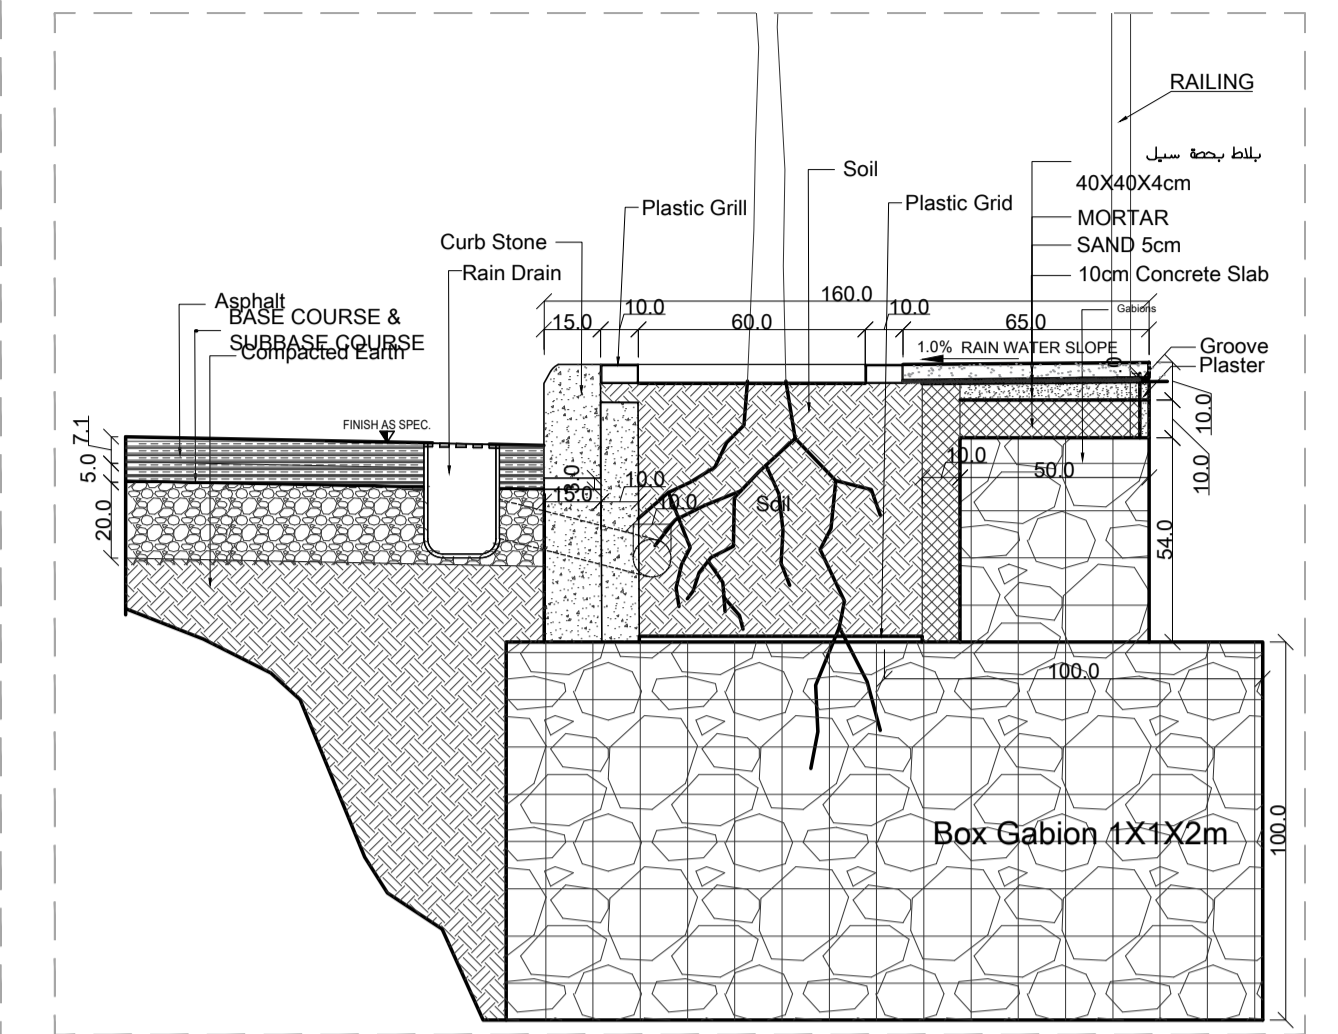
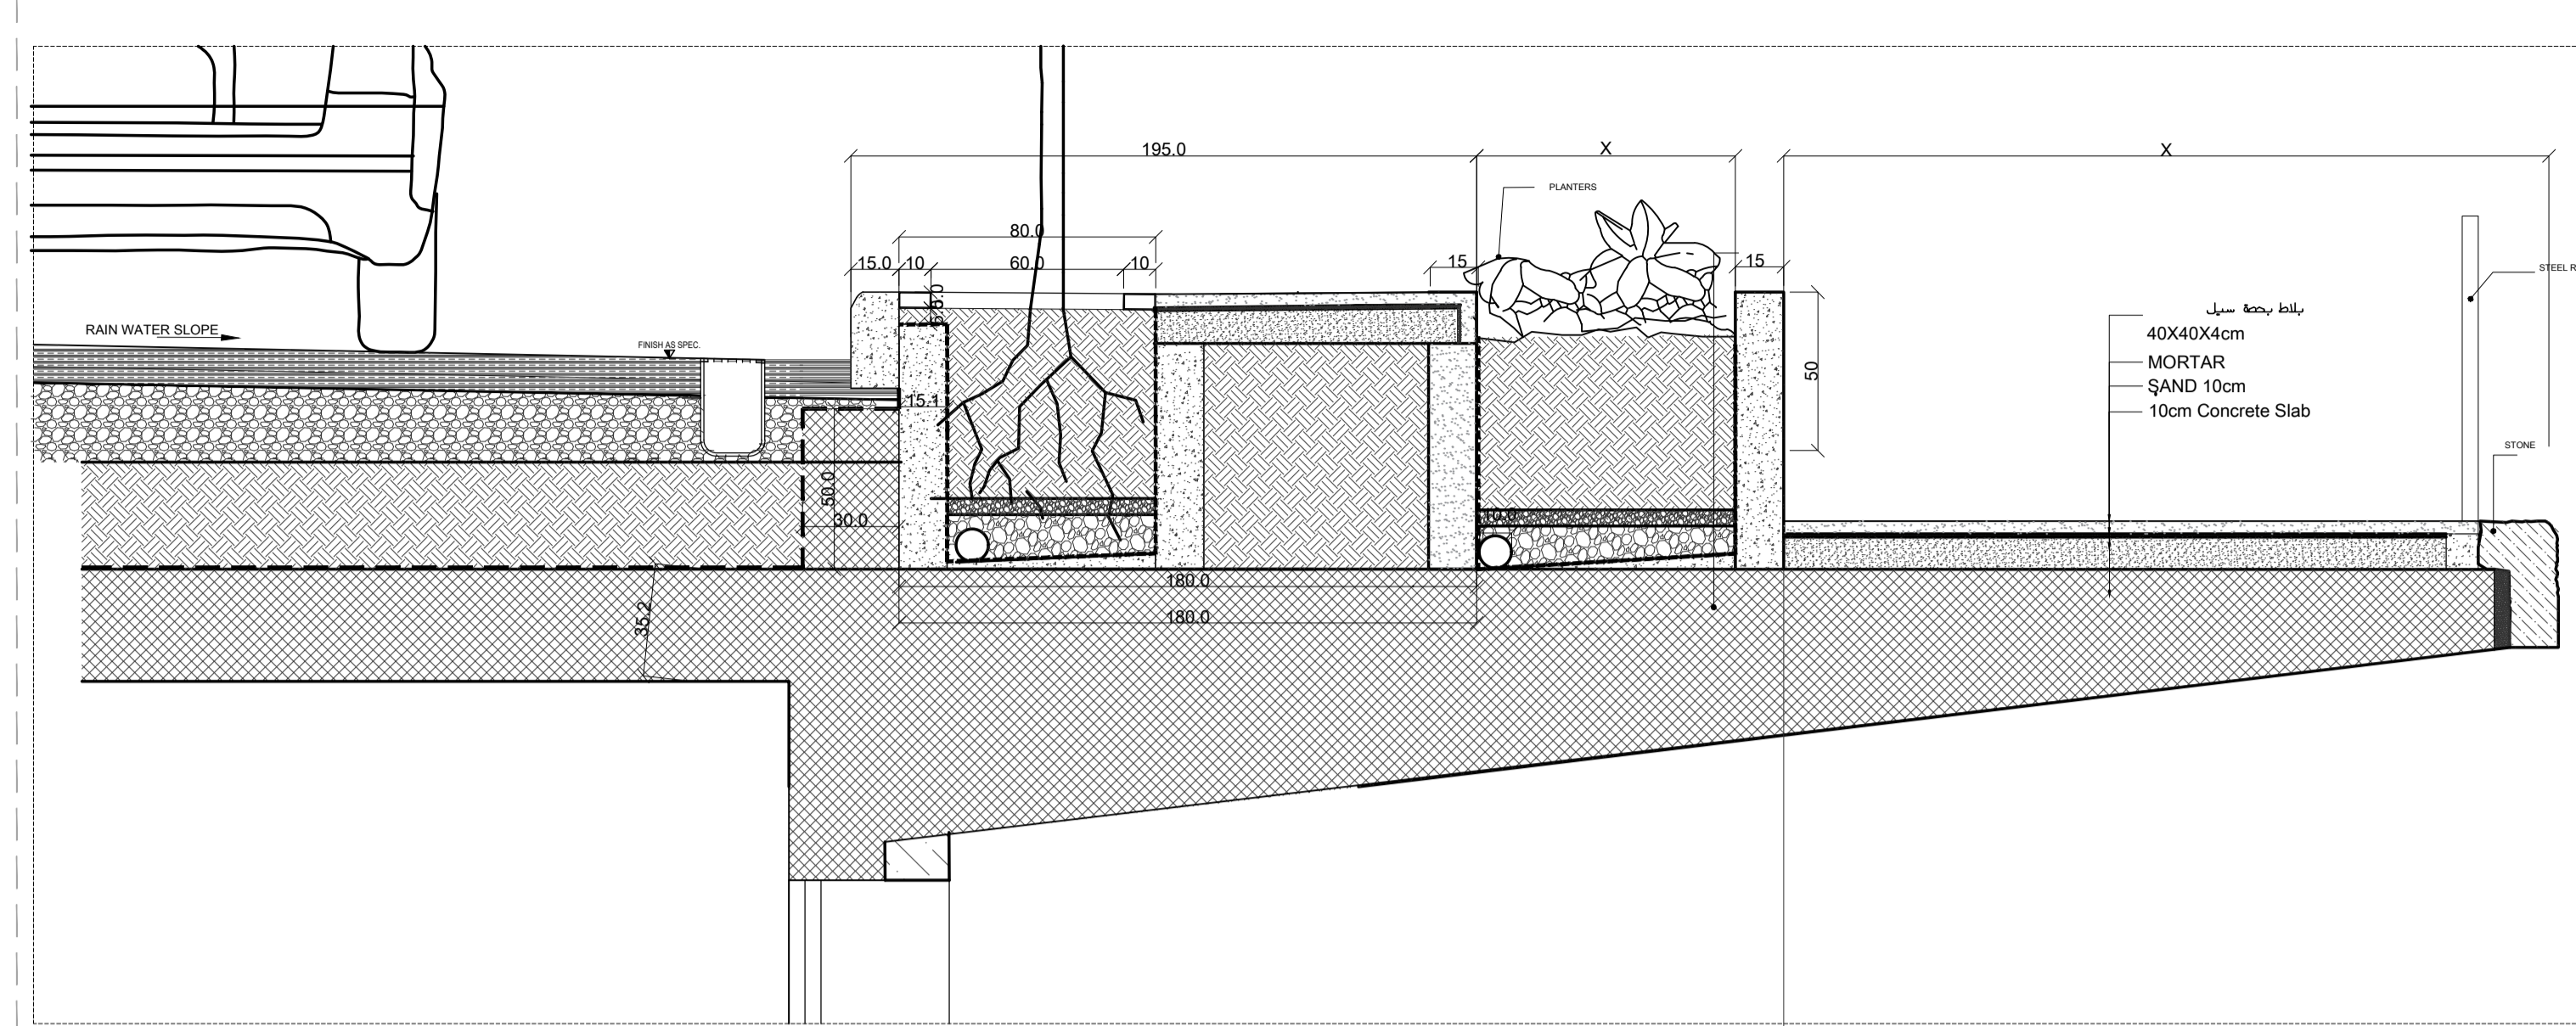


DETAIL 02
SCALE:1-20

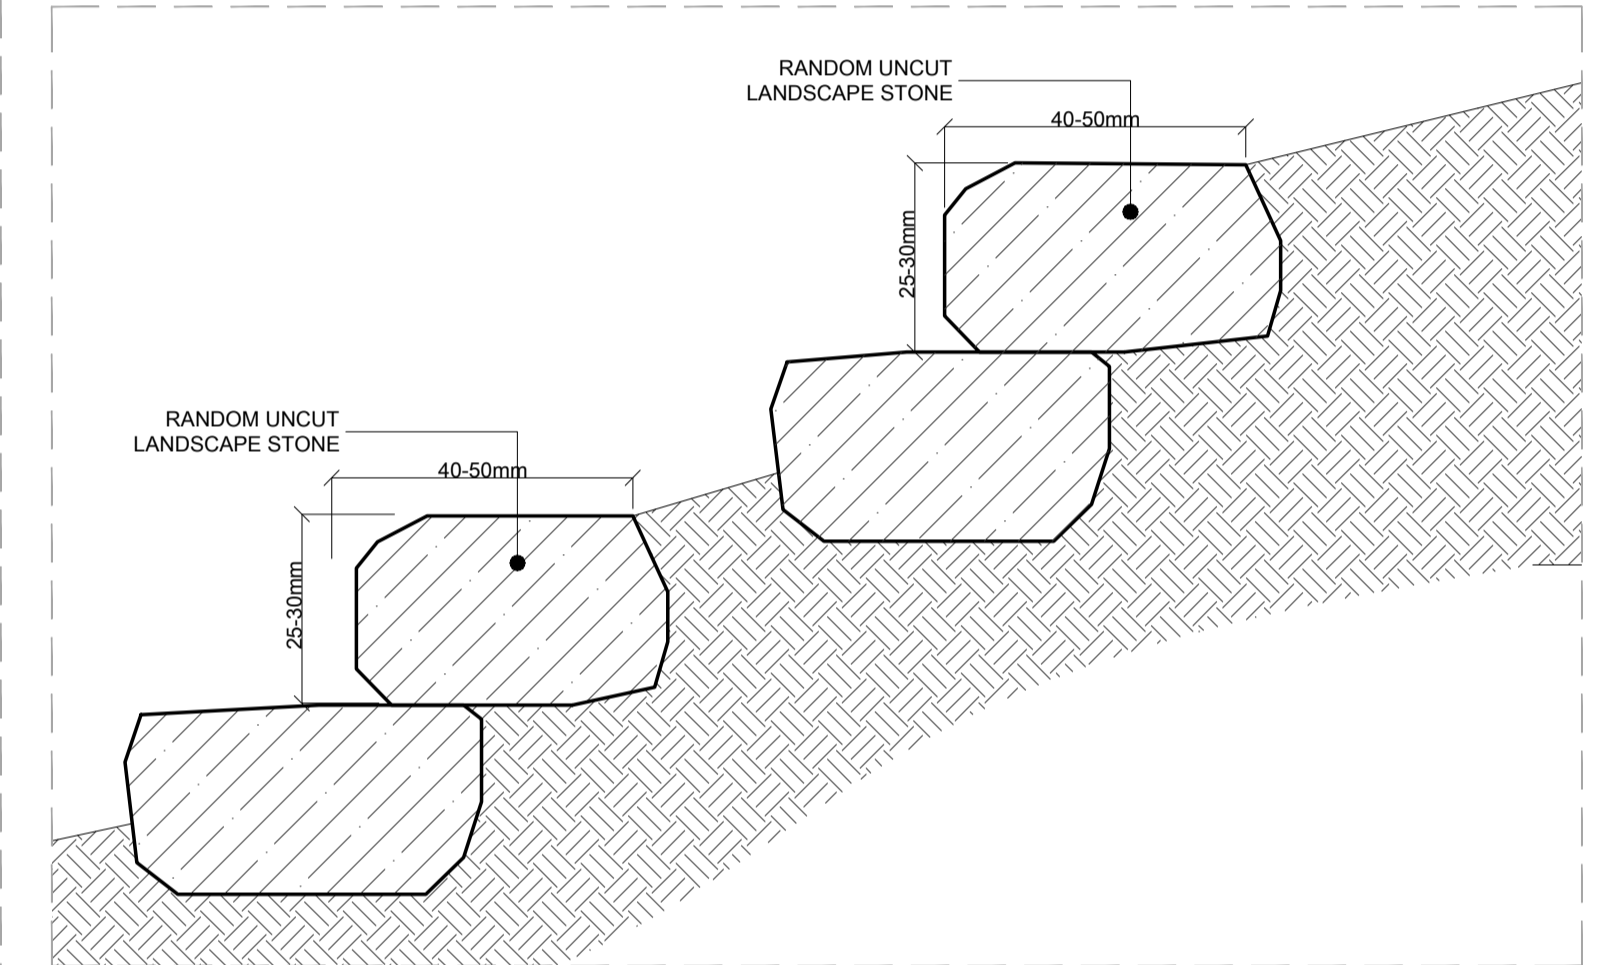


DETAIL 06
SCALE:1-10



DETAIL 04
SCALE:1-20

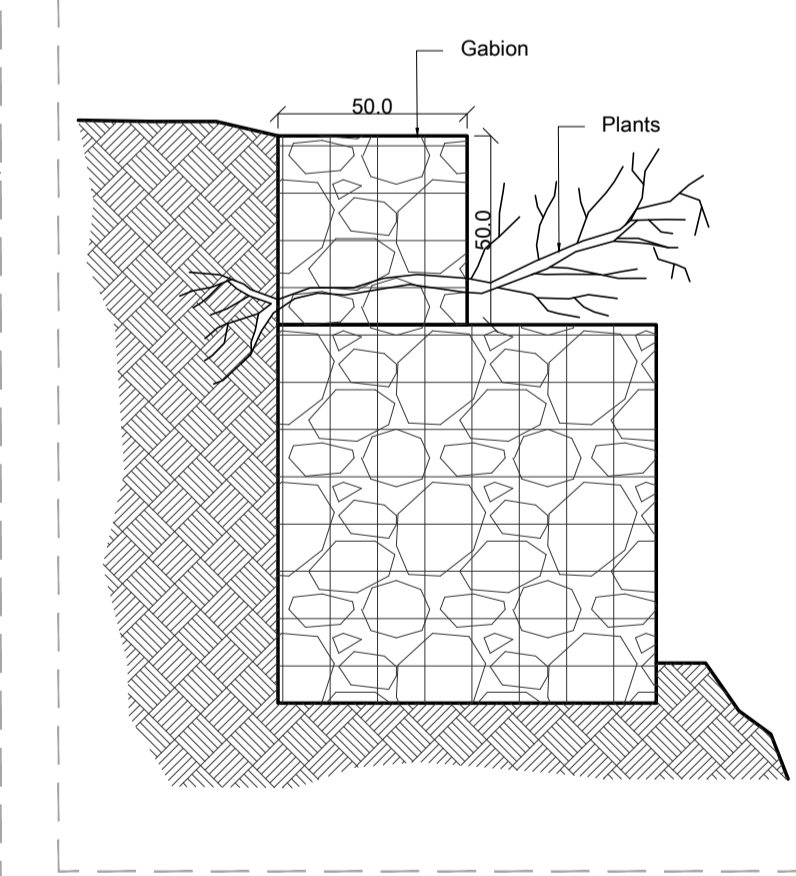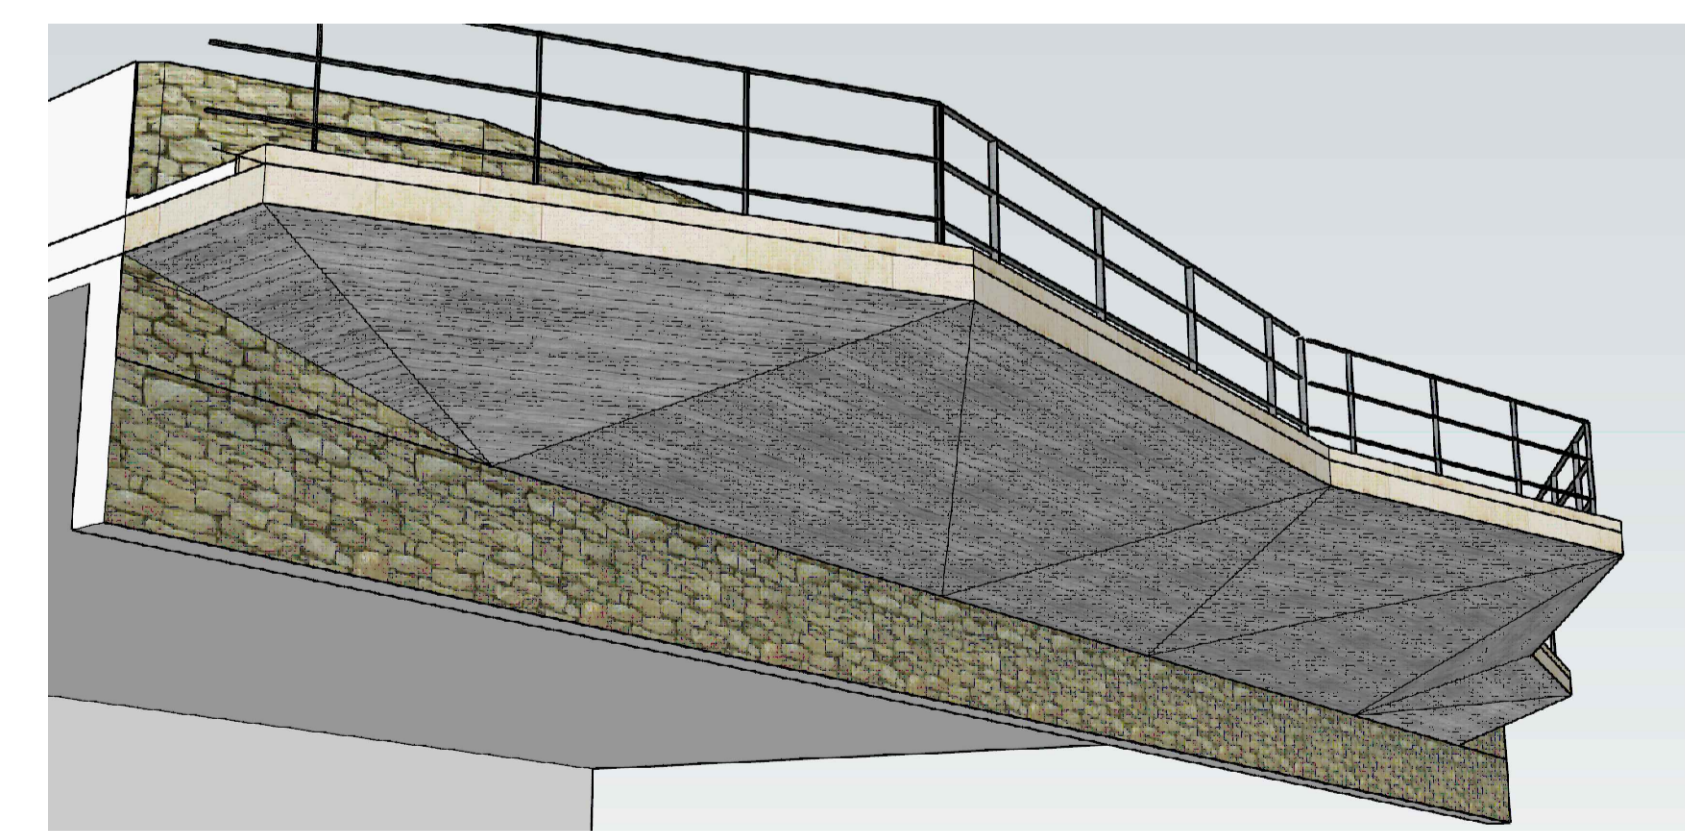


DETAIL 07
SCALE:1-20

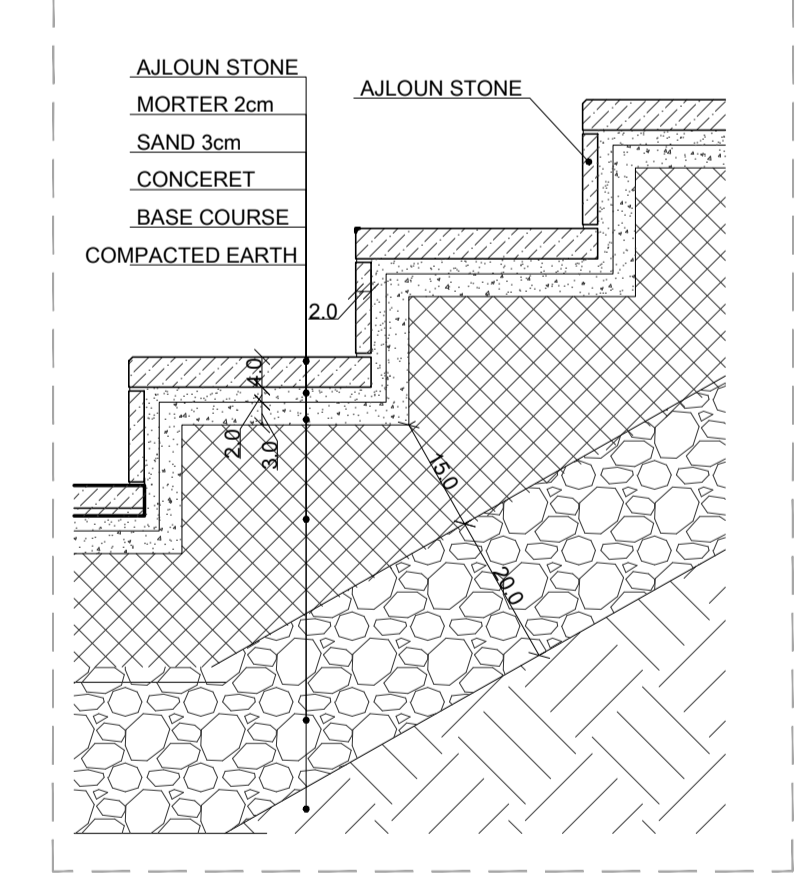


DETAIL 08
SCALE:1-10

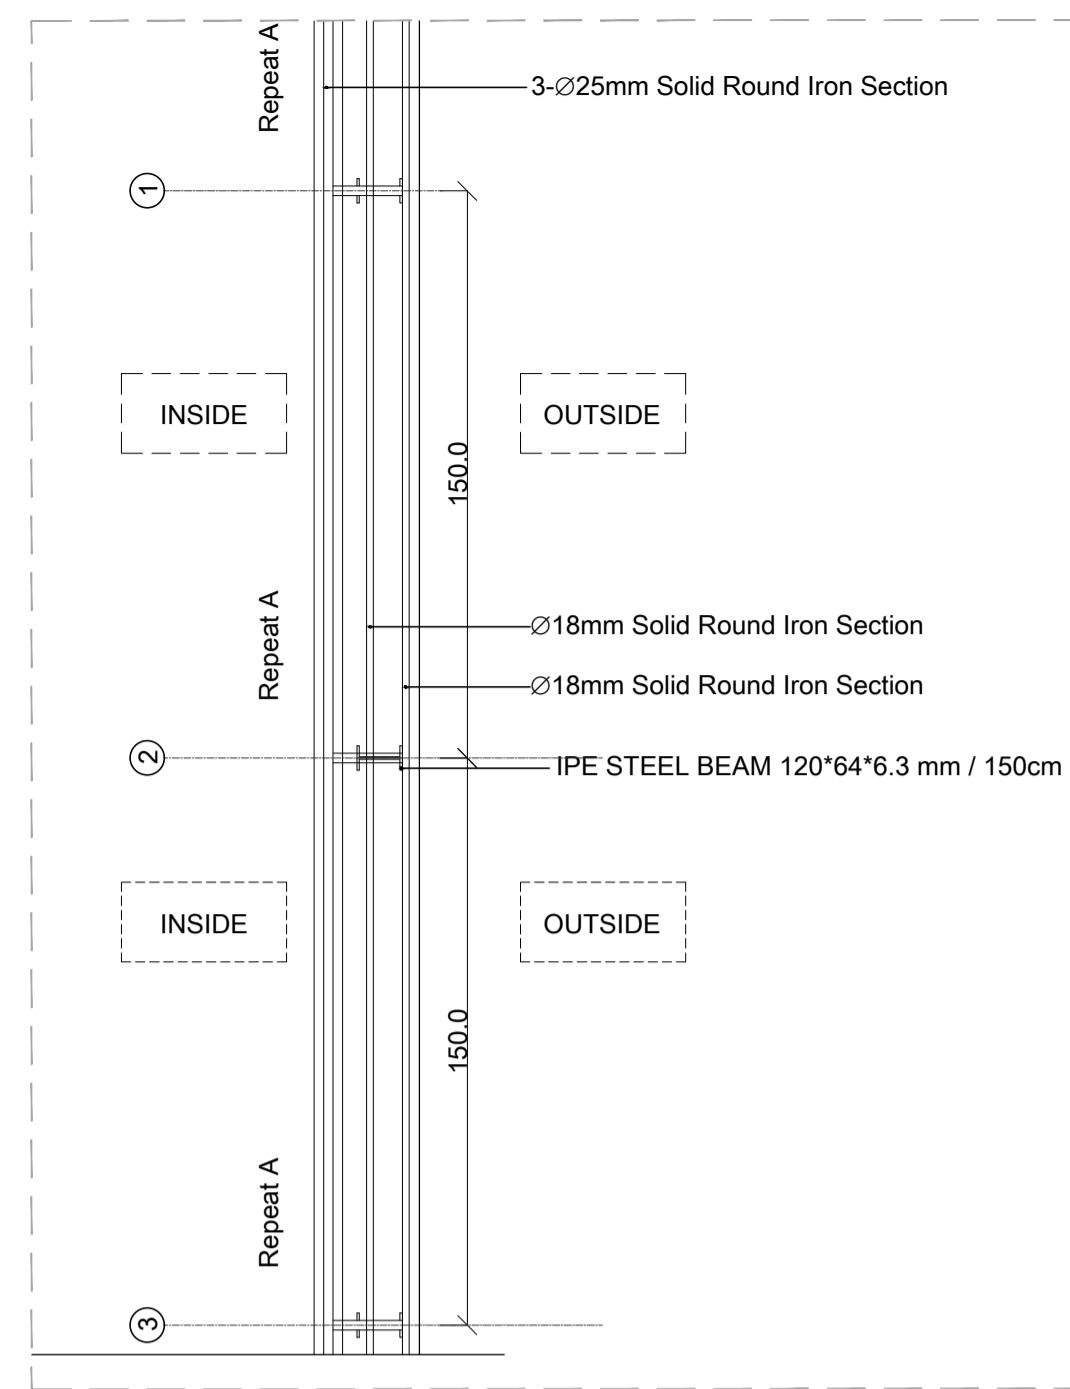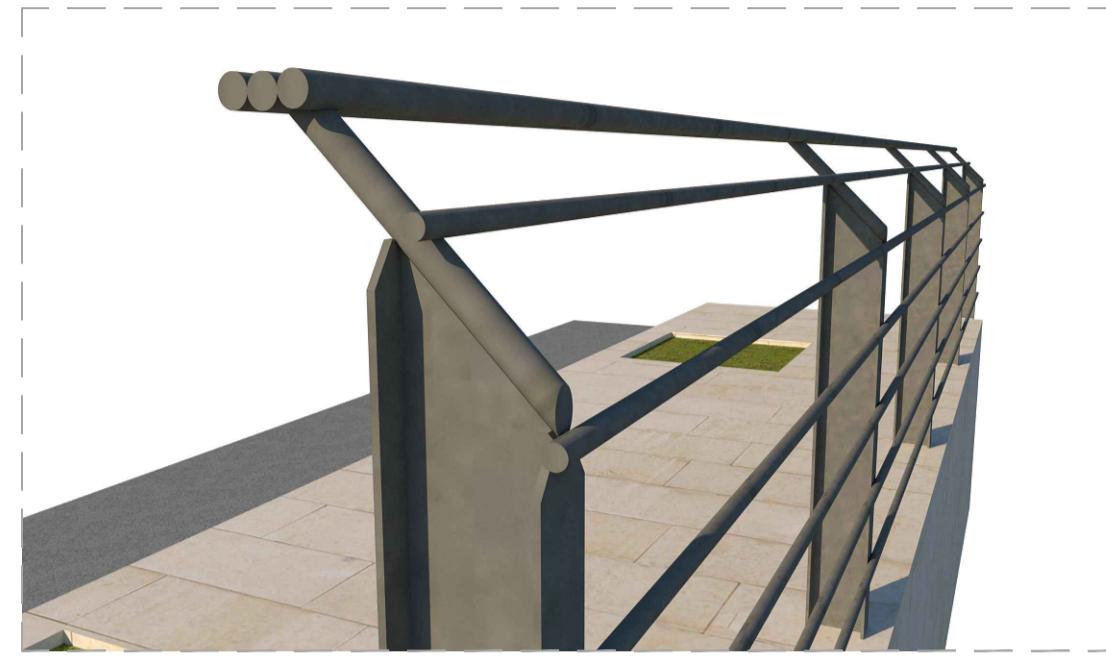


DETAIL 09 RAILING EDGE DETAIL - PLAN
SCALE:1-20

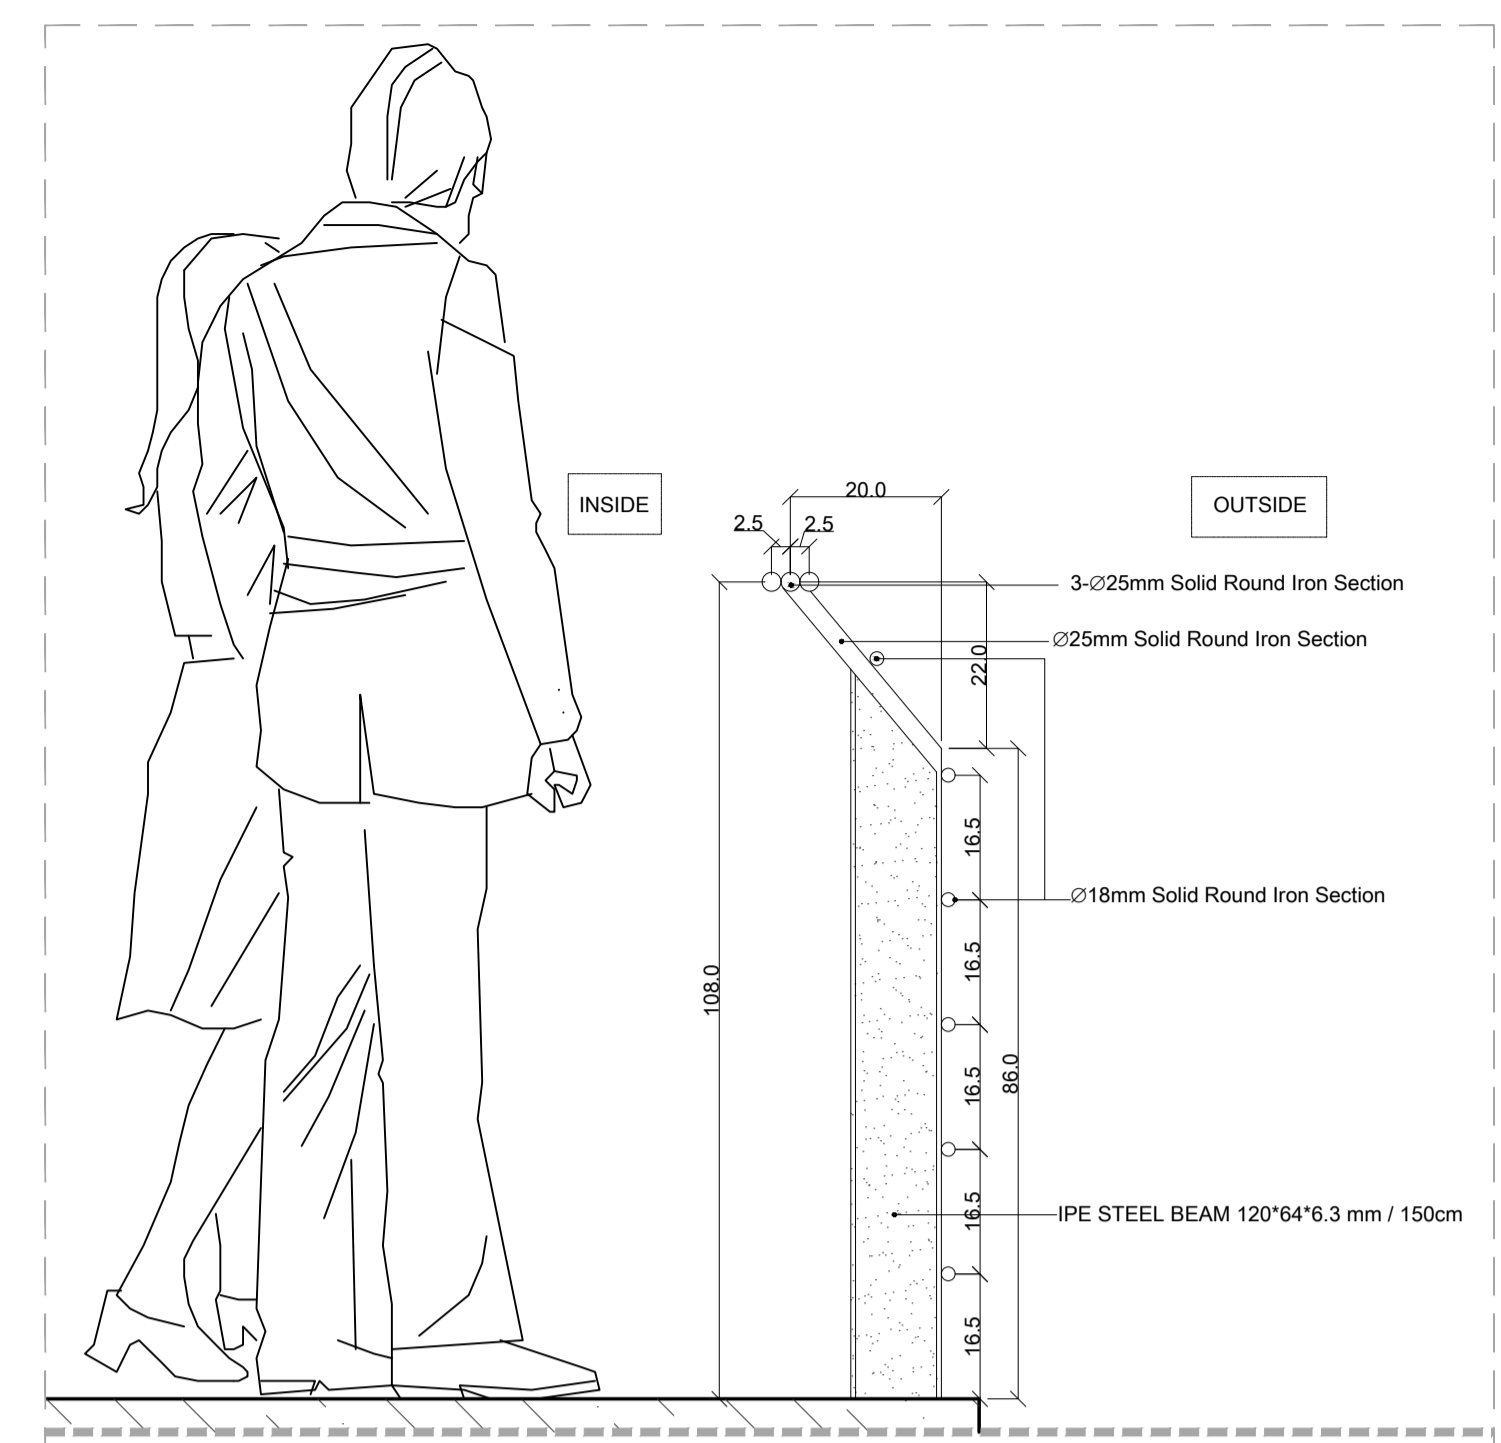


DETAIL 09 RAILING EDGE DETAIL - SECTION
SCALE:1-10

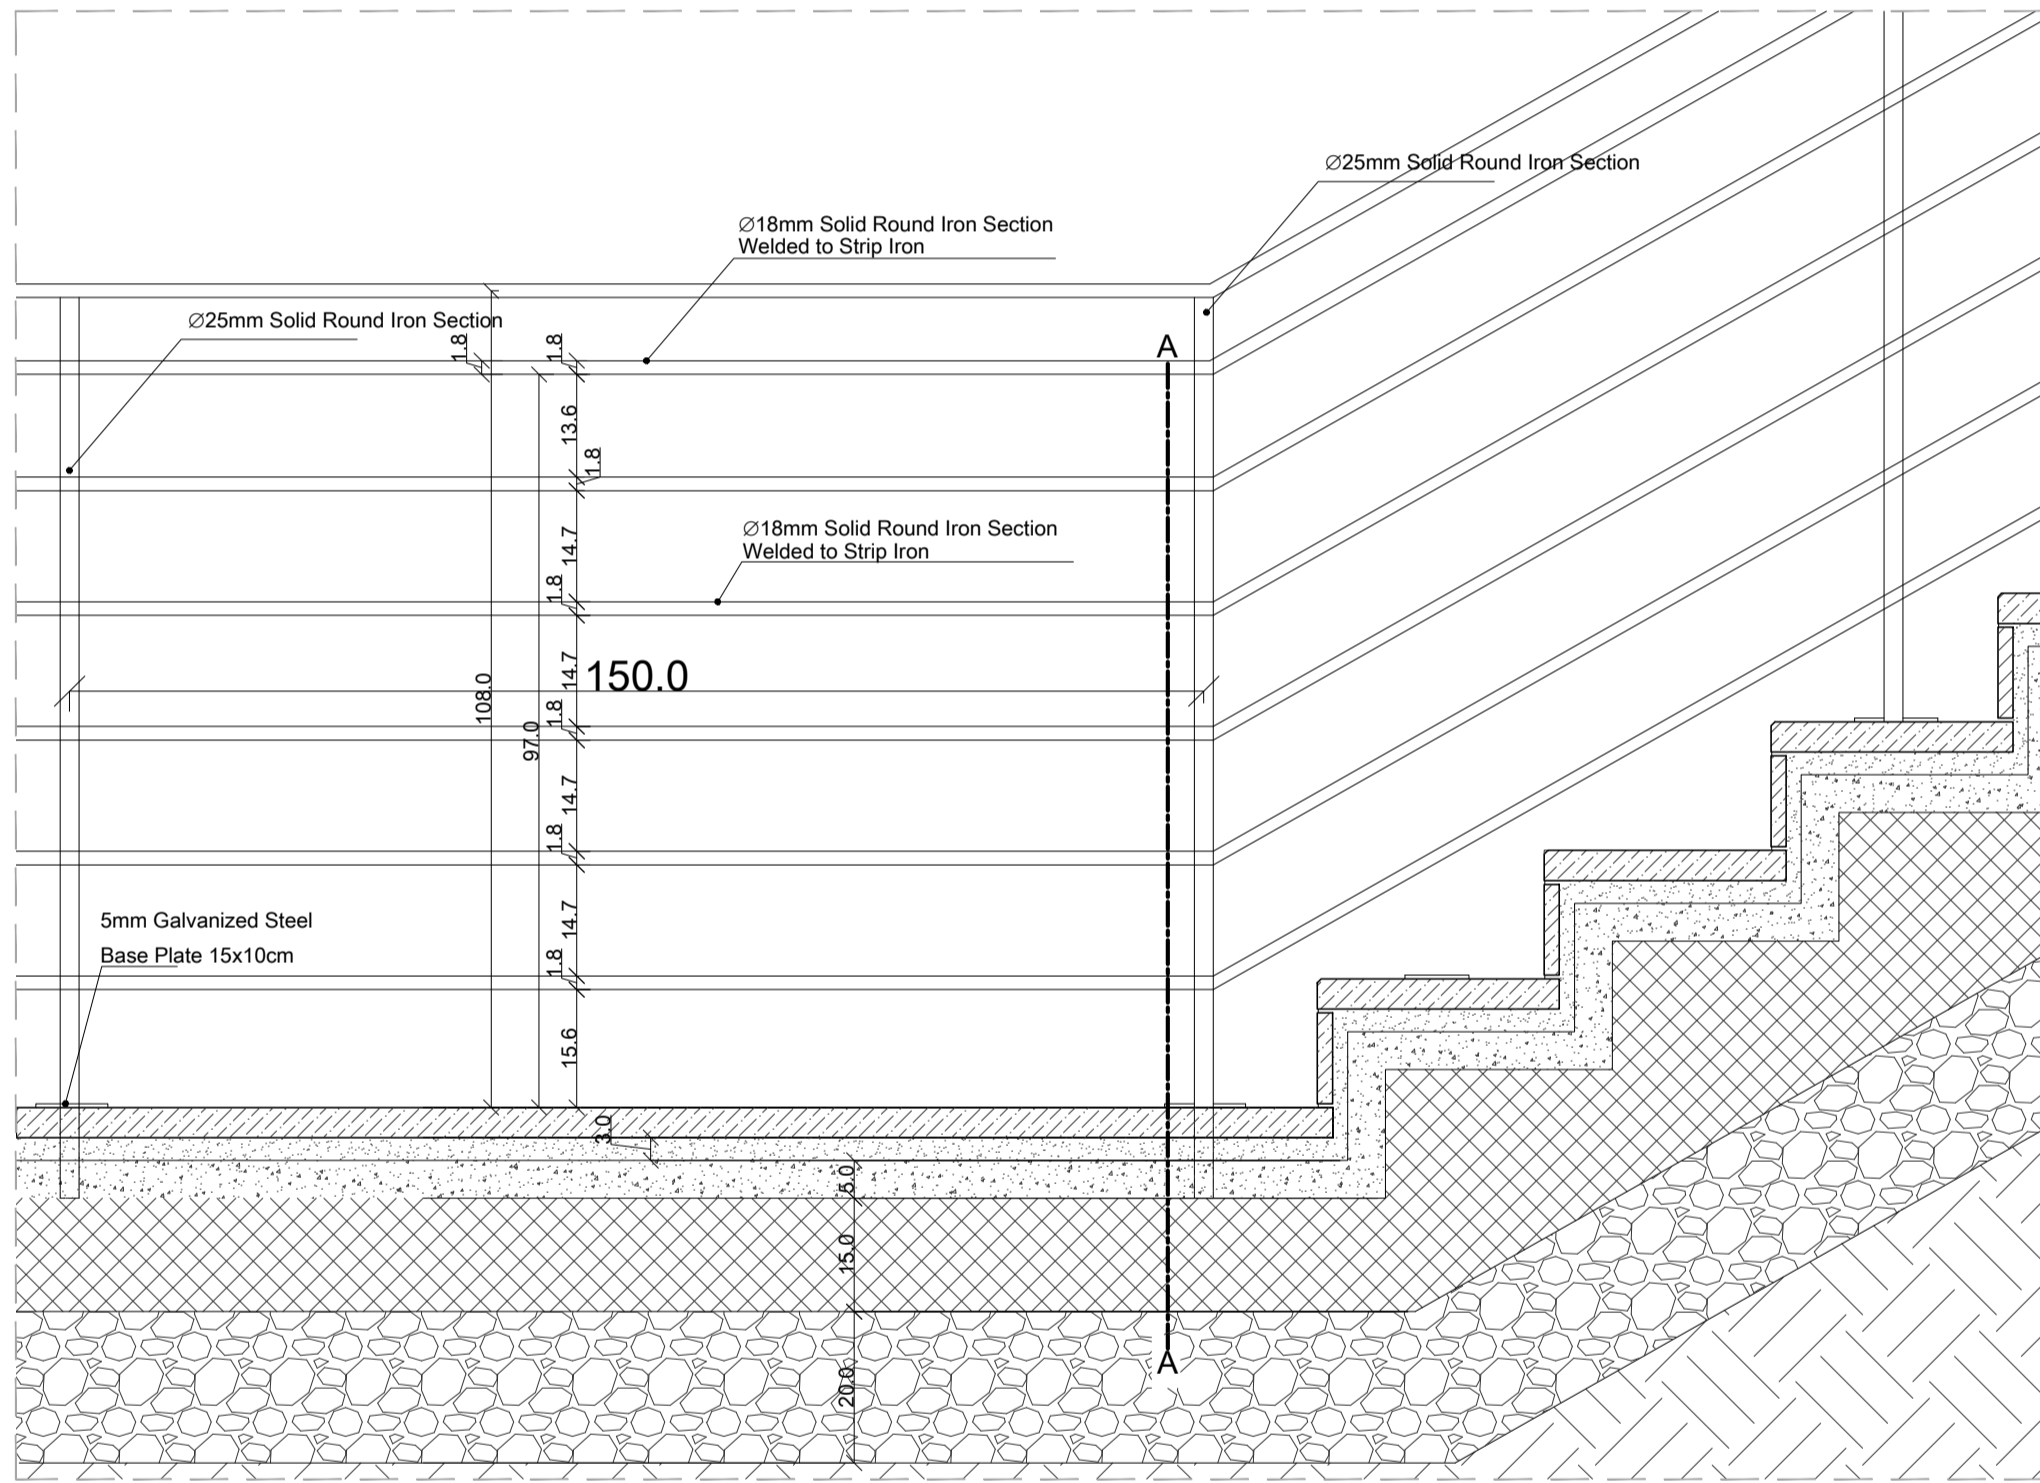


DETAIL 10 RAILING STAIRS DETAIL
SCALE:1-10

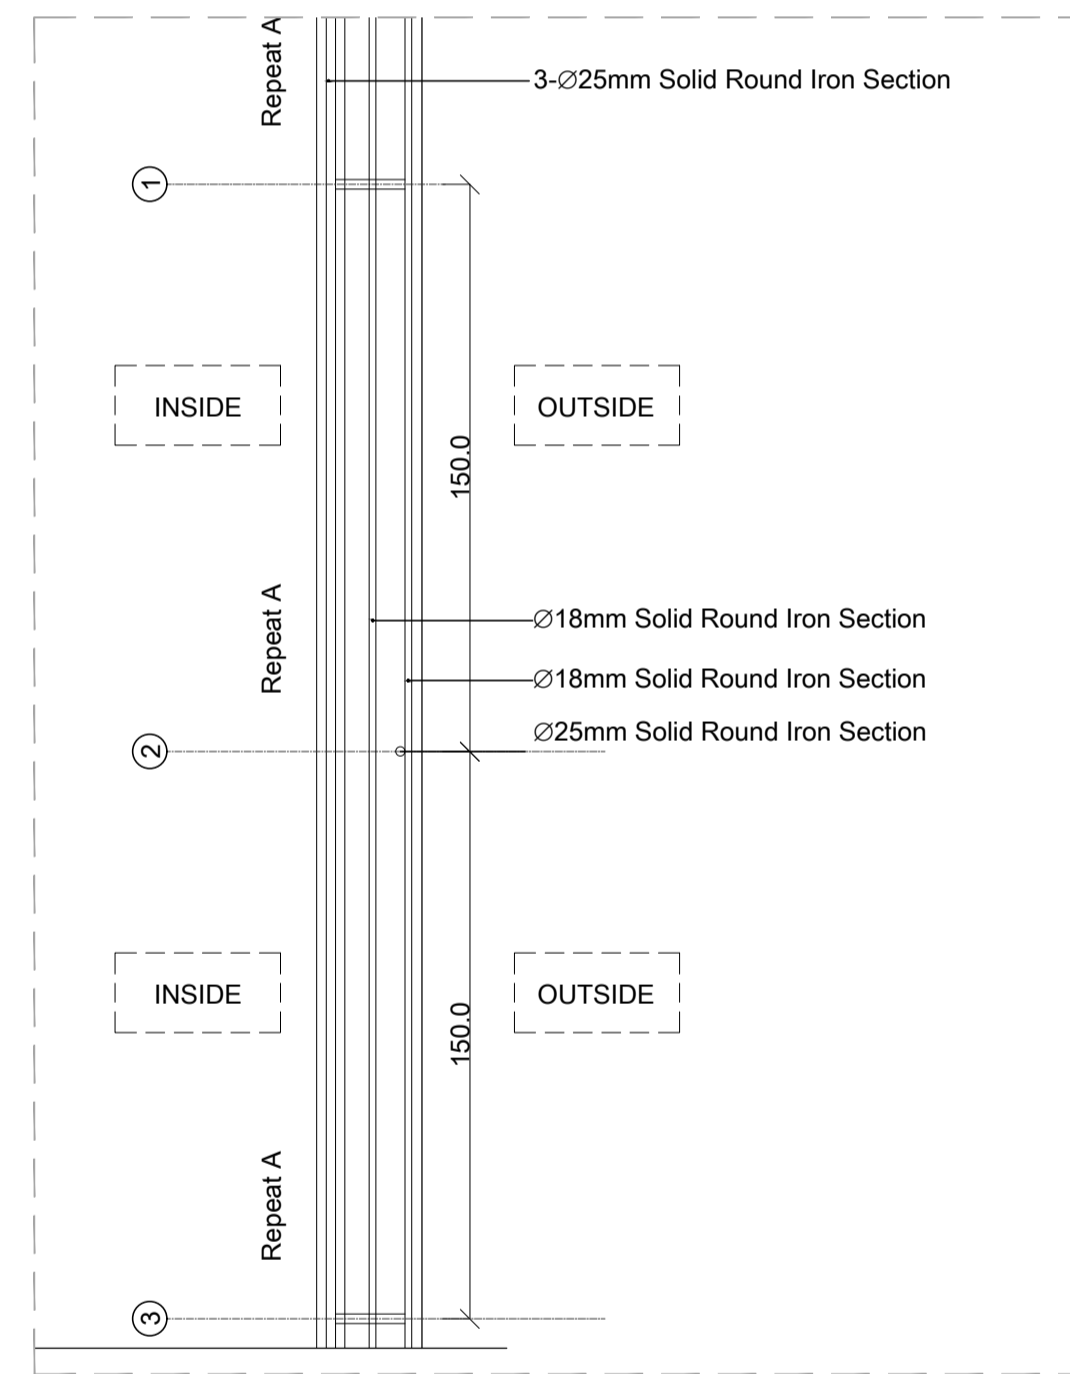


DETAIL 10 RAILING STAIRS DETAIL - PLAN
SCALE:1-20

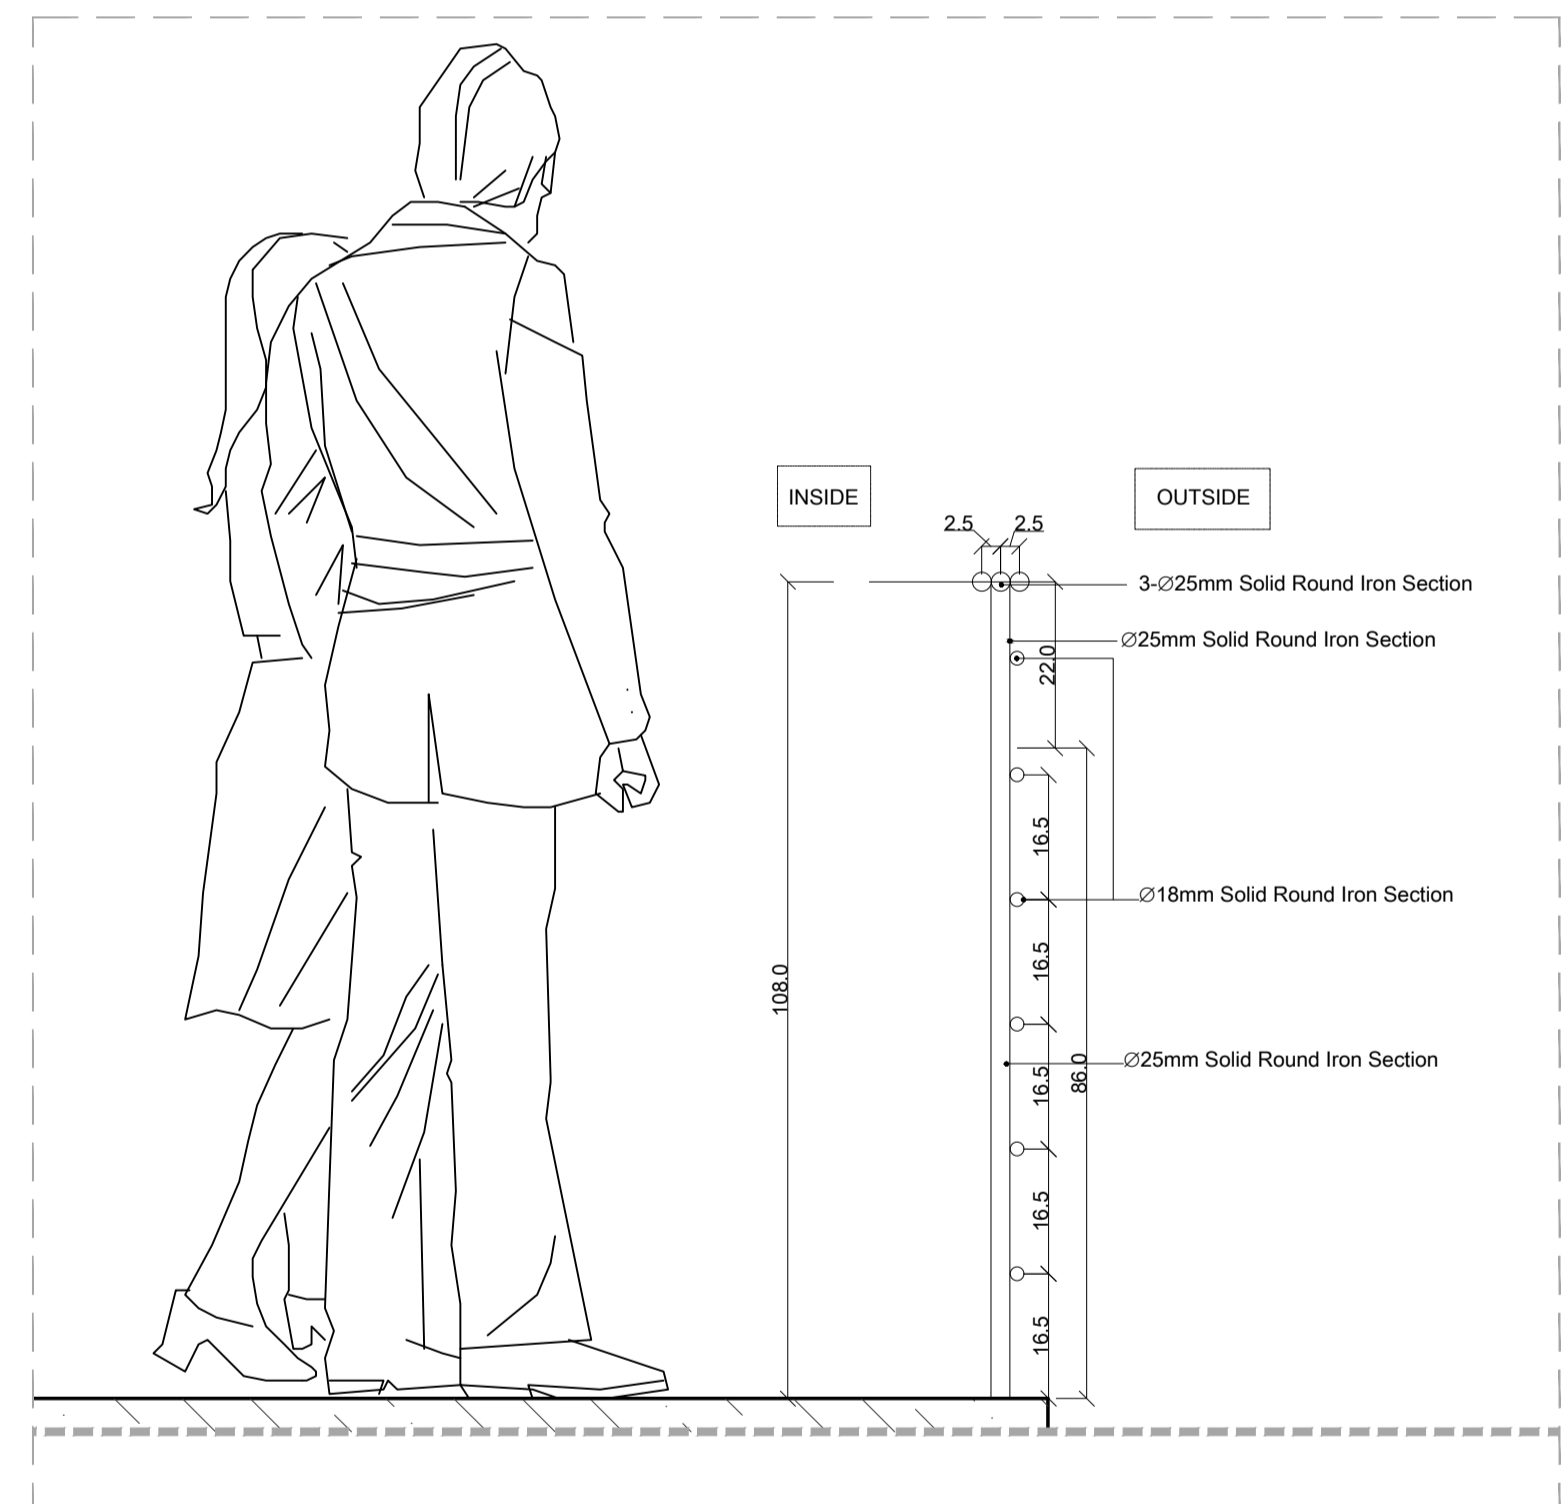


DETAIL 10 RAILING STAIRS DETAIL - SECTION - A
SCALE:1-10

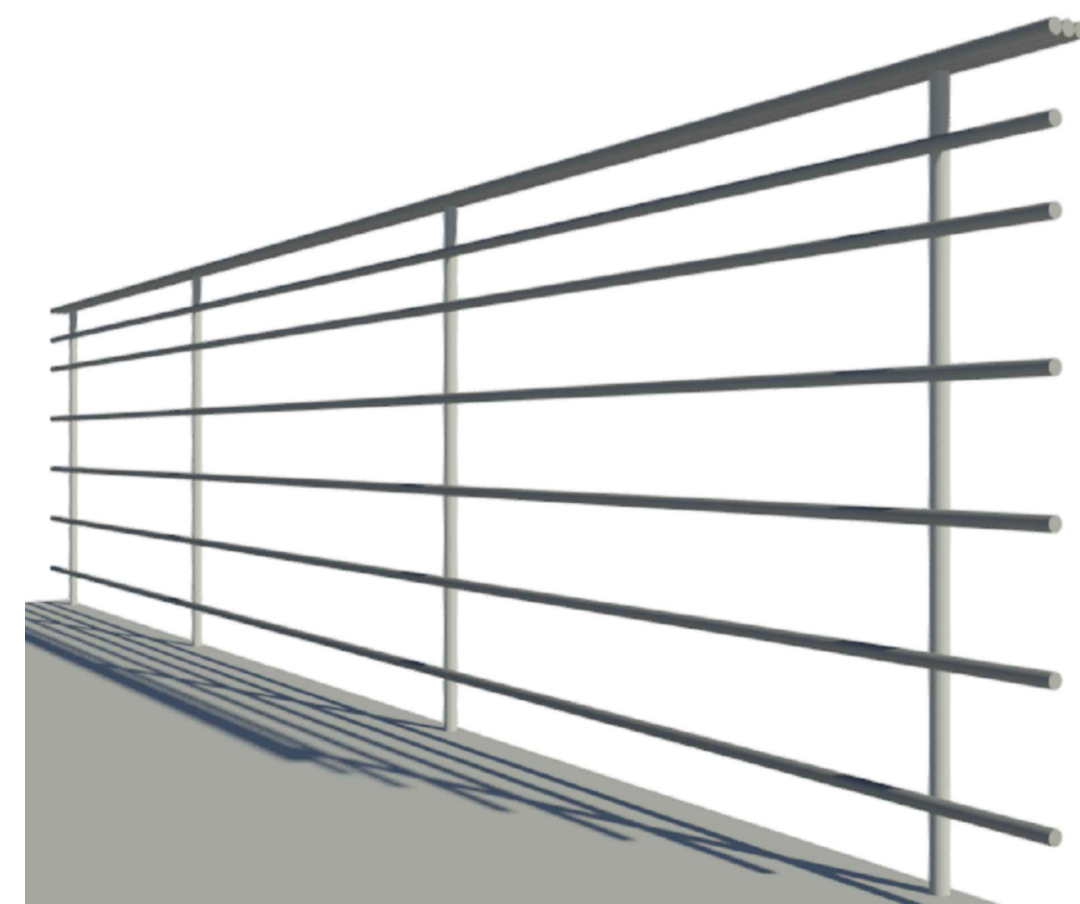


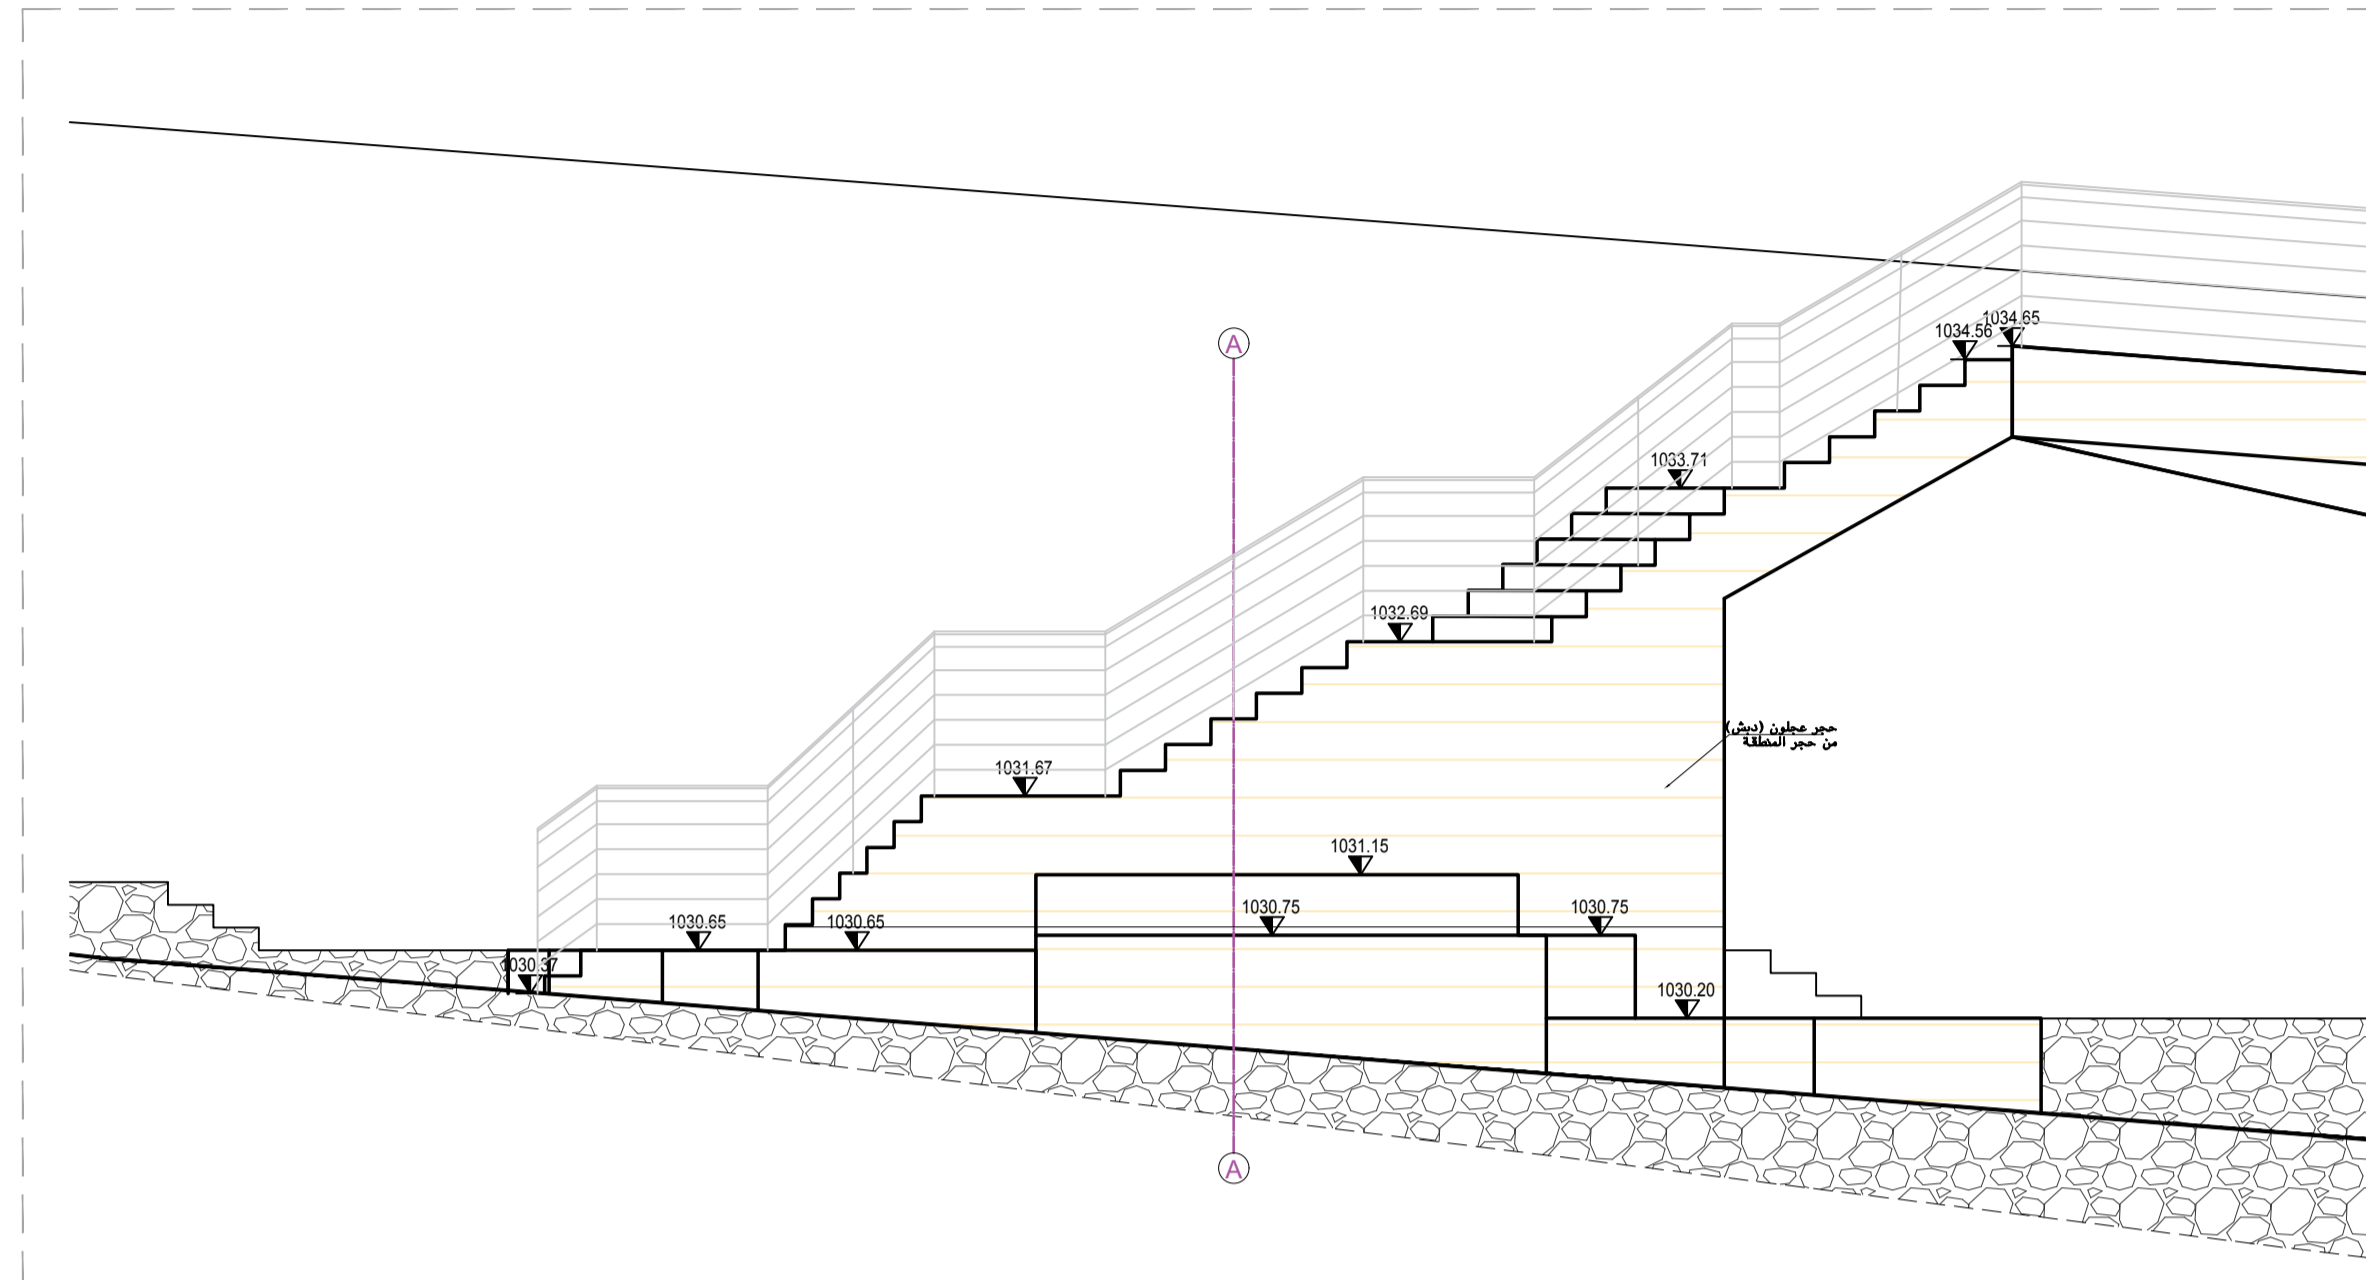


STAIRS 04-ELEVATION 1
SCALE:1-50

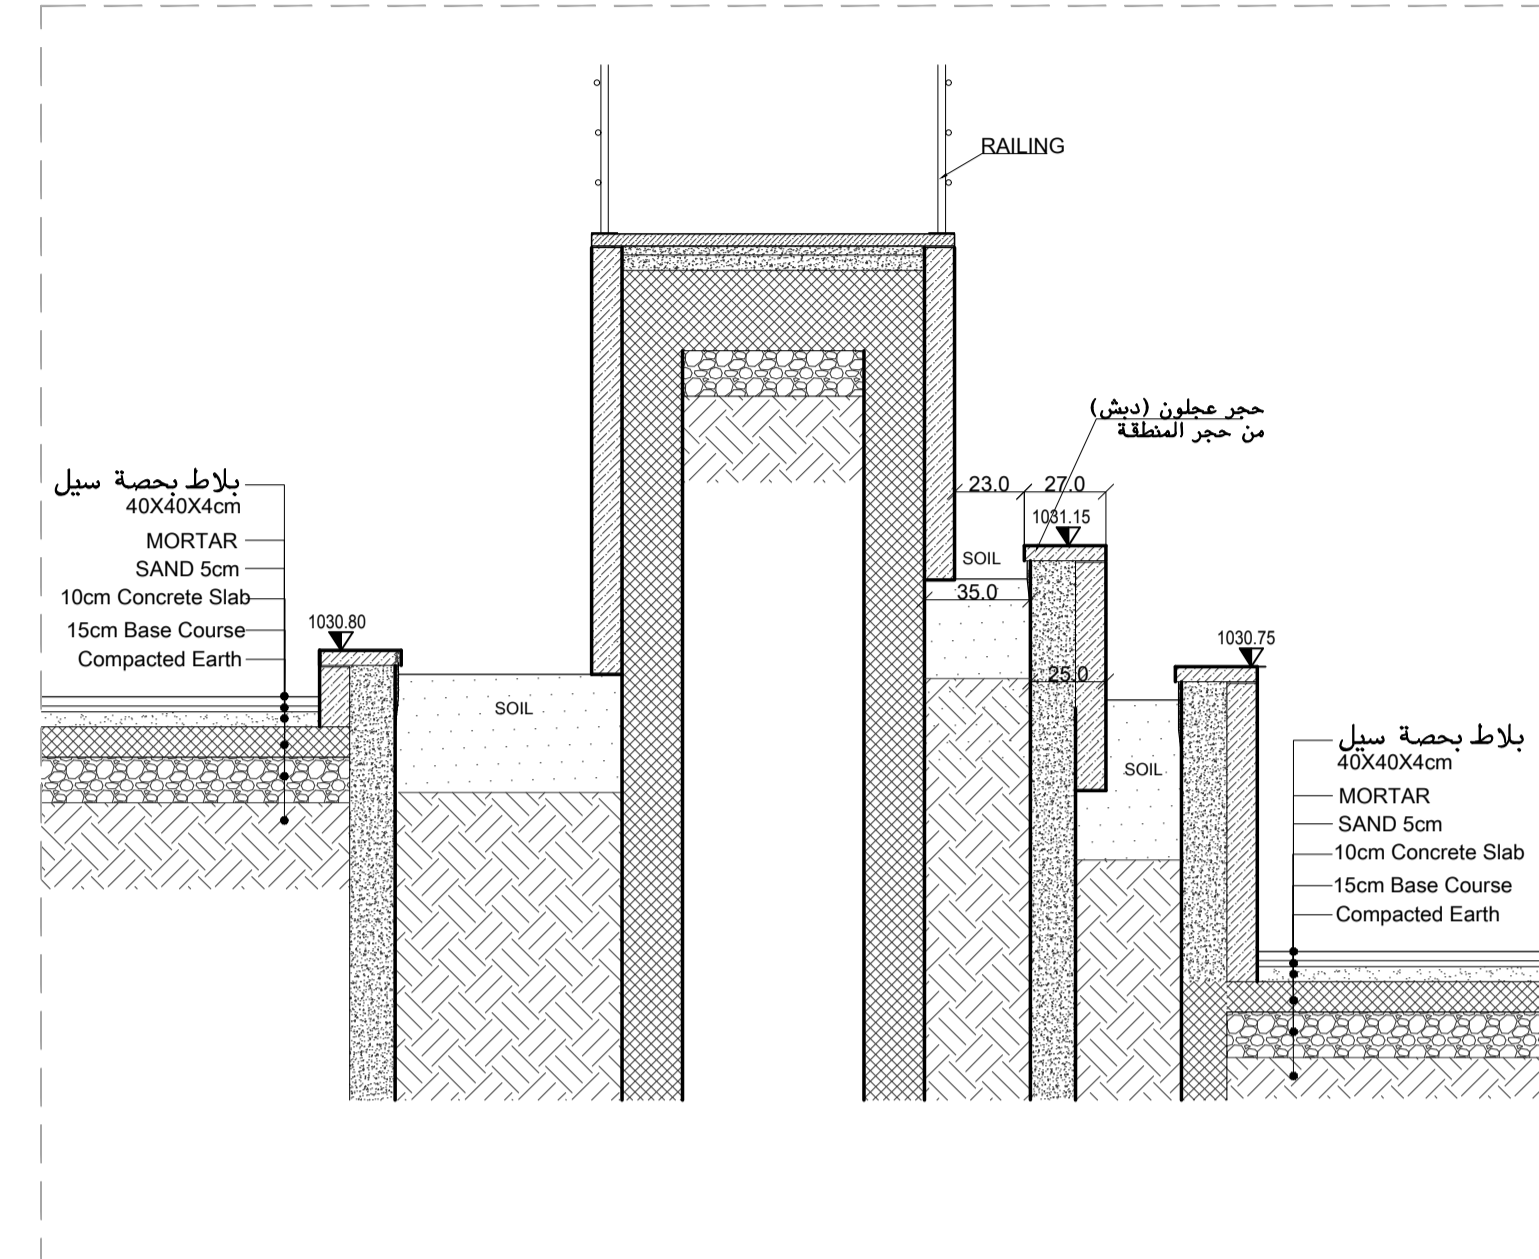


STAIRS 04-SECTION A-A
SCALE:1-25

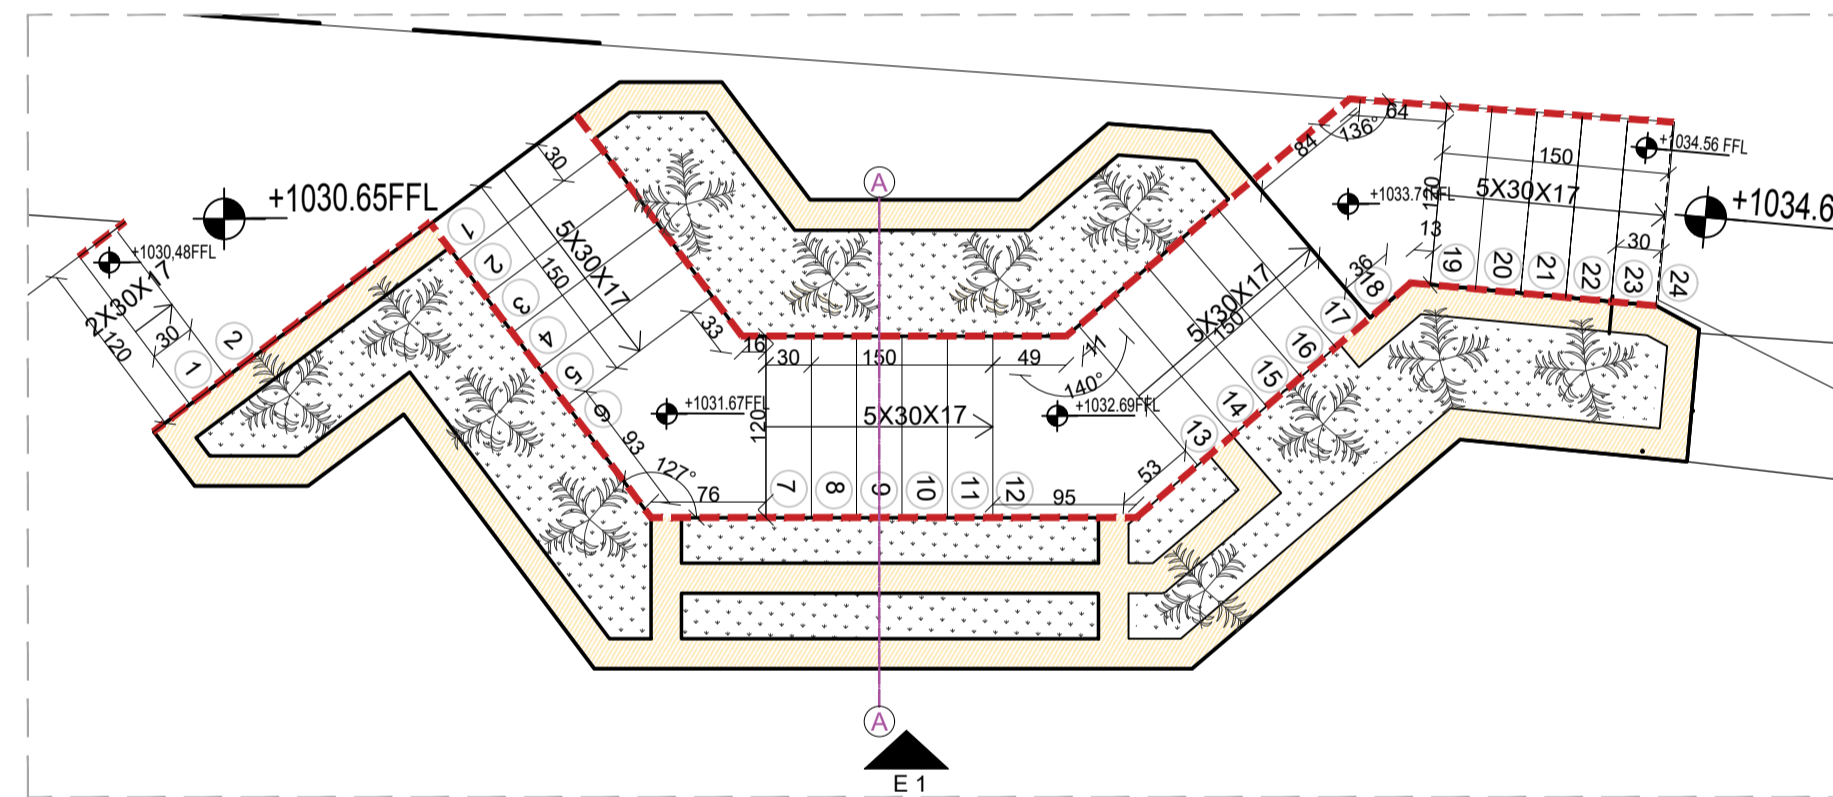


STAIRS 04-TOP VIEW
SCALE:1-50

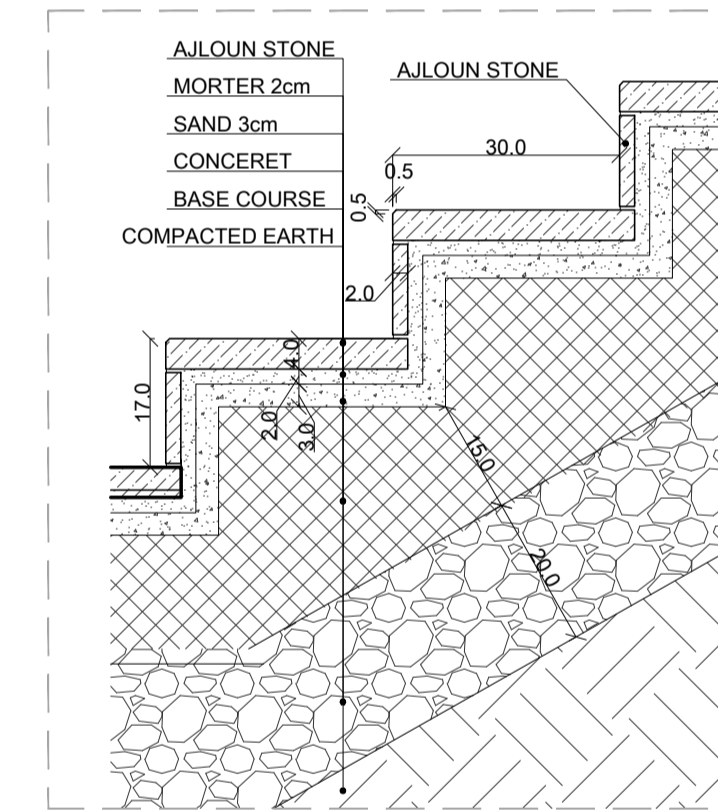


STAIRS 04-DETAIL 01
SCALE:1-10

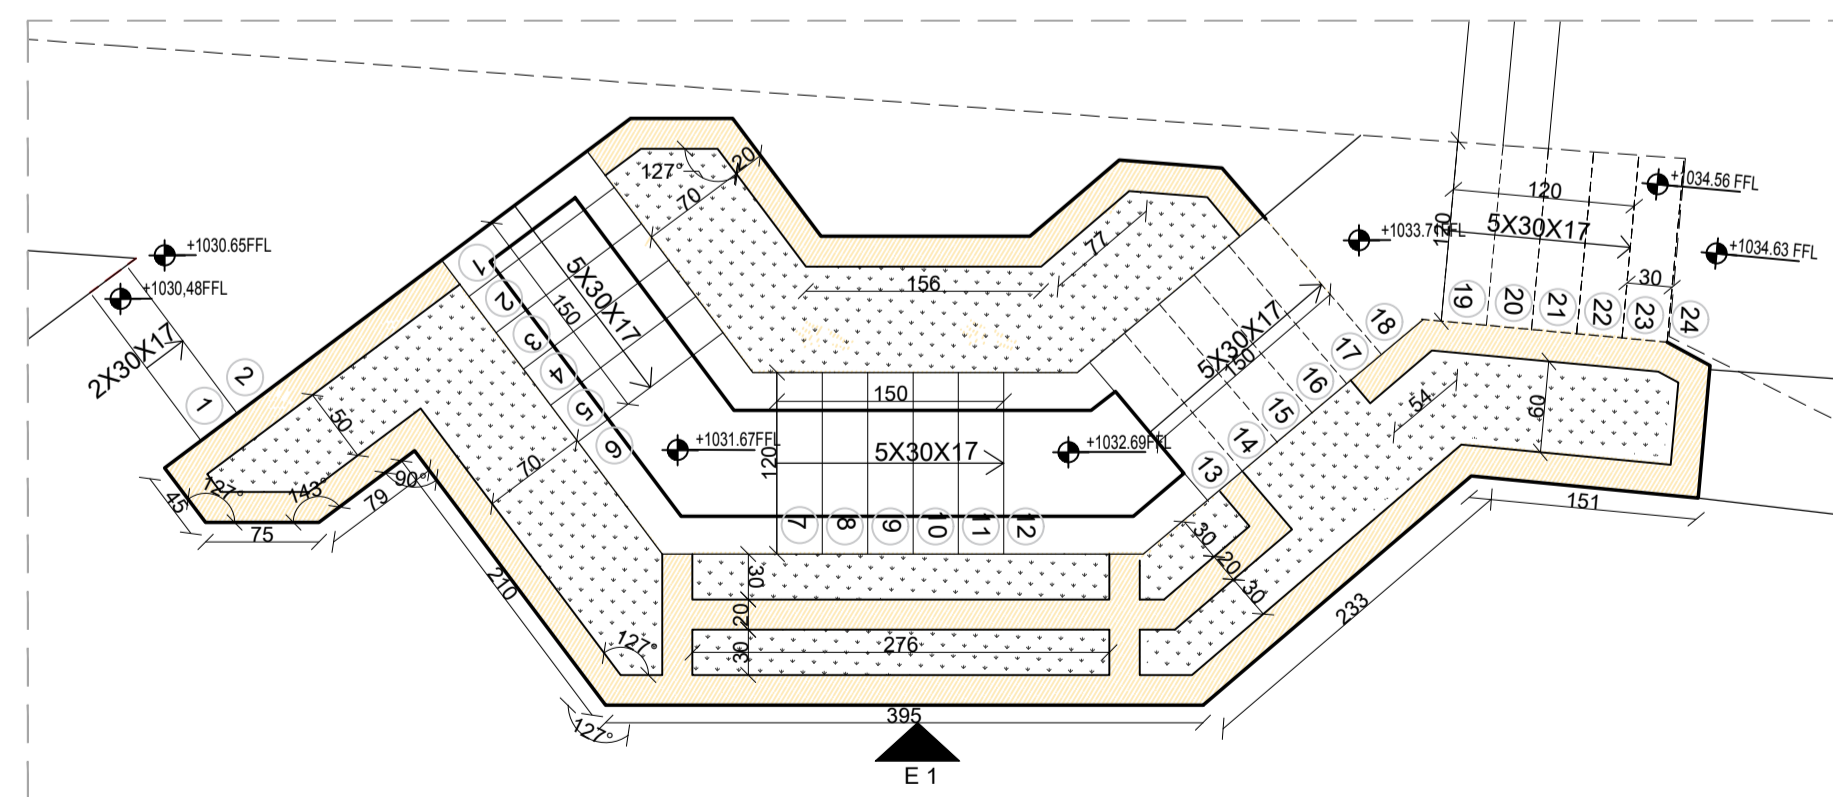


STAIRS 04-PLAN VIEW
SCALE:1-50

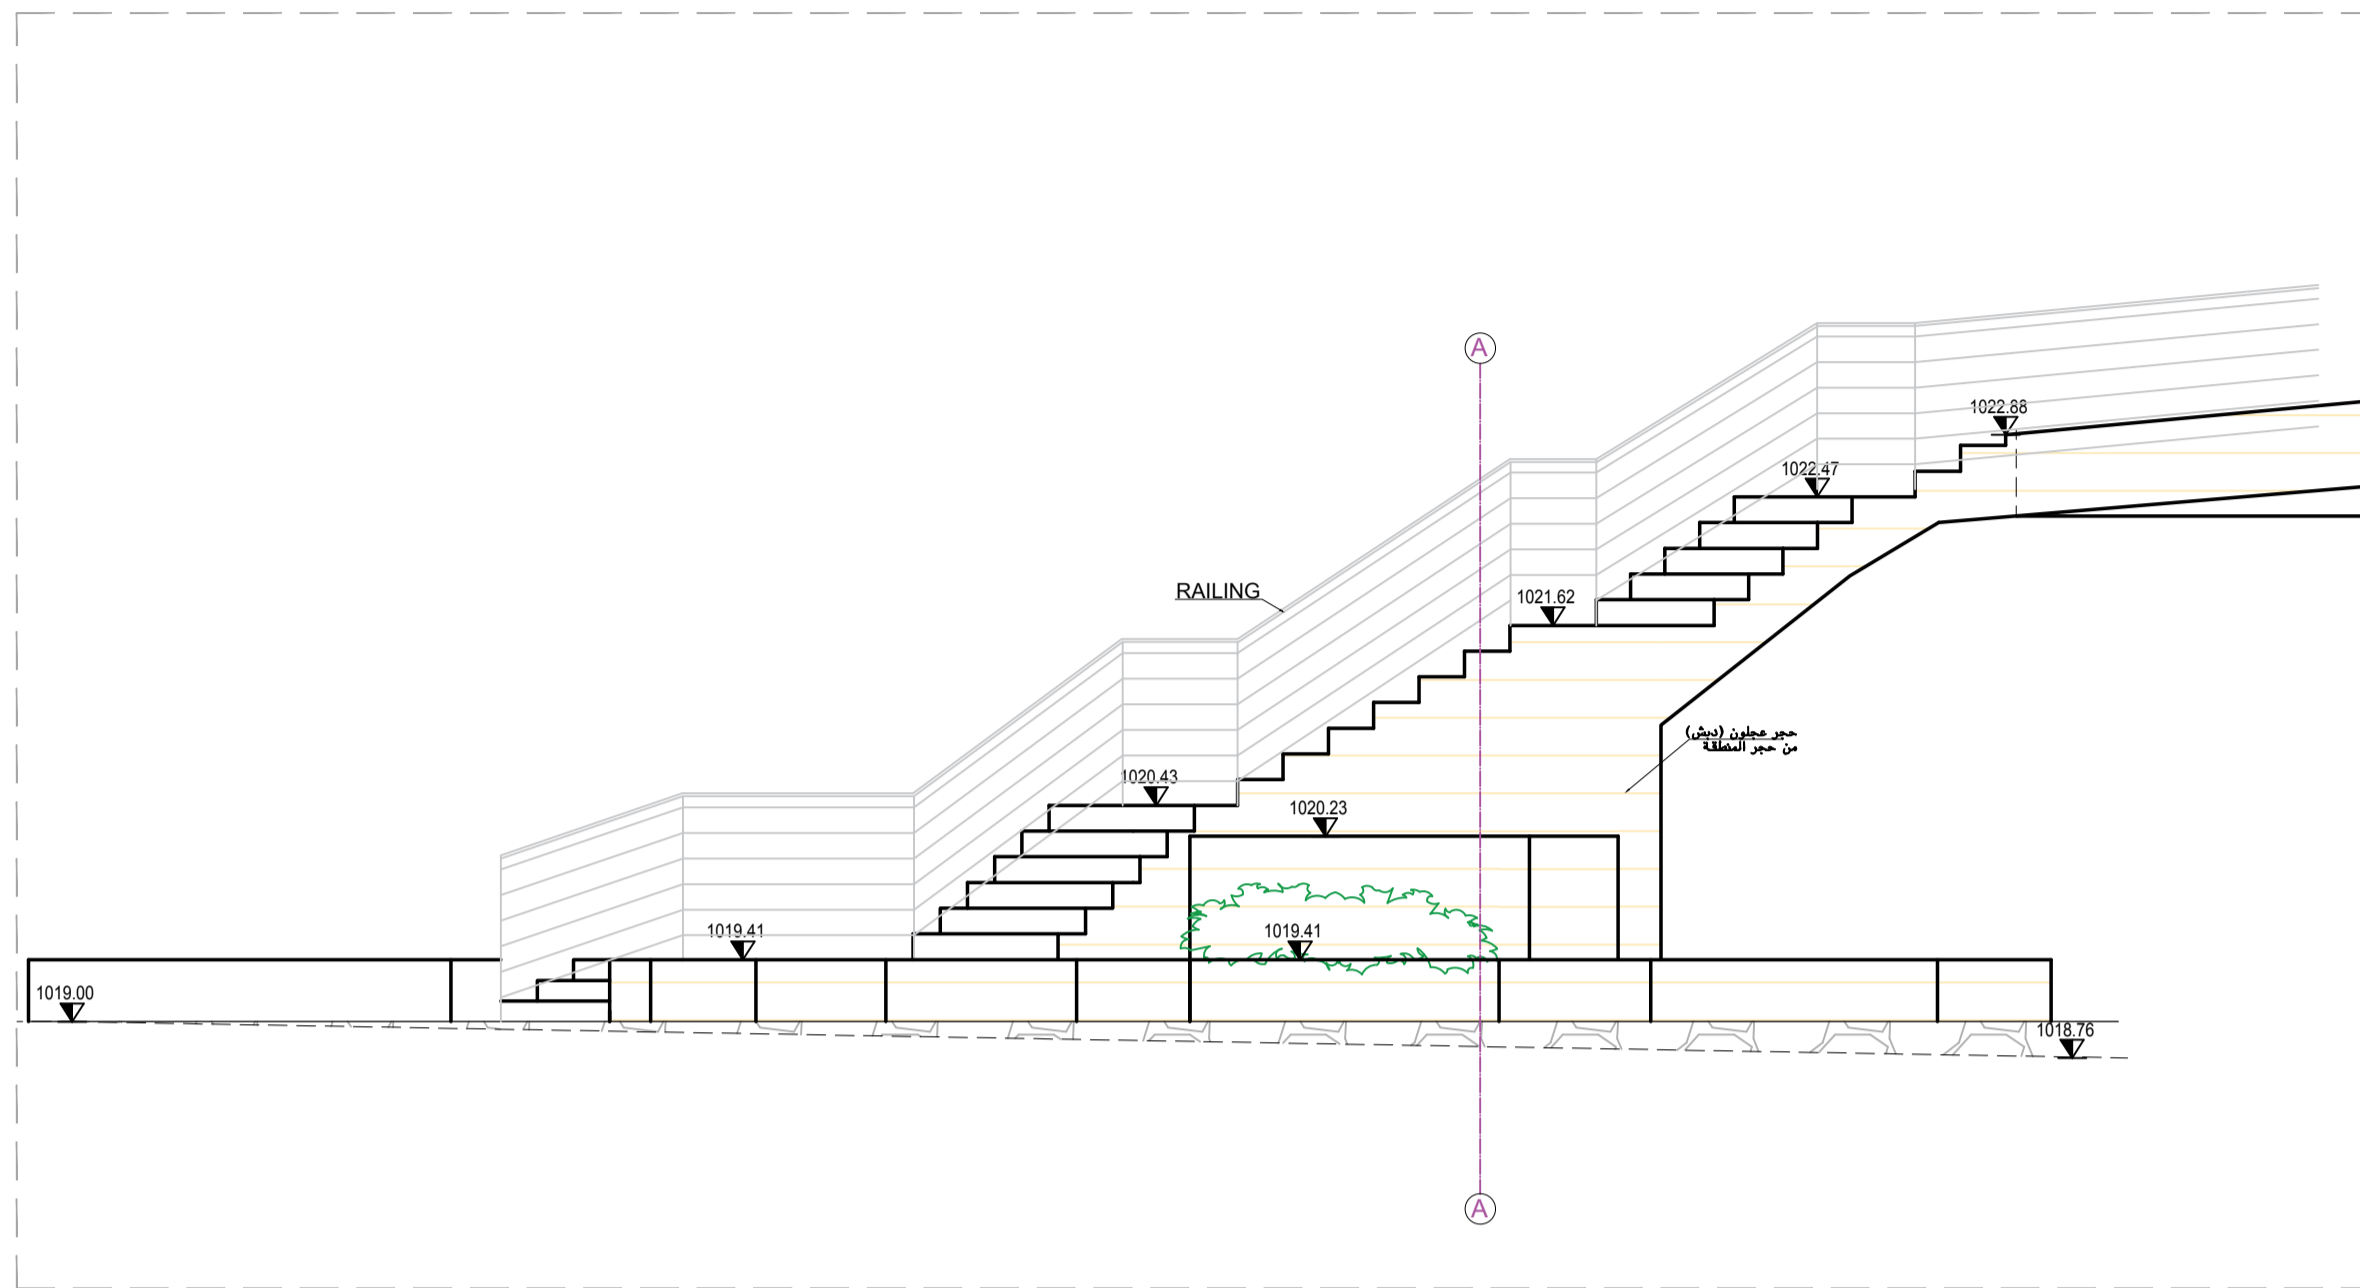


STAIRS 05-ELEVATION 1
SCALE:1-50

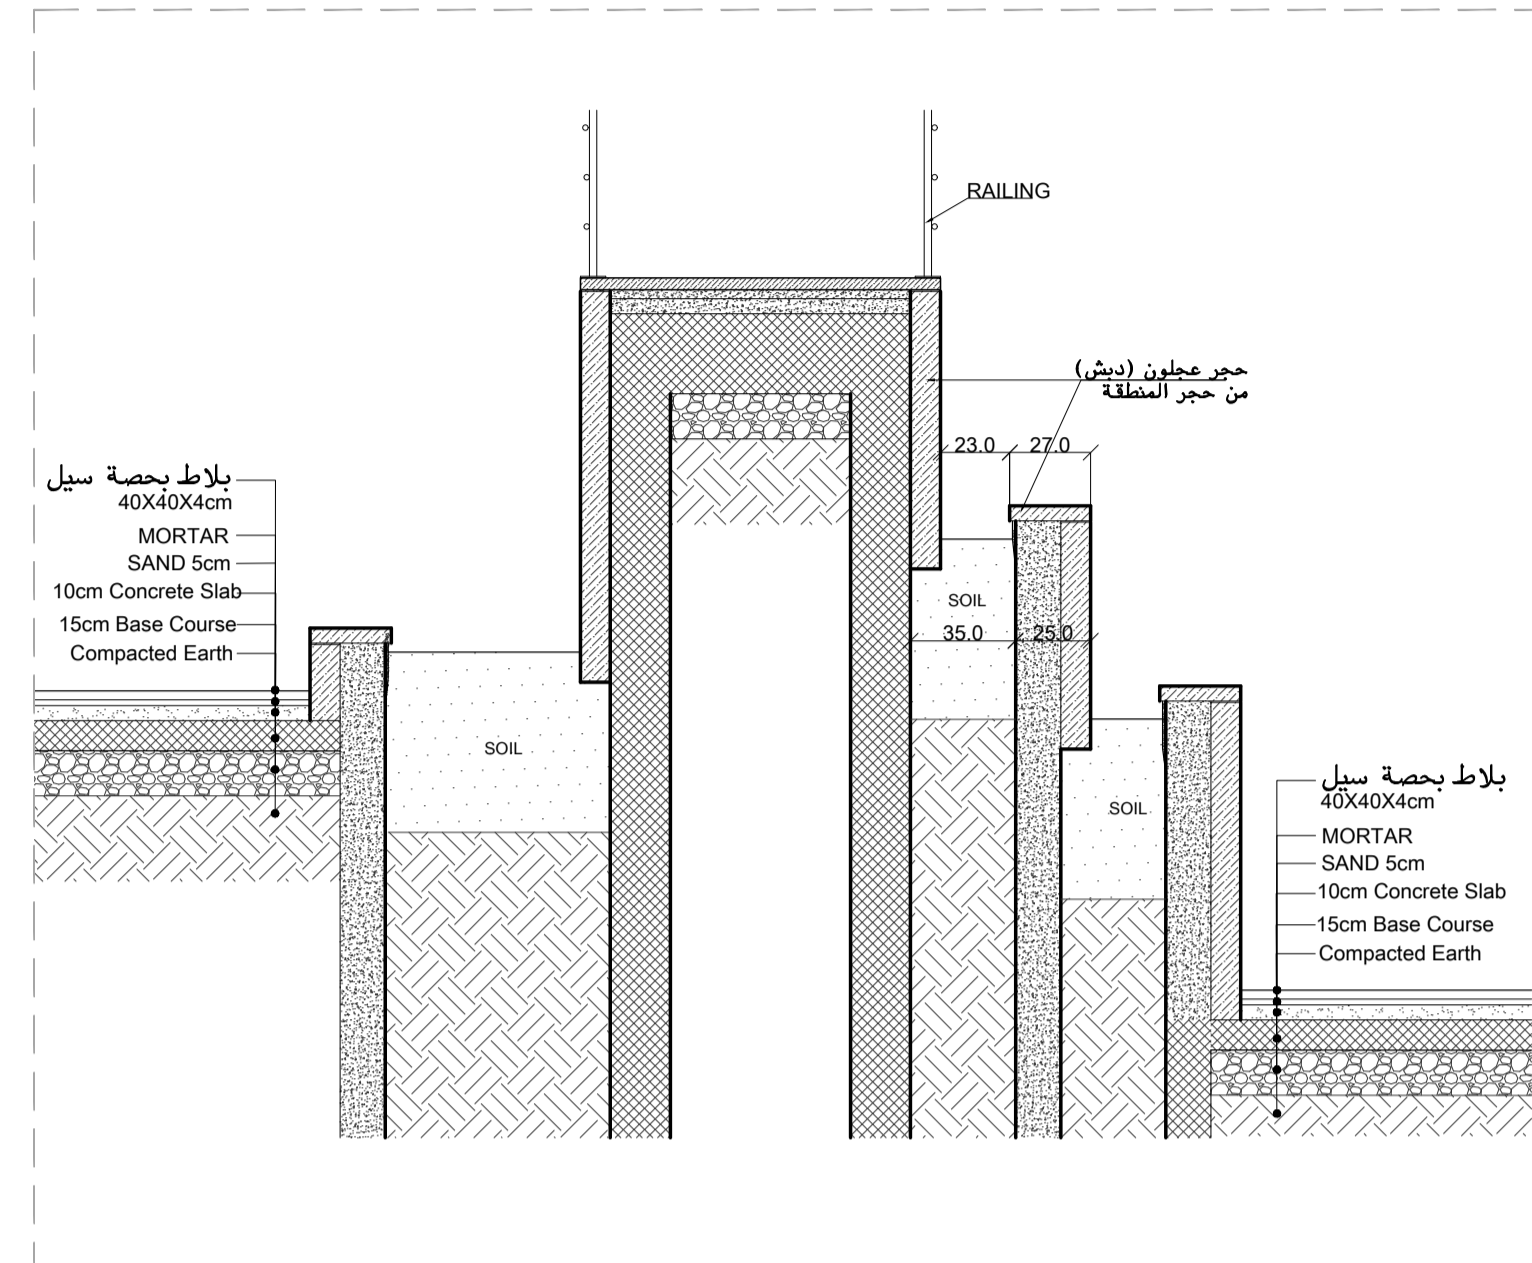


STAIRS 05-SECTION A-A
SCALE:1-25

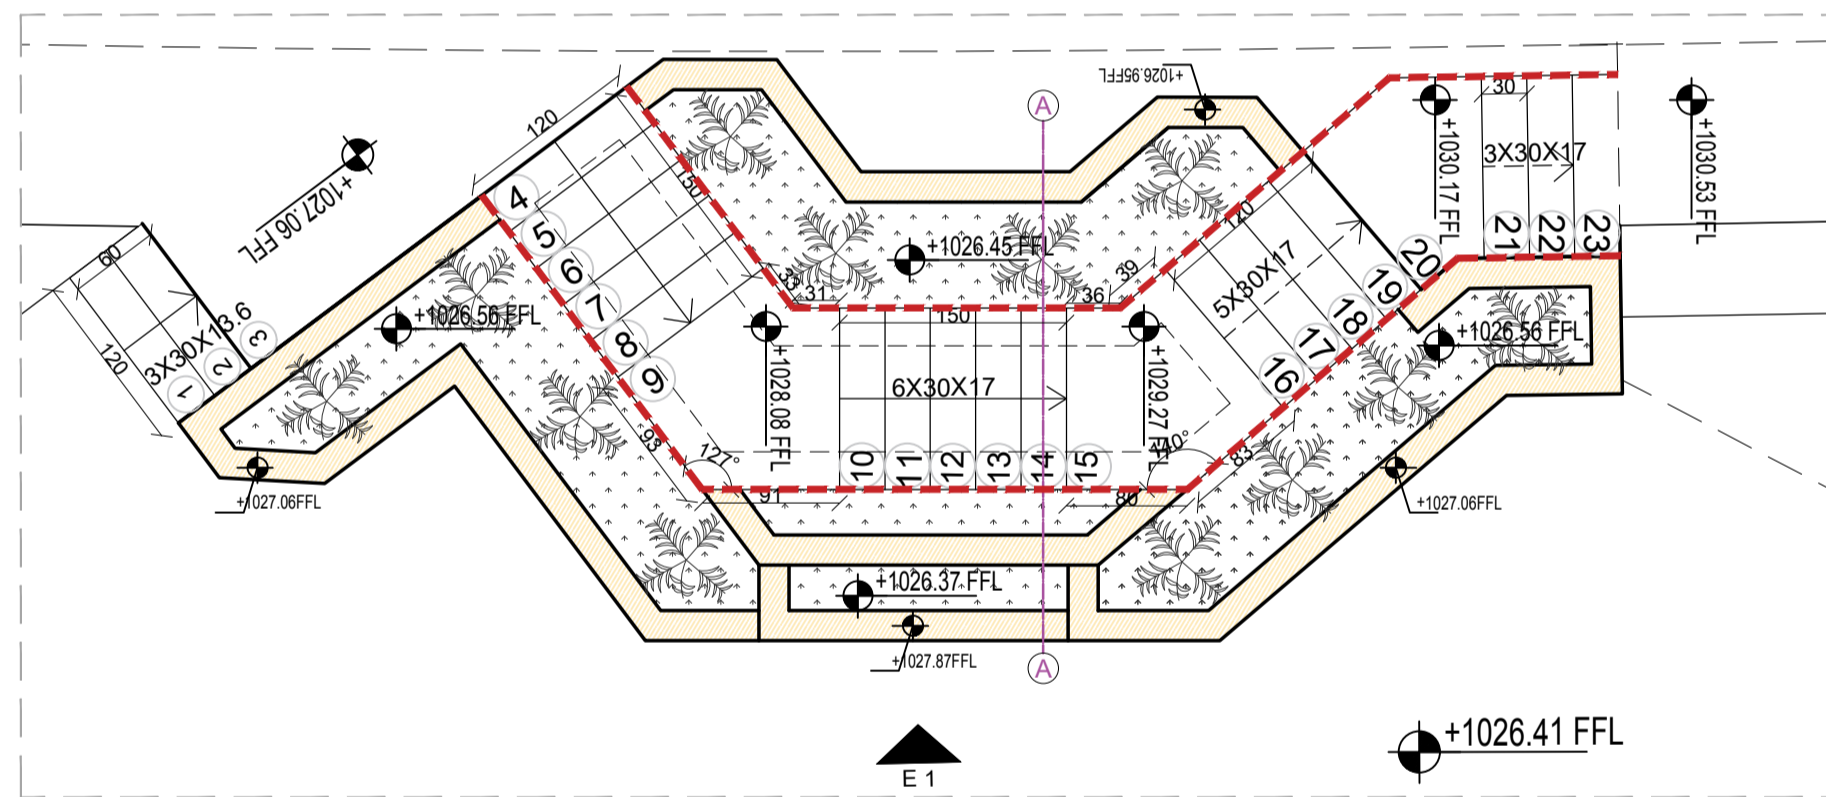


STAIRS 05-TOP VIEW
SCALE:1-50

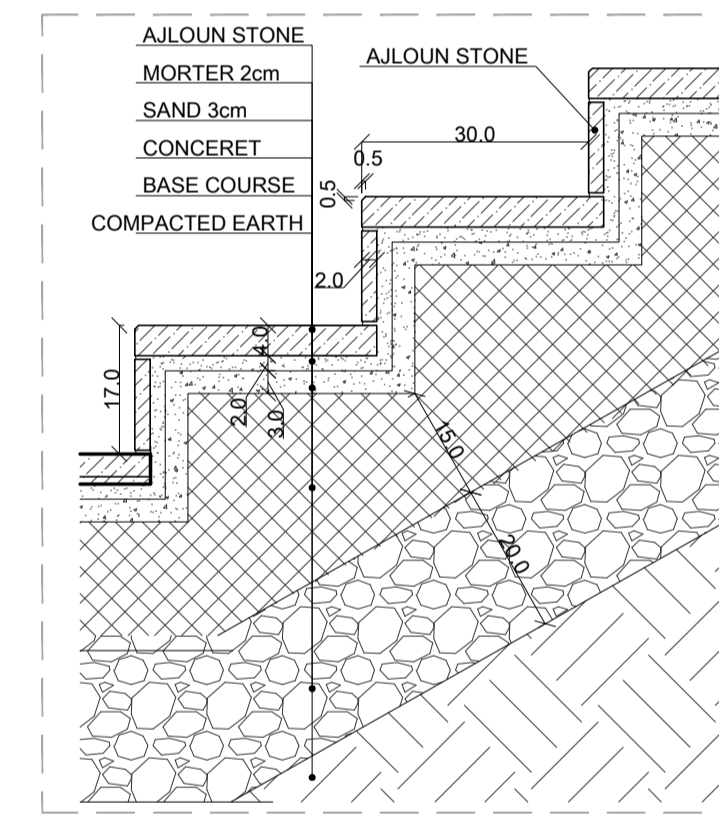


STAIRS 05-DETAIL 01
SCALE:1-10

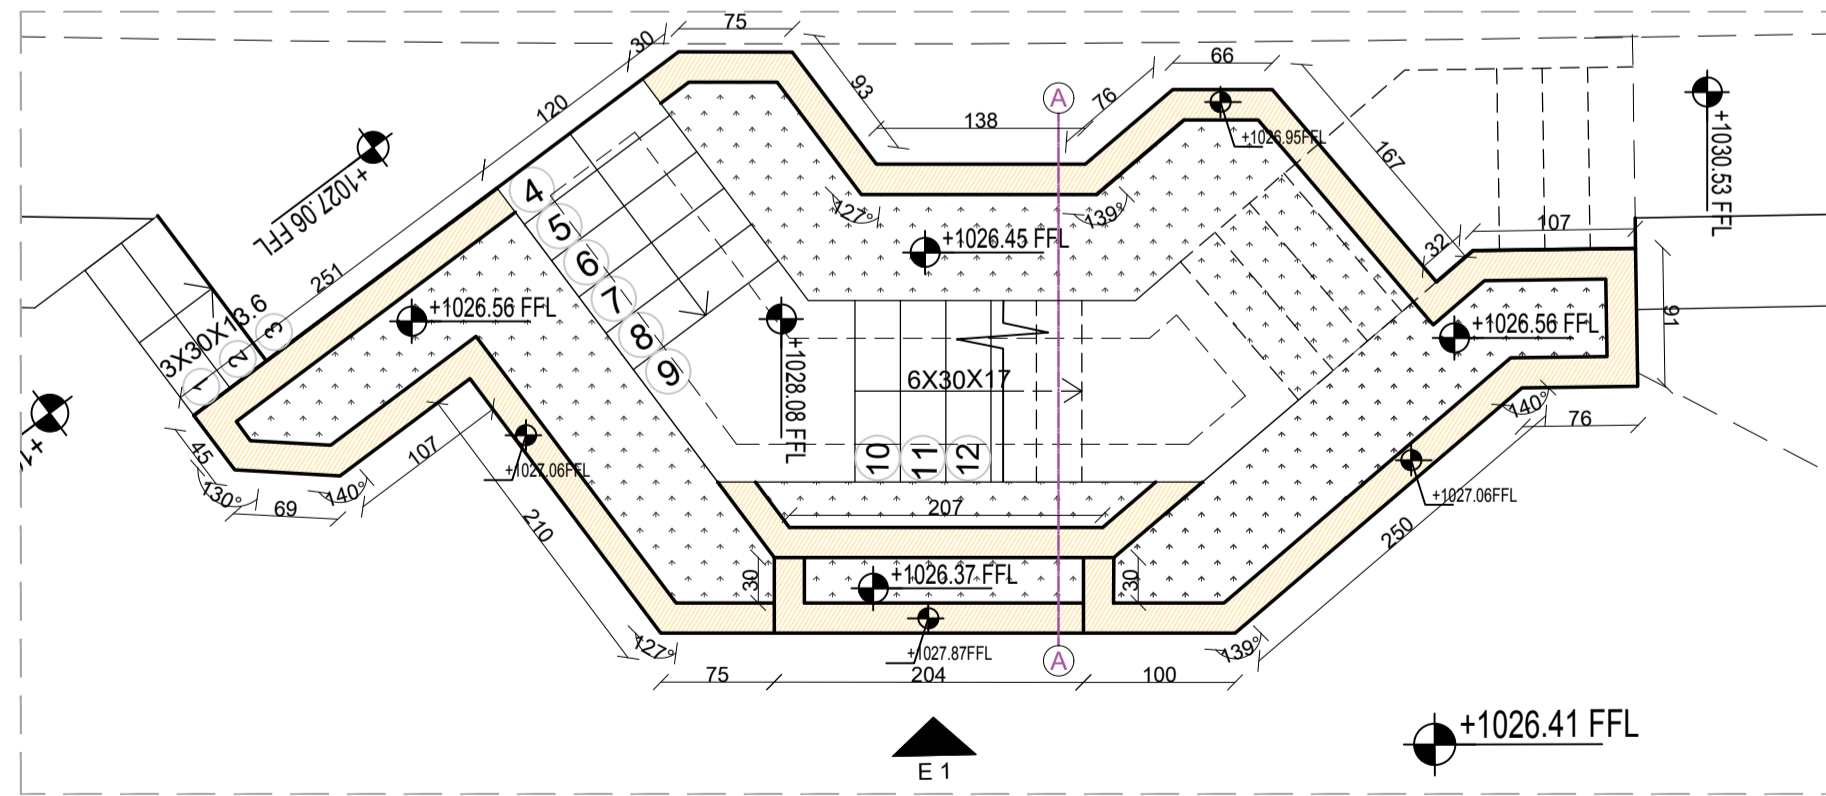


STAIRS 05-PLAN VIEW
SCALE:1-50

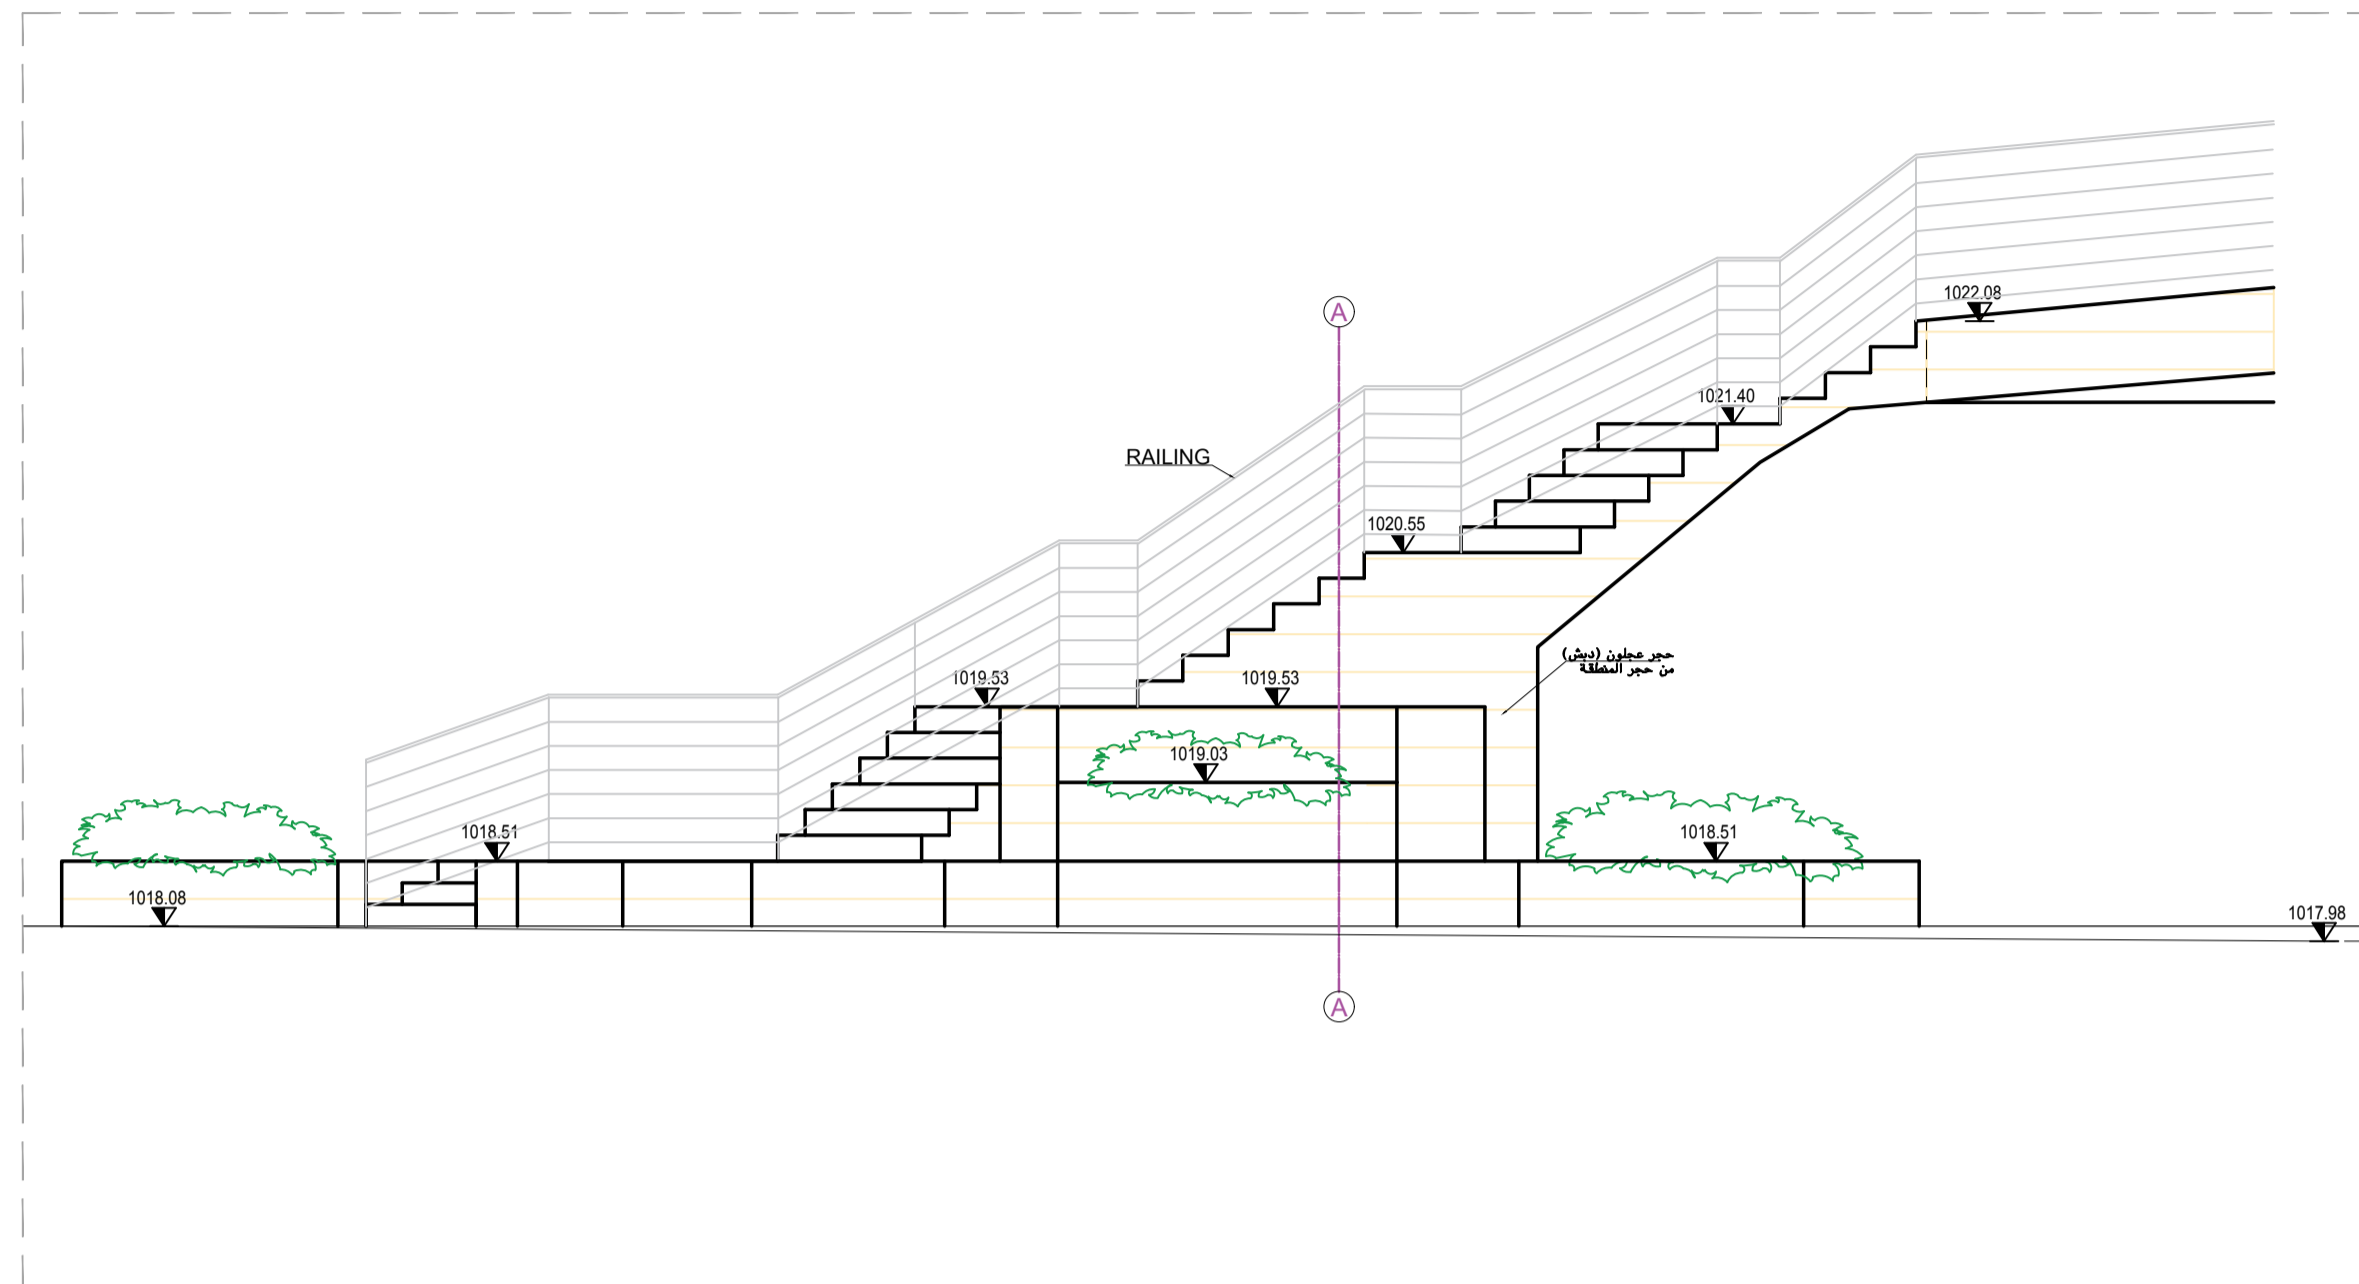


STAIRS 06-ELEVATION 1
SCALE:1-50

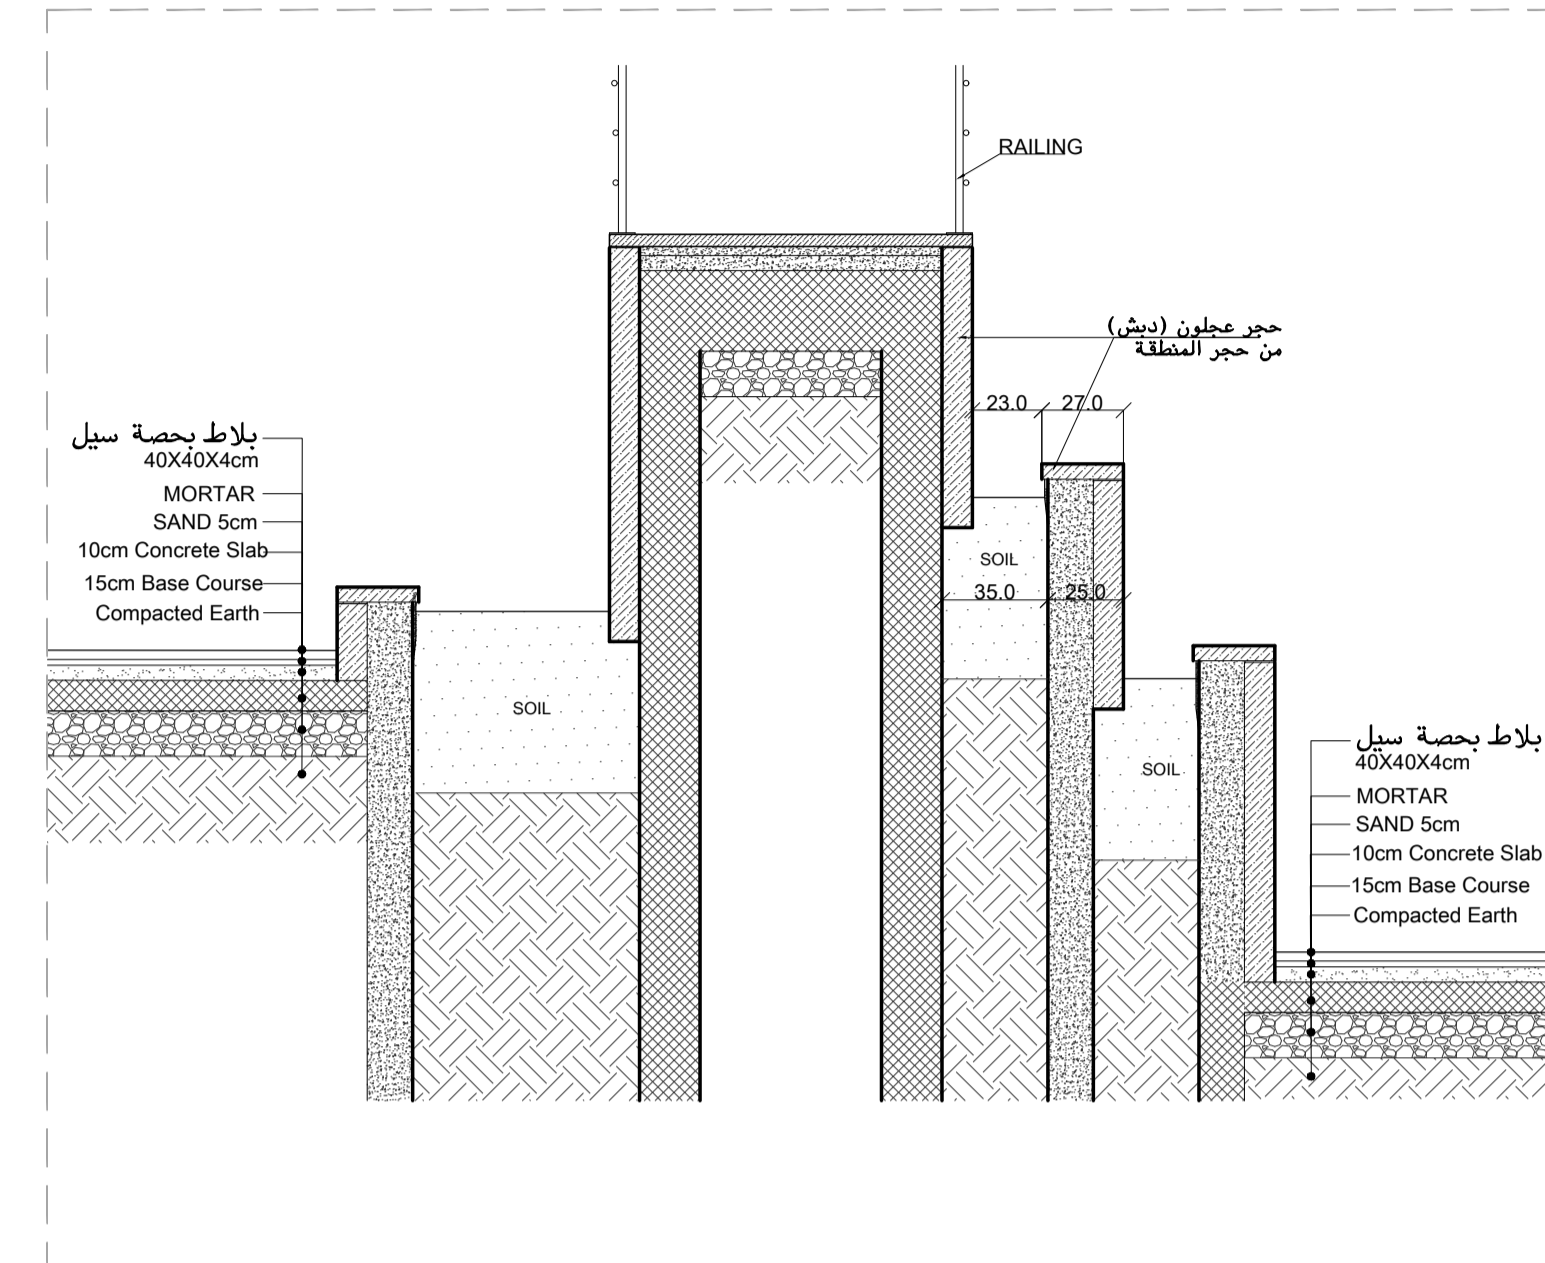


STAIRS 06-SECTION A-A
SCALE:1-25

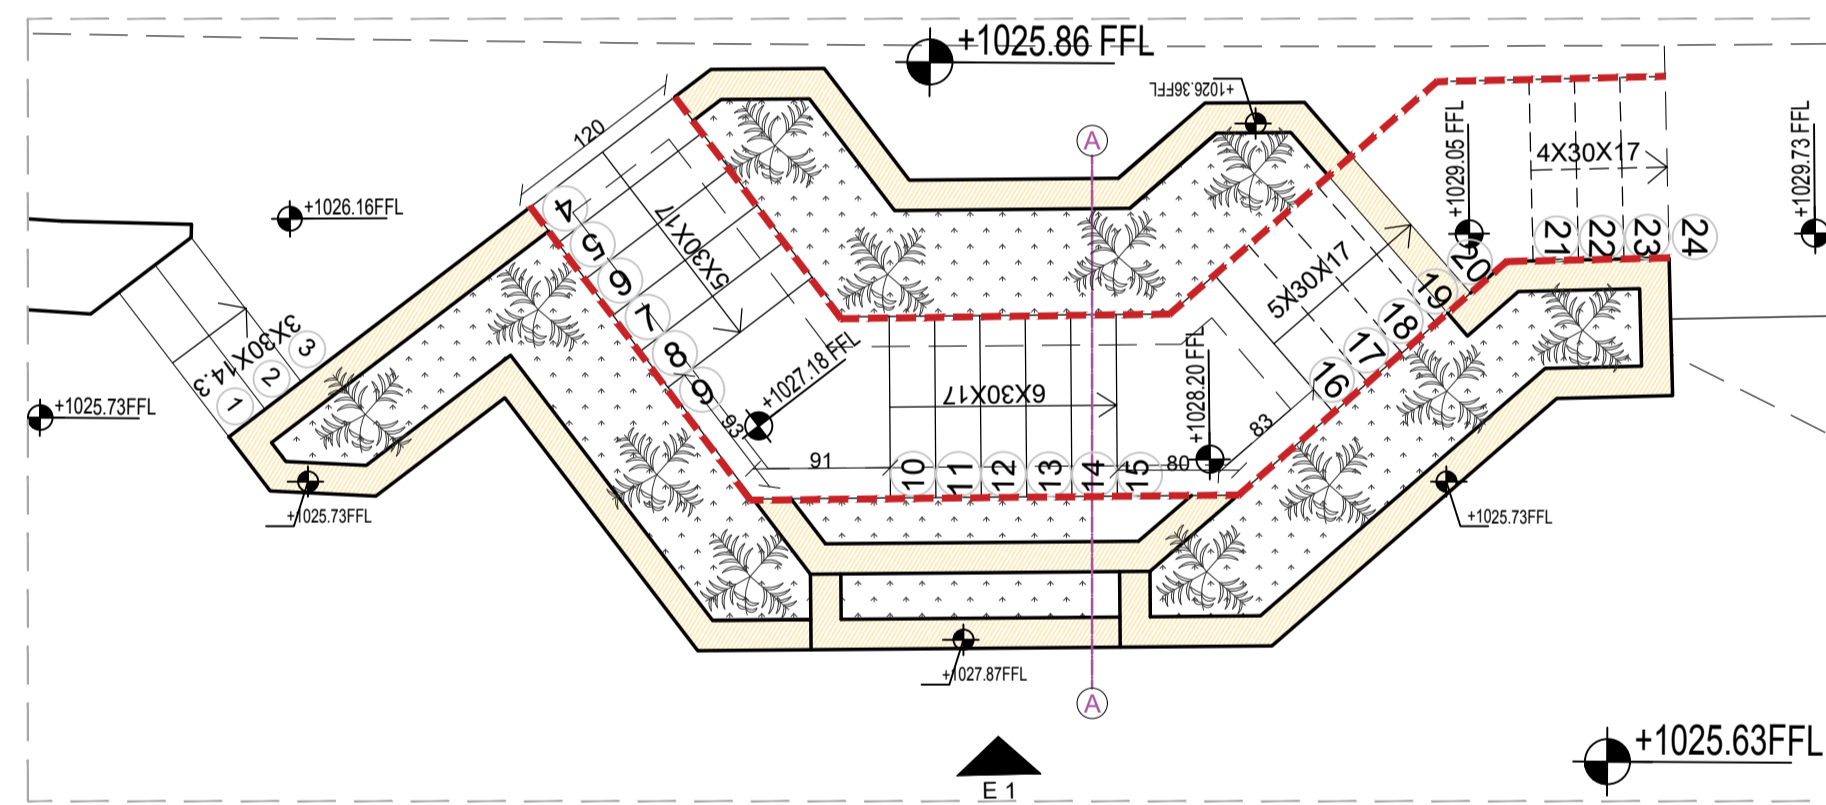

STAIRS 06-TOP VIEW
SCALE:1-50

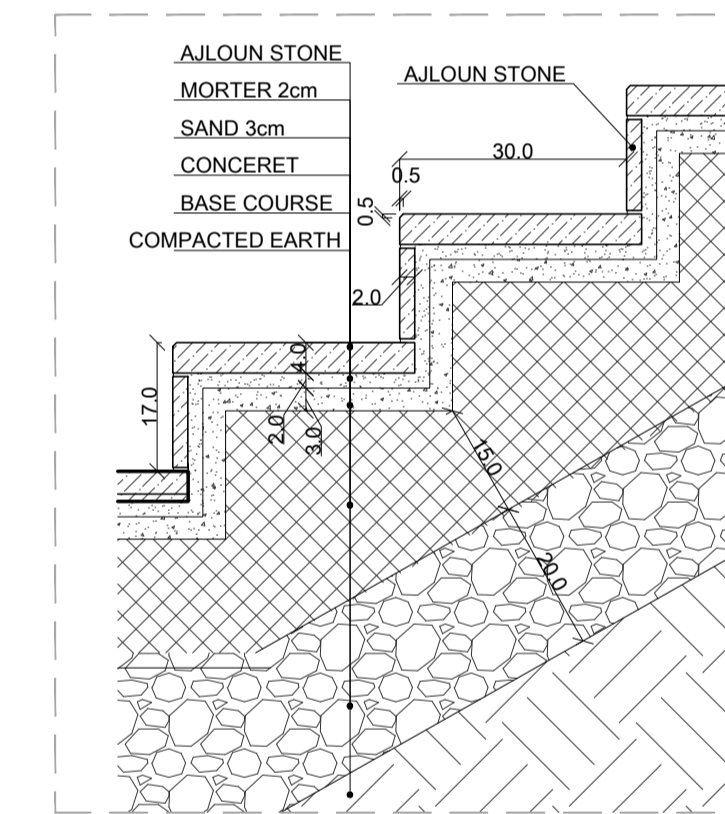

STAIRS 04-DETAIL 01
SCALE:1-10

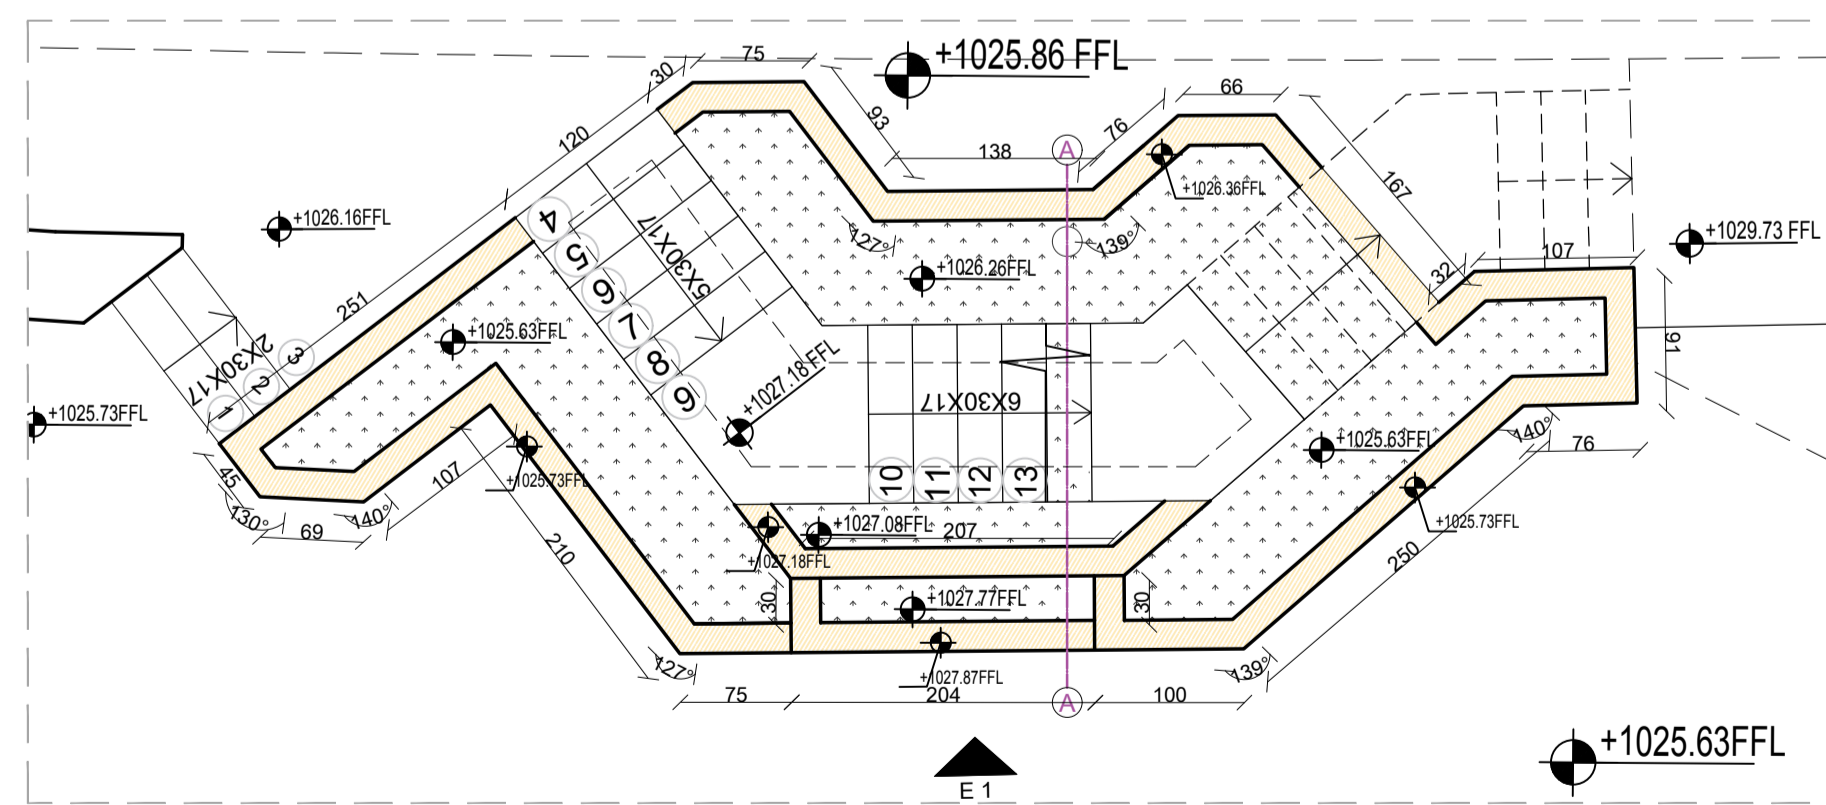

STAIRS 06-PLAN VIEW
SCALE:1-50