
 
 


# Plaza & PARKING



DEMOLITION KEY	
DEMOLITION OF THE WALL	
DEMOLITION TO THE APPROPRIATE LEVEL OF THE WALL	
DEMOLITION - PAVEMENT	

**KHAMMASH ARCHITECTS**  
 P.O. Box 921474, Amman - 11192, Jordan. Tel: +962 6 5695134, Fax: +962 6 5622366  
 E-mail: info@khammash.com

CLIENT  
**Petra Development & Tourism Region Authority**  
 P.O. Box 7693, Amman 11118, Jordan | T +962 6 5055555 | F +962 6 4650639 | W www.pdf.com



PROJECT  
**Road 4**  
 ADDRESS  
**Wadi Musa, JORDAN**

STATUS  
**TENDER**  
 Copyright © Khammash Architects  
 THIS DRAWING IS AND IN ALL TIMES REMAINS THE EXCLUSIVE PROPERTY OF KHAMMASH ARCHITECTS. ALL MEASUREMENTS MUST BE CHECKED BY THE CONTRACTOR ON SITE BEFORE THE COMMENCEMENT OF ANY WORKS.

NOTES

DRAWN	NORTH	SCALE	DRAWING TITLE
CHECKED	APPROVED	1:300 @ A1	<b>DEMOLITION PLAN</b>
ISSUE	DATE	AMENDMENT	SHEET NUMBER
			<b>A-ZB-005</b>
			ISSUE DATE
			<b>Mar.2022</b>

AK

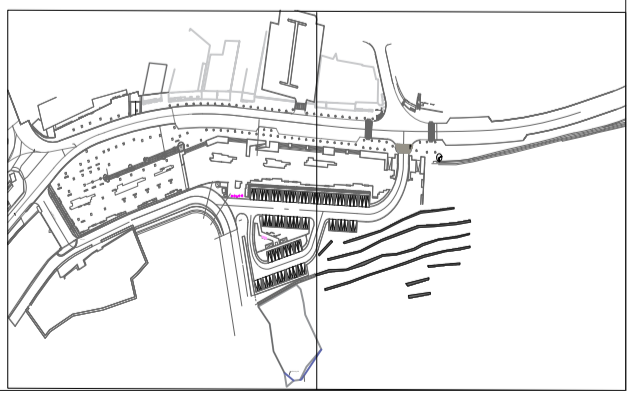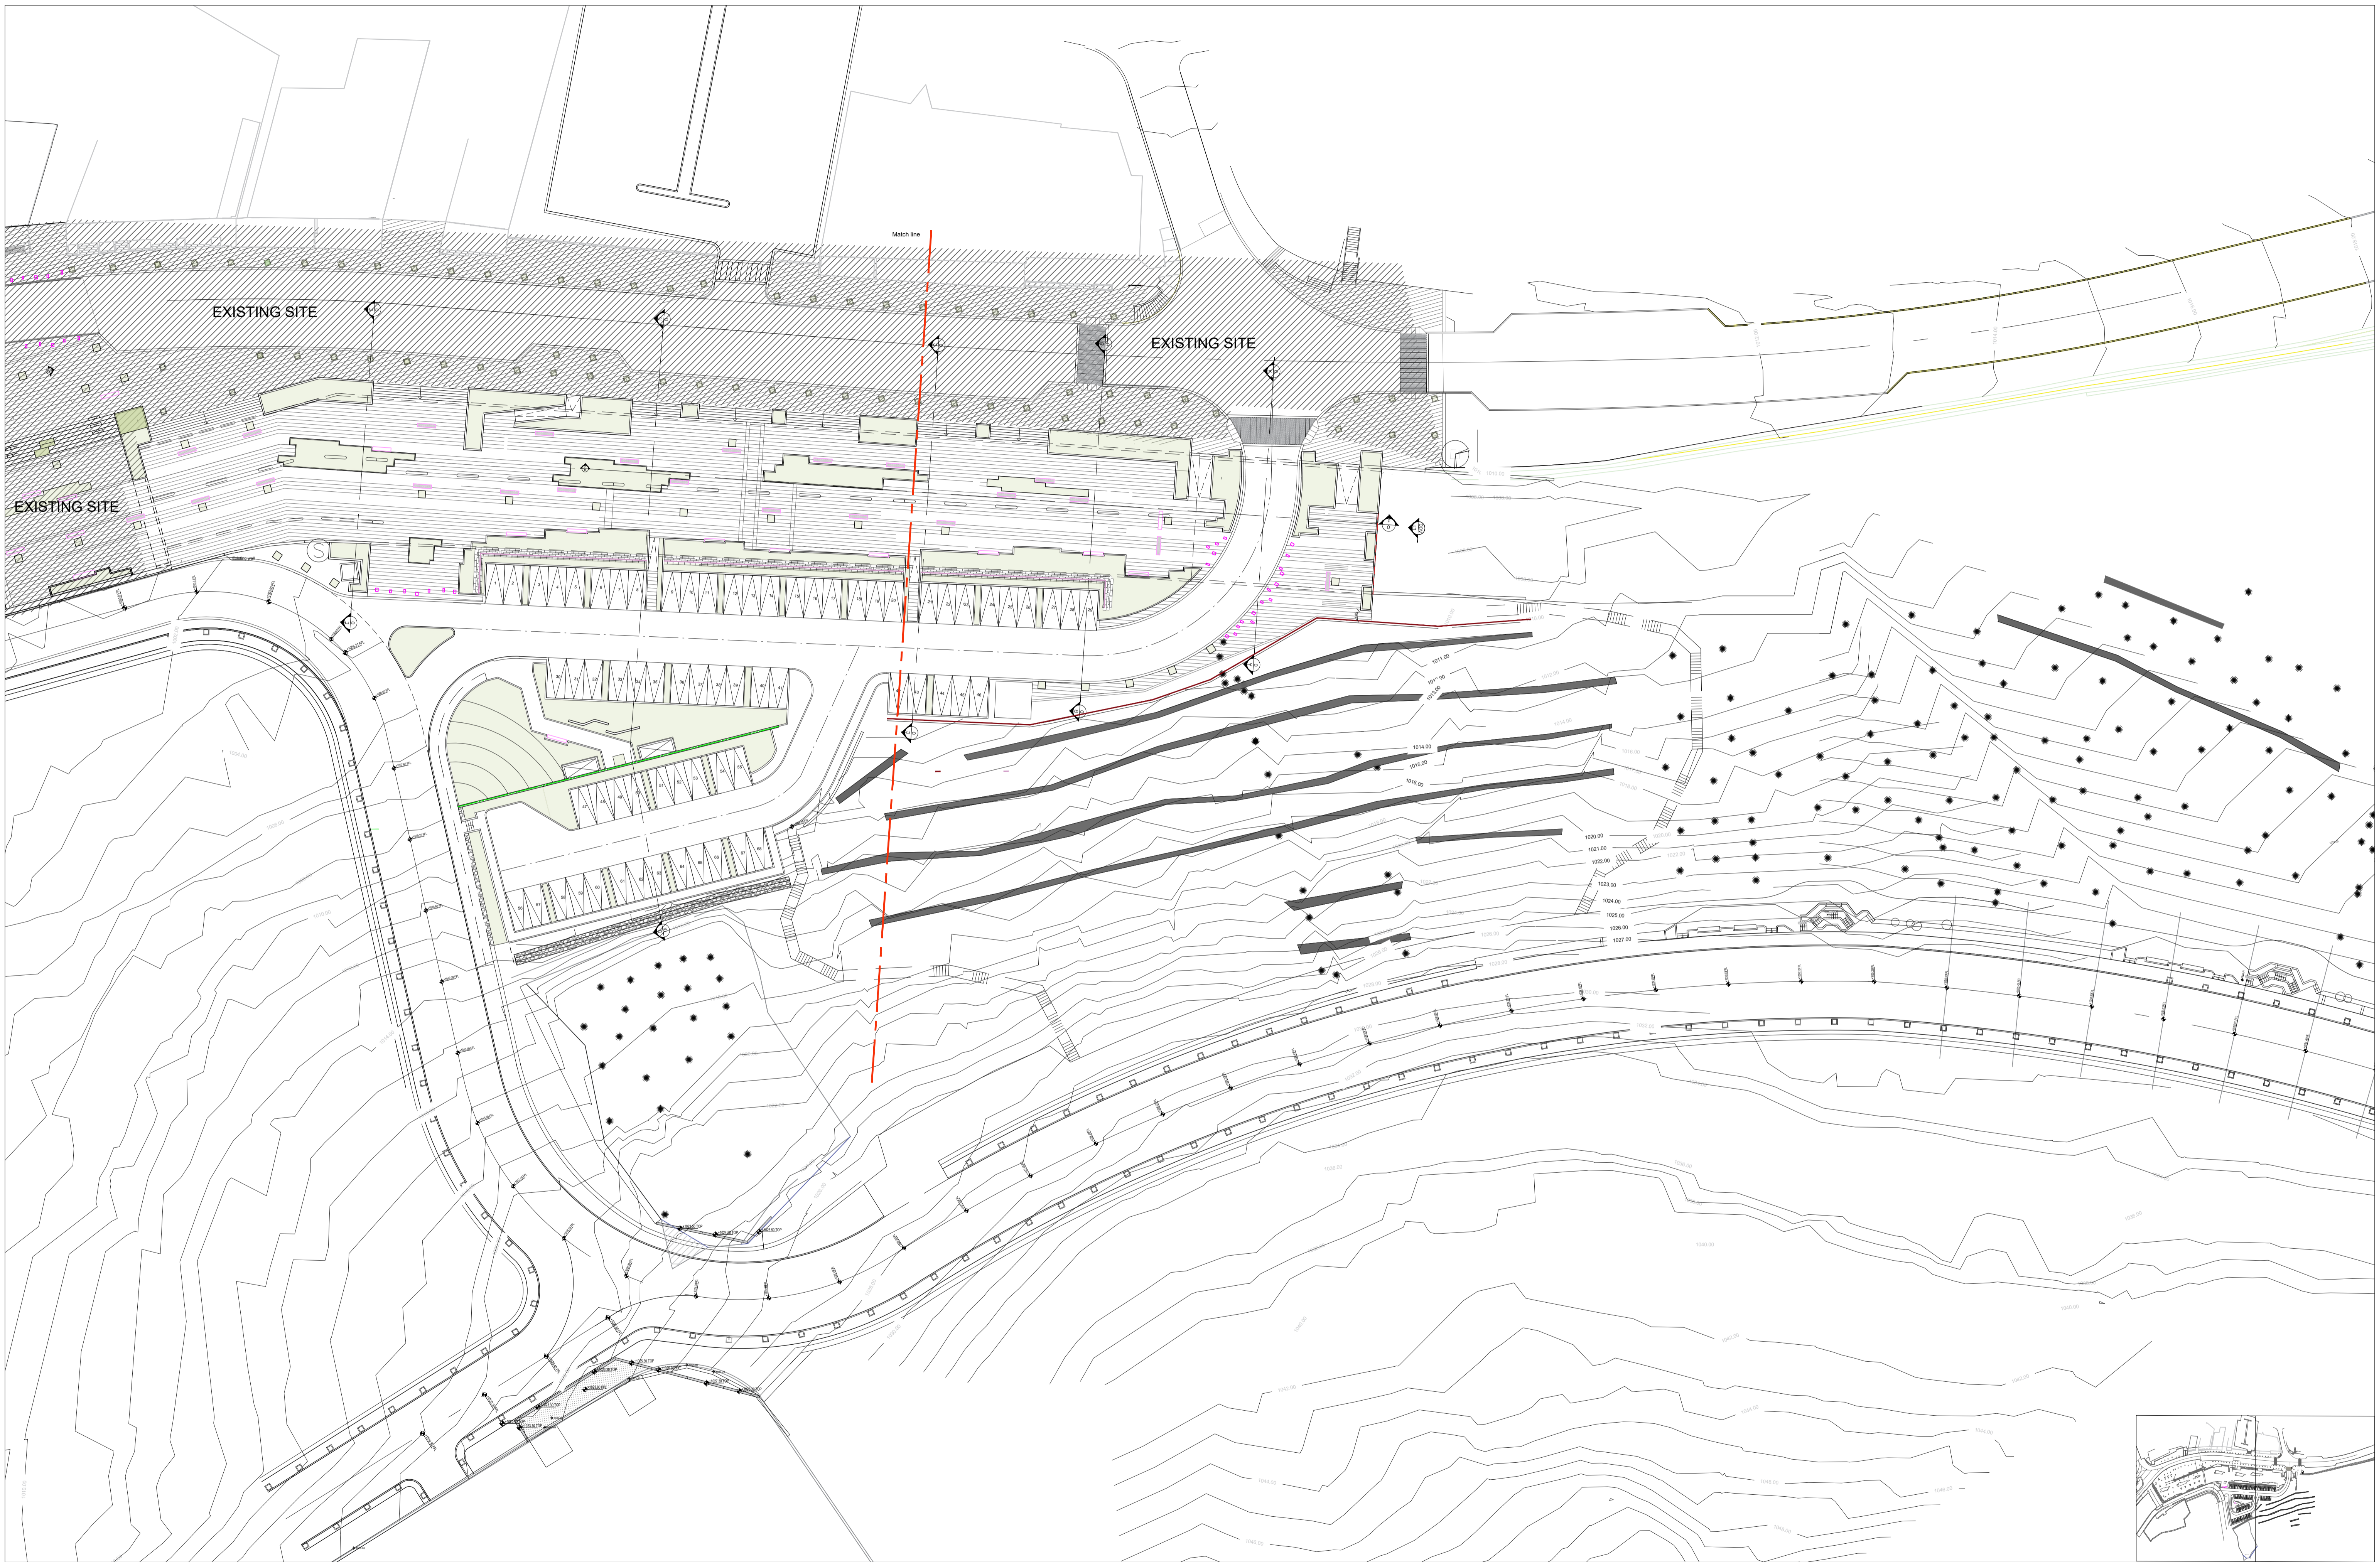

**KHAMMASH ARCHITECTS**

P.O. Box 921474, Amman - 11192, Jordan, Tel: +962 6 5696134, Fax: +962 6 5622366  
E-mail: info@khammash.com

CLIENT

Petra Development & Tourism Region Authority

PROJECT

Road 4

ADDRESS

Wadi Musa, JORDAN

STATUS

TENDER

Copyright © Khammash Architects

THIS DRAWING IS AND IN ALL TIMES REMAINS THE EXCLUSIVE PROPERTY OF KHAMMASH ARCHITECTS. ALL MEASUREMENTS MUST BE CHECKED BY THE CONTRACTOR ON SITE BEFORE THE COMMENCEMENT OF ANY WORKS.

NOTES

ISSUE/DATE

AMENDMENT

DRAWN

CHECKED

APPROVED

AK

NORTH

SCALE

1:400 A1

DRAWING TITLE

SITE PLAN TAGS & DIMENSION (KEY PLAN)

SHEET NUMBER


A-ZB-010

ISSUE DATE

MAY.2023

AMENDMENT


CHECKED

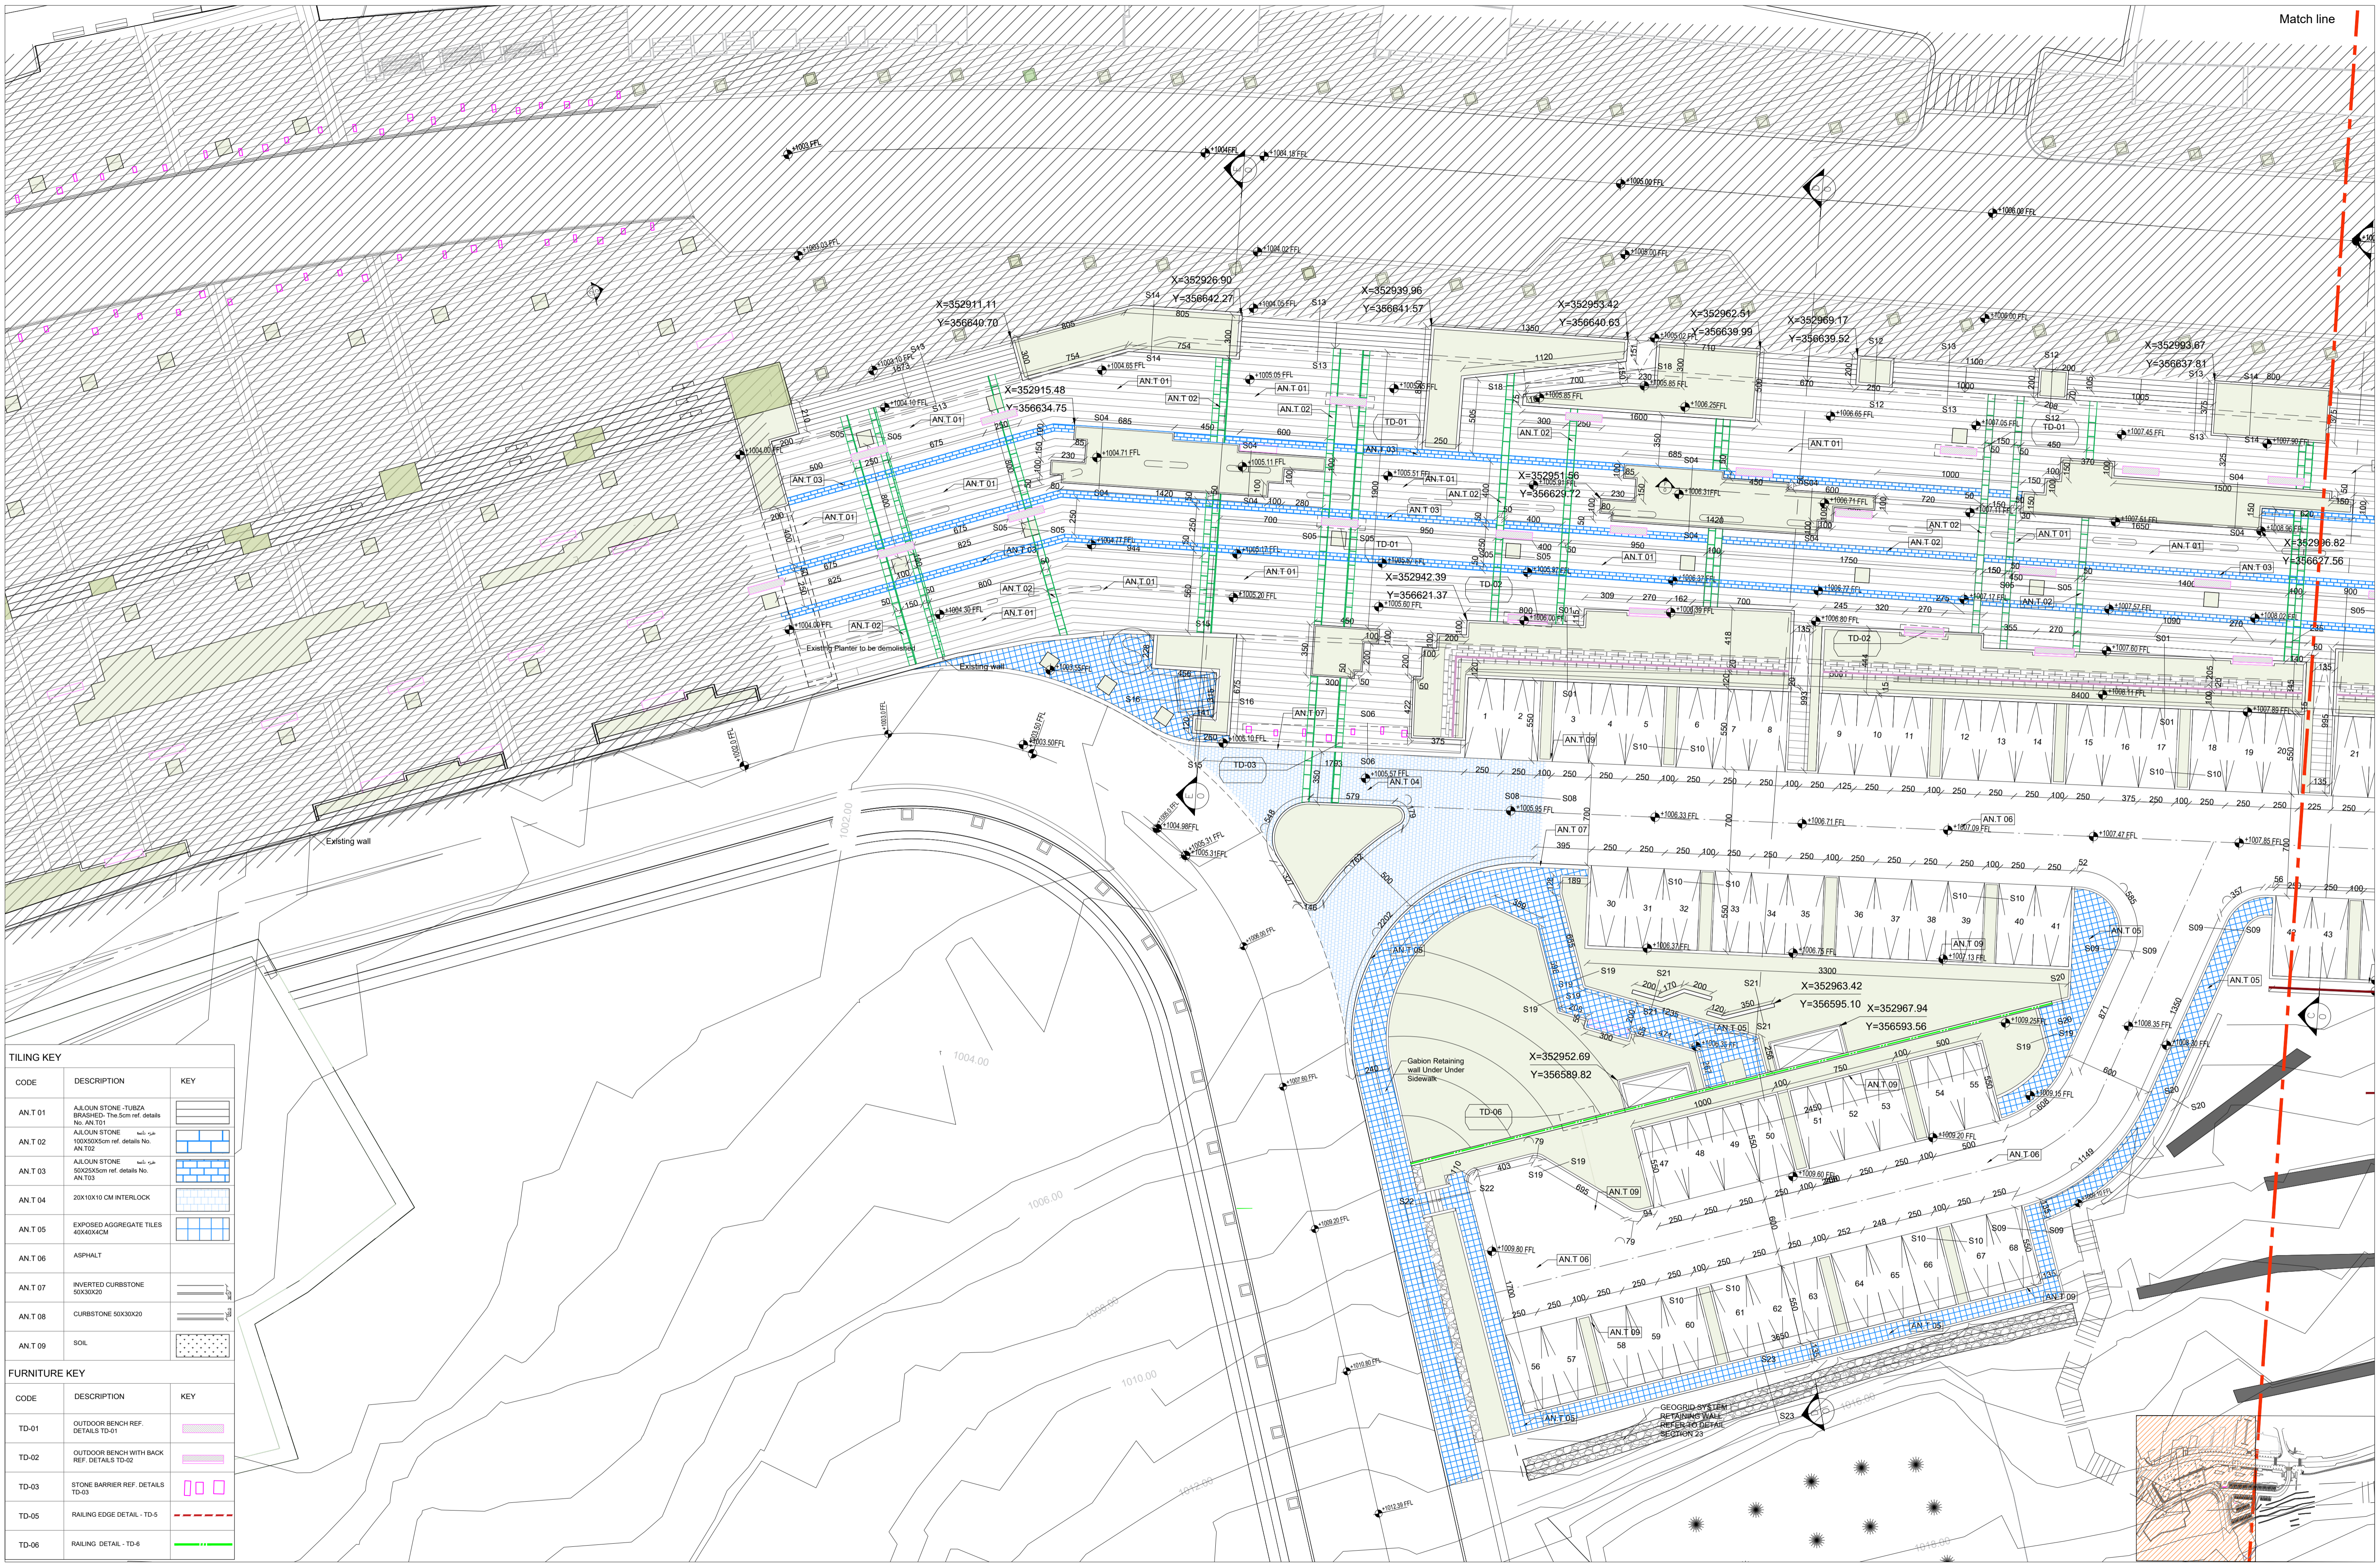

CODE	DESCRIPTION	KEY
ANT 01	AJLOUN STONE - TUSA BRASHED - The 5cm ref. details No. AN.T01	[Key symbol]
ANT 02	AJLOUN STONE 100X50X5cm ref. details No. AN.T02	[Key symbol]
ANT 03	AJLOUN STONE 50X50X5cm ref. details No. AN.T03	[Key symbol]
ANT 04	20X10X10 CM INTERLOCK	[Key symbol]
ANT 05	EXPOSED AGGREGATE TILES 40X40X4CM	[Key symbol]
ANT 06	ASPHALT	[Key symbol]
ANT 07	INVERTED CURBSTONE 50X30X20	[Key symbol]
ANT 08	CURBSTONE 50X30X20	[Key symbol]
ANT 09	SOIL	[Key symbol]



CODE	DESCRIPTION	KEY
TD-01	OUTDOOR BENCH REF. DETAILS TD-01	[Key symbol]
TD-02	OUTDOOR BENCH WITH BACK REF. DETAILS TD-02	[Key symbol]
TD-03	STONE BARRIER REF. DETAILS TD-03	[Key symbol]
TD-05	RAILING EDGE DETAIL - TD-5	[Key symbol]
TD-06	RAILING DETAIL - TD-6	[Key symbol]

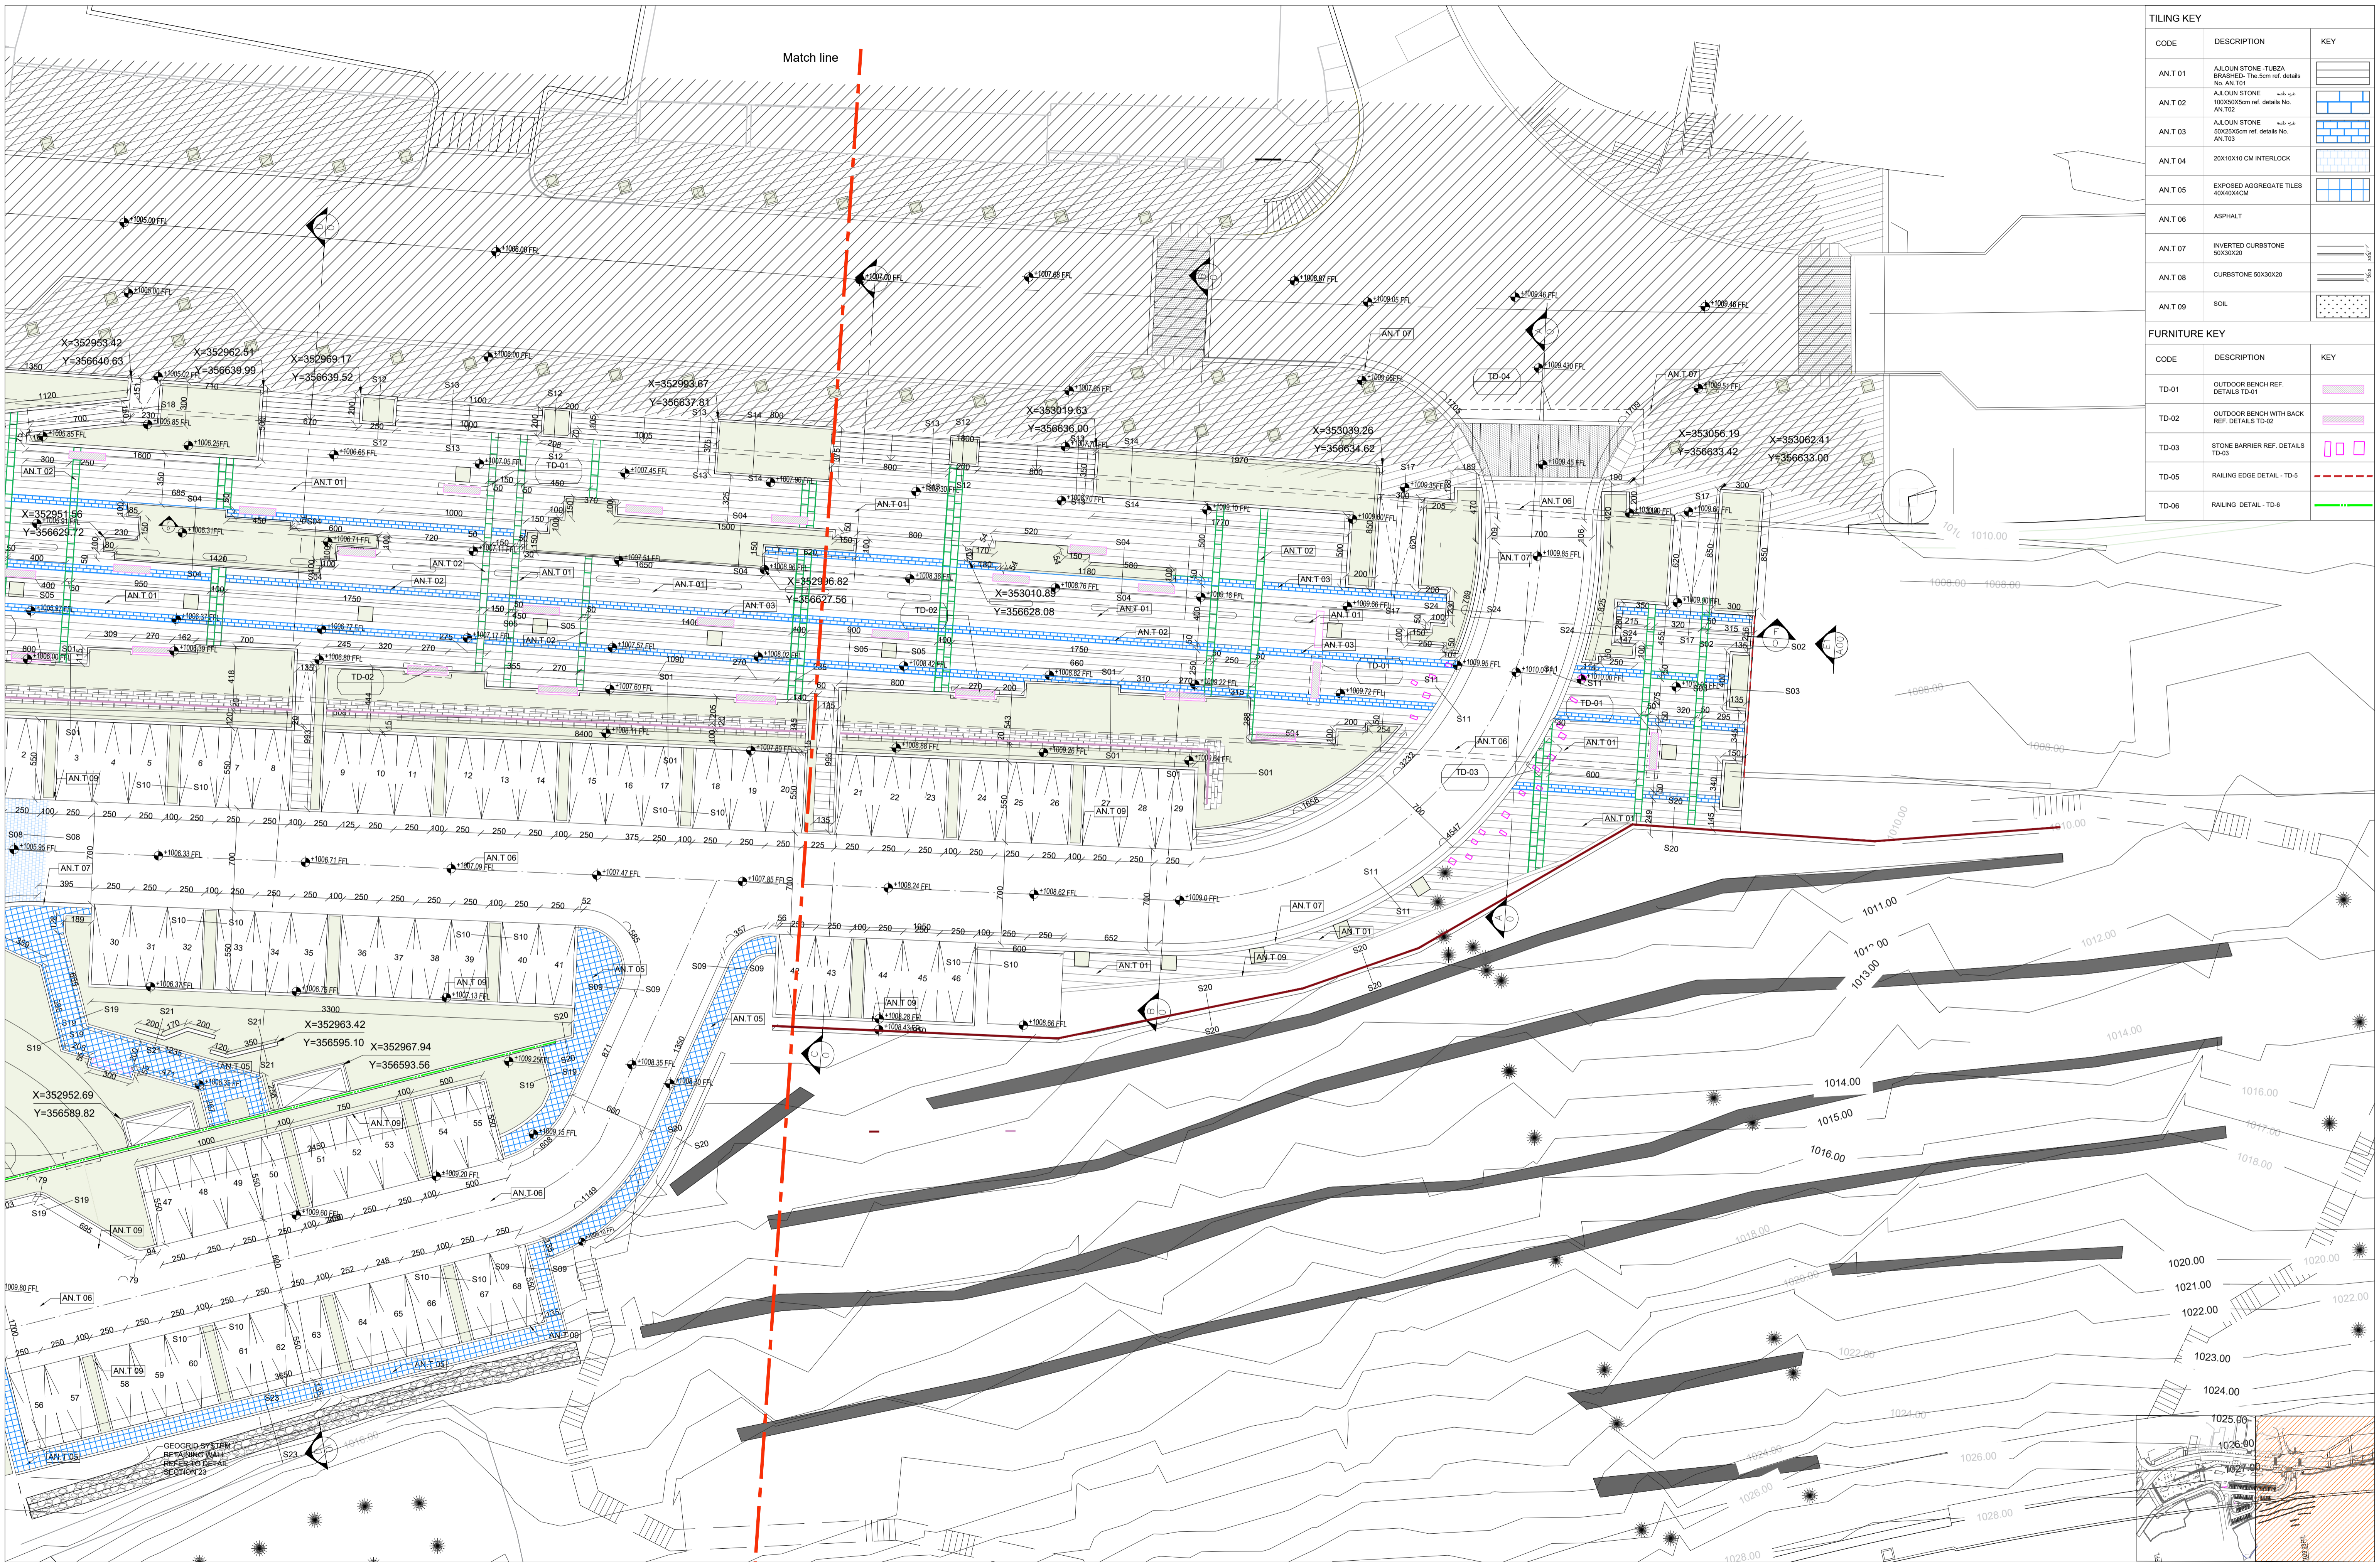


TILING KEY		
CODE	DESCRIPTION	KEY
AN.T 01	AJLUN STONE -TUBZA BRASHED- The 5cm ref. details No. AN.T01	
AN.T 02	AJLUN STONE 100x50x5cm ref. details No. AN.T02	
AN.T 03	AJLUN STONE 50x25x5cm ref. details No. AN.T03	
AN.T 04	20X10X10 CM INTERLOCK	
AN.T 05	EXPOSED AGGREGATE TILES 40X40X4CM	
AN.T 06	ASPHALT	
AN.T 07	INVERTED CURBSTONE 60X30X20	
AN.T 08	CURBSTONE 50X30X20	
AN.T 09	SOIL	

FURNITURE KEY		
CODE	DESCRIPTION	KEY
TD-01	OUTDOOR BENCH REF. DETAILS TD-01	
TD-02	OUTDOOR BENCH WITH BACK REF. DETAILS TD-02	
TD-03	STONE BARRIER REF. DETAILS TD-03	
TD-05	RAILING EDGE DETAIL- TD-5	
TD-06	RAILING DETAIL- TD-6	




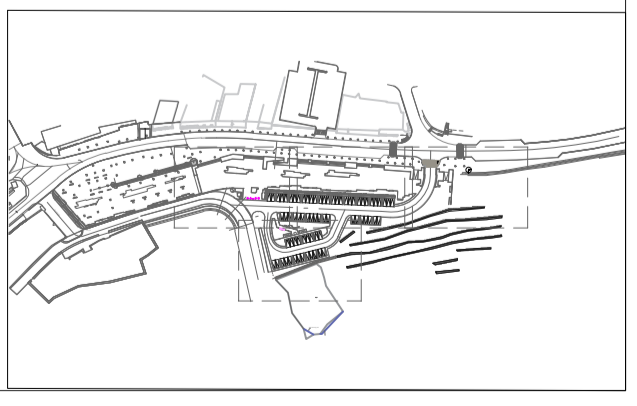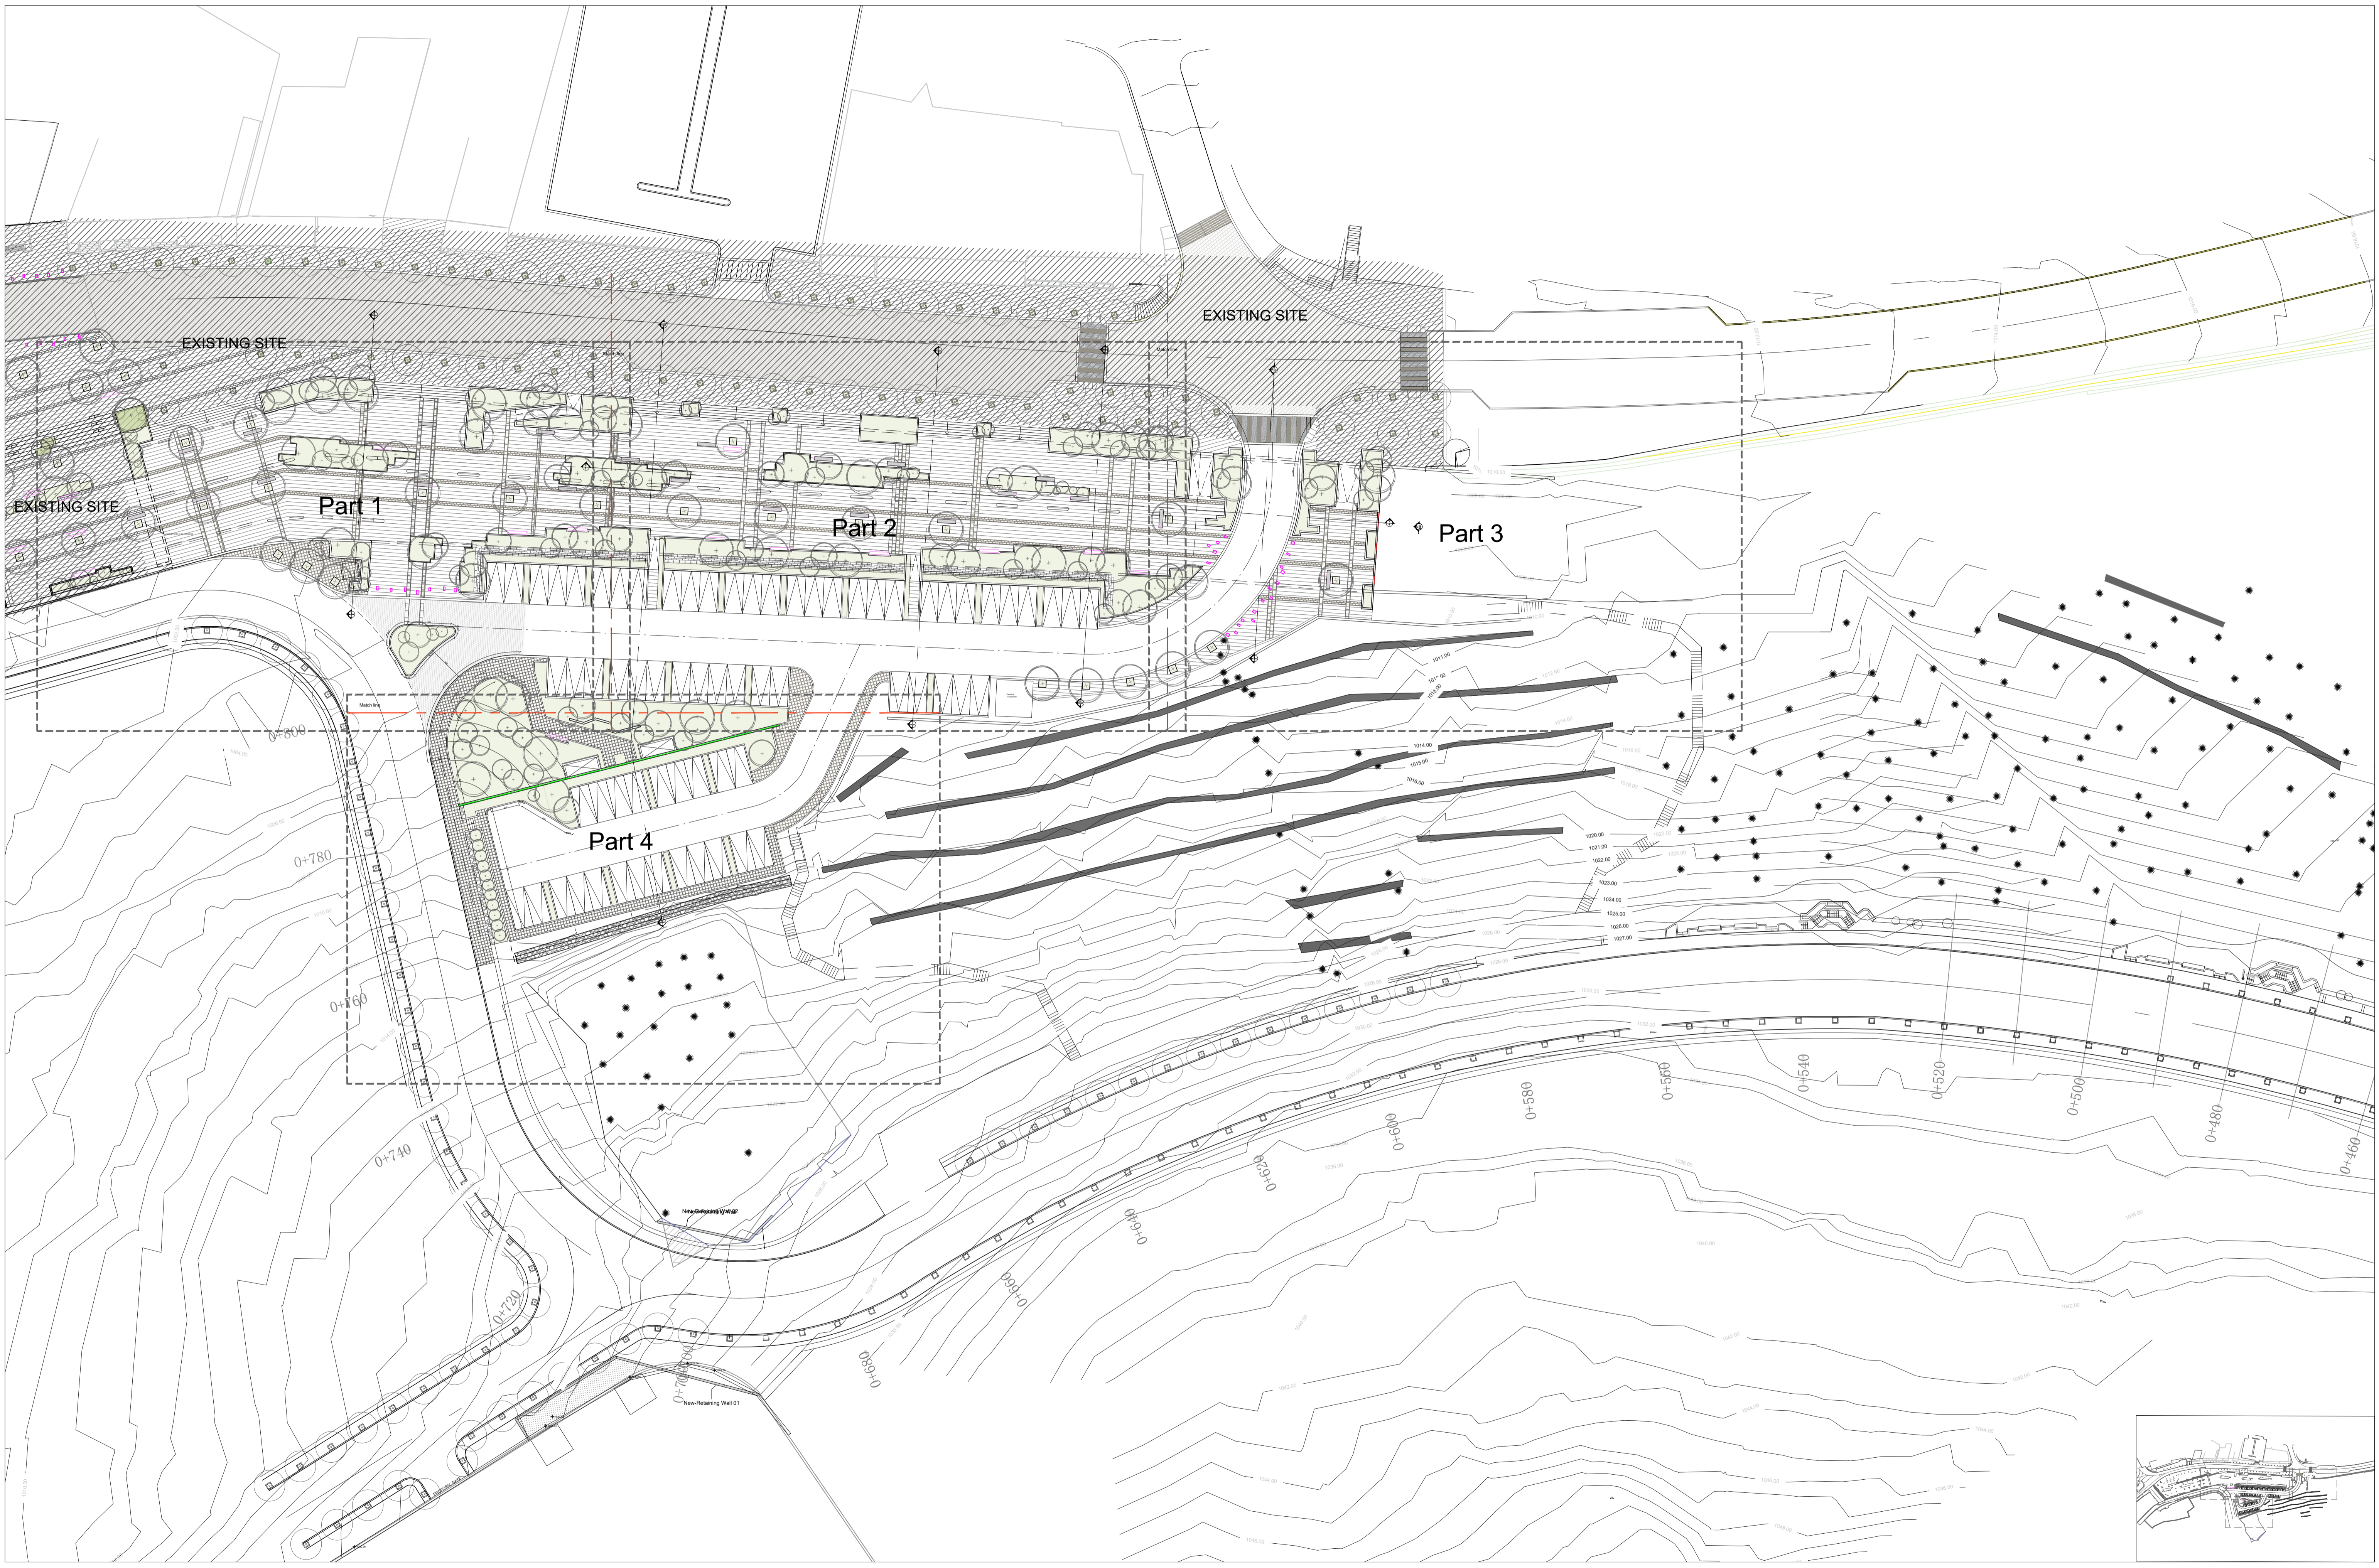

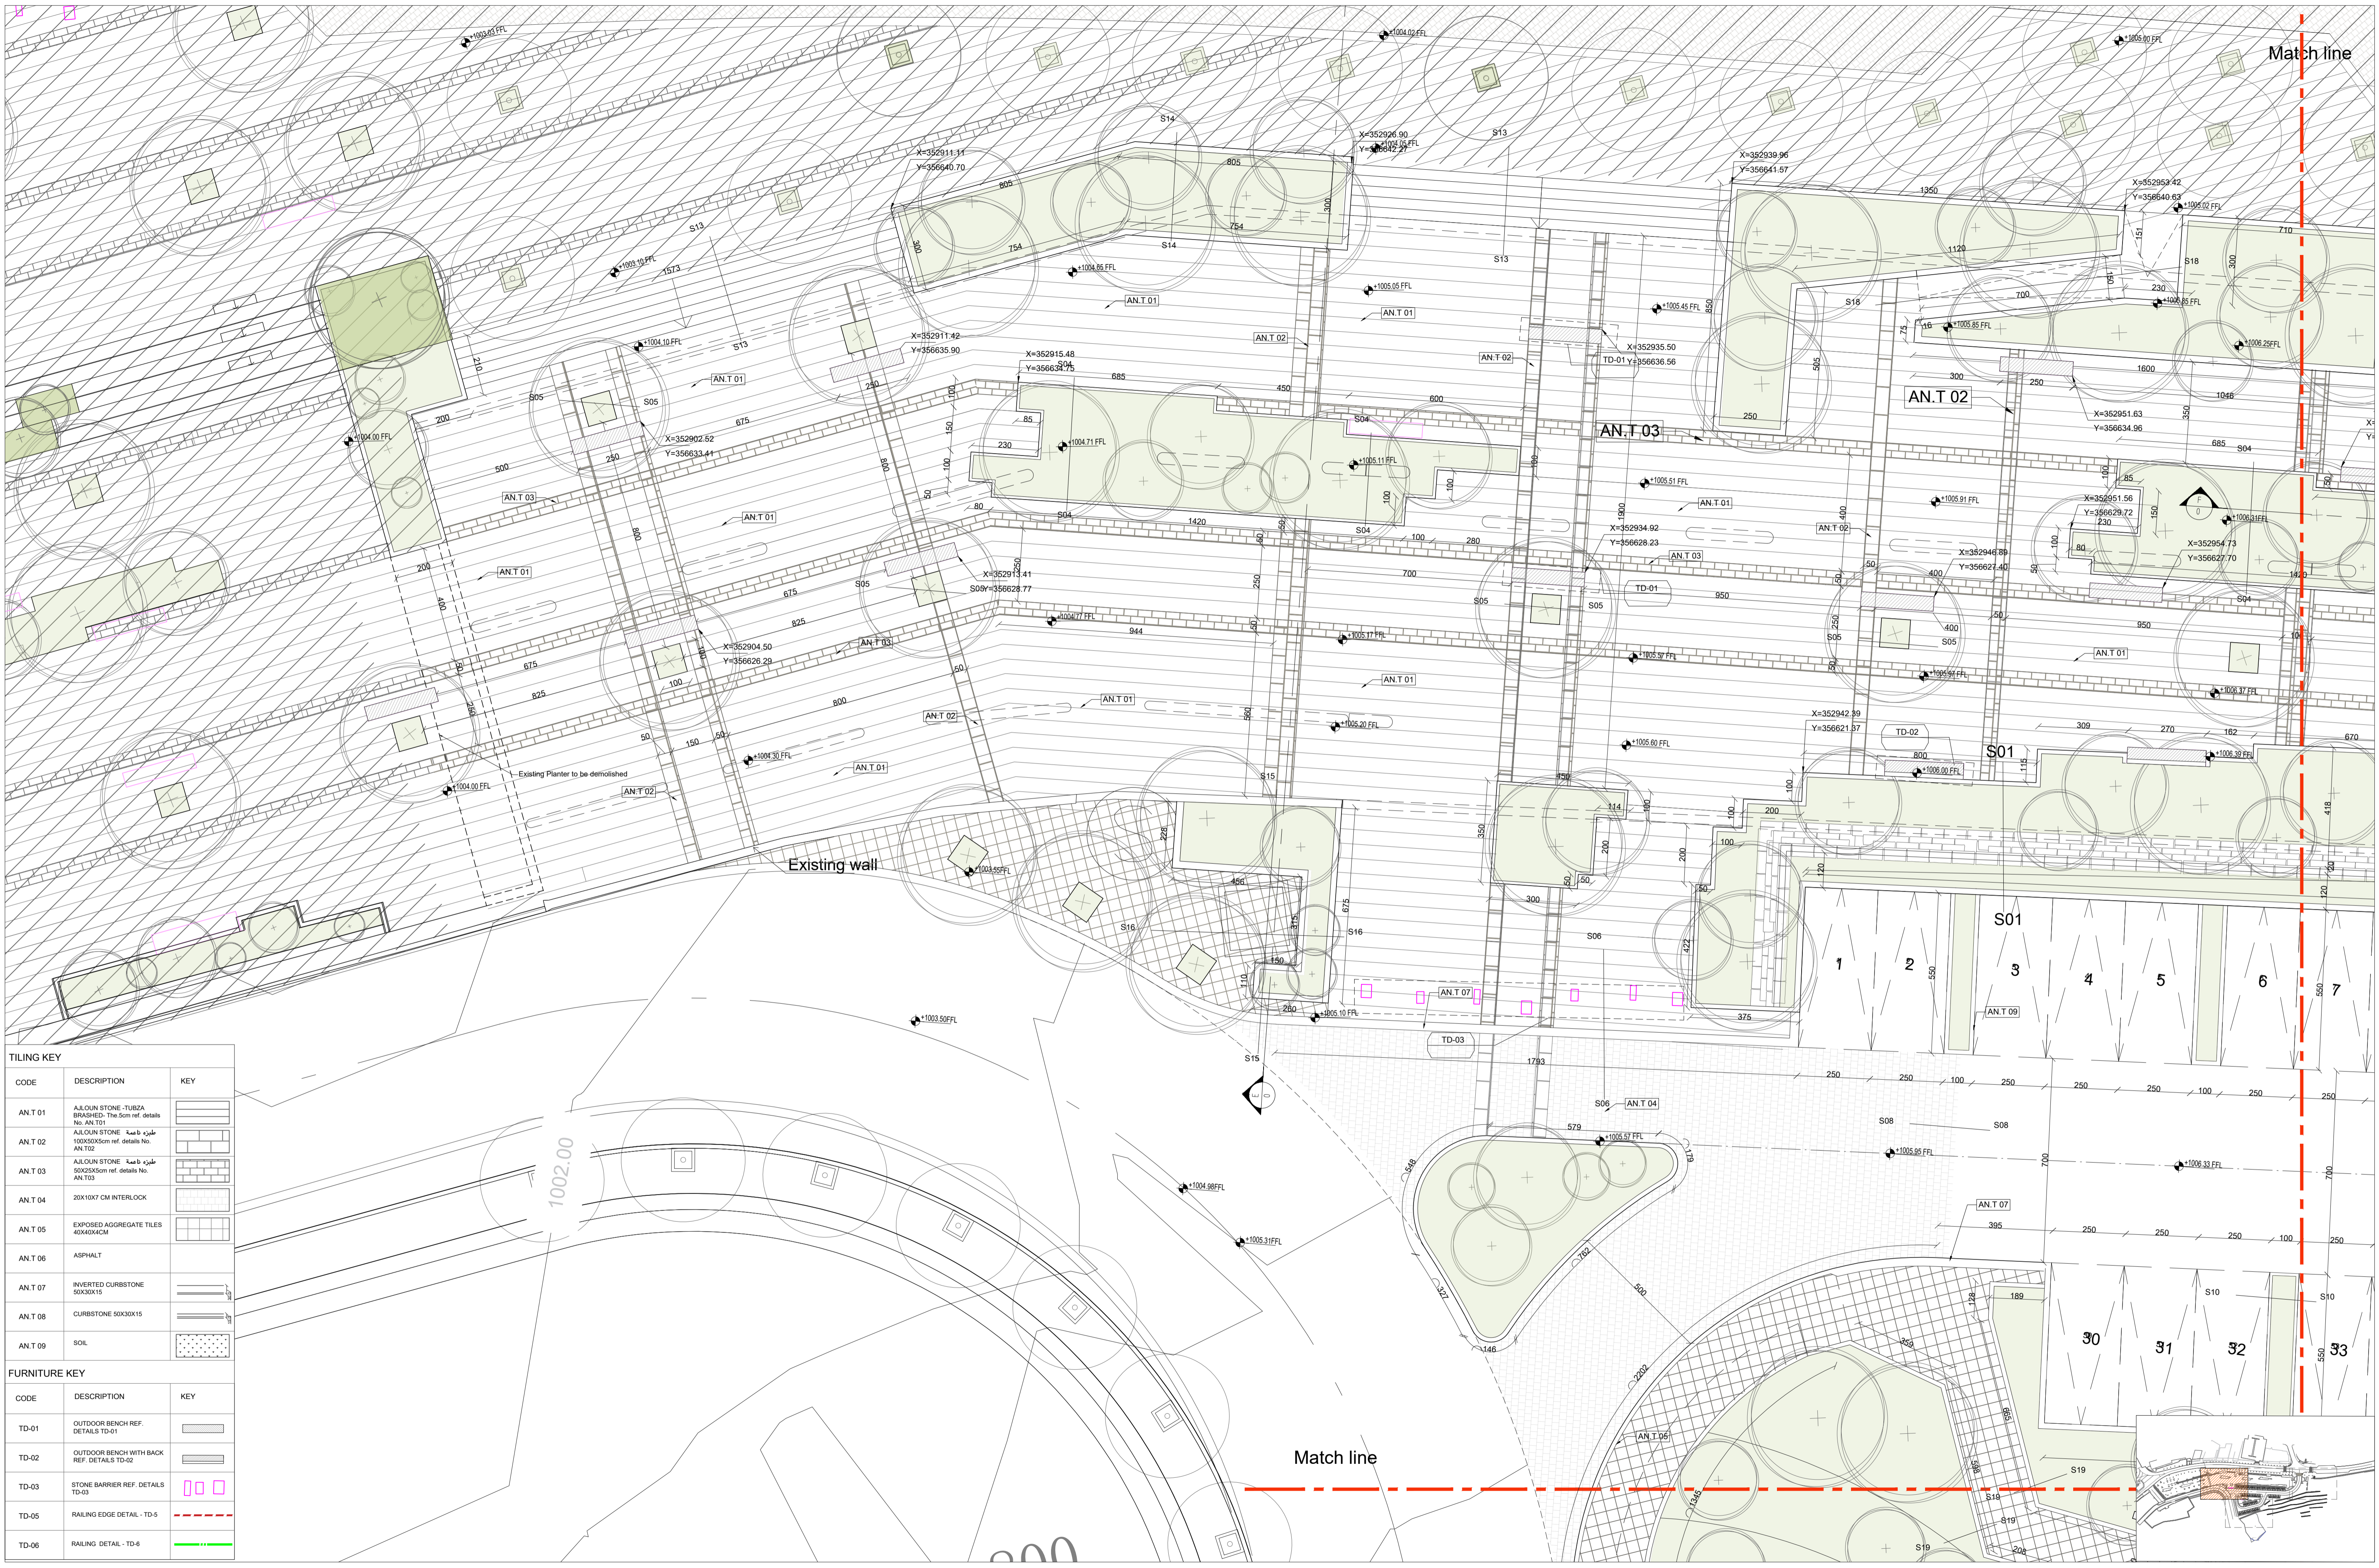CODE	DESCRIPTION	KEY
AN.T 01	A.L.COUN STONE -TUBSA BRASHED- The Scm ref. details No. AN.T01	[Pattern]
AN.T 02	A.L.COUN STONE -مخمس باحثة 100X50X5cm ref. details No. AN.T02	[Pattern]
AN.T 03	A.L.COUN STONE -مخمس باحثة 80X50X5cm ref. details No. AN.T03	[Pattern]
AN.T 04	20X10X7 CM INTERLOCK	[Pattern]
AN.T 05	EXPOSED AGGREGATE TILES 40X40X4CM	[Pattern]
AN.T 06	ASPHALT	[Pattern]
AN.T 07	INVERTED CURBSTONE 50X30X15	[Pattern]
AN.T 08	CURBSTONE 50X30X15	[Pattern]
AN.T 09	SOIL	[Pattern]


CODE	DESCRIPTION	KEY
TD-01	OUTDOOR BENCH REF. DETAILS TD-01	[Symbol]
TD-02	OUTDOOR BENCH WITH BACK REF. DETAILS TD-02	[Symbol]
TD-03	STONE BARRIER REF. DETAILS TD-03	[Symbol]
TD-05	RAILING EDGE DETAIL - TD-5	[Symbol]
TD-06	RAILING DETAIL - TD-6	[Symbol]

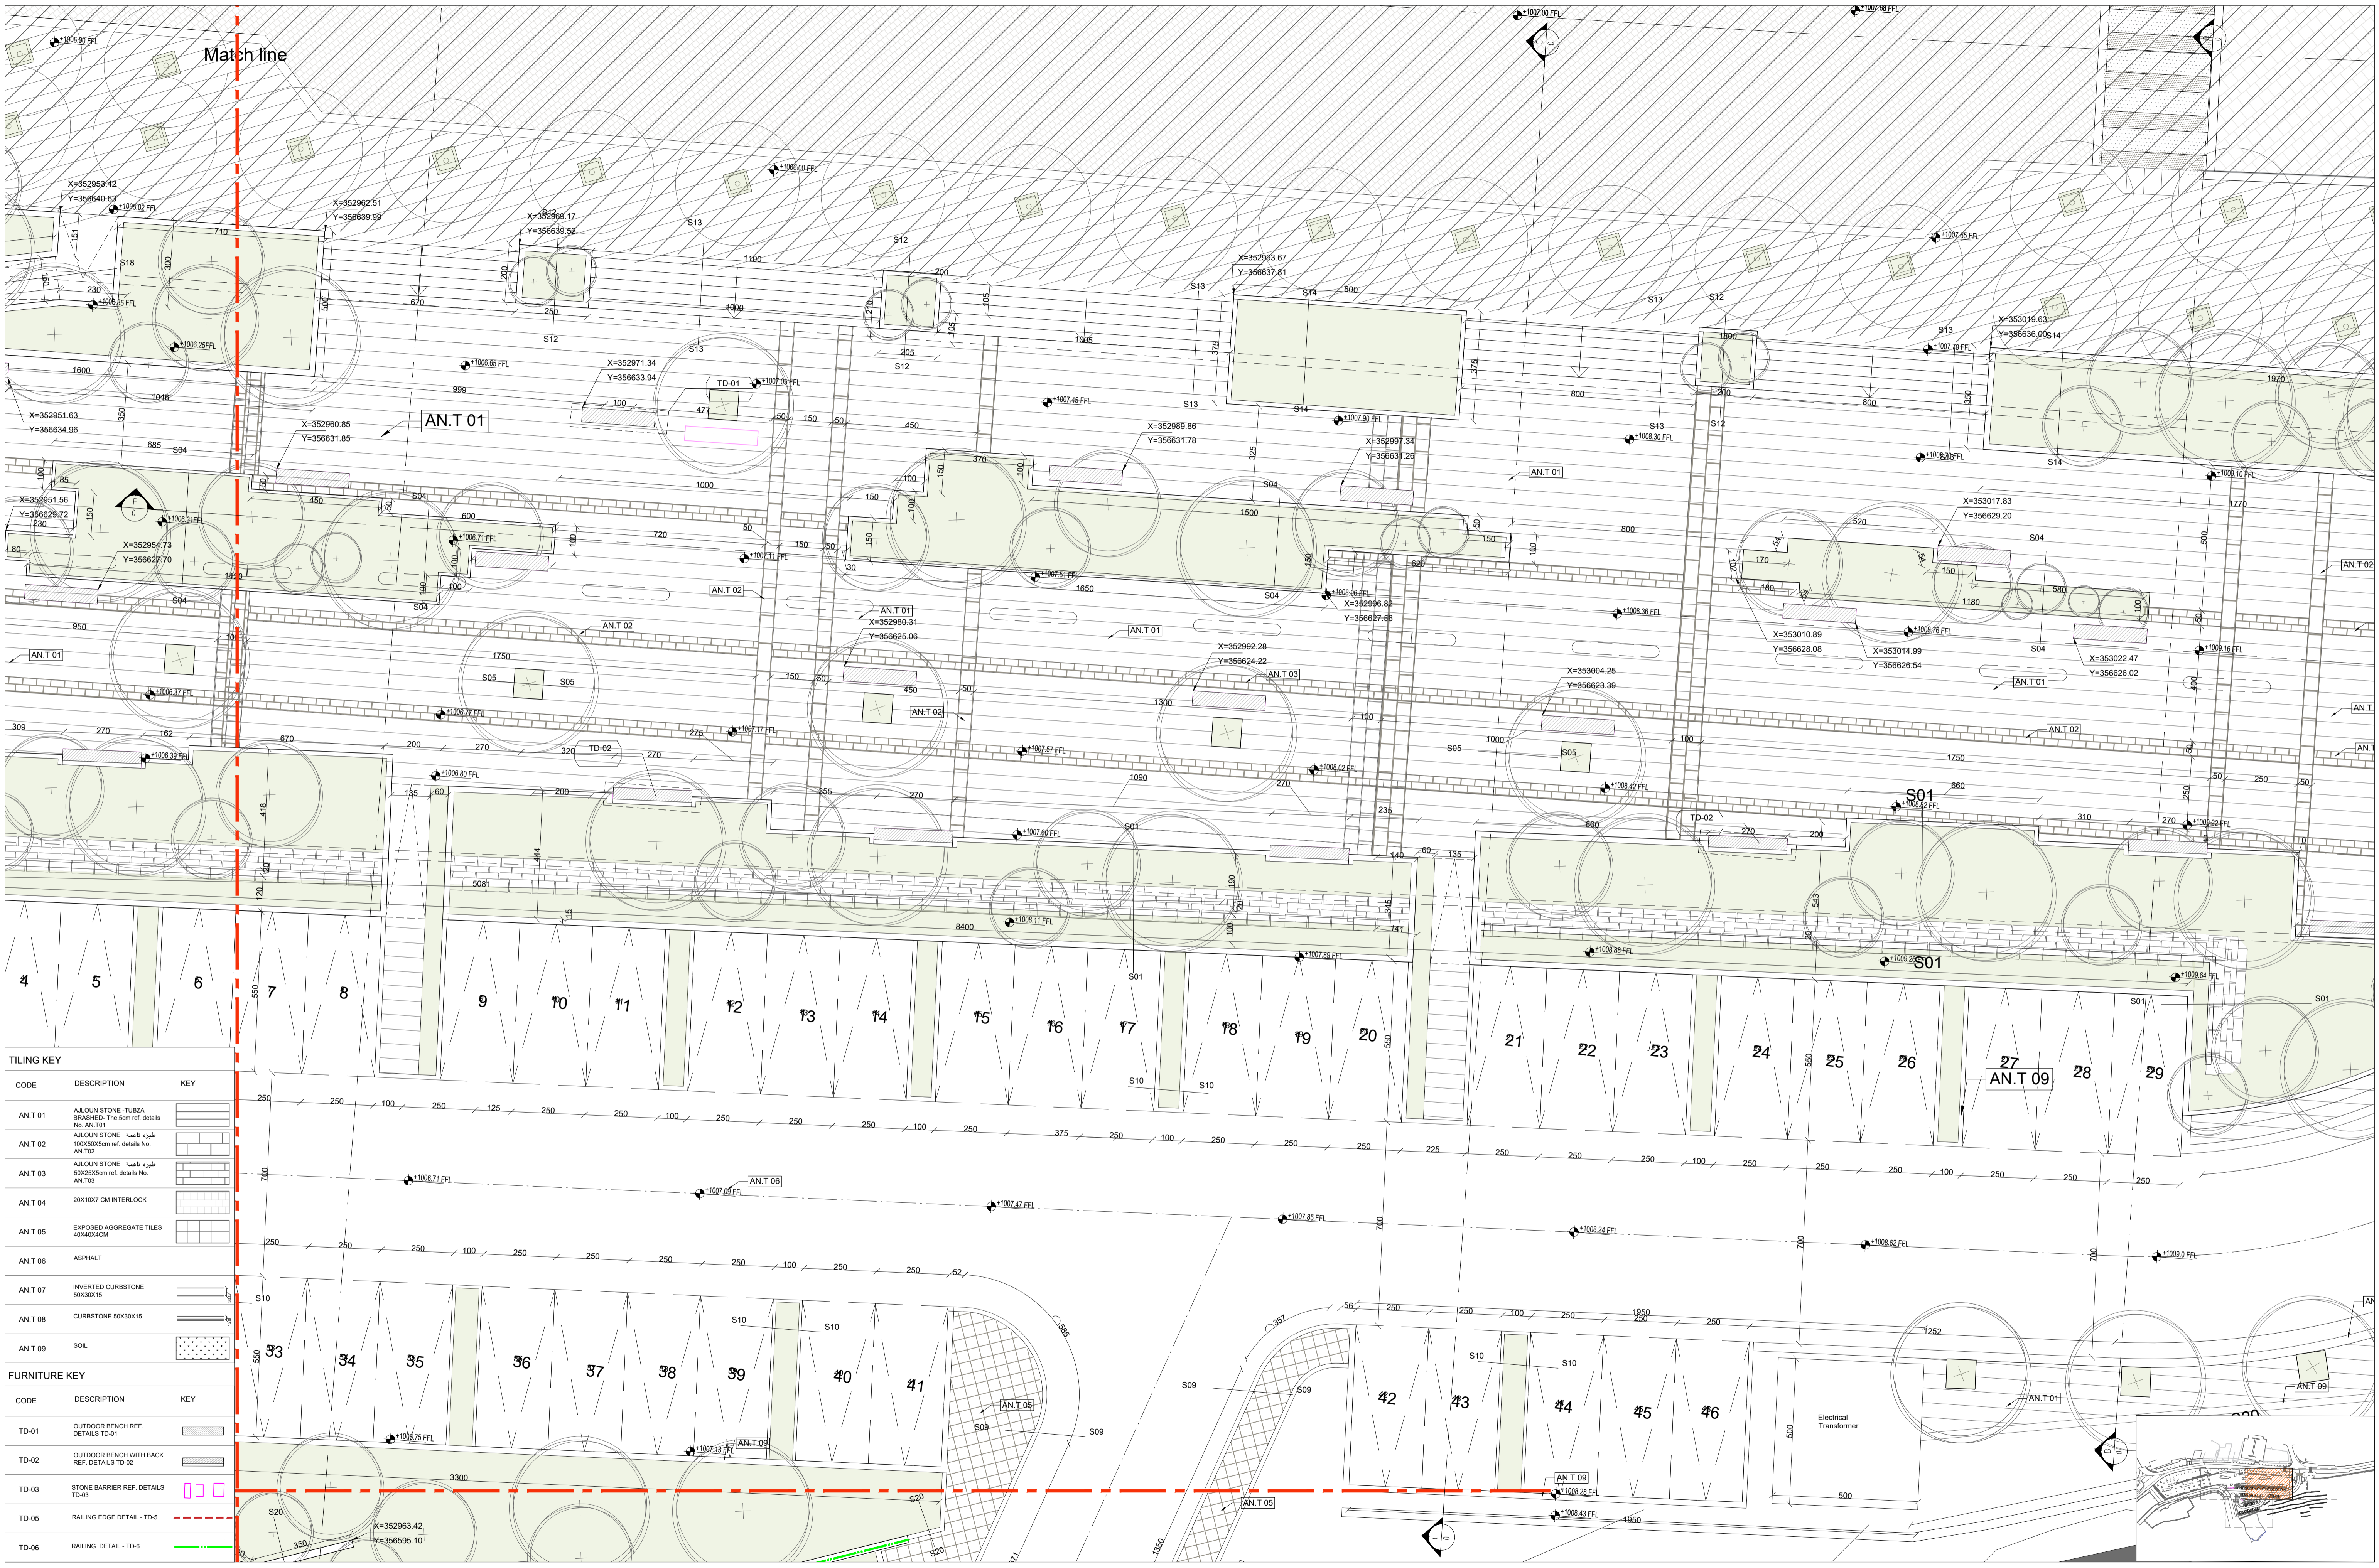

CODE	DESCRIPTION	KEY
ANT 01	ALQUIN STONE - TUBEZA BRASHED - The color ref. details No. AN.T01	[Key symbol]
ANT 02	ALQUIN STONE - 100X500cm ref. details No. AN.T02	[Key symbol]
ANT 03	ALQUIN STONE - 50X250cm ref. details No. AN.T03	[Key symbol]
ANT 04	20X10X7 CM INTERLOCK	[Key symbol]
ANT 05	EXPOSED AGGREGATE TILES 40X40X4CM	[Key symbol]
ANT 06	ASPHALT	[Key symbol]
ANT 07	INVERTED CURBSTONE 50X30X15	[Key symbol]
ANT 08	CURBSTONE 50X30X15	[Key symbol]
ANT 09	SOIL	[Key symbol]

CODE	DESCRIPTION	KEY
TD-01	OUTDOOR BENCH REF. DETAILS TD-01	[Key symbol]
TD-02	OUTDOOR BENCH WITH BACK REF. DETAILS TD-02	[Key symbol]
TD-03	STONE BARRIER REF. DETAILS TD-03	[Key symbol]
TD-05	RAILING EDGE DETAIL - TD-5	[Key symbol]
TD-06	RAILING DETAIL - TD-6	[Key symbol]

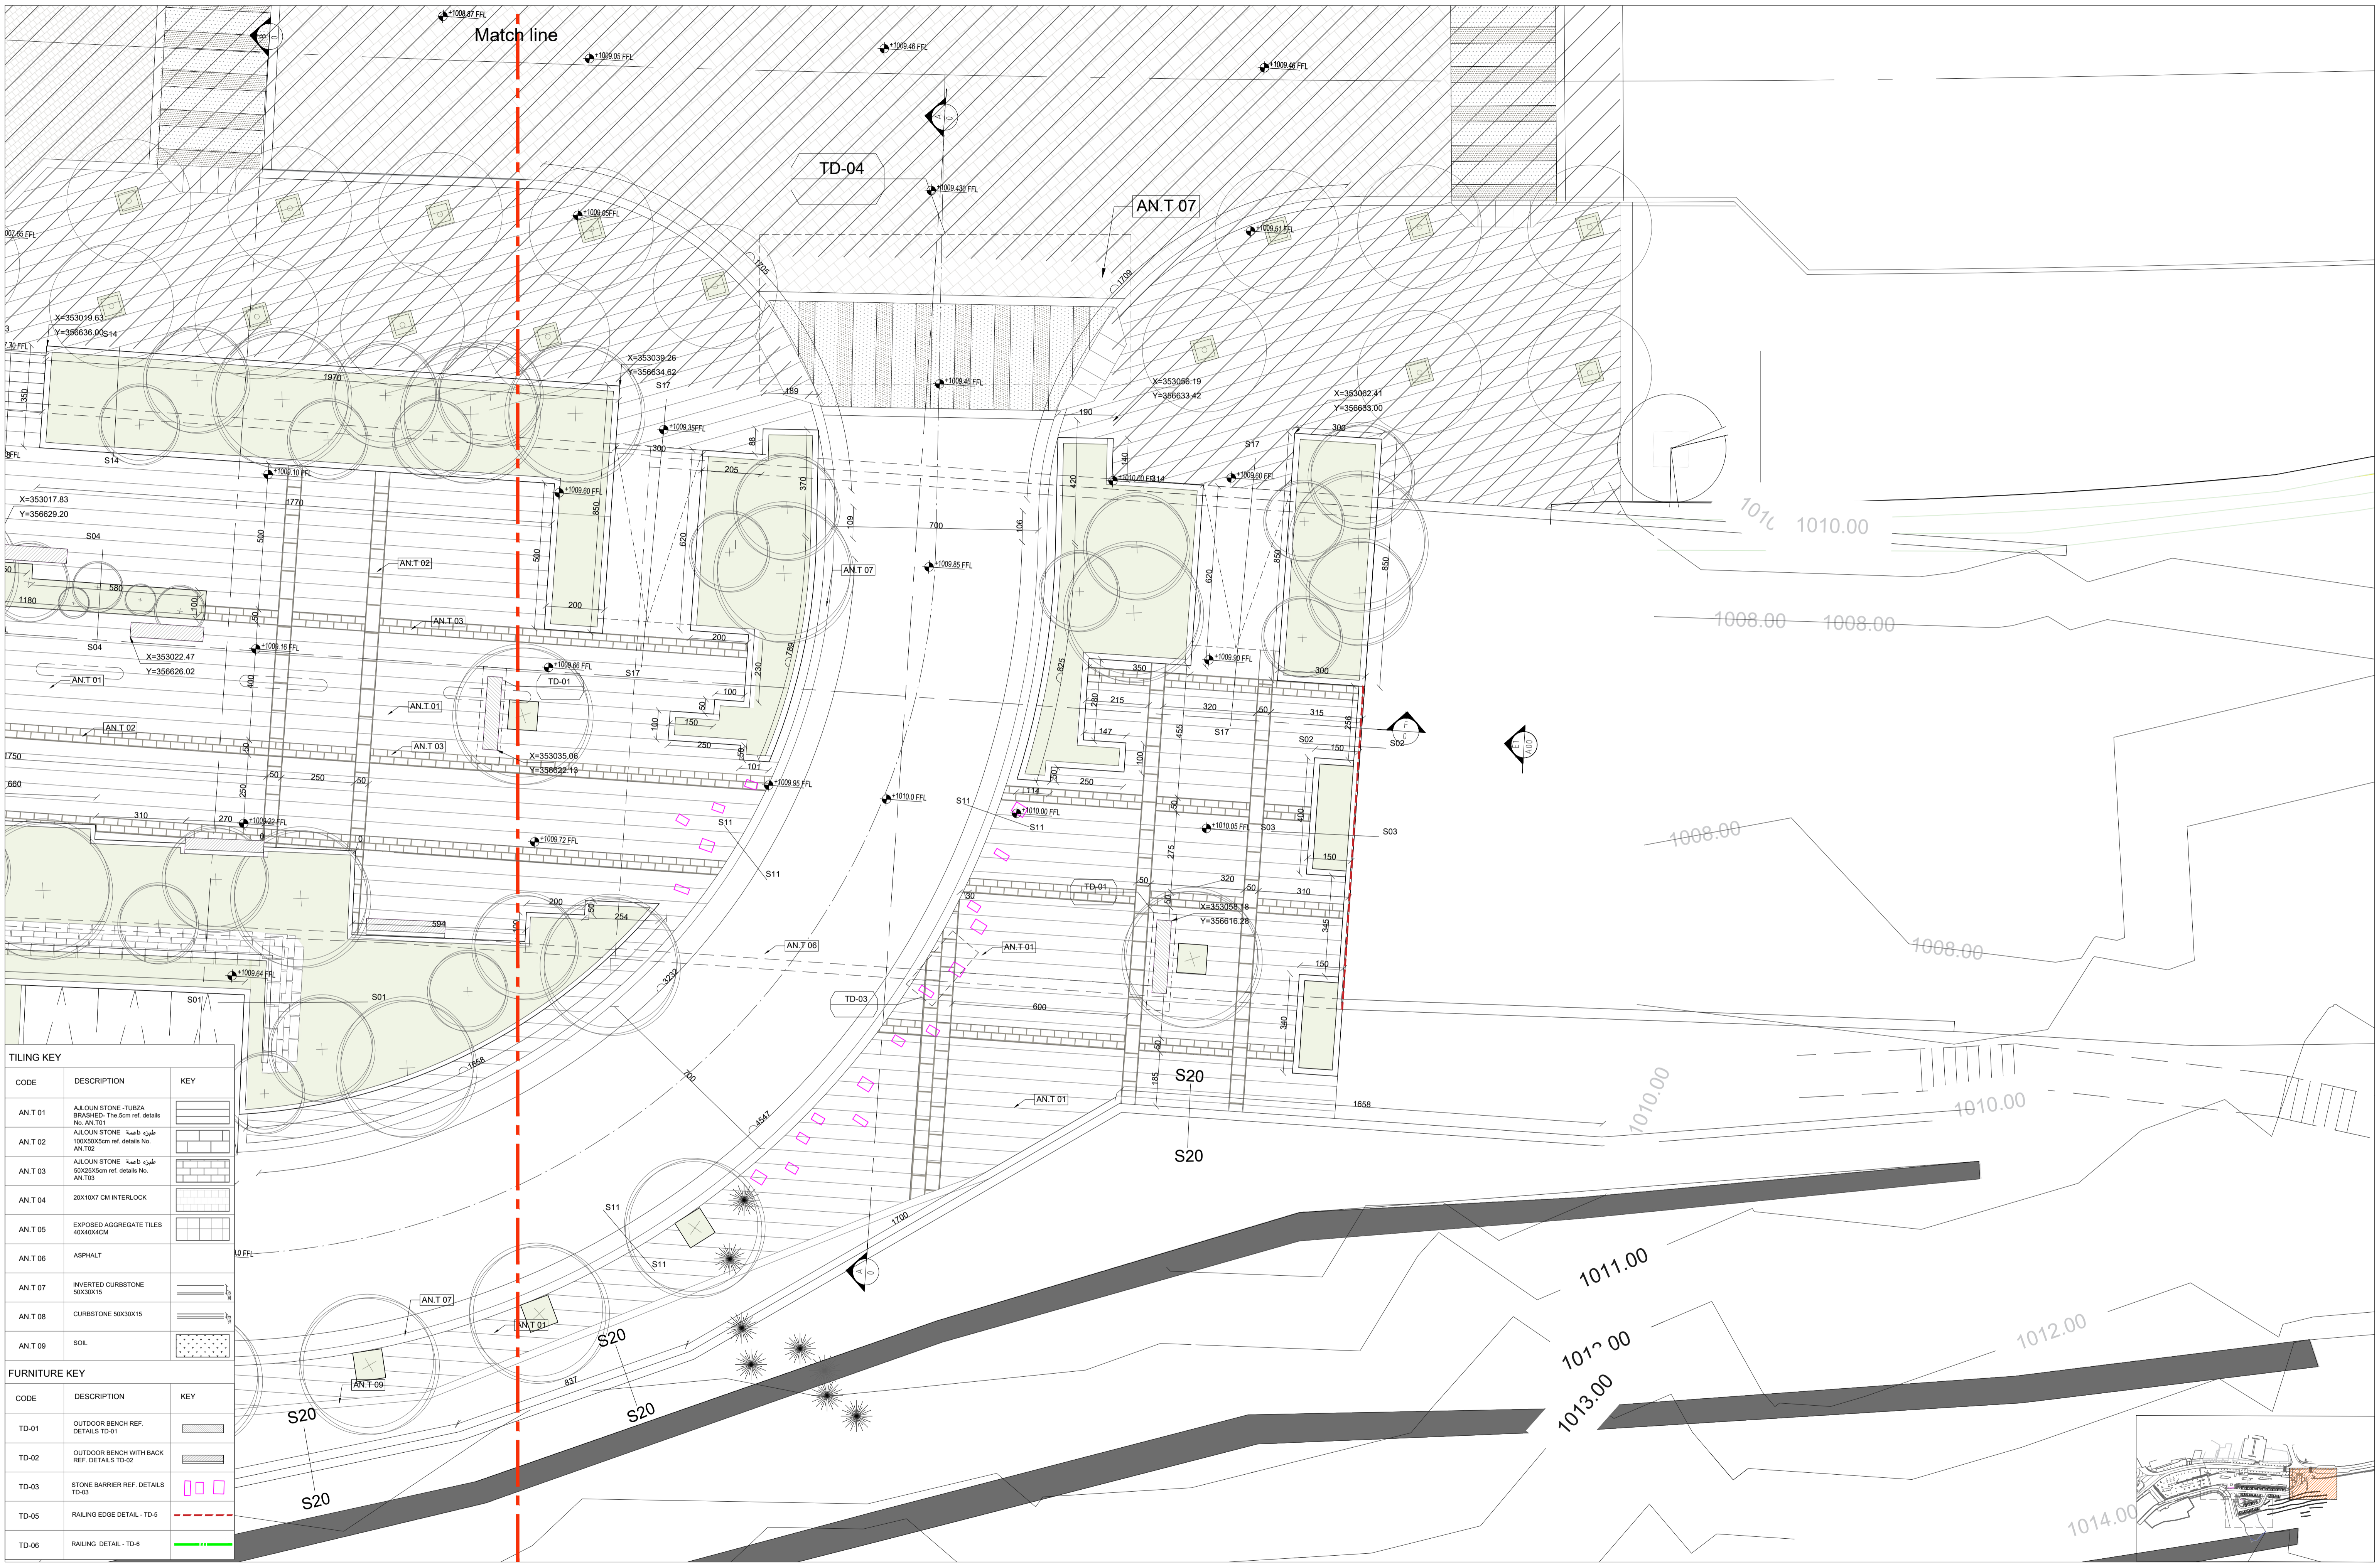


CODE	DESCRIPTION	KEY
AN.T 01	A.LOUIN STONE-TURSA BRASHED-The Scm ref. details No. AN.T01	[Pattern]
AN.T 02	A.LOUIN STONE- حجارة باصية 100X50X5cm ref. details No. AN.T02	[Pattern]
AN.T 03	A.LOUIN STONE- حجارة باصية 50X50X5cm ref. details No. AN.T03	[Pattern]
AN.T 04	20X10X7 CM INTERLOCK	[Pattern]
AN.T 05	EXPOSED AGGREGATE TILES 40X40X4CM	[Pattern]
AN.T 06	ASPHALT	[Pattern]
AN.T 07	INVERTED CURBSTONE 50X30X15	[Pattern]
AN.T 08	CURBSTONE 50X30X15	[Pattern]
AN.T 09	SOIL	[Pattern]

CODE	DESCRIPTION	KEY
TD-01	OUTDOOR BENCH REF. DETAILS TD-01	[Symbol]
TD-02	OUTDOOR BENCH WITH BACK REF. DETAILS TD-02	[Symbol]
TD-03	STONE BARRIER REF. DETAILS TD-03	[Symbol]
TD-05	RAILING EDGE DETAIL - TD-5	[Symbol]
TD-06	RAILING DETAIL - TD-6	[Symbol]


Match line


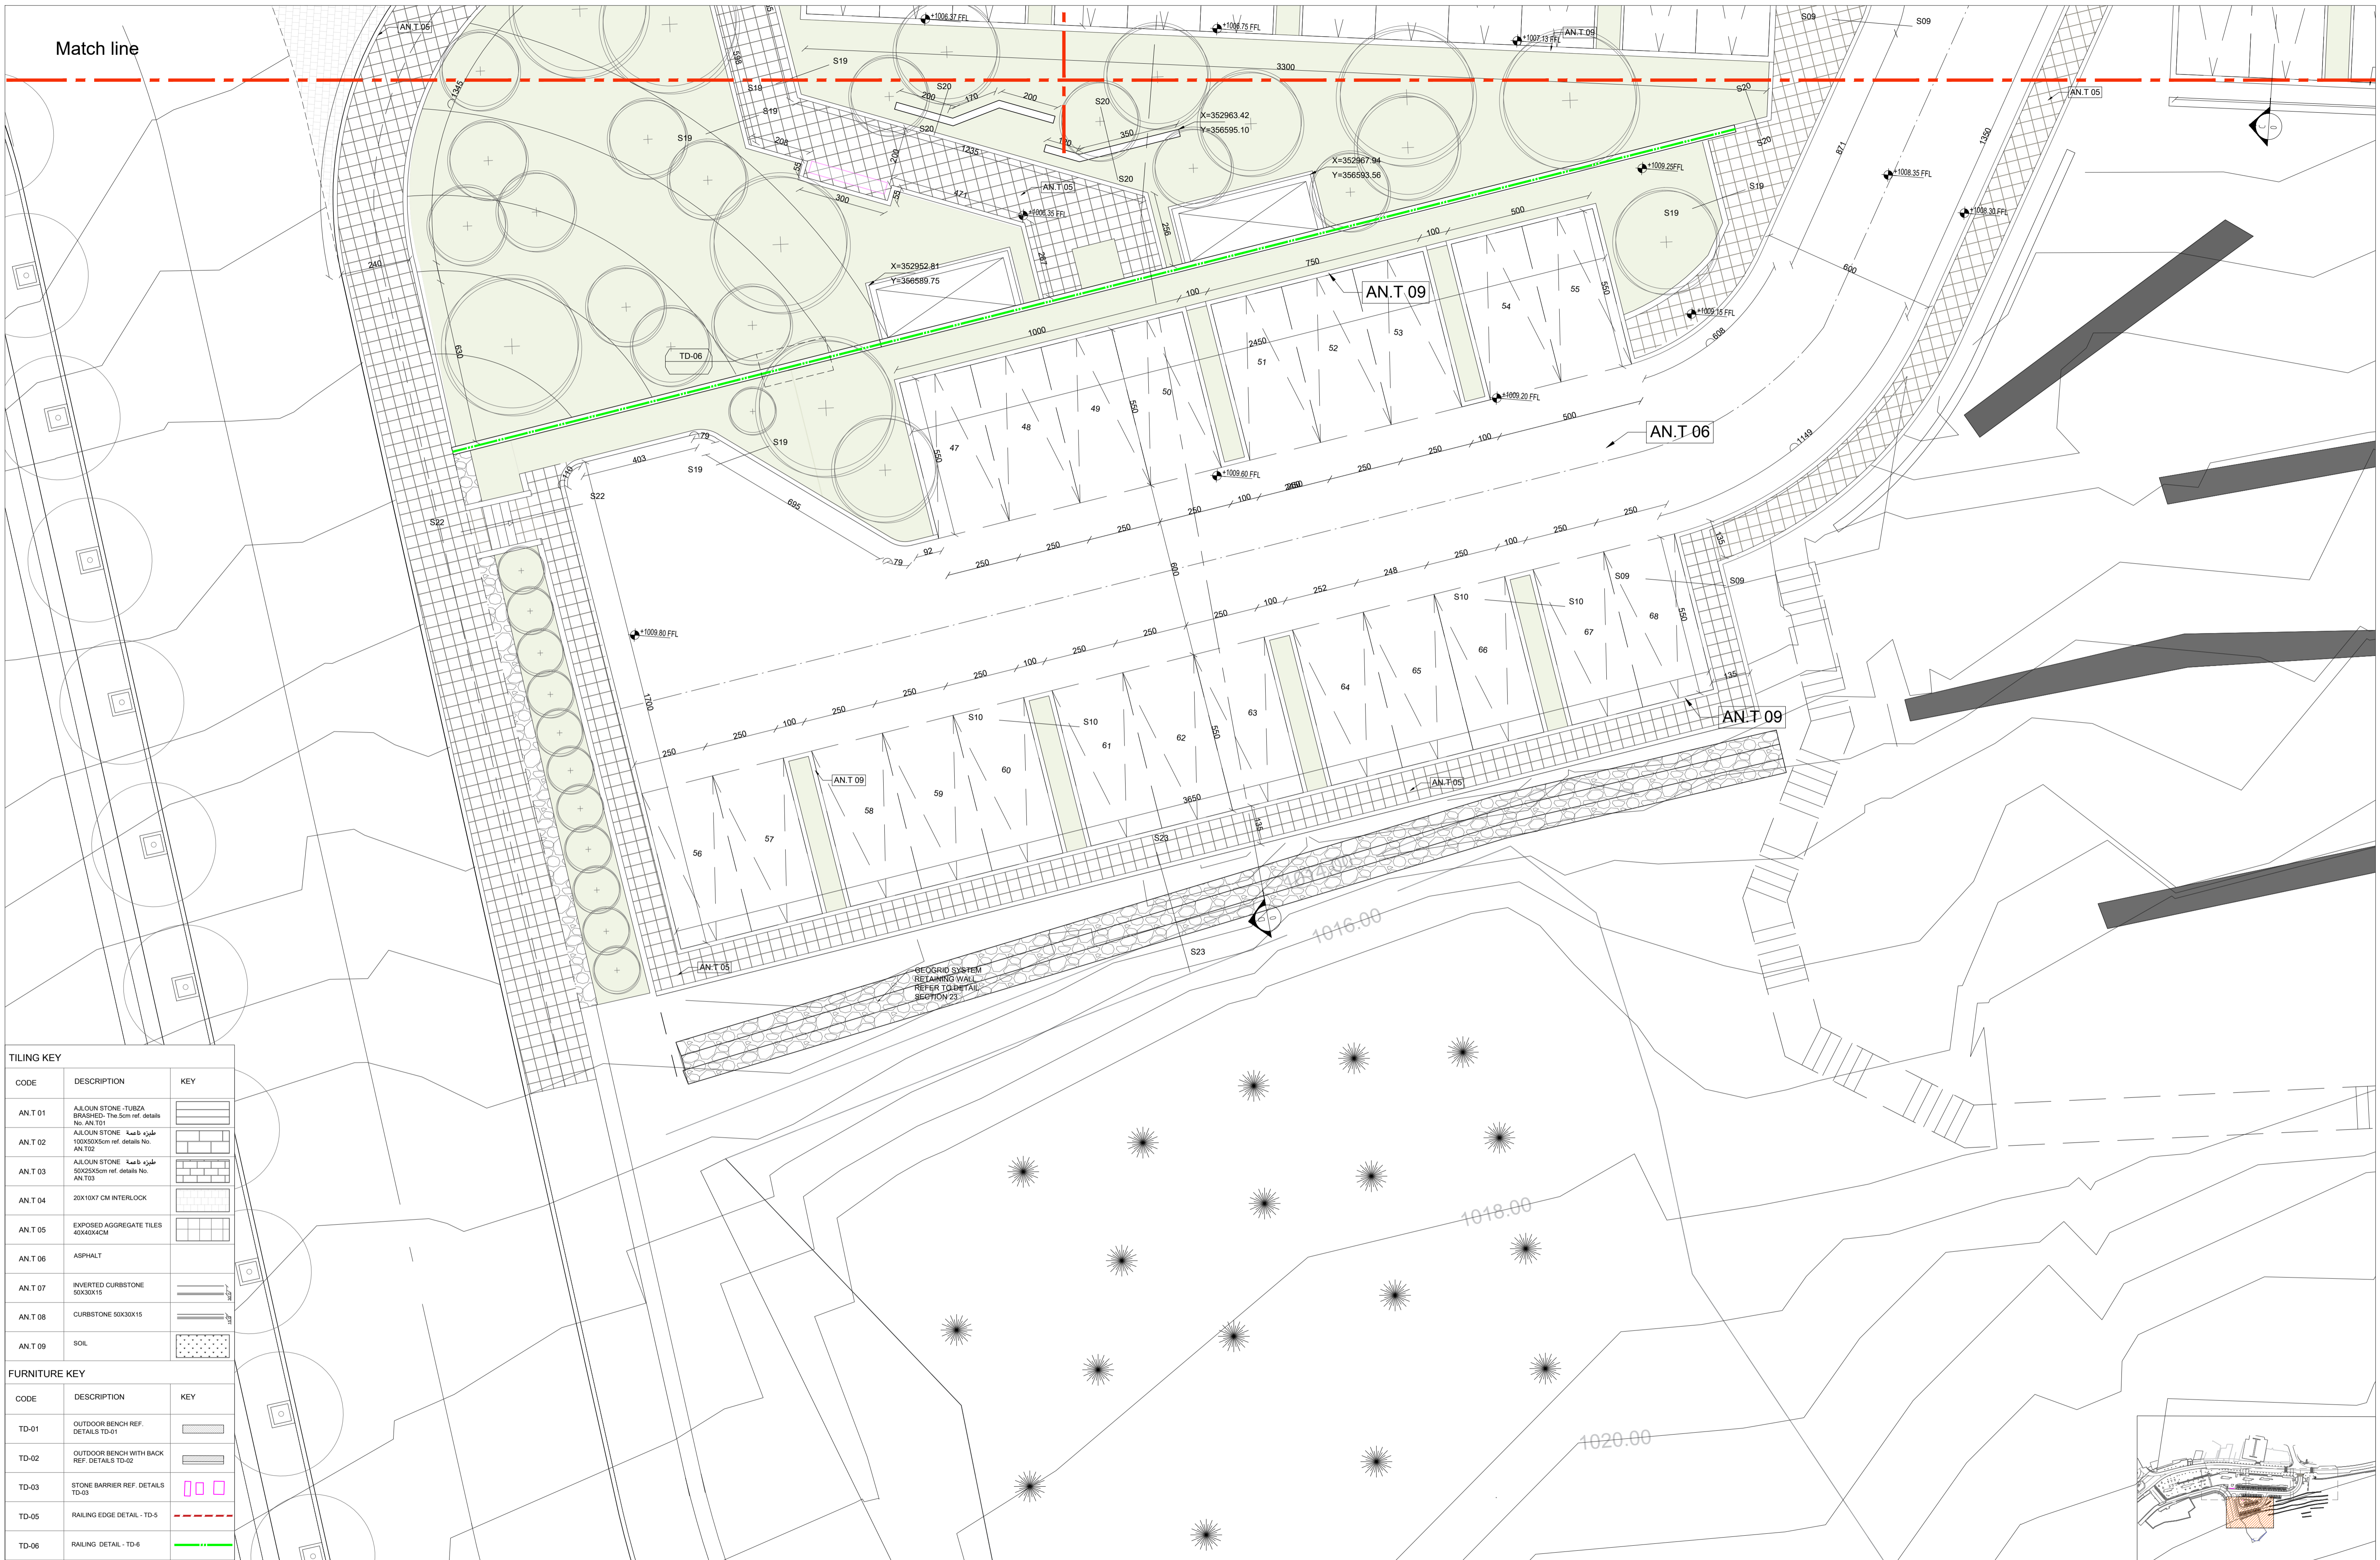


TILING KEY		
CODE	DESCRIPTION	KEY
AN.T 01	A.L.OUN STONE - TUSZA BRASHED- The 5cm ref. details No. AN.T01	[Pattern]
AN.T 02	A.L.OUN STONE - 100X50X5cm ref. details No. AN.T02	[Pattern]
AN.T 03	A.L.OUN STONE - 80X50X5cm ref. details No. AN.T03	[Pattern]
AN.T 04	20X10X7 CM INTERLOCK	[Pattern]
AN.T 05	EXPOSED AGGREGATE TILES 40X40X4CM	[Pattern]
AN.T 06	ASPHALT	[Pattern]
AN.T 07	INVERTED CURBSTONE 50X30X15	[Pattern]
AN.T 08	CURBSTONE 50X30X15	[Pattern]
AN.T 09	SOIL	[Pattern]


  


FURNITURE KEY		
CODE	DESCRIPTION	KEY
TD-01	OUTDOOR BENCH REF. DETAILS TD-01	[Symbol]
TD-02	OUTDOOR BENCH WITH BACK REF. DETAILS TD-02	[Symbol]
TD-03	STONE BARRIER REF. DETAILS TD-03	[Symbol]
TD-05	RAILING EDGE DETAIL - TD-5	[Symbol]
TD-06	RAILING DETAIL - TD-6	[Symbol]

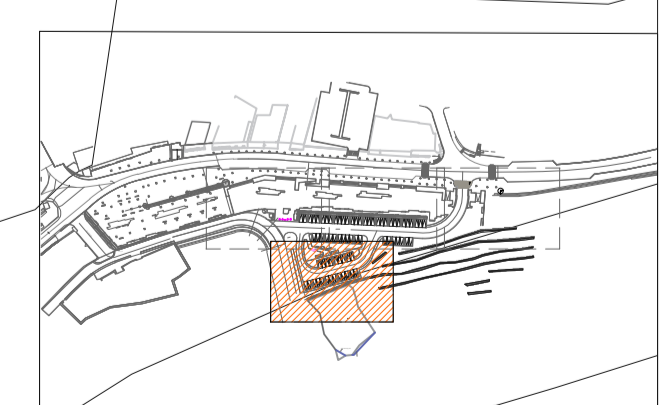

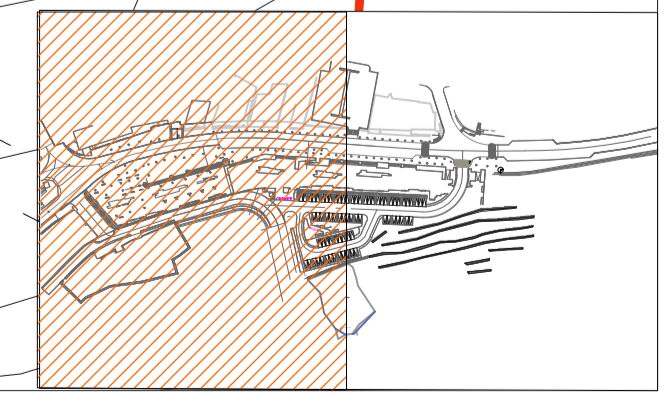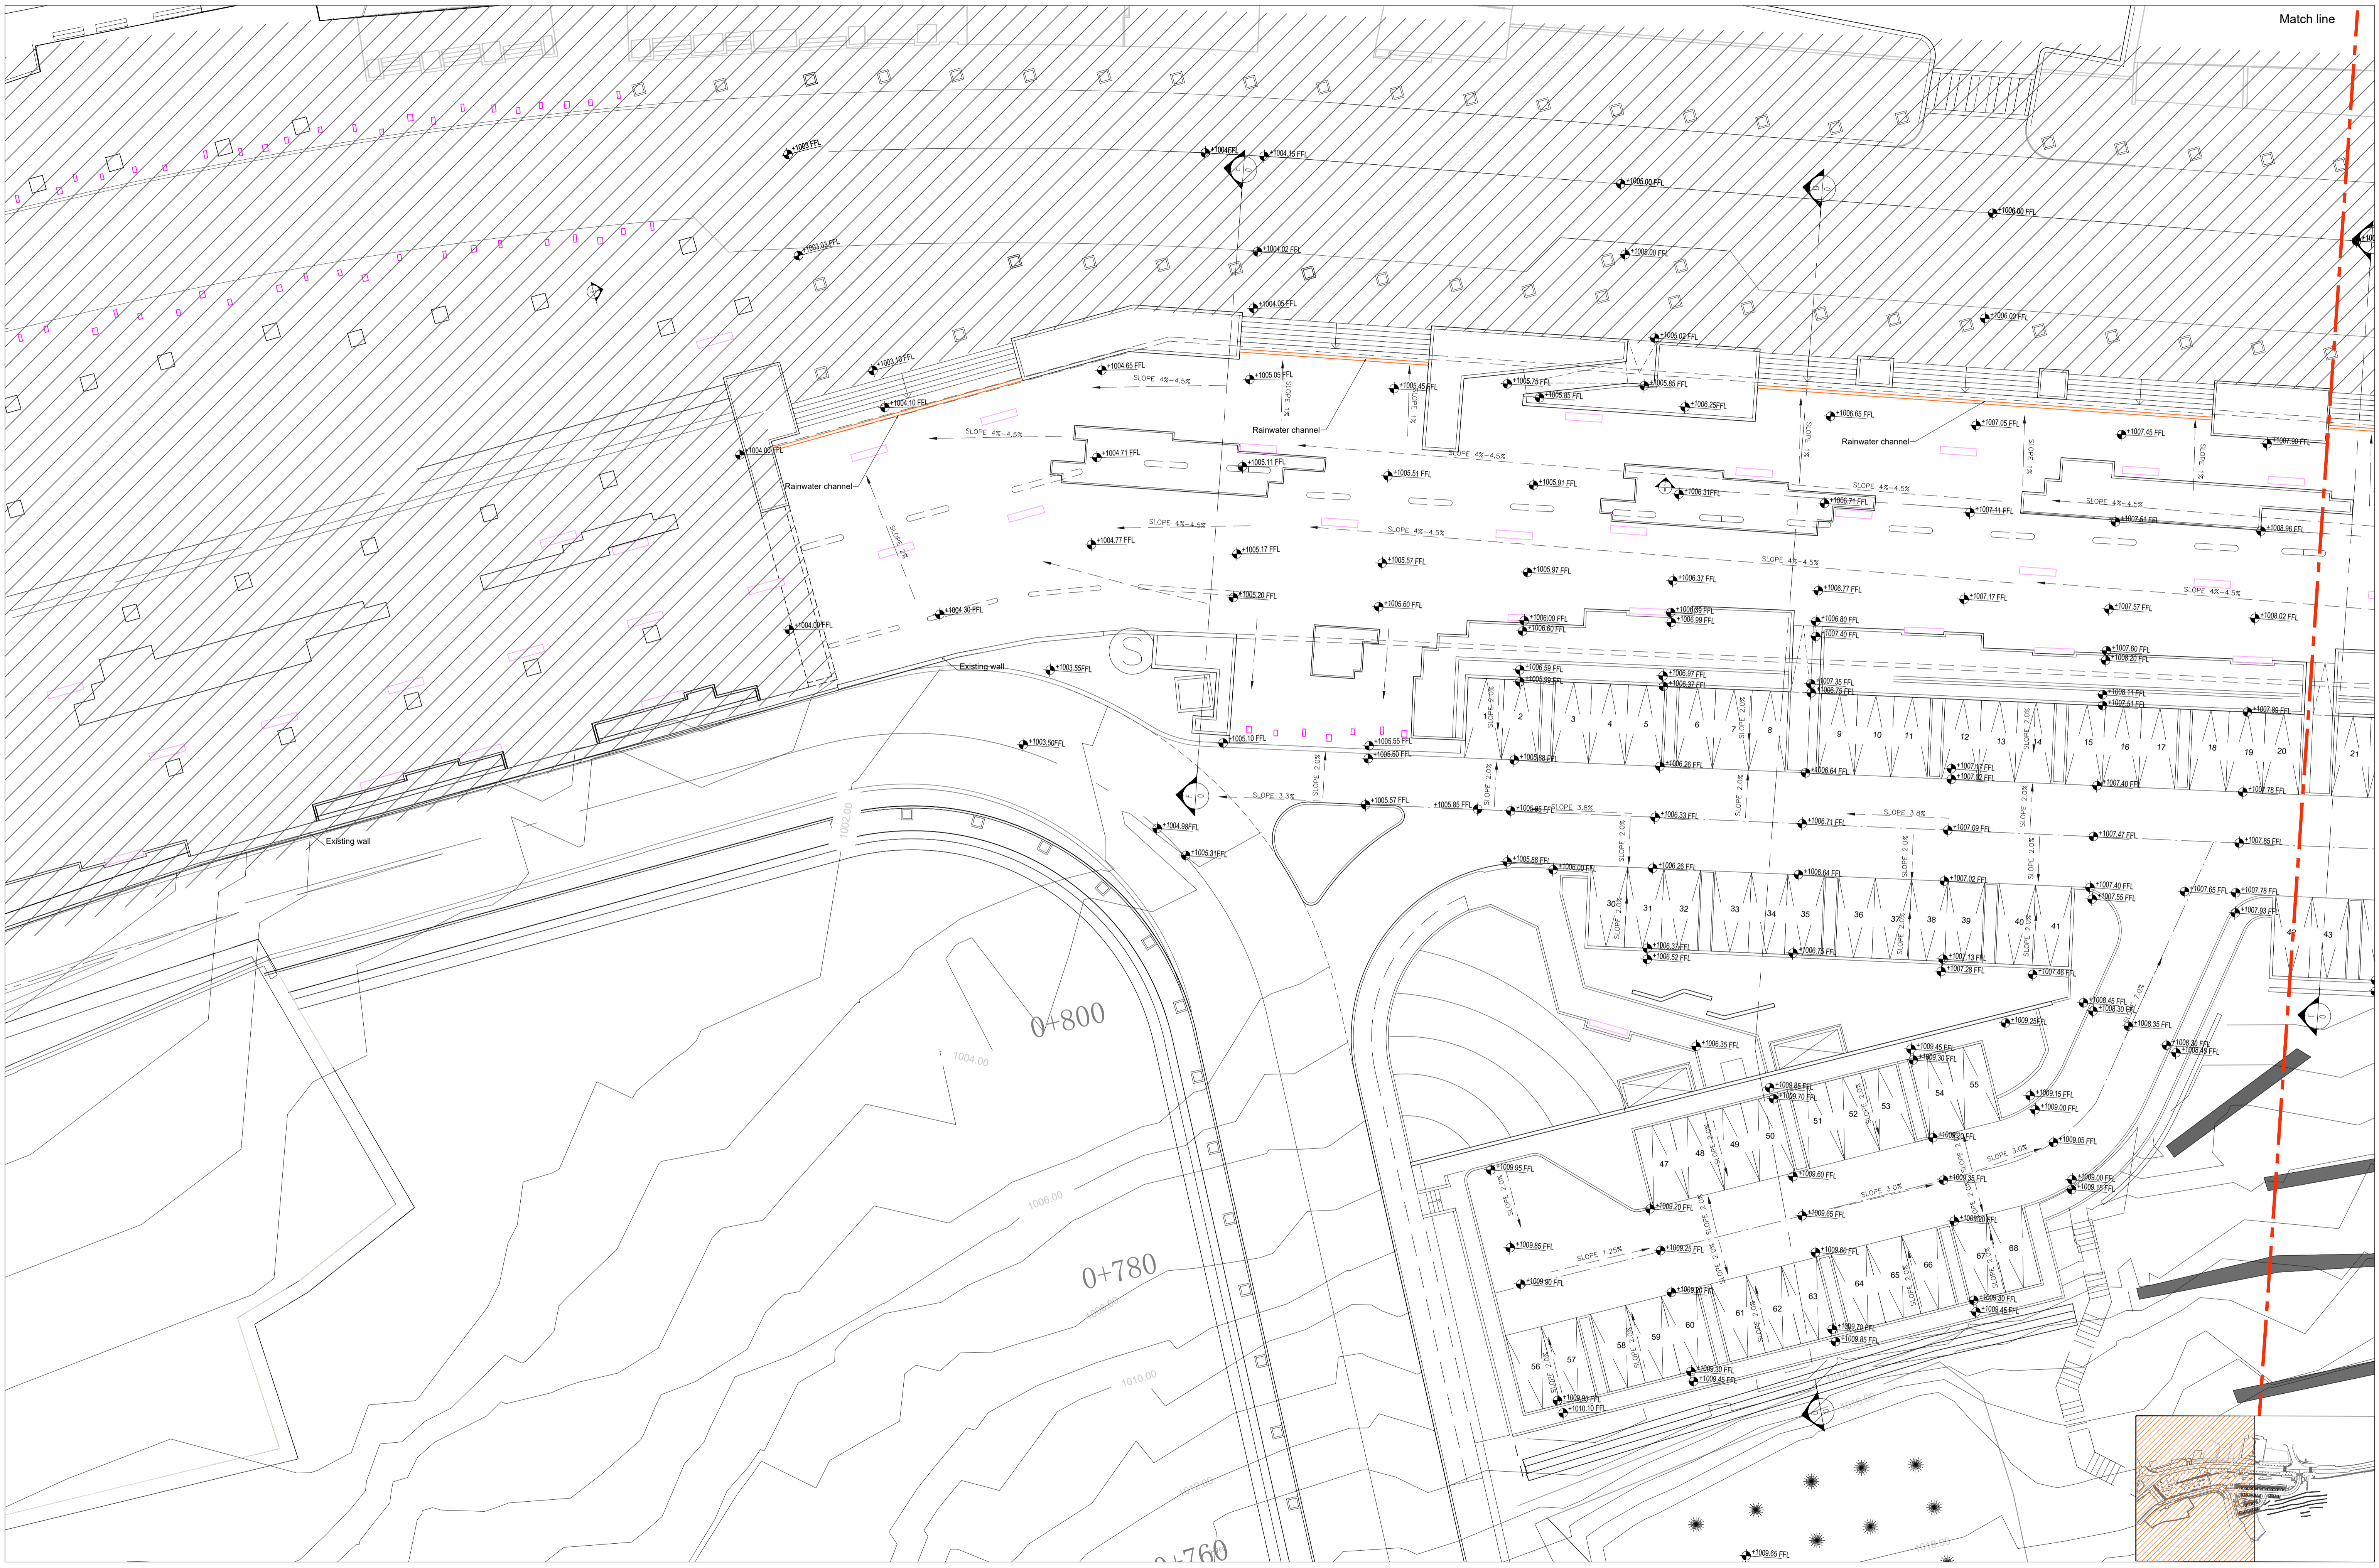



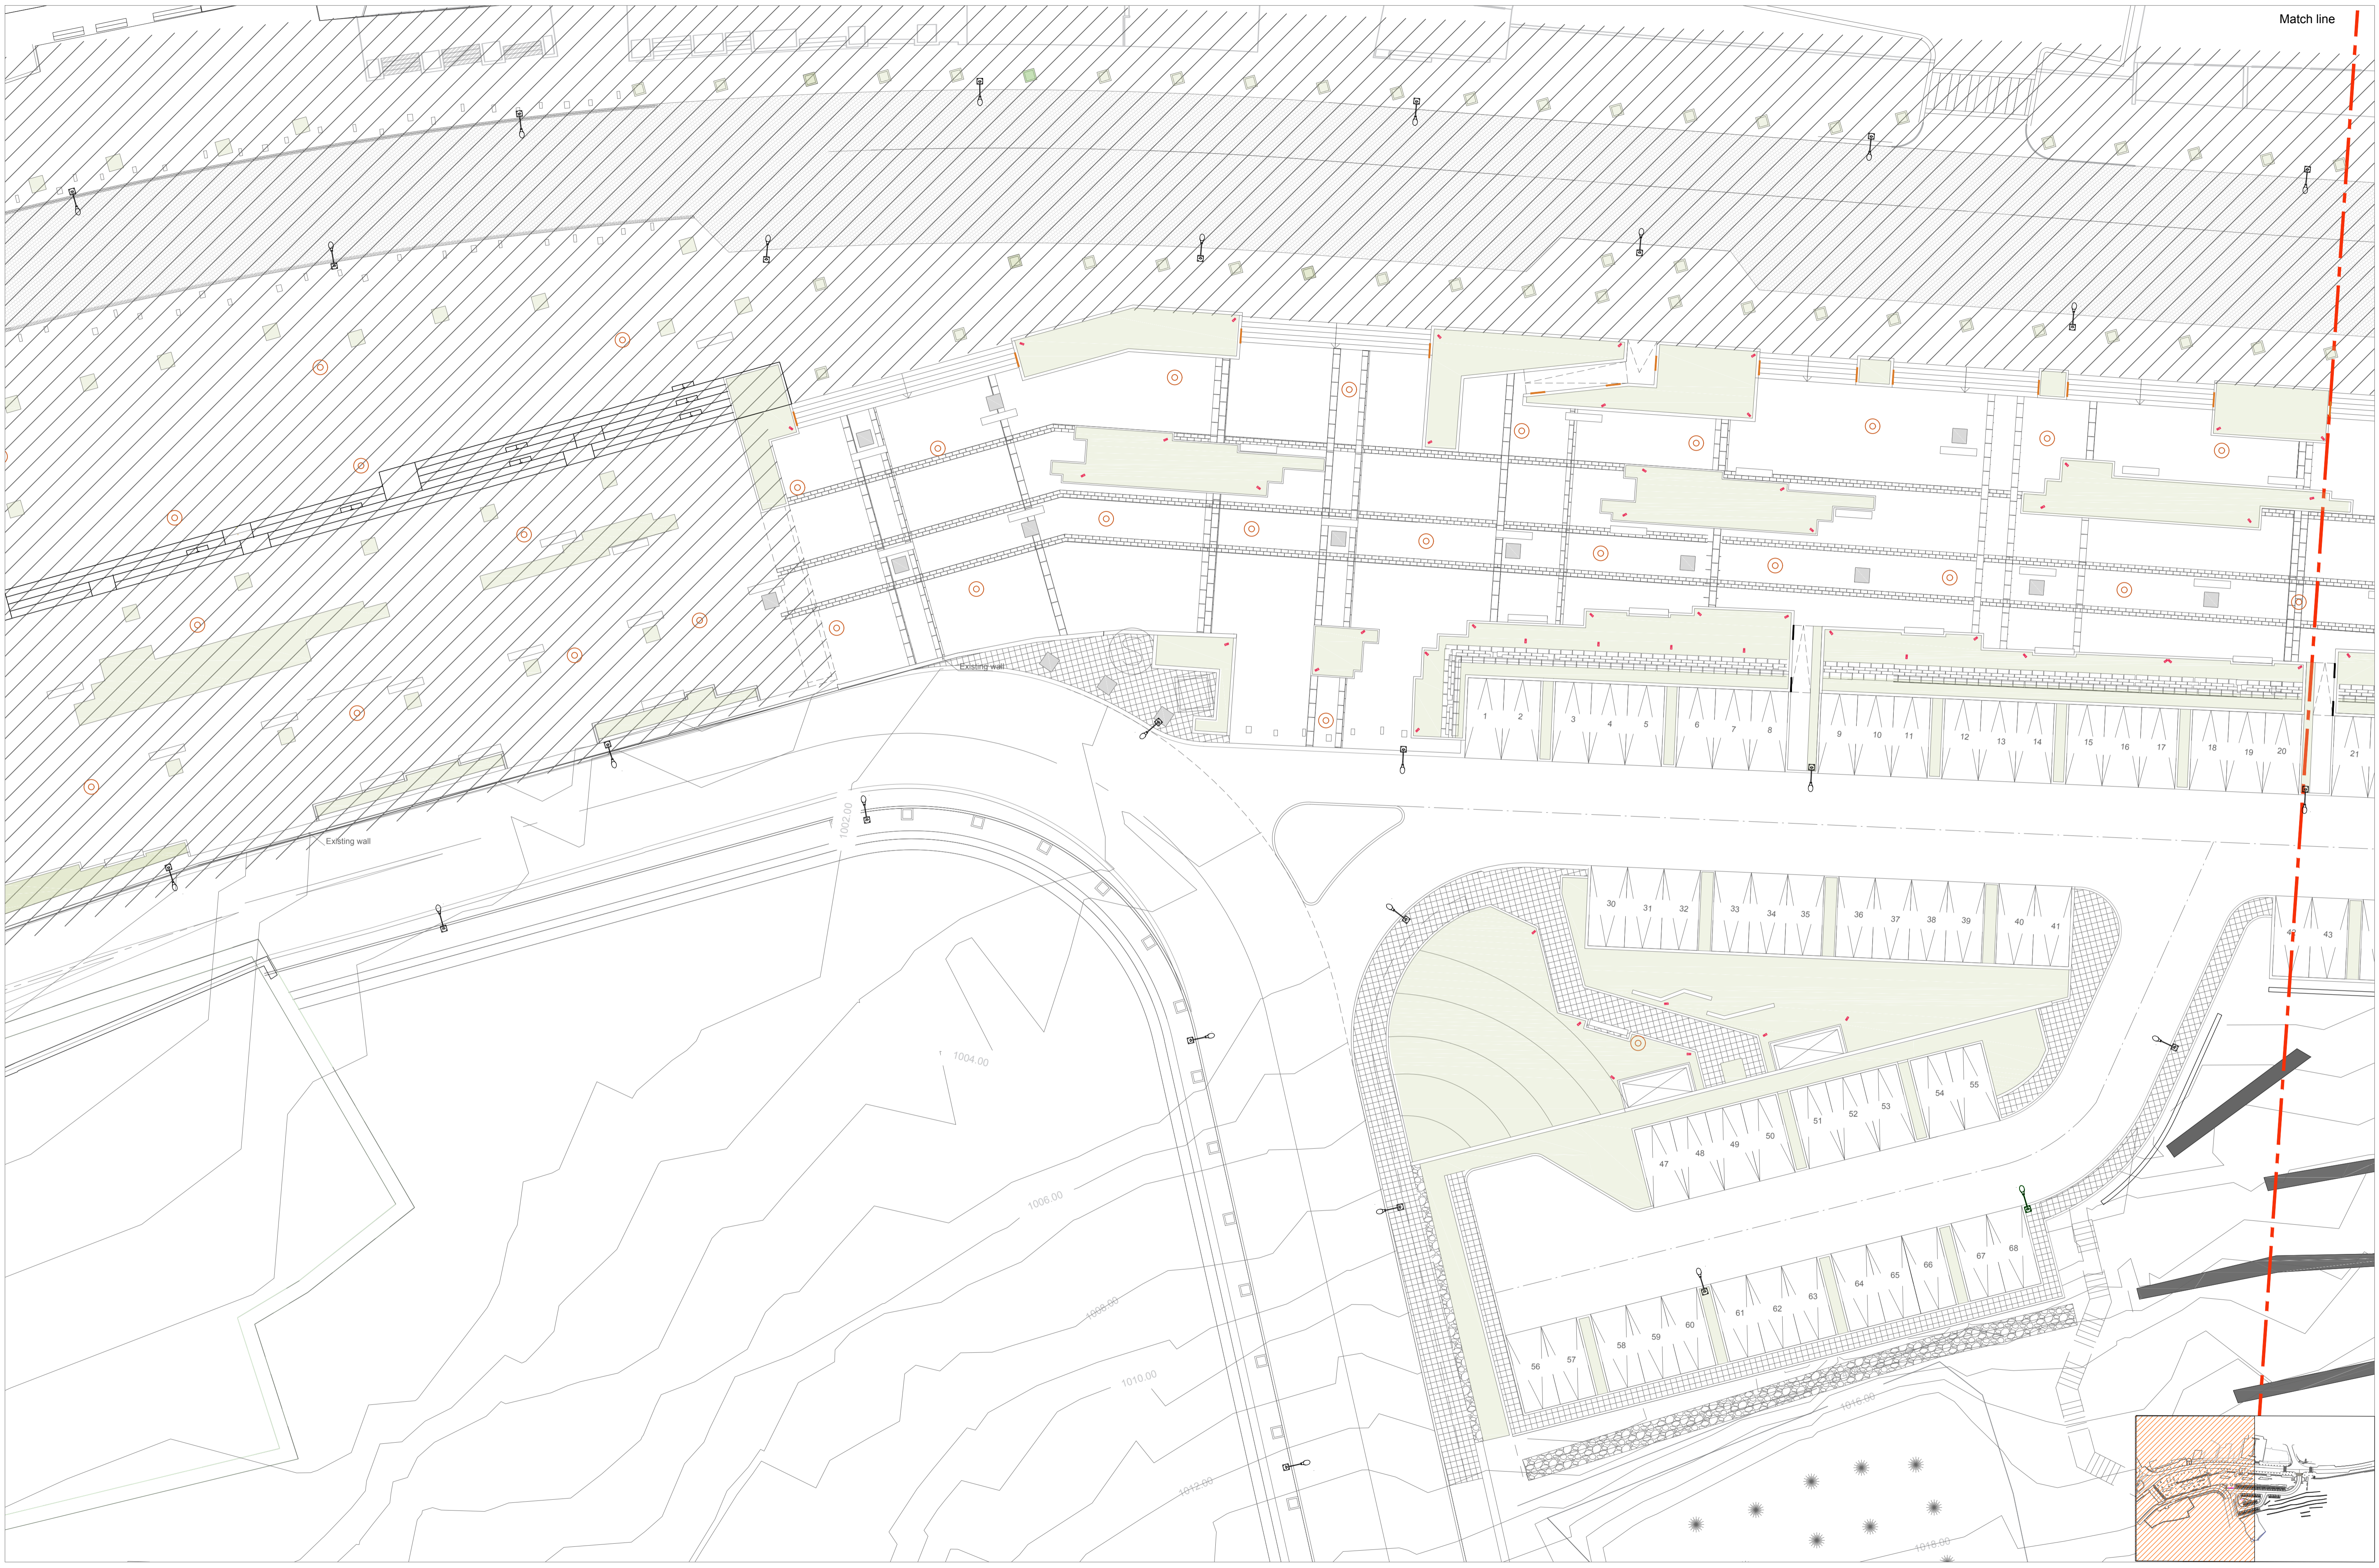

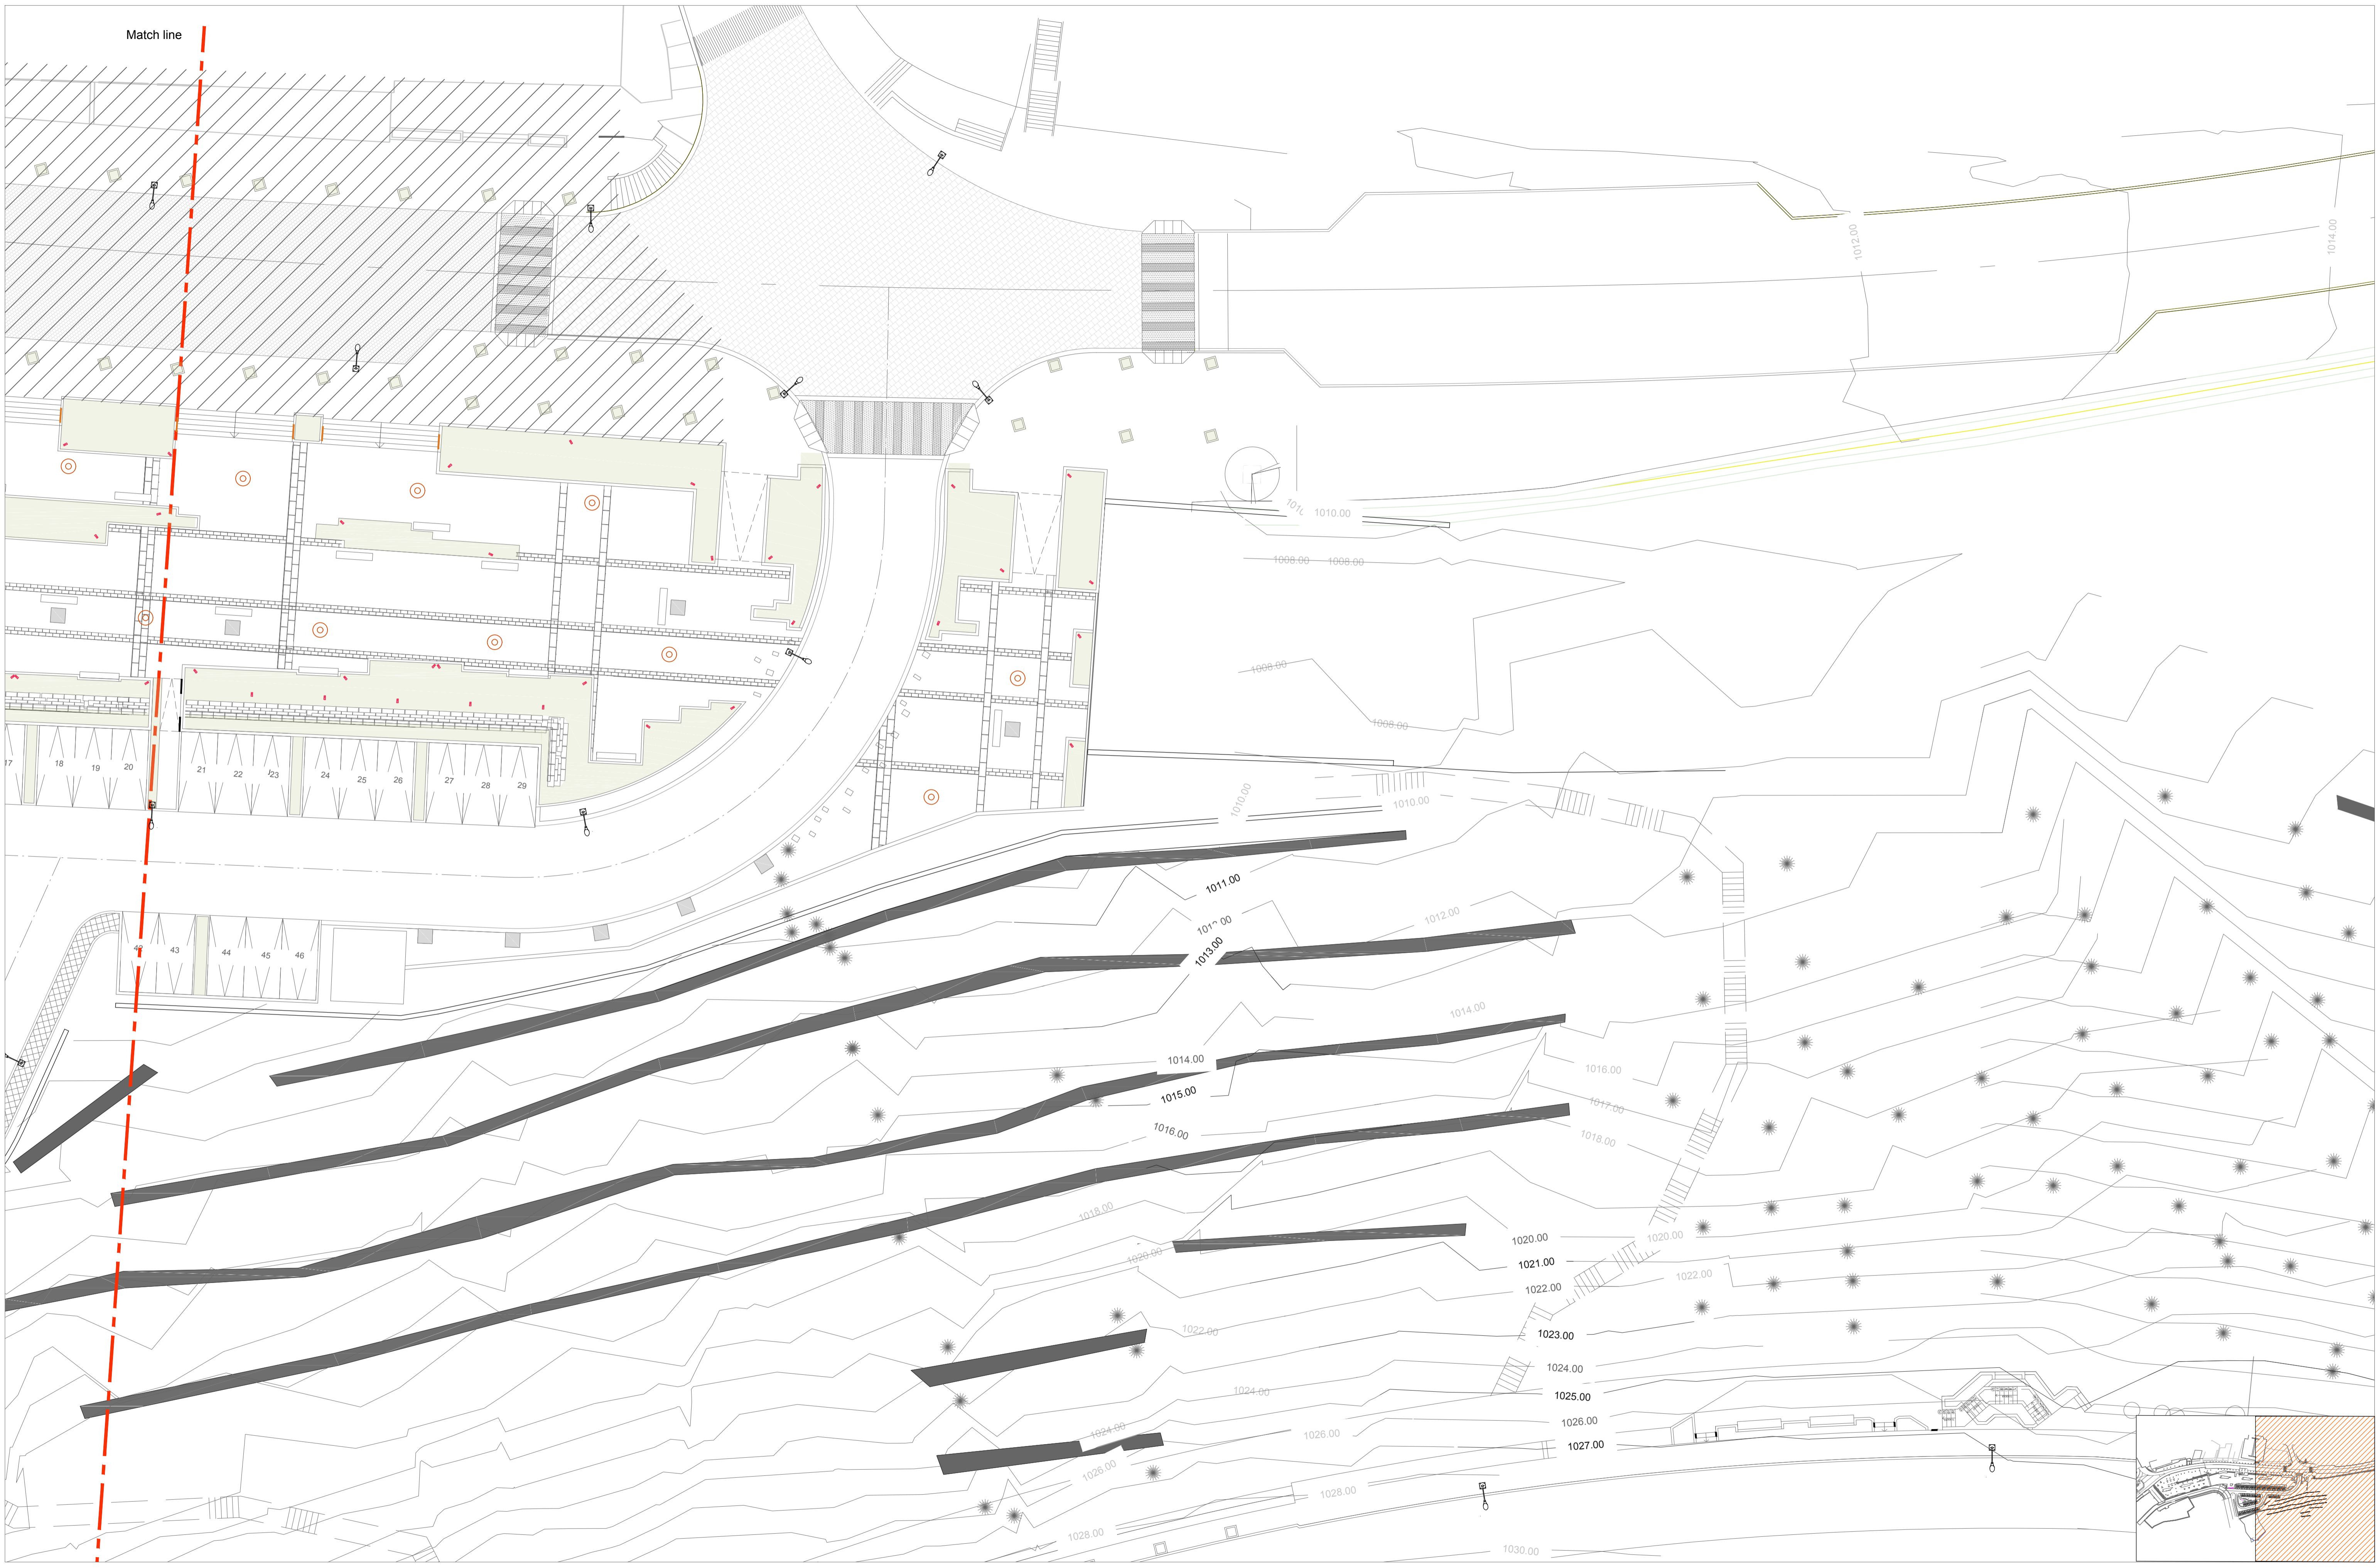

Match line

**KHAMMASH ARCHITECTS**  
 P.O. Box 921476, Amman, 11192, Jordan, Tel: +962 6 5695134, Fax: +962 6 5022366  
 E-mail: info@khammash.com


CLIENT  
 Petra Development & Tourism Region Authority  
 P.O. Box 7693, Amman 11118, Jordan | T +962 6 5055555 | F +962 6 4650639 | W www.hbf.com

PROJECT  
 Road 4  
 ADDRESS  
 Wadi Musa, JORDAN


STATUS  
 TENDER  
 Copyright © Khammash Architects  
 THIS DRAWING IS AND IN ALL TIMES REMAINS THE EXCLUSIVE PROPERTY OF KHAMMASH ARCHITECTS. ALL MEASUREMENTS MUST BE CHECKED BY THE CONTRACTOR ON SITE BEFORE THE COMMENCEMENT OF ANY WORKS.







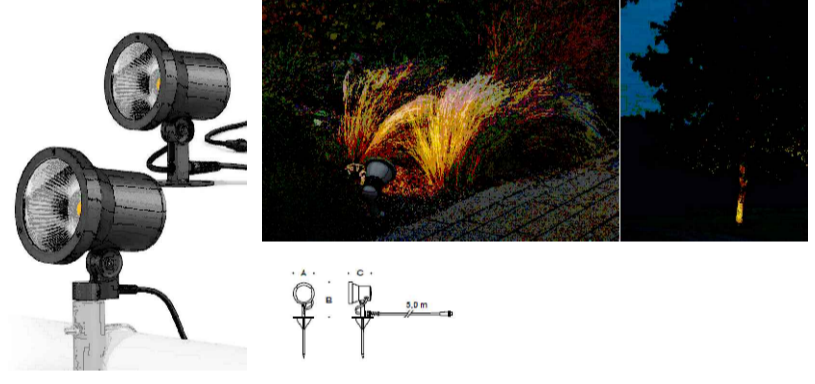



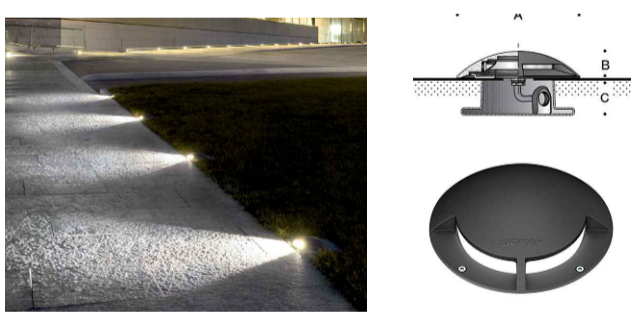
 
NOTES

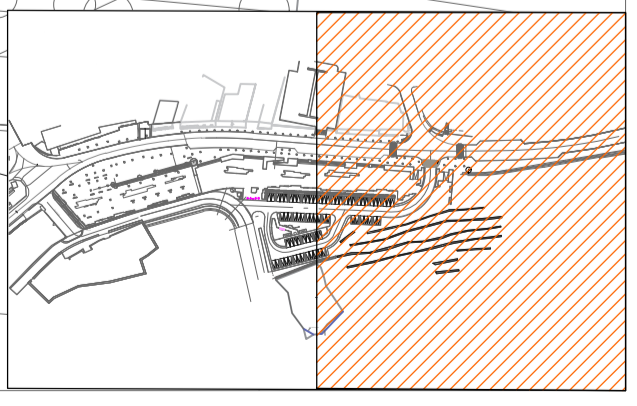



ISSUE	DATE	AMENDMENT	CHECKED

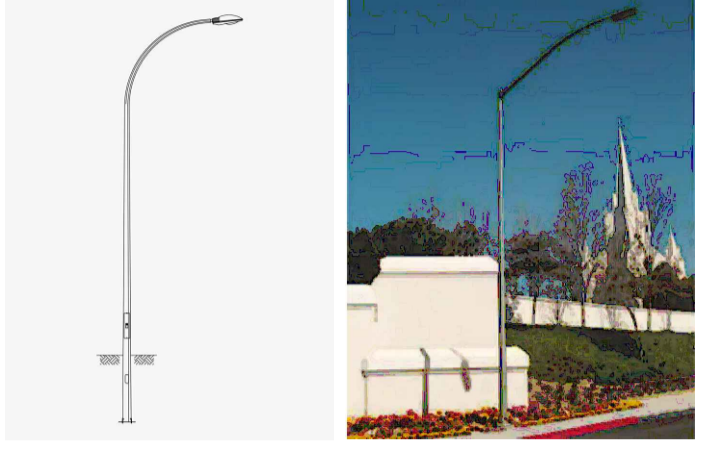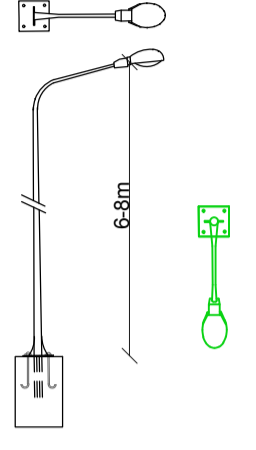
DRAWN: \_\_\_\_\_  
 CHECKED: \_\_\_\_\_  
 NORTH:   
 APPROVED: AK  
 SCALE: 1:200 @ A1

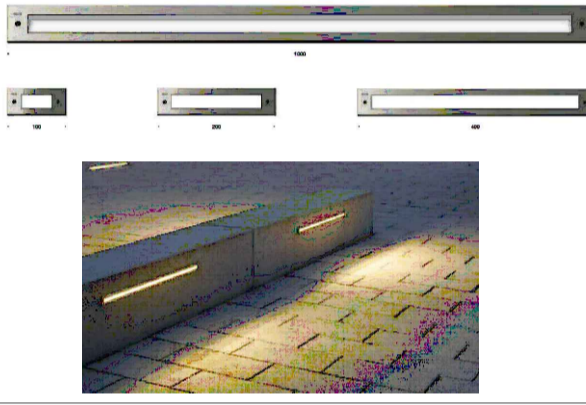DRAWING TITLE  
 SITE PLAN LIGHTING PLAN (PART 2)  
 SHEET NUMBER: A-ZB-021  
 ISSUE: \_\_\_\_\_ DATE: Mar.2022

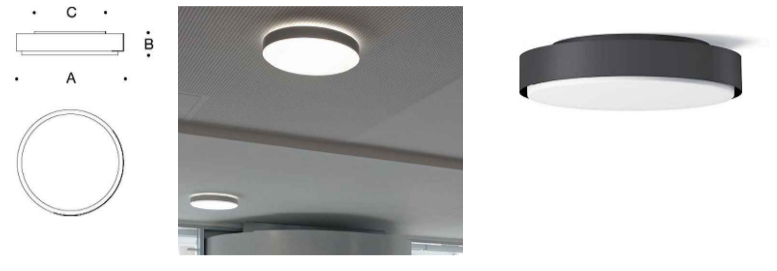


OUTDOOR LIGHTING	LIGHTING LOCATION	DETAILS
L1 STREET LIGHTING POLES 6-8M HEIGHTS		
L3 POLES 4 M HEIGHTS		
L4 STAIRS & WALL LIGHTING		
L5 GARDEN FLOODLIGHTS WITH EARTH SPIKE		
L6 WALL LUMINAIRES LIGHT EMISSION ON TWO SIDES		
L7 GROUND-MOUNTED LUMINAIRE		


CEILING LIGHTING	LIGHTING LOCATION	DETAILS
L8 CEILING AND WALL LUMINAIRE		
L9 CEILING AND WALL LUMINAIRE		

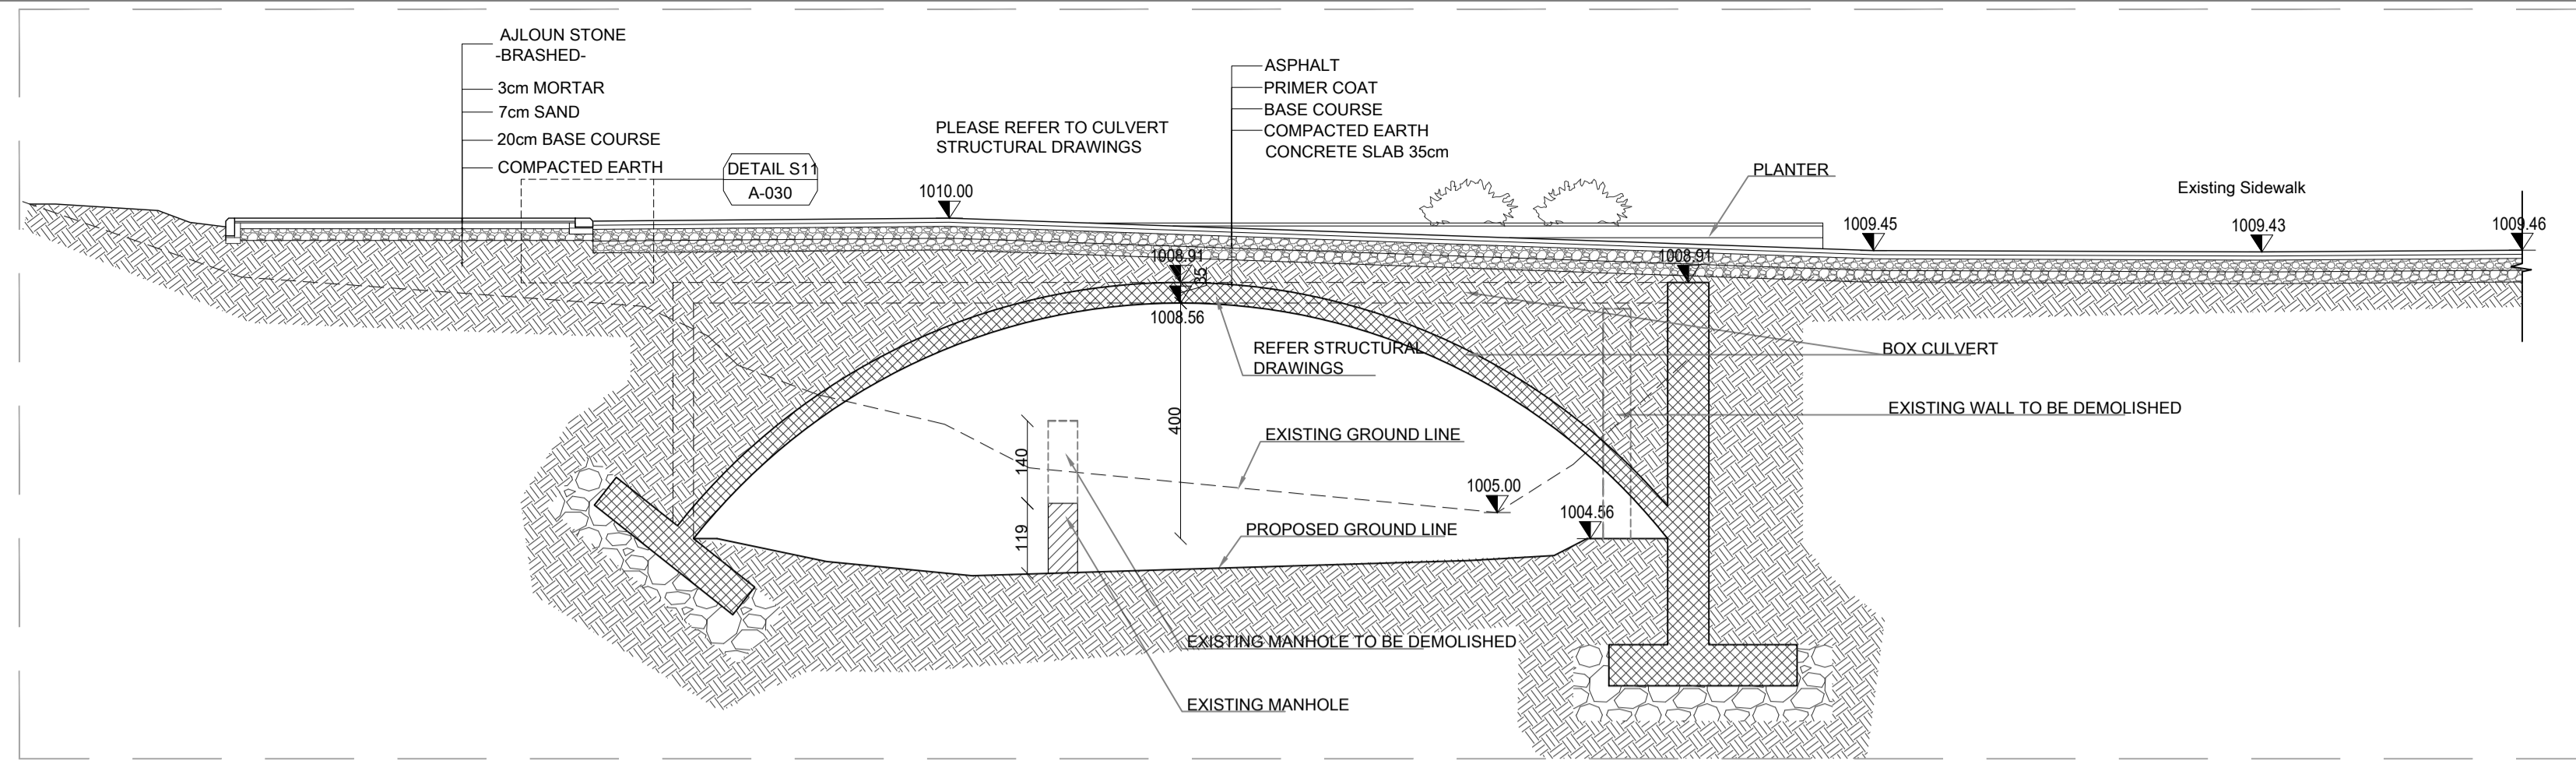


SECTION A-A

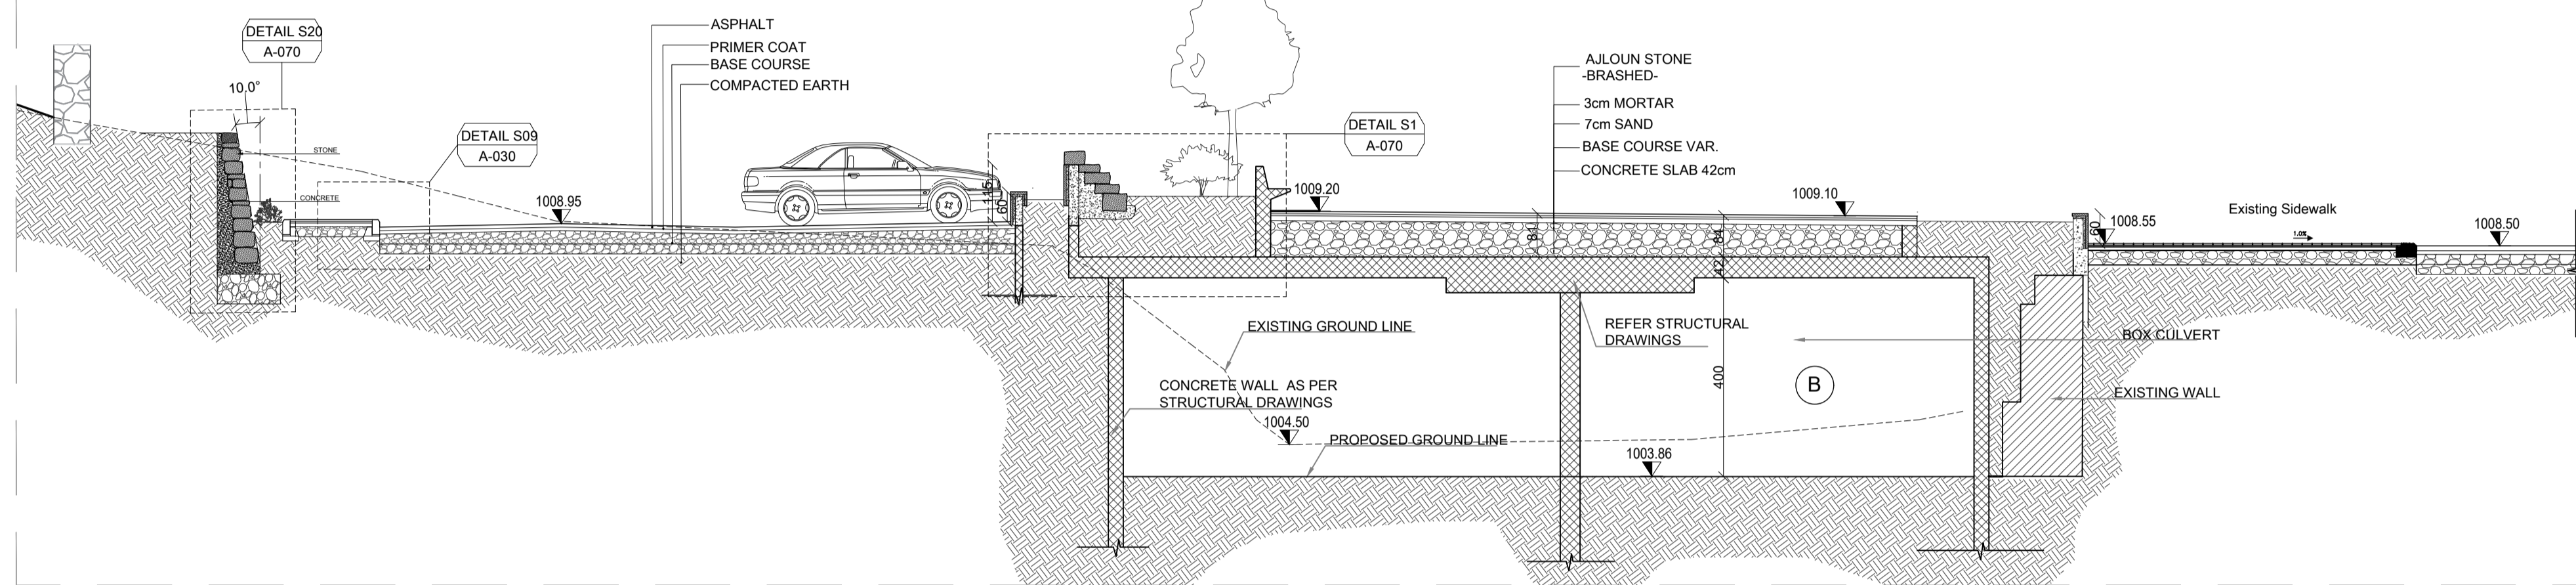

SECTION B-B

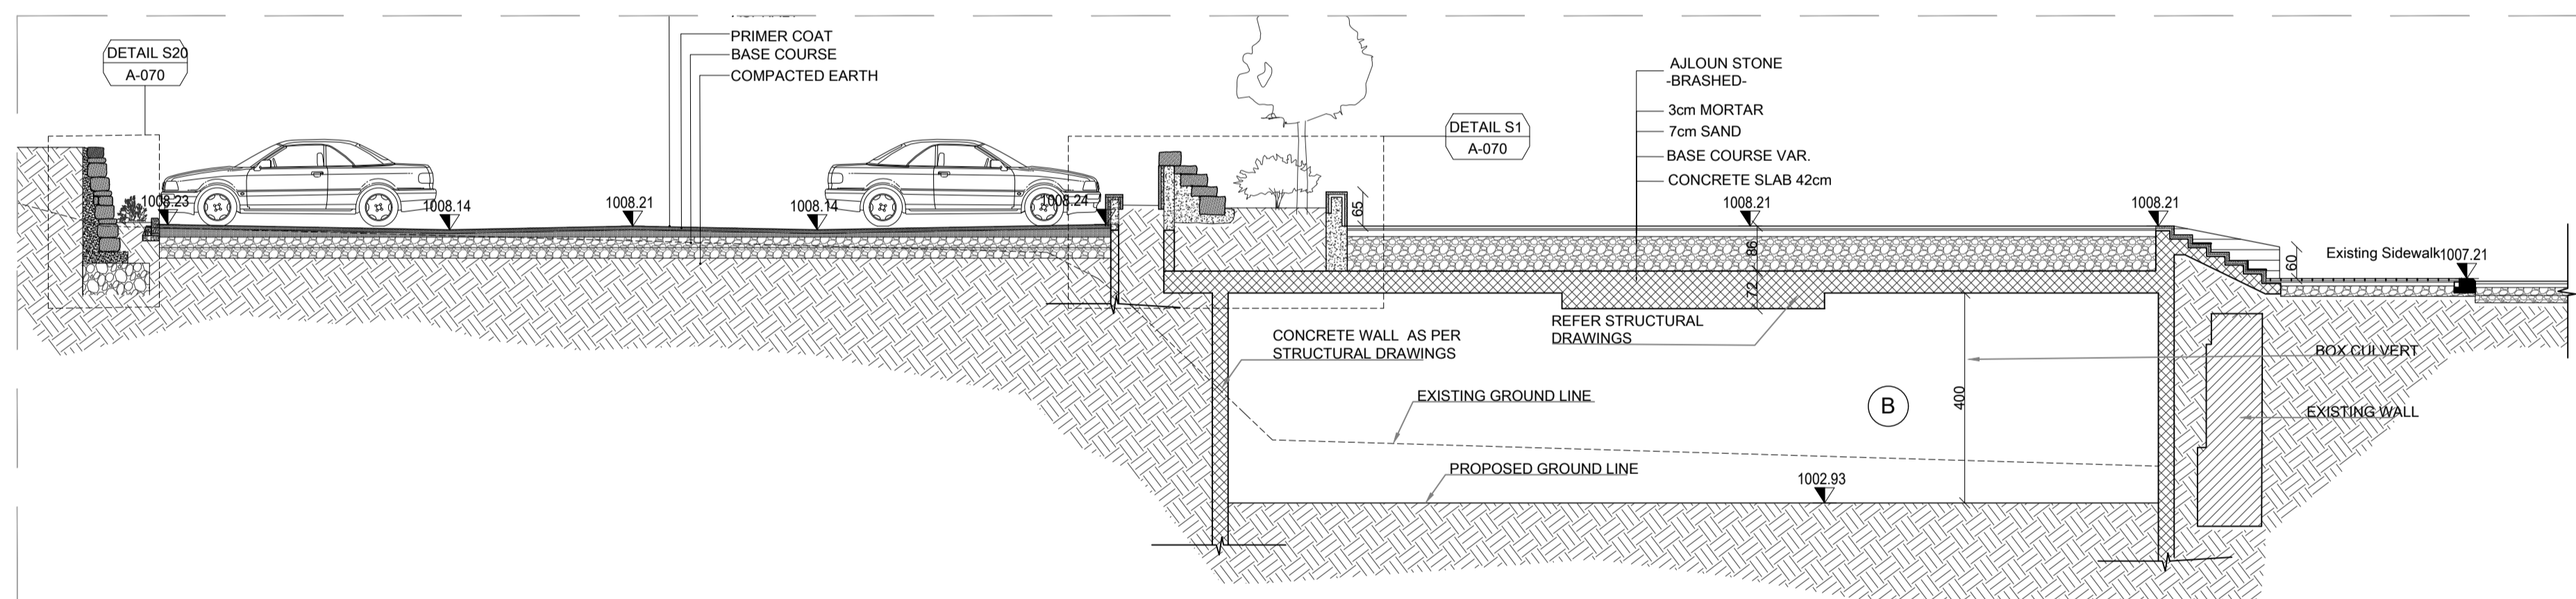


SECTION C-C

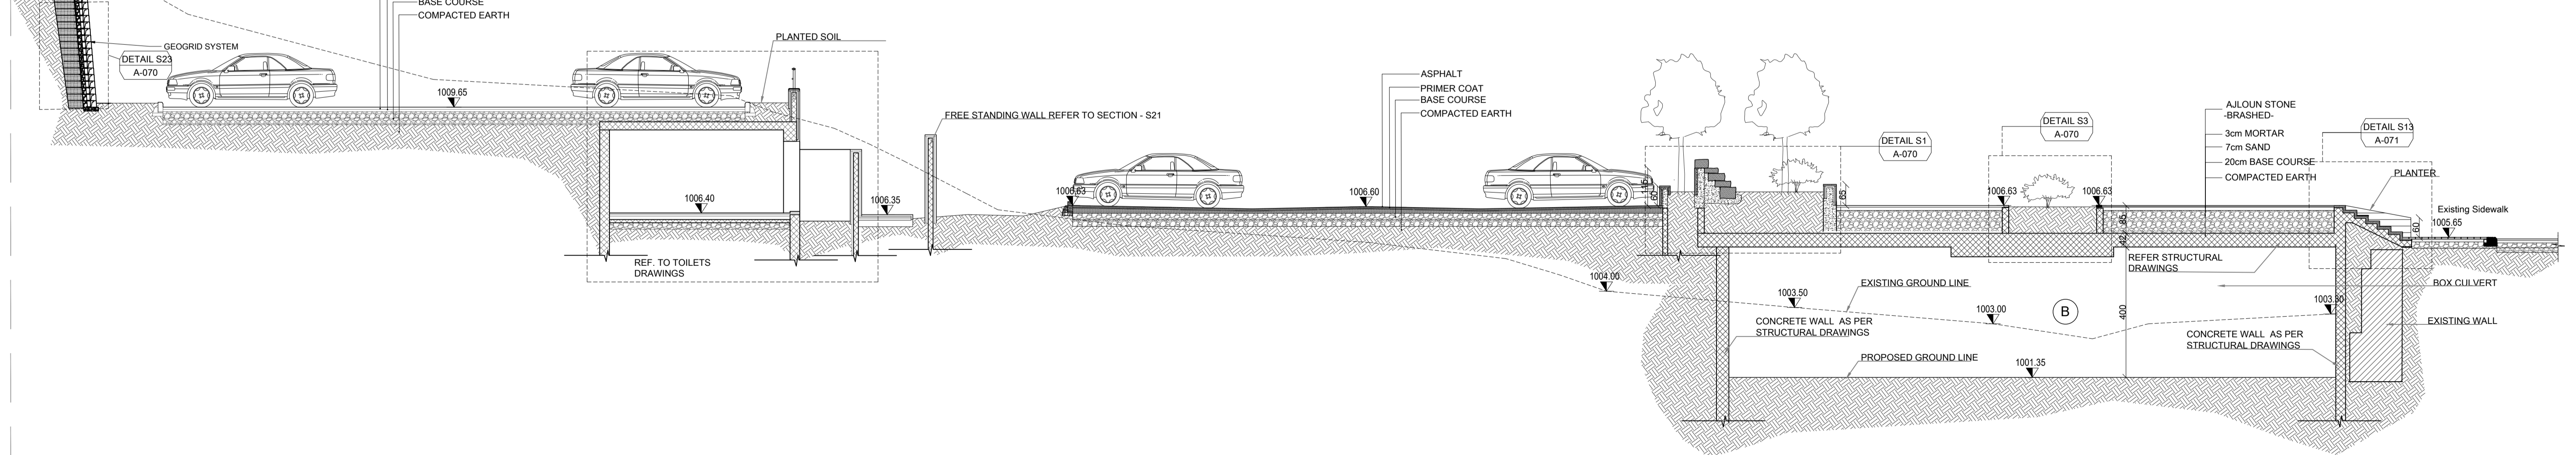


SECTION D-D



(A)	Rubble stone
(B)	Concrete

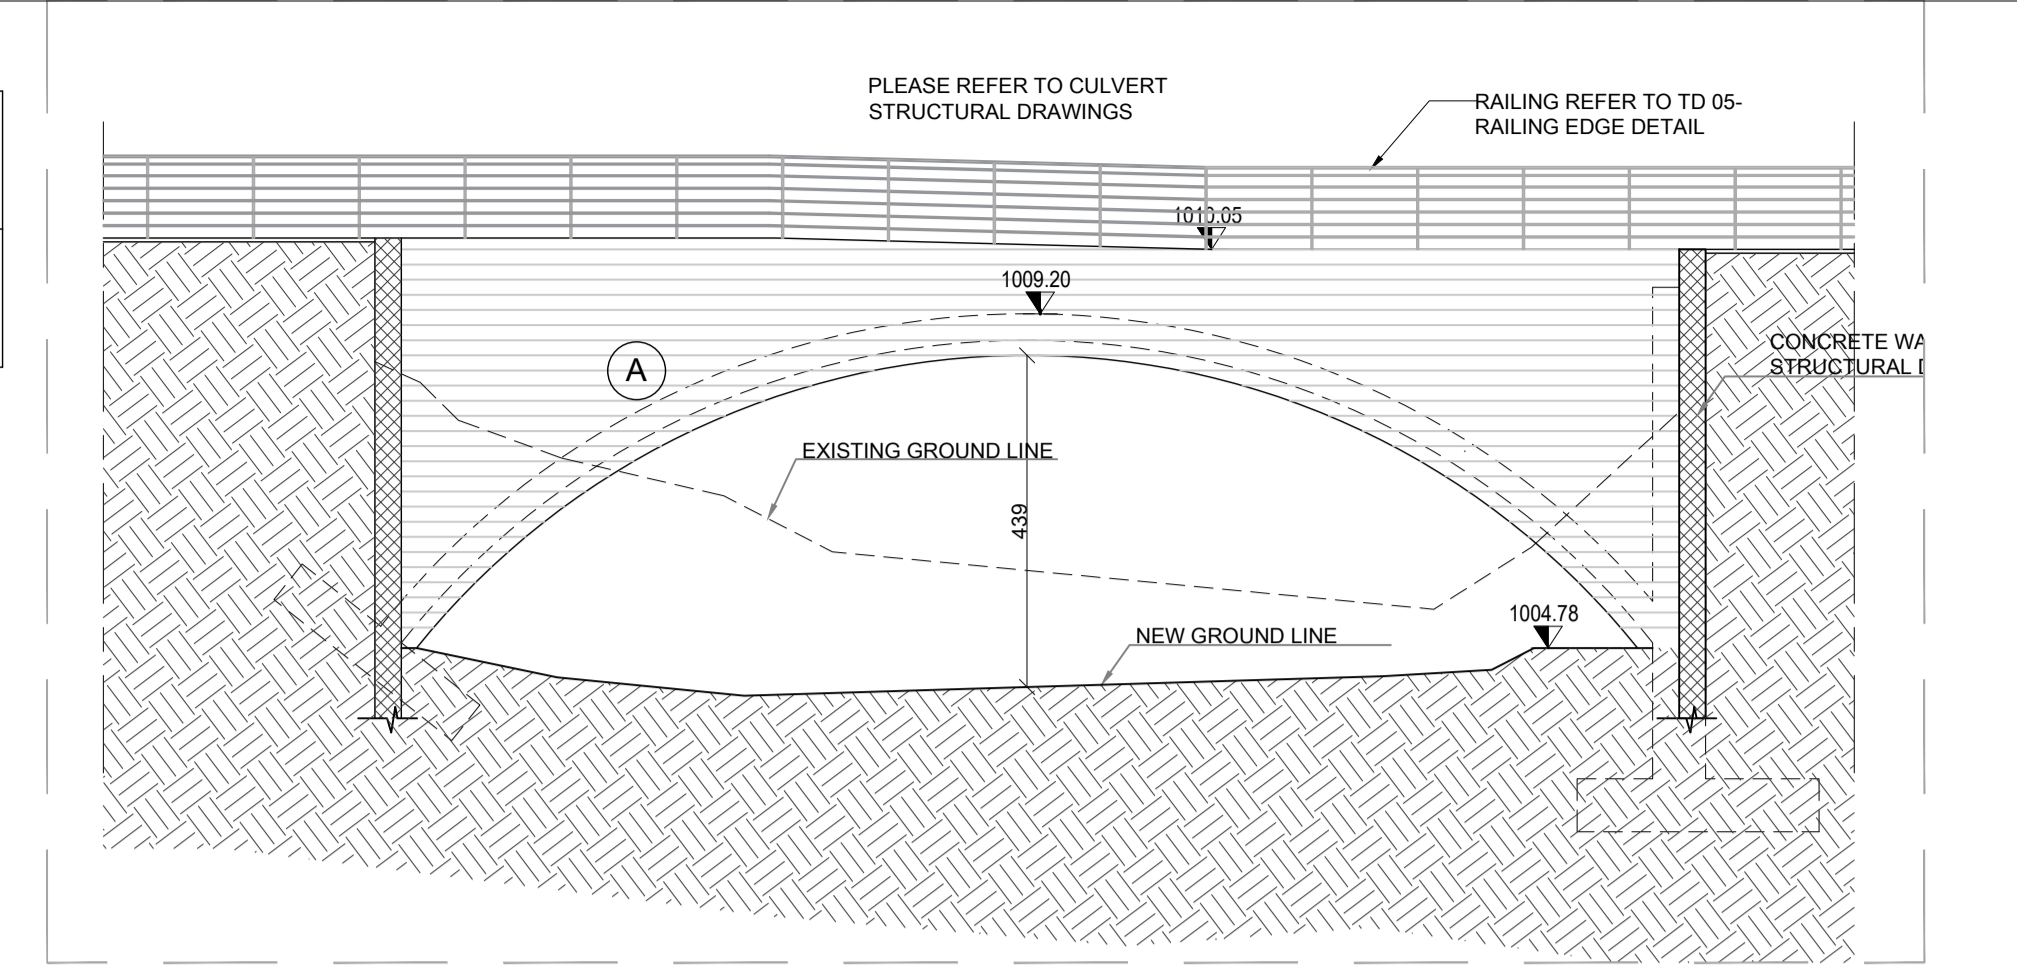


ELEVATION 01

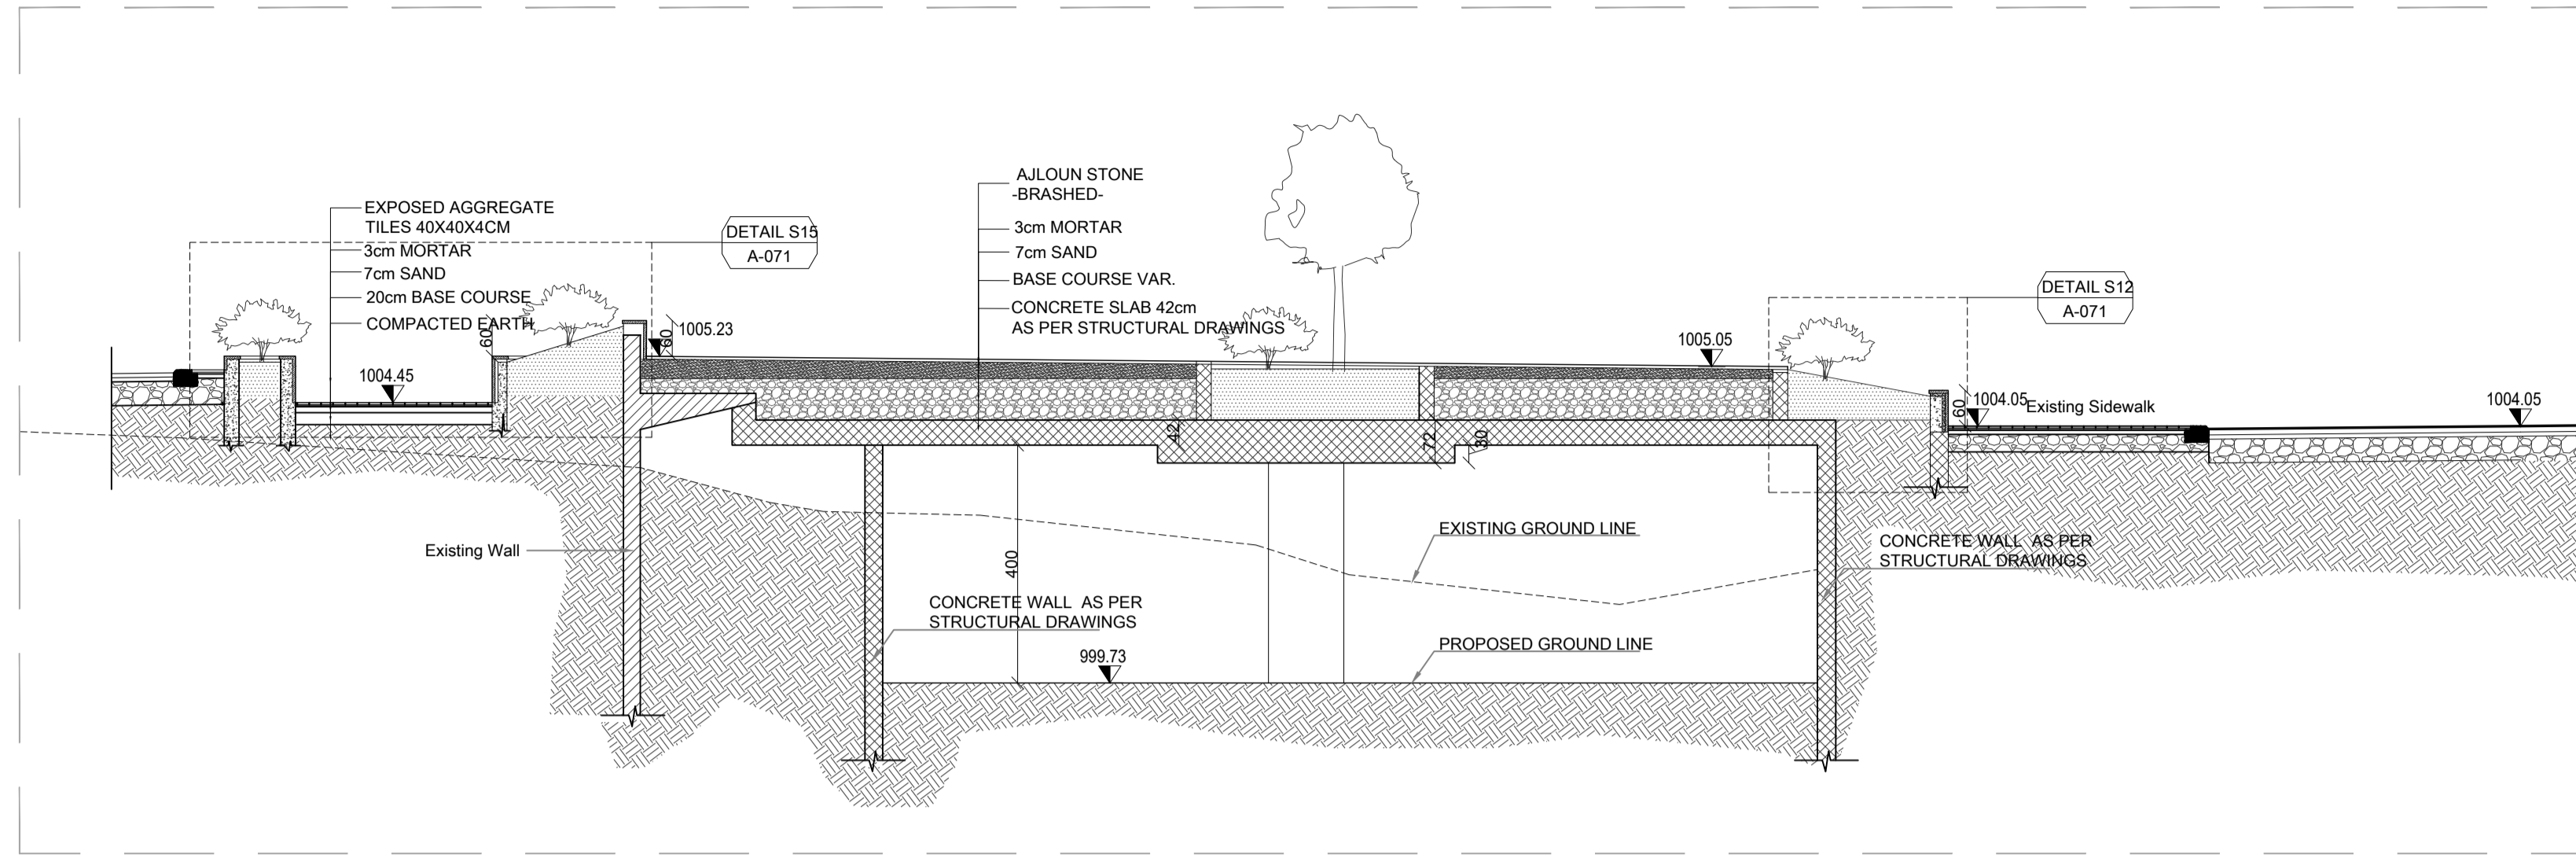


(A)	Rubble stone
(B)	Concrete

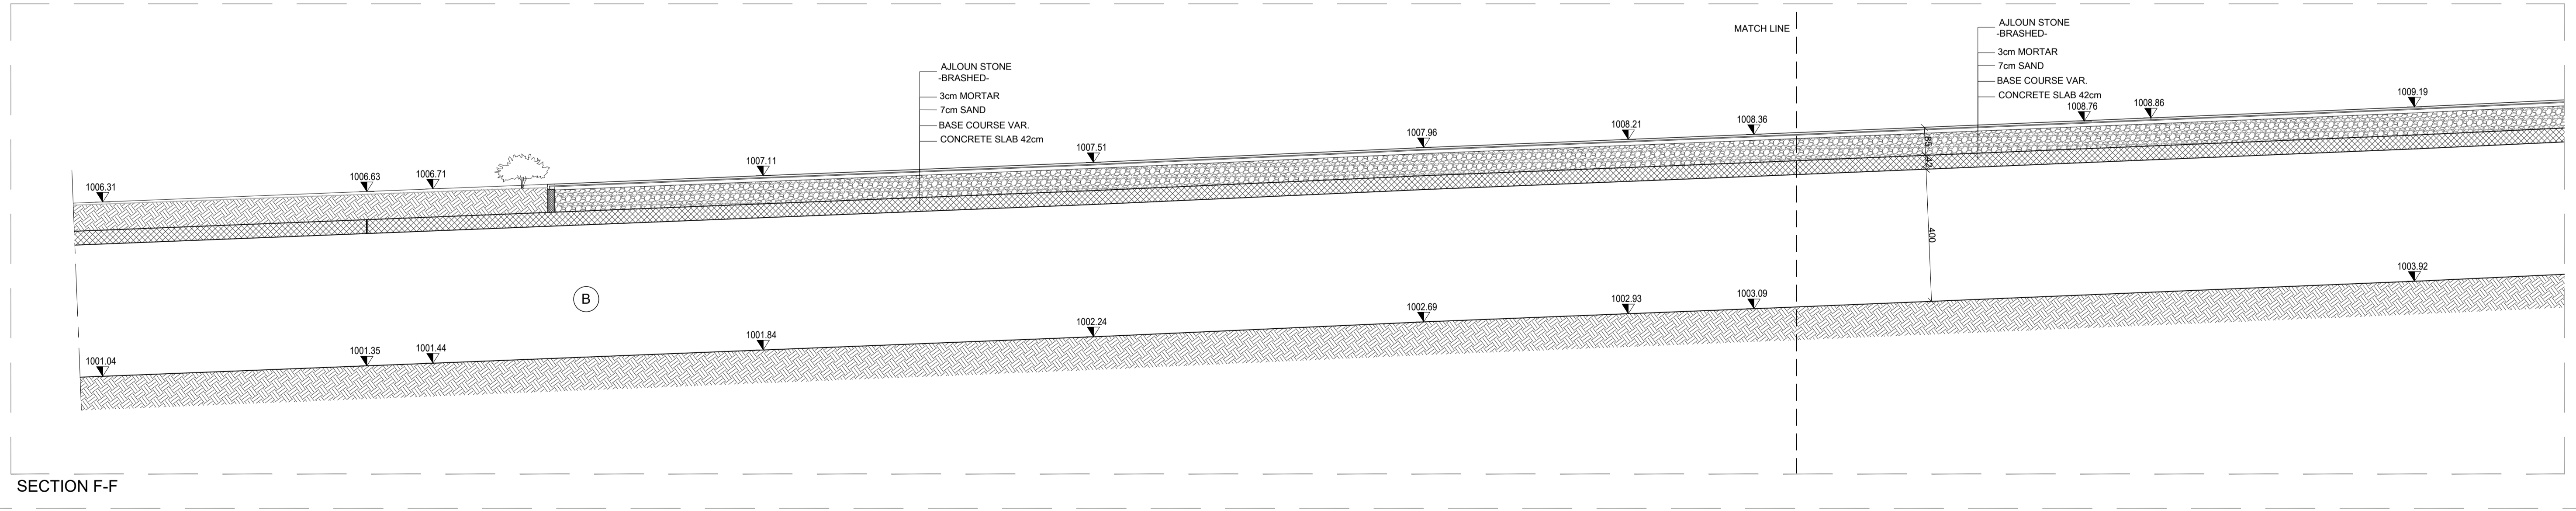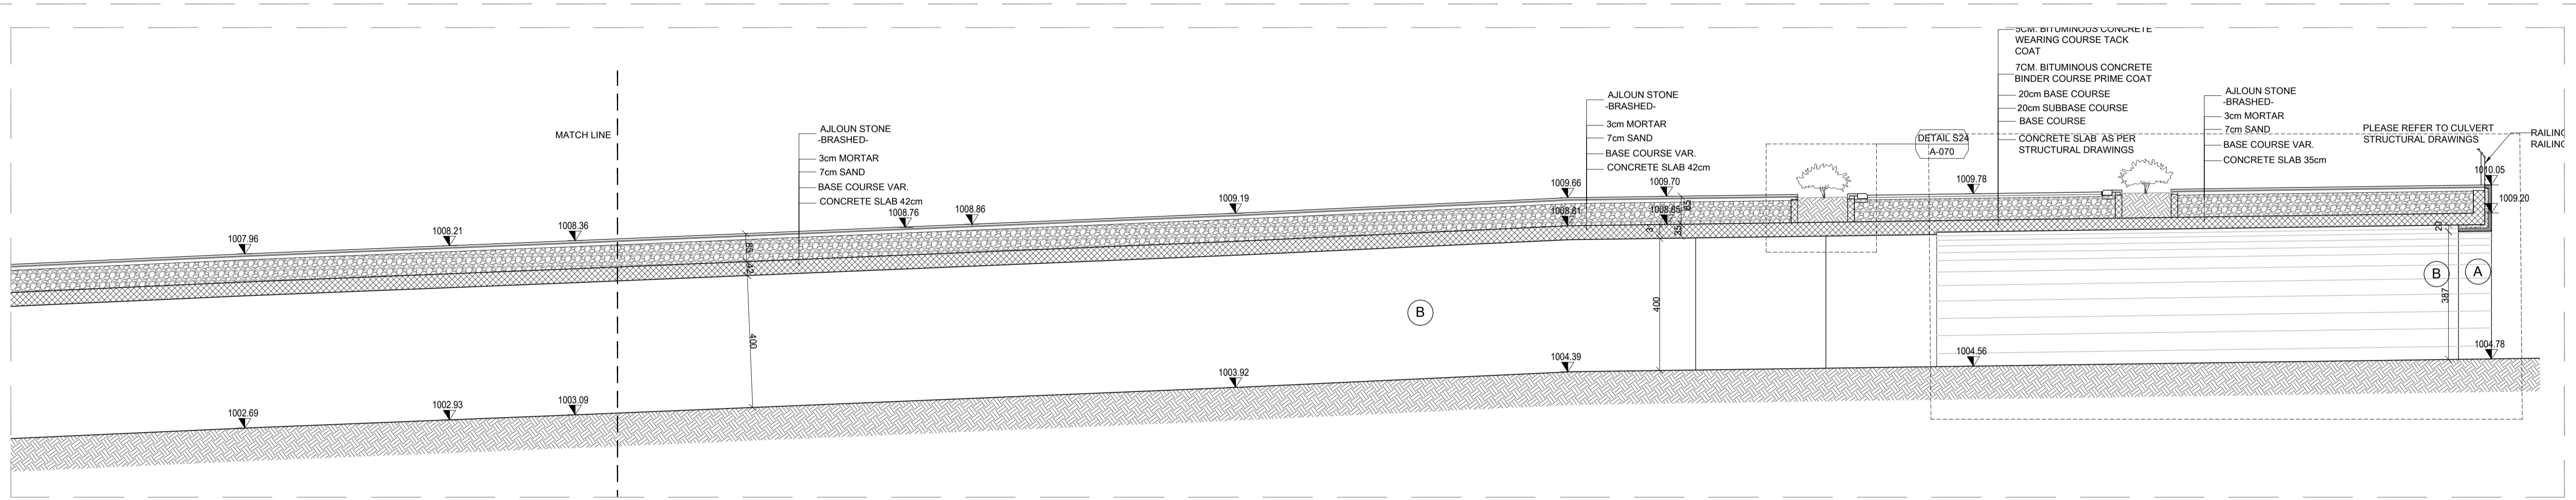


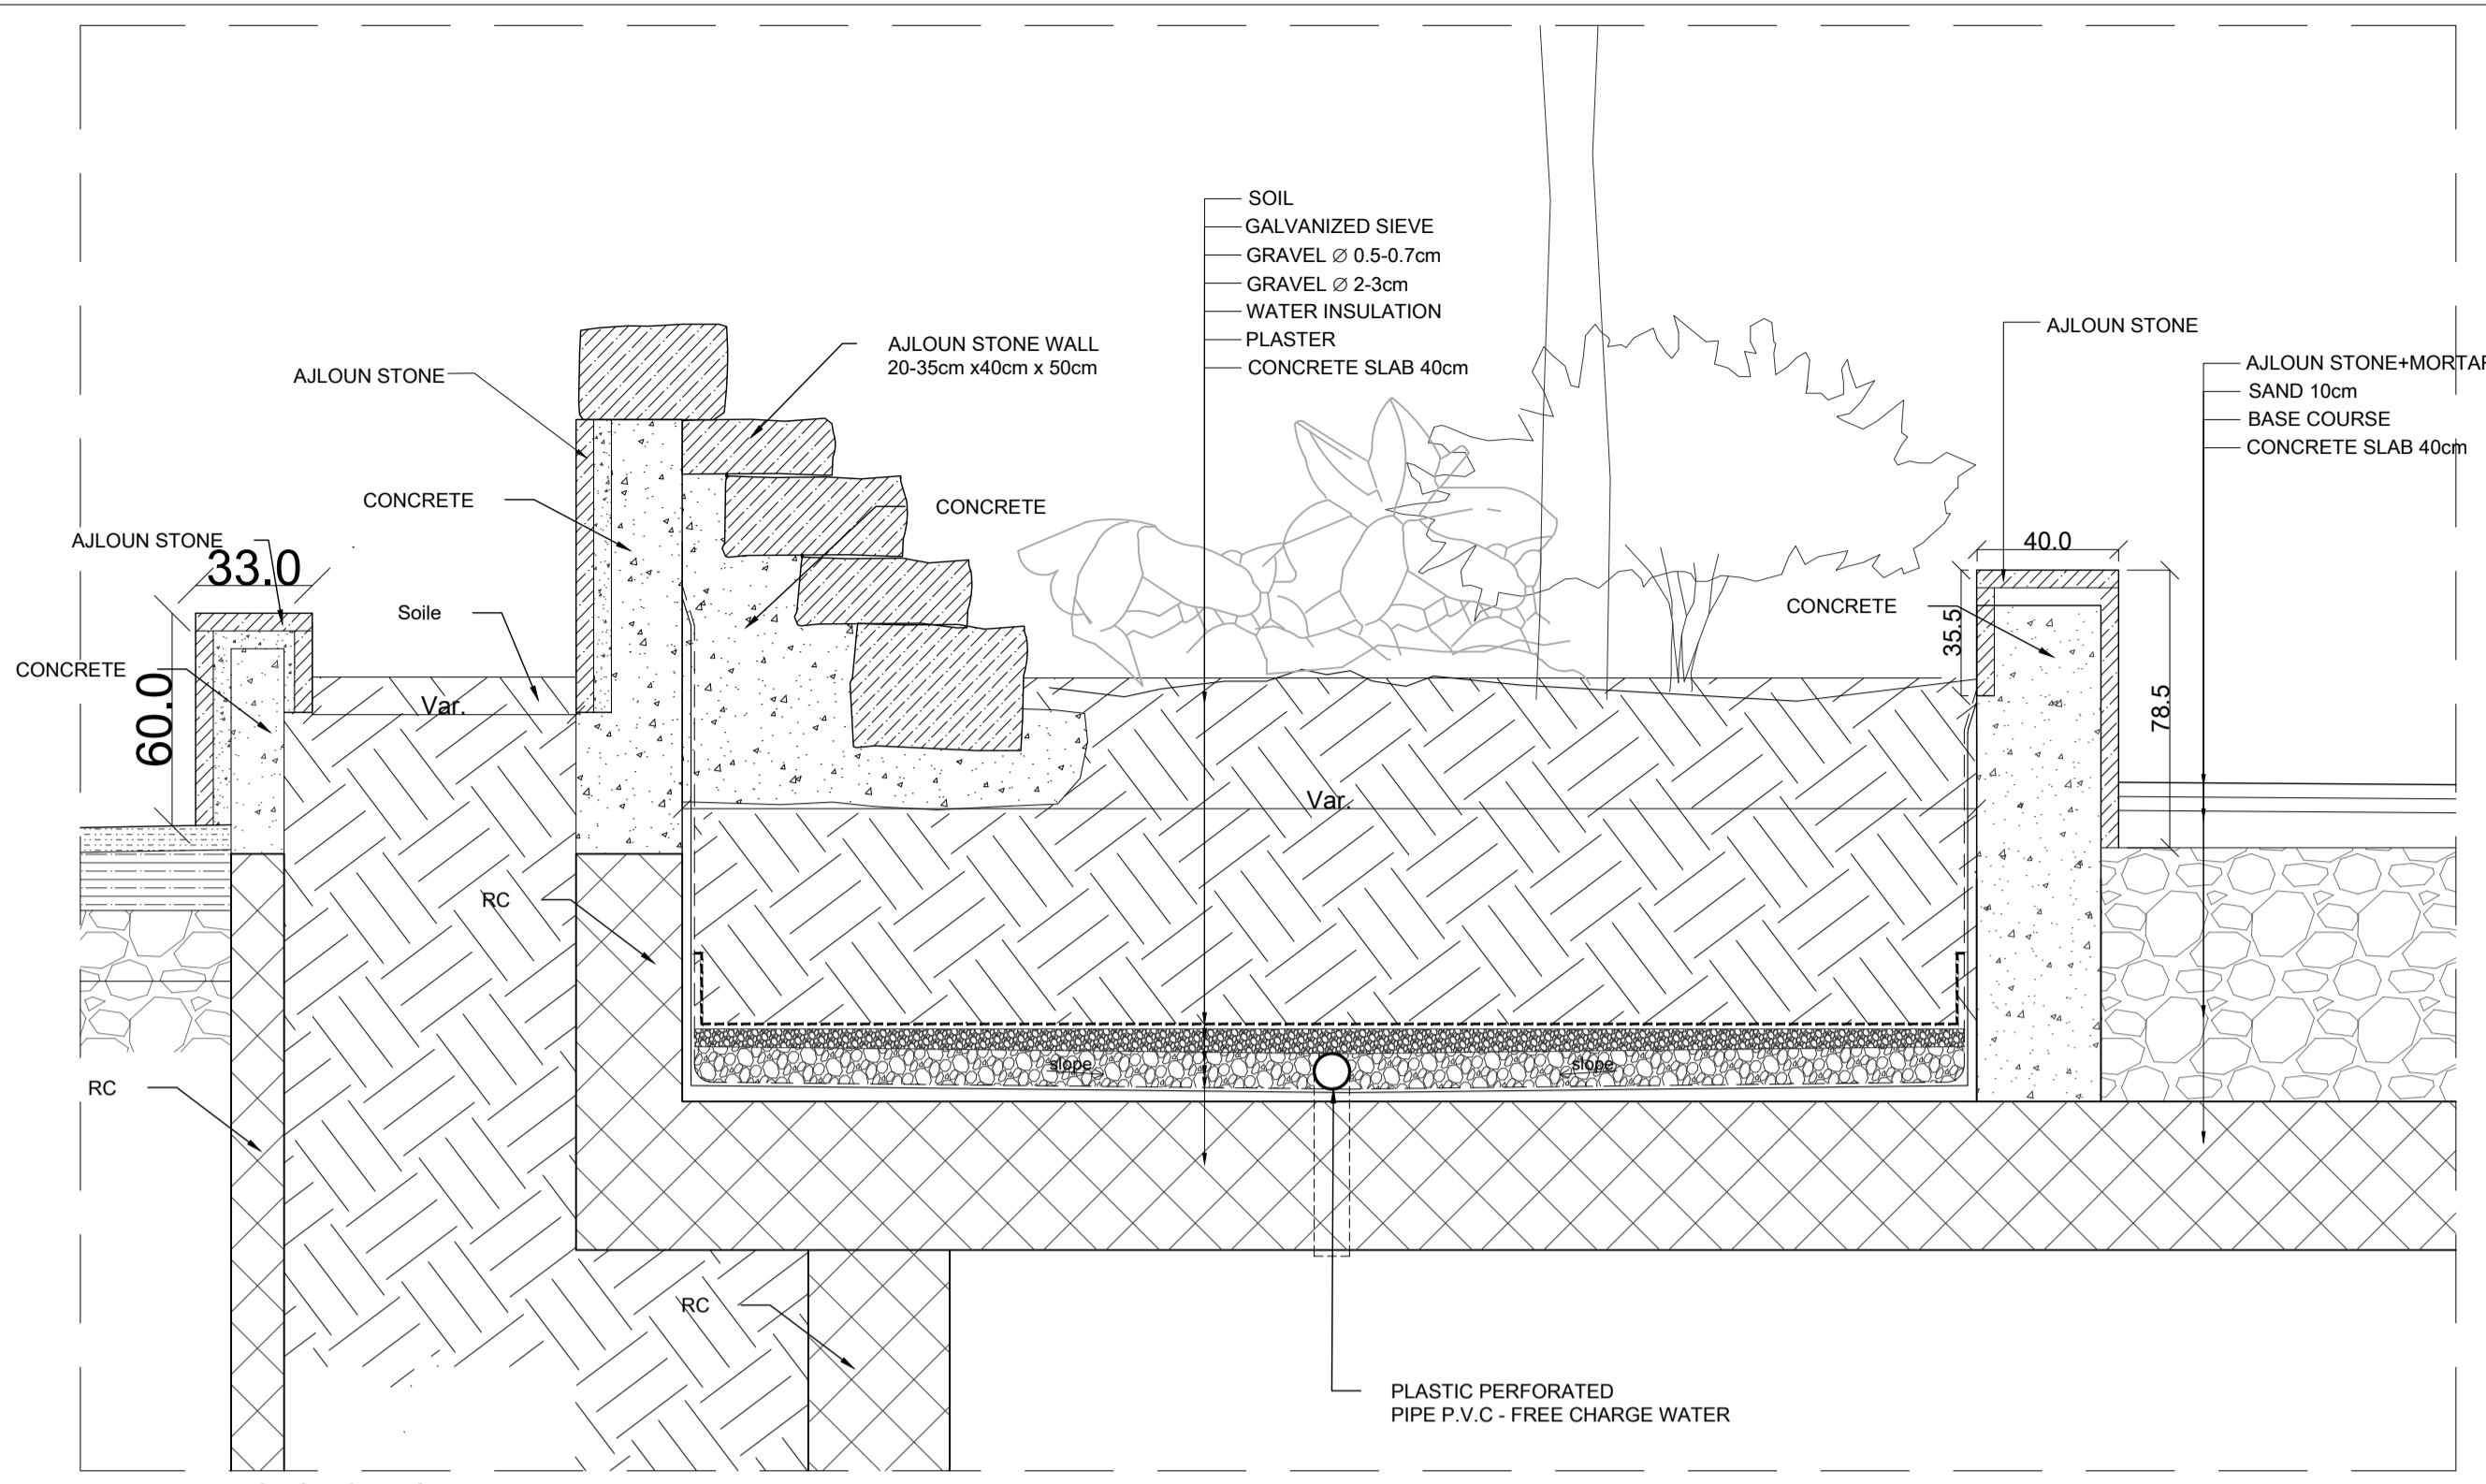


SECTION - S01  
SCALE: 1/20

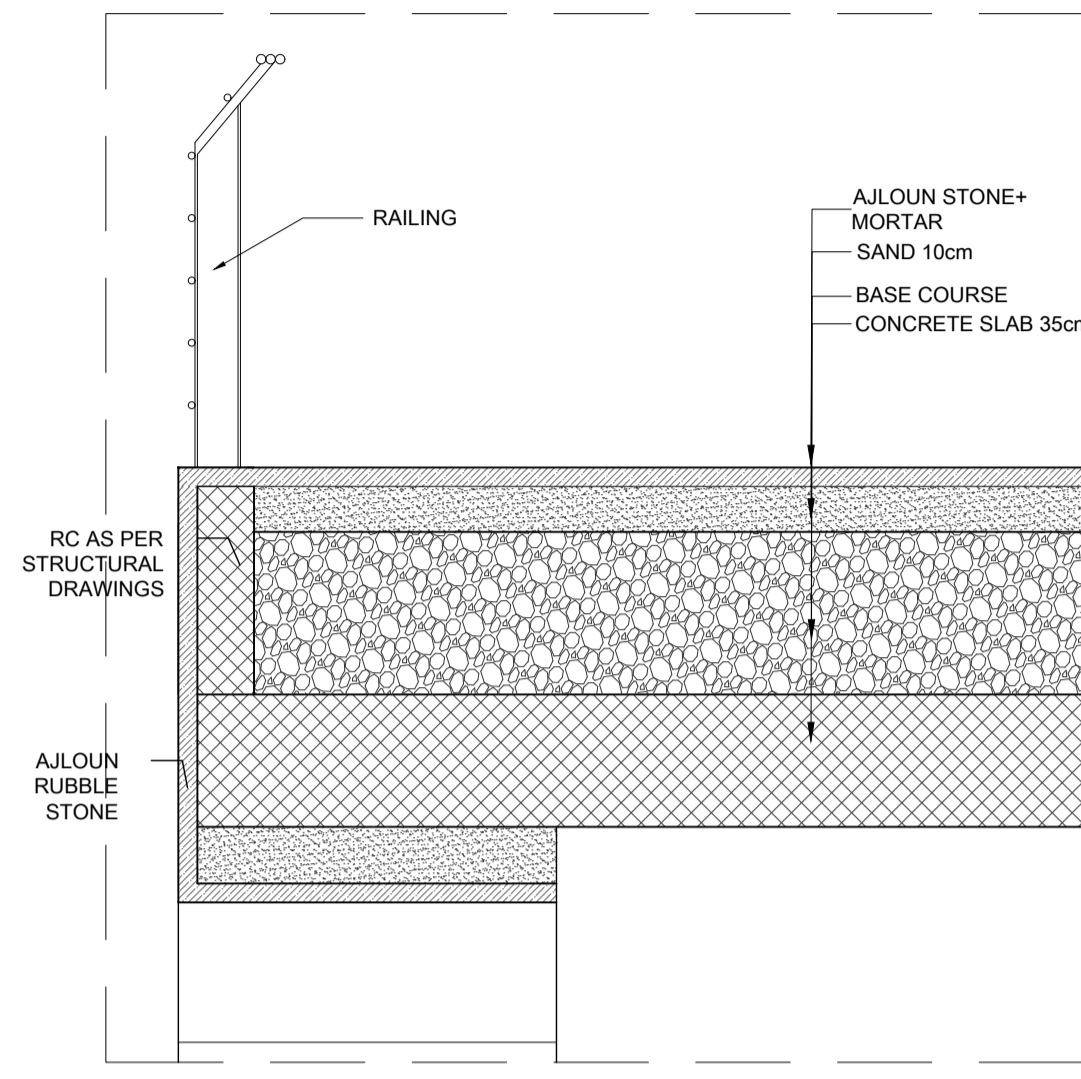


SECTION - S02  
SCALE: 1-20

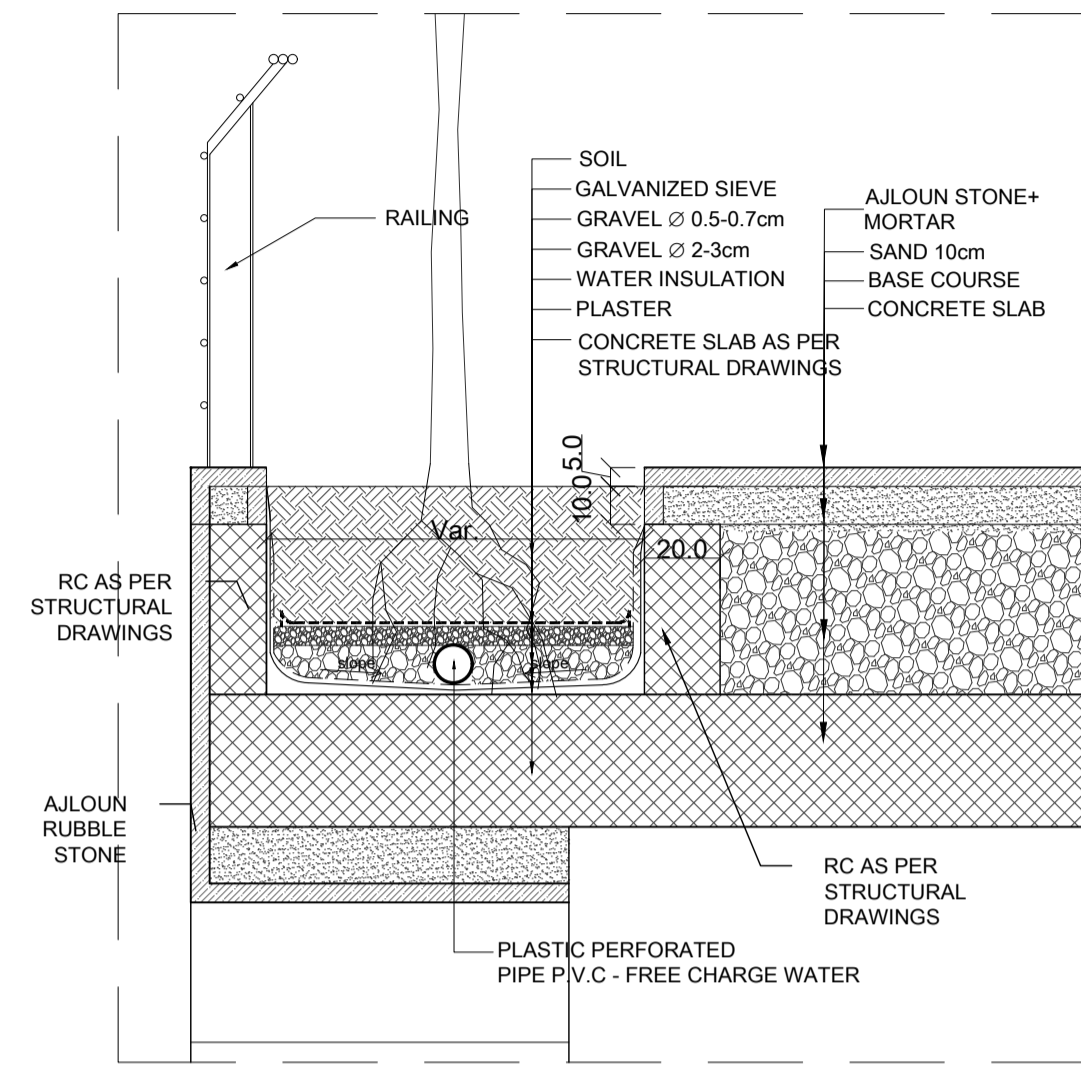


SECTION - S03  
SCALE: 1-20

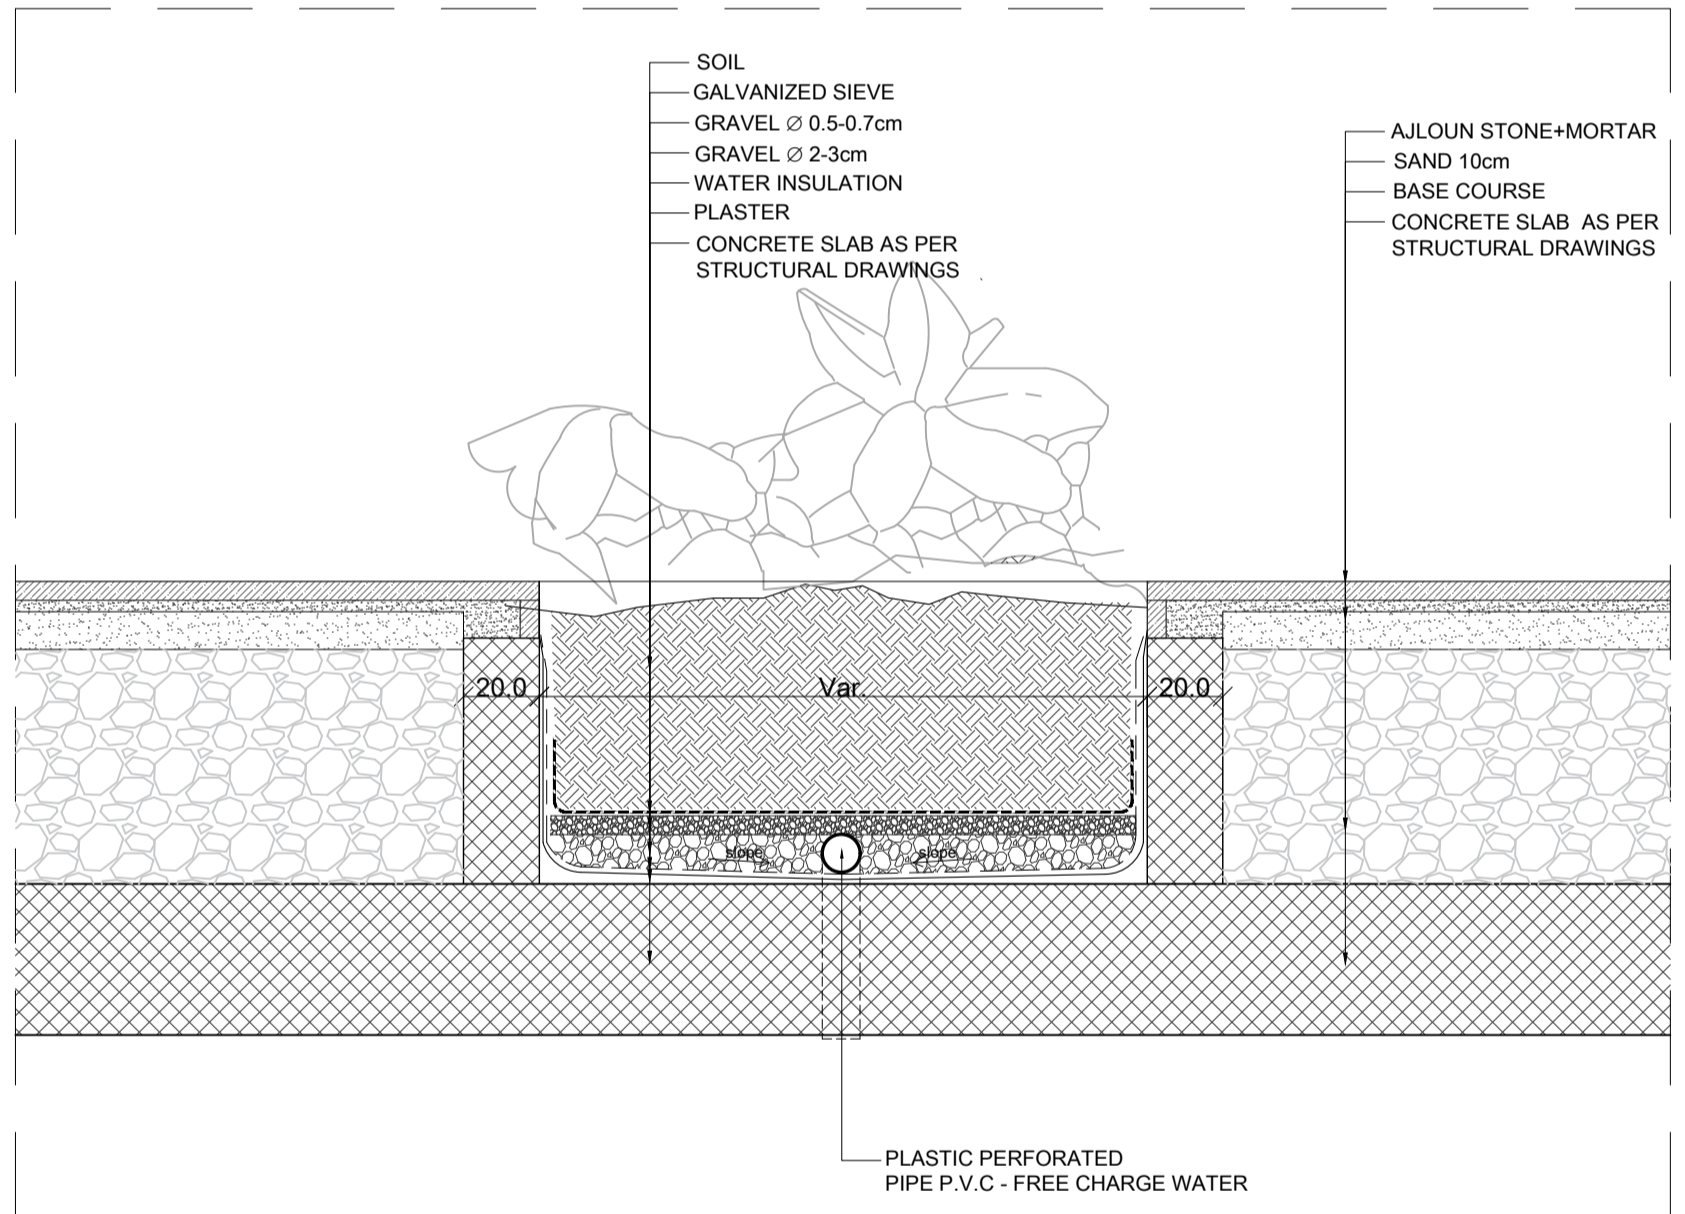


SECTION - S04  
SCALE: 1-20

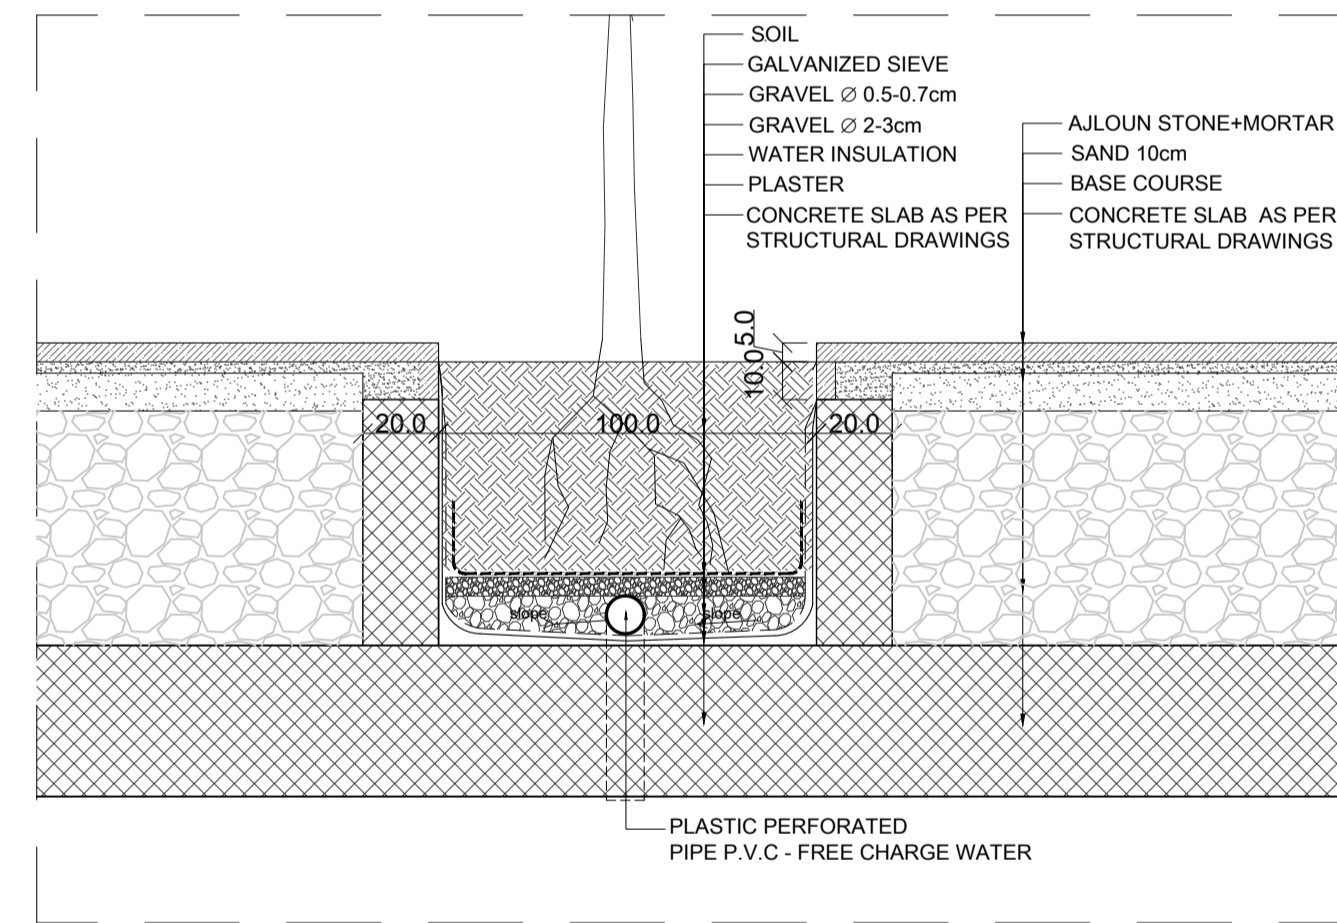


SECTION - S05  
SCALE: 1-20

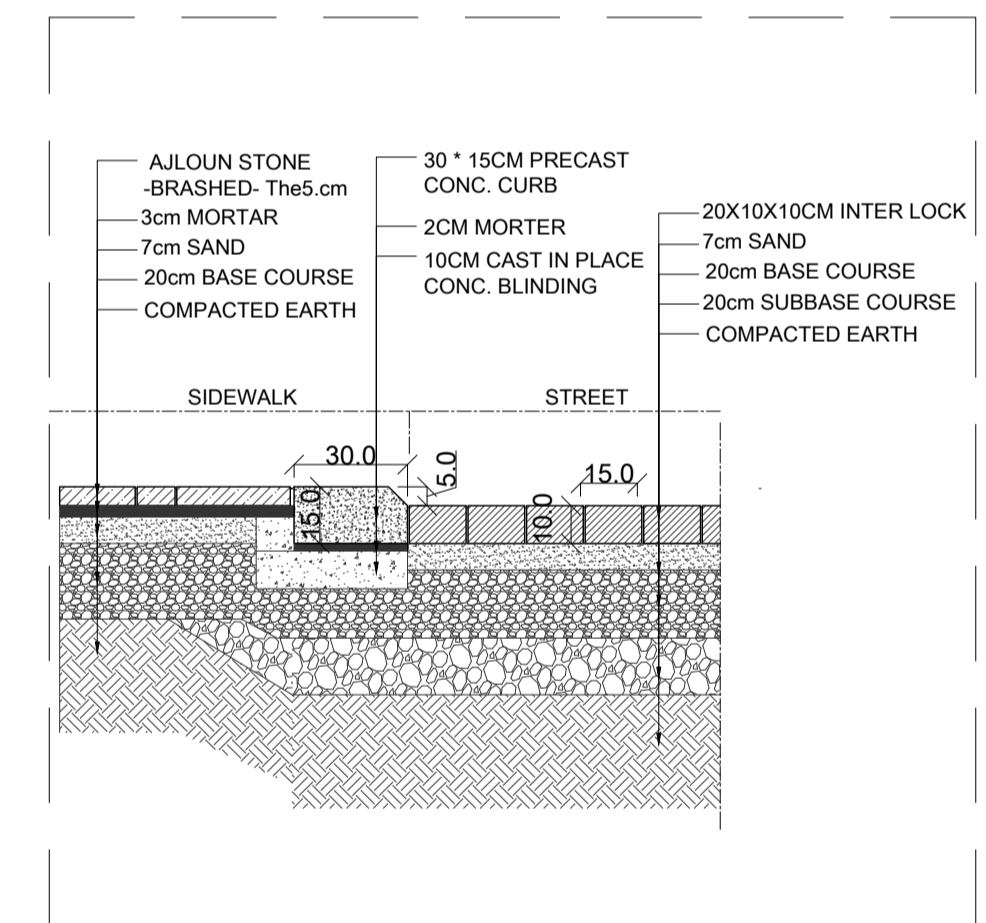


SECTION - S06  
SCALE: 1-20

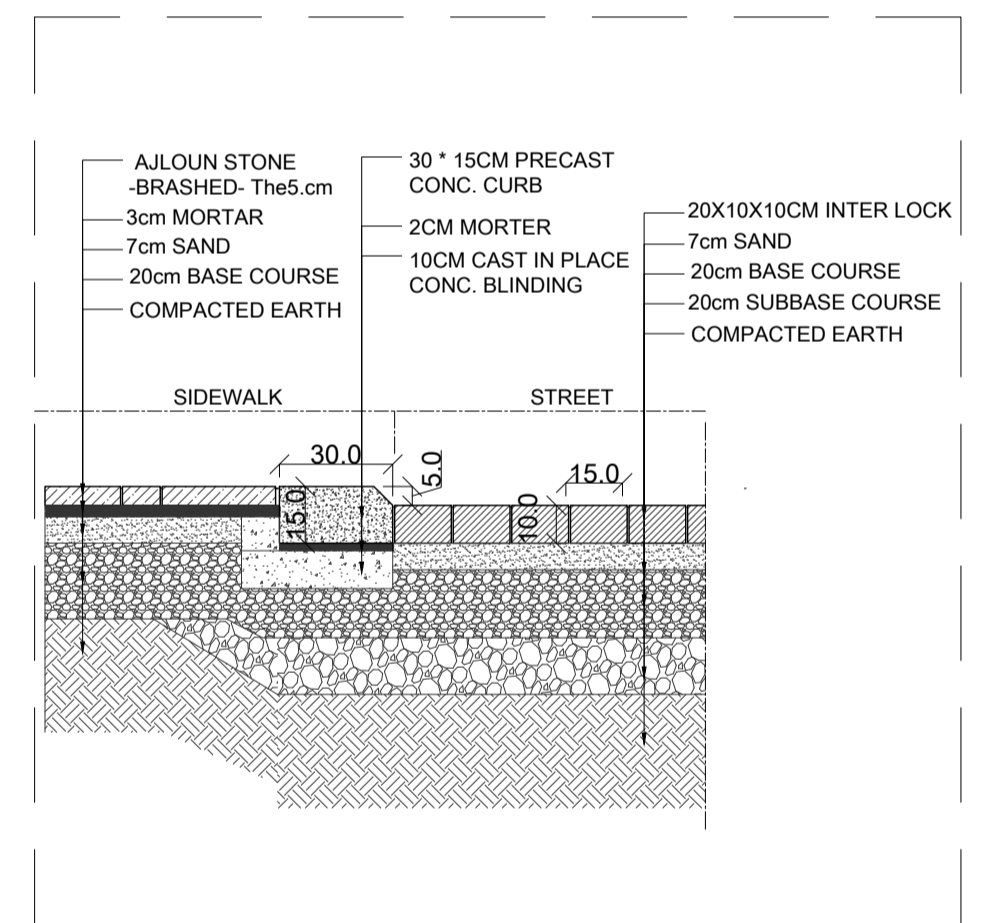


SECTION - S06  
SCALE: 1-20

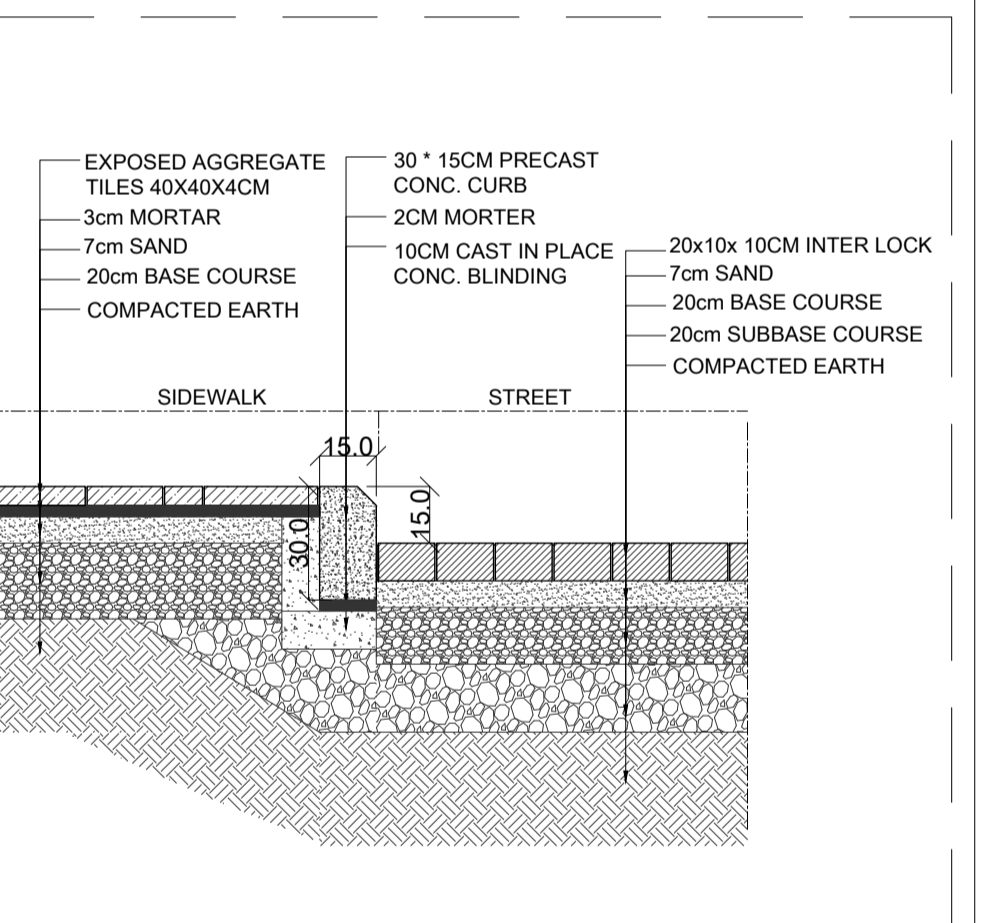


SECTION - S07  
SCALE: 1-20

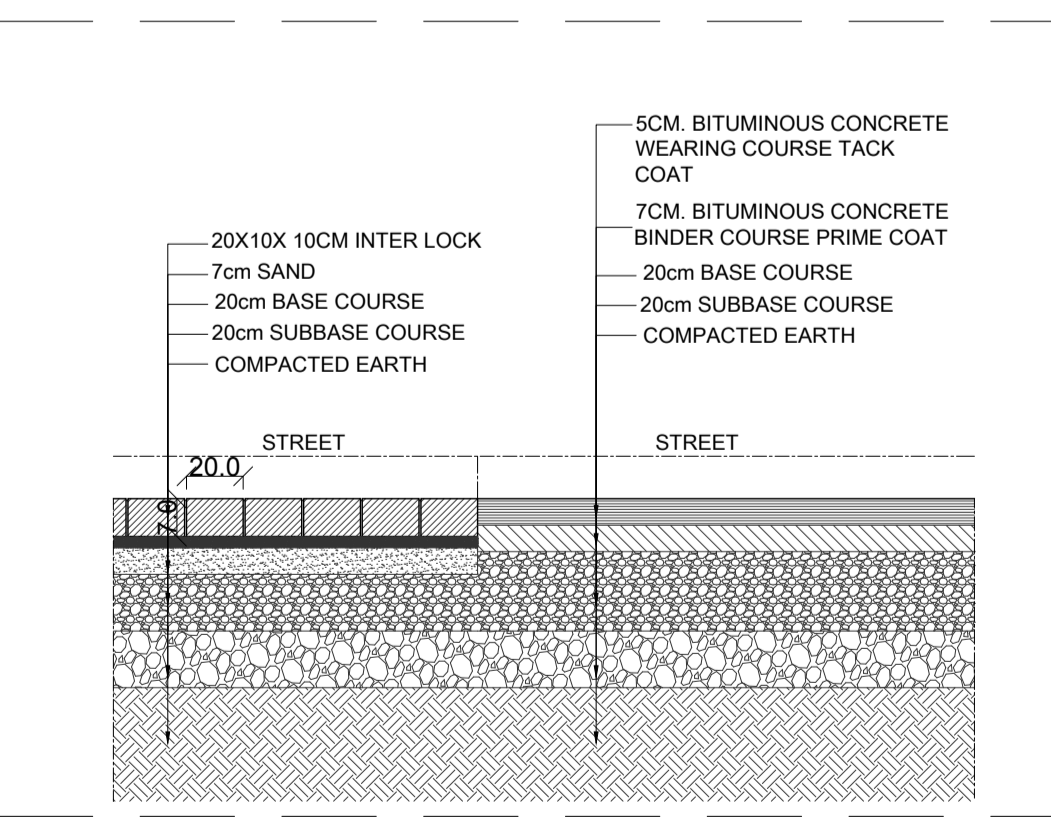


SECTION - S08  
SCALE: 1-20

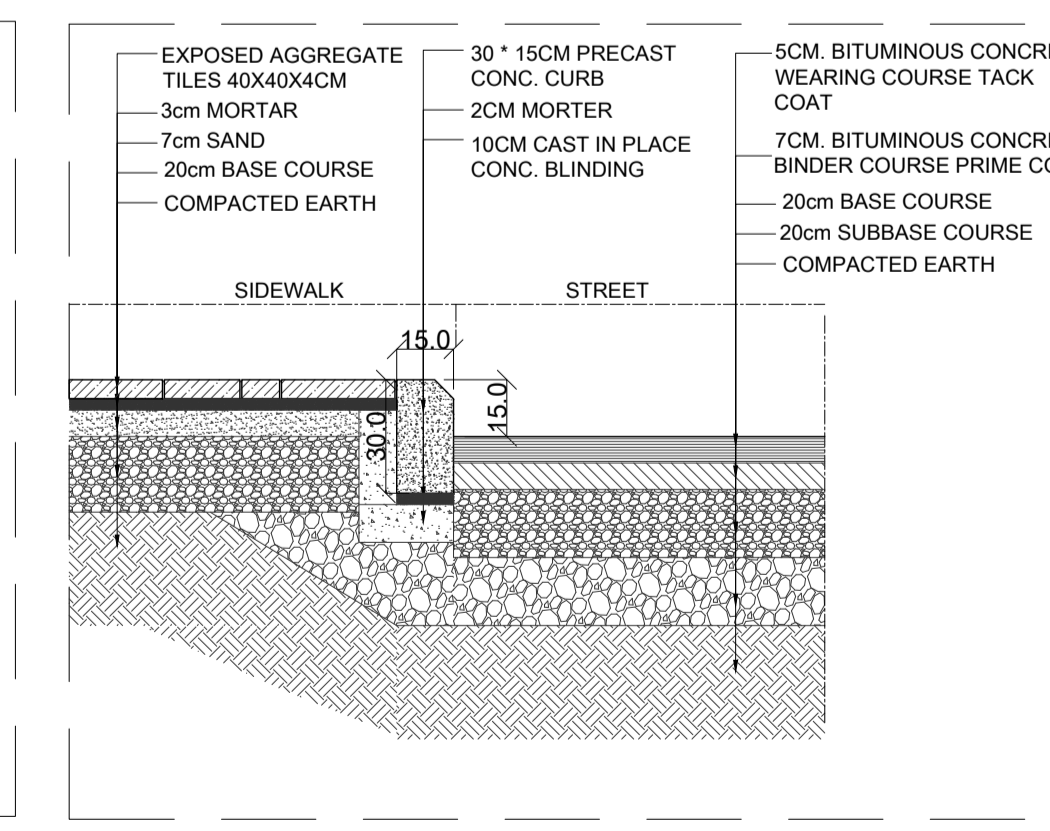


SECTION - S09  
SCALE: 1-20

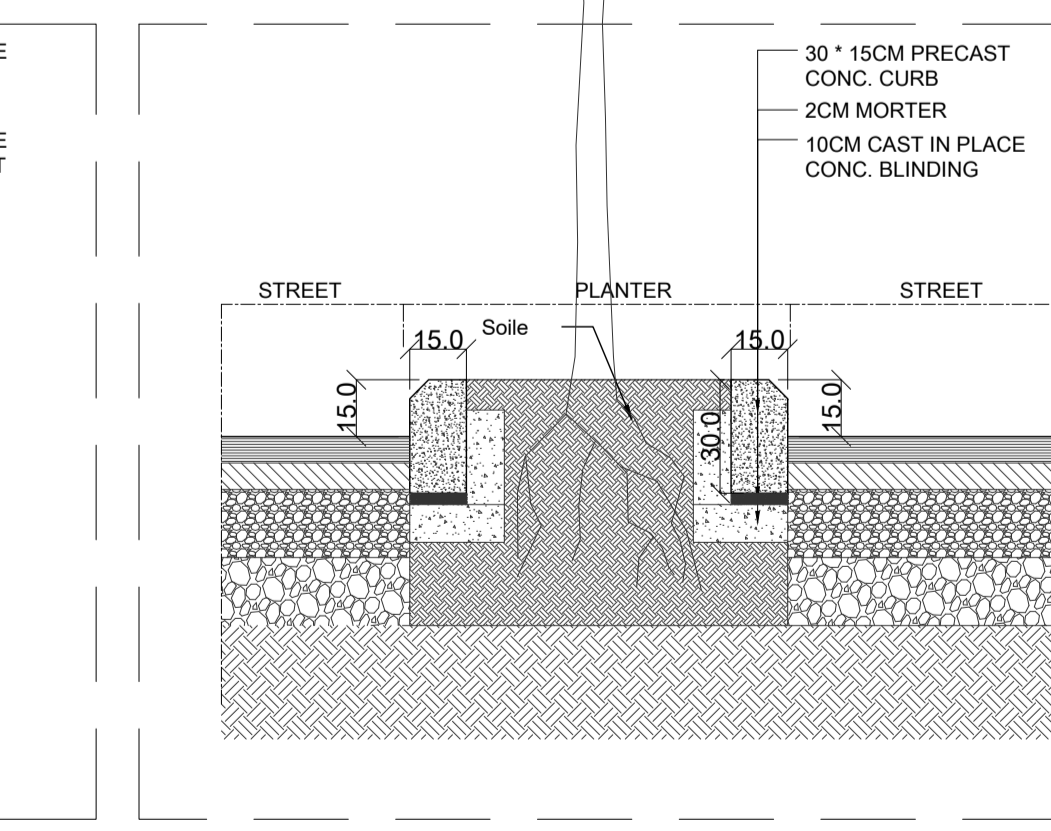


SECTION - S10  
SCALE: 1-20

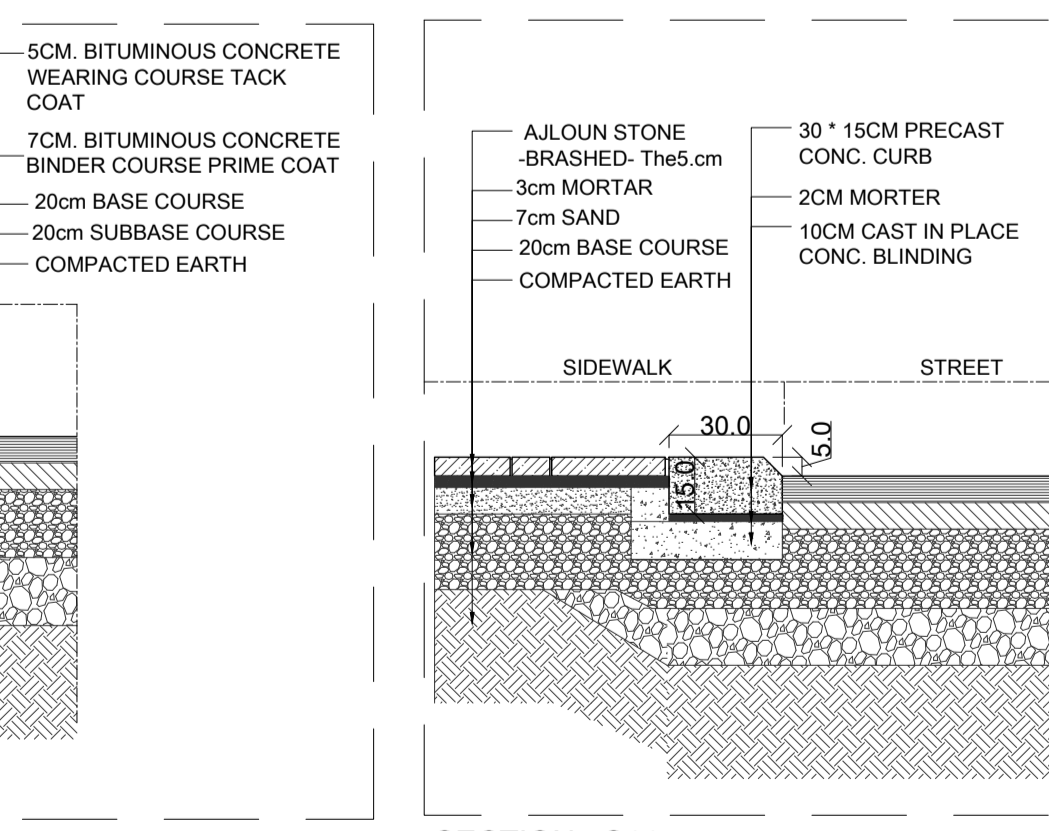


SECTION - S11  
SCALE: 1-20

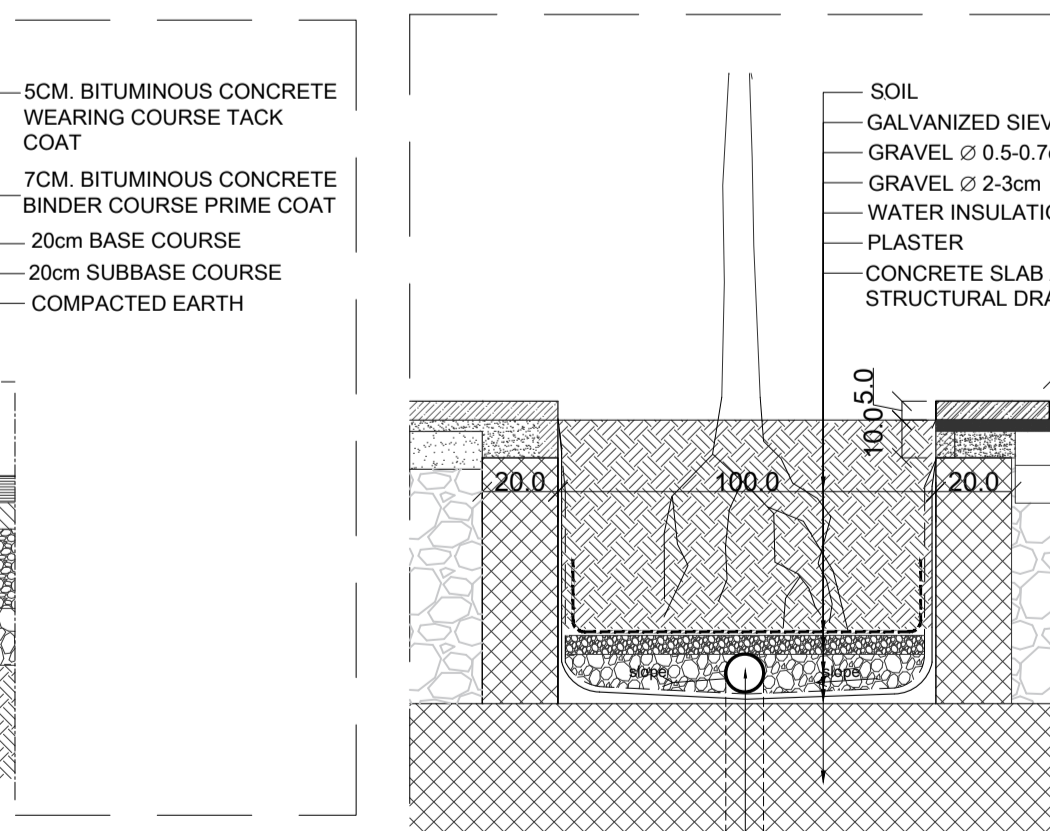


SECTION - S24  
SCALE: 1-20

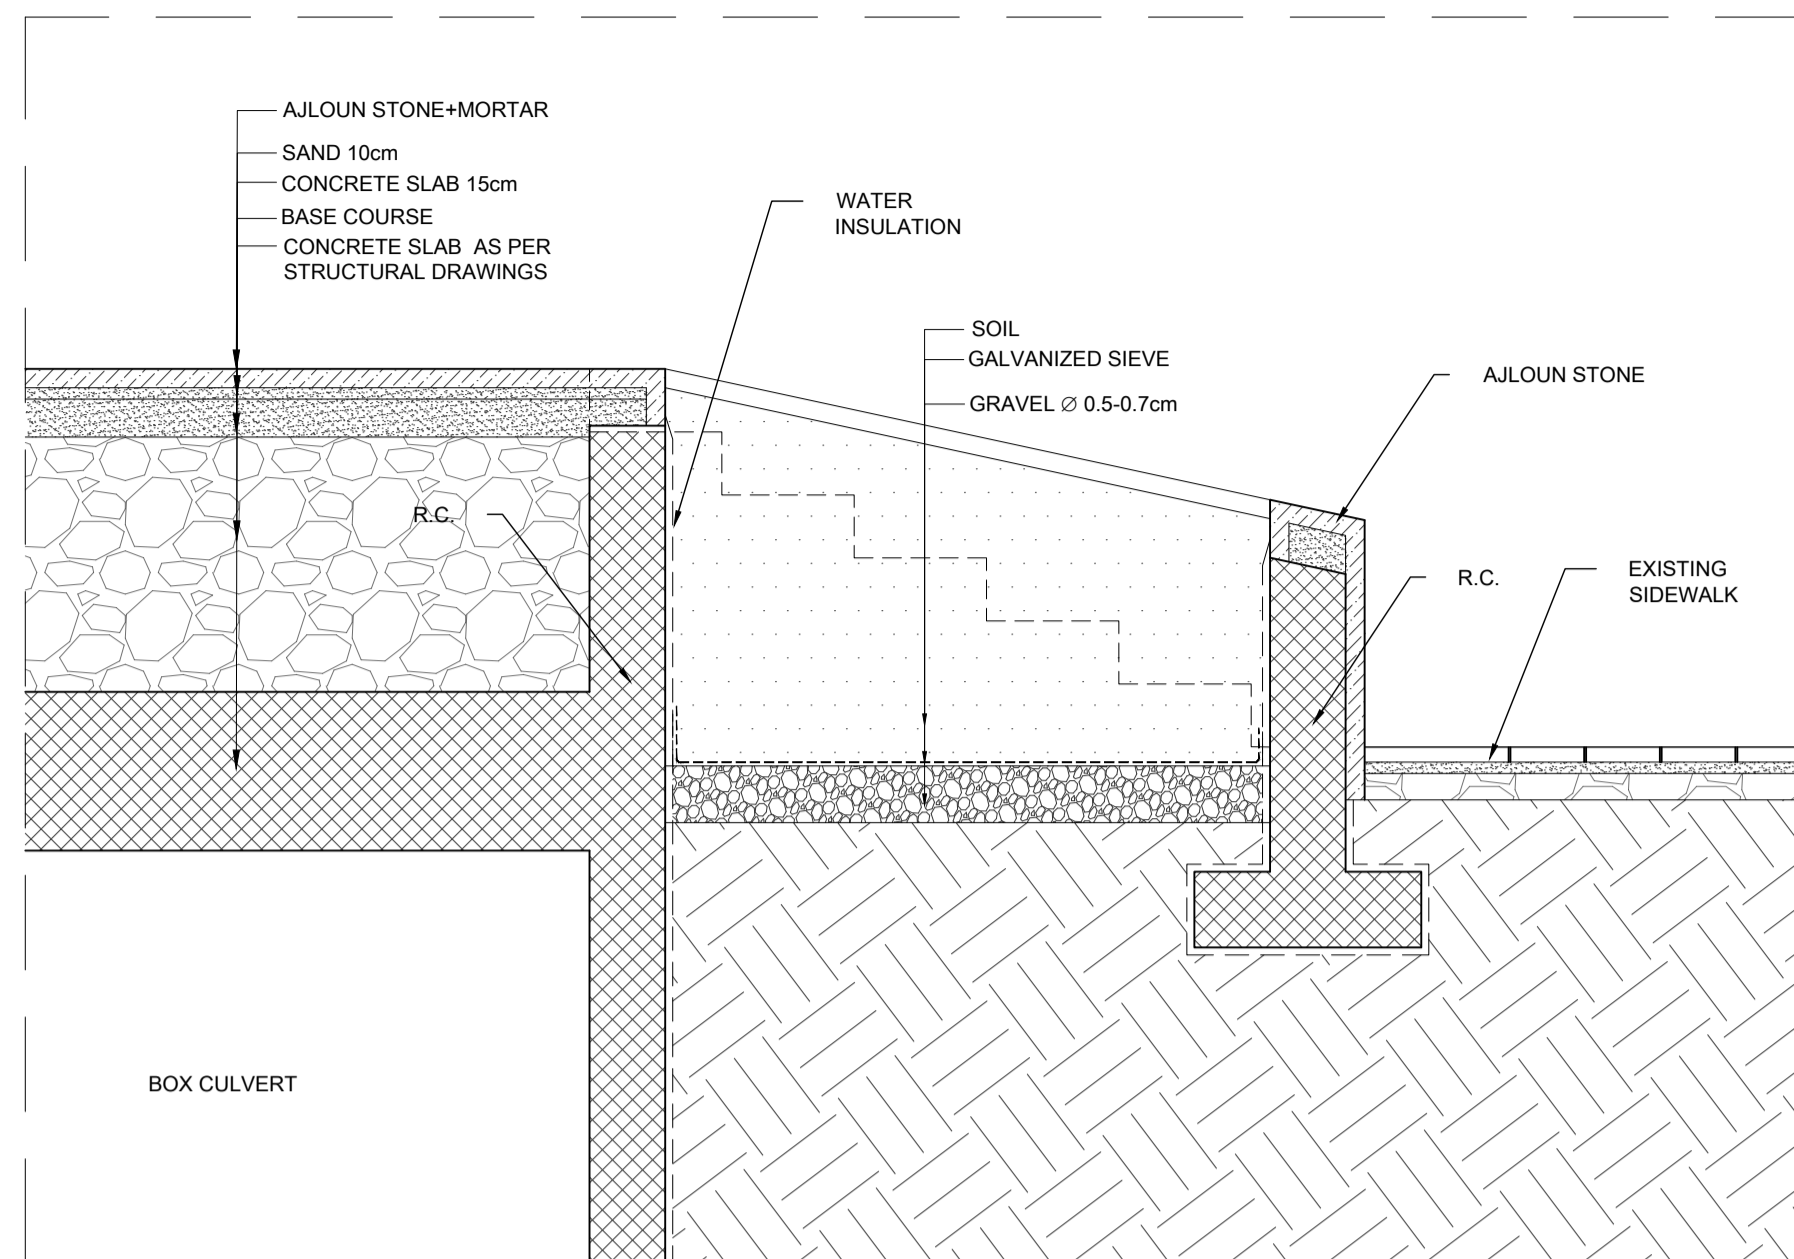


SECTION - S-12  
SCALE:1-20

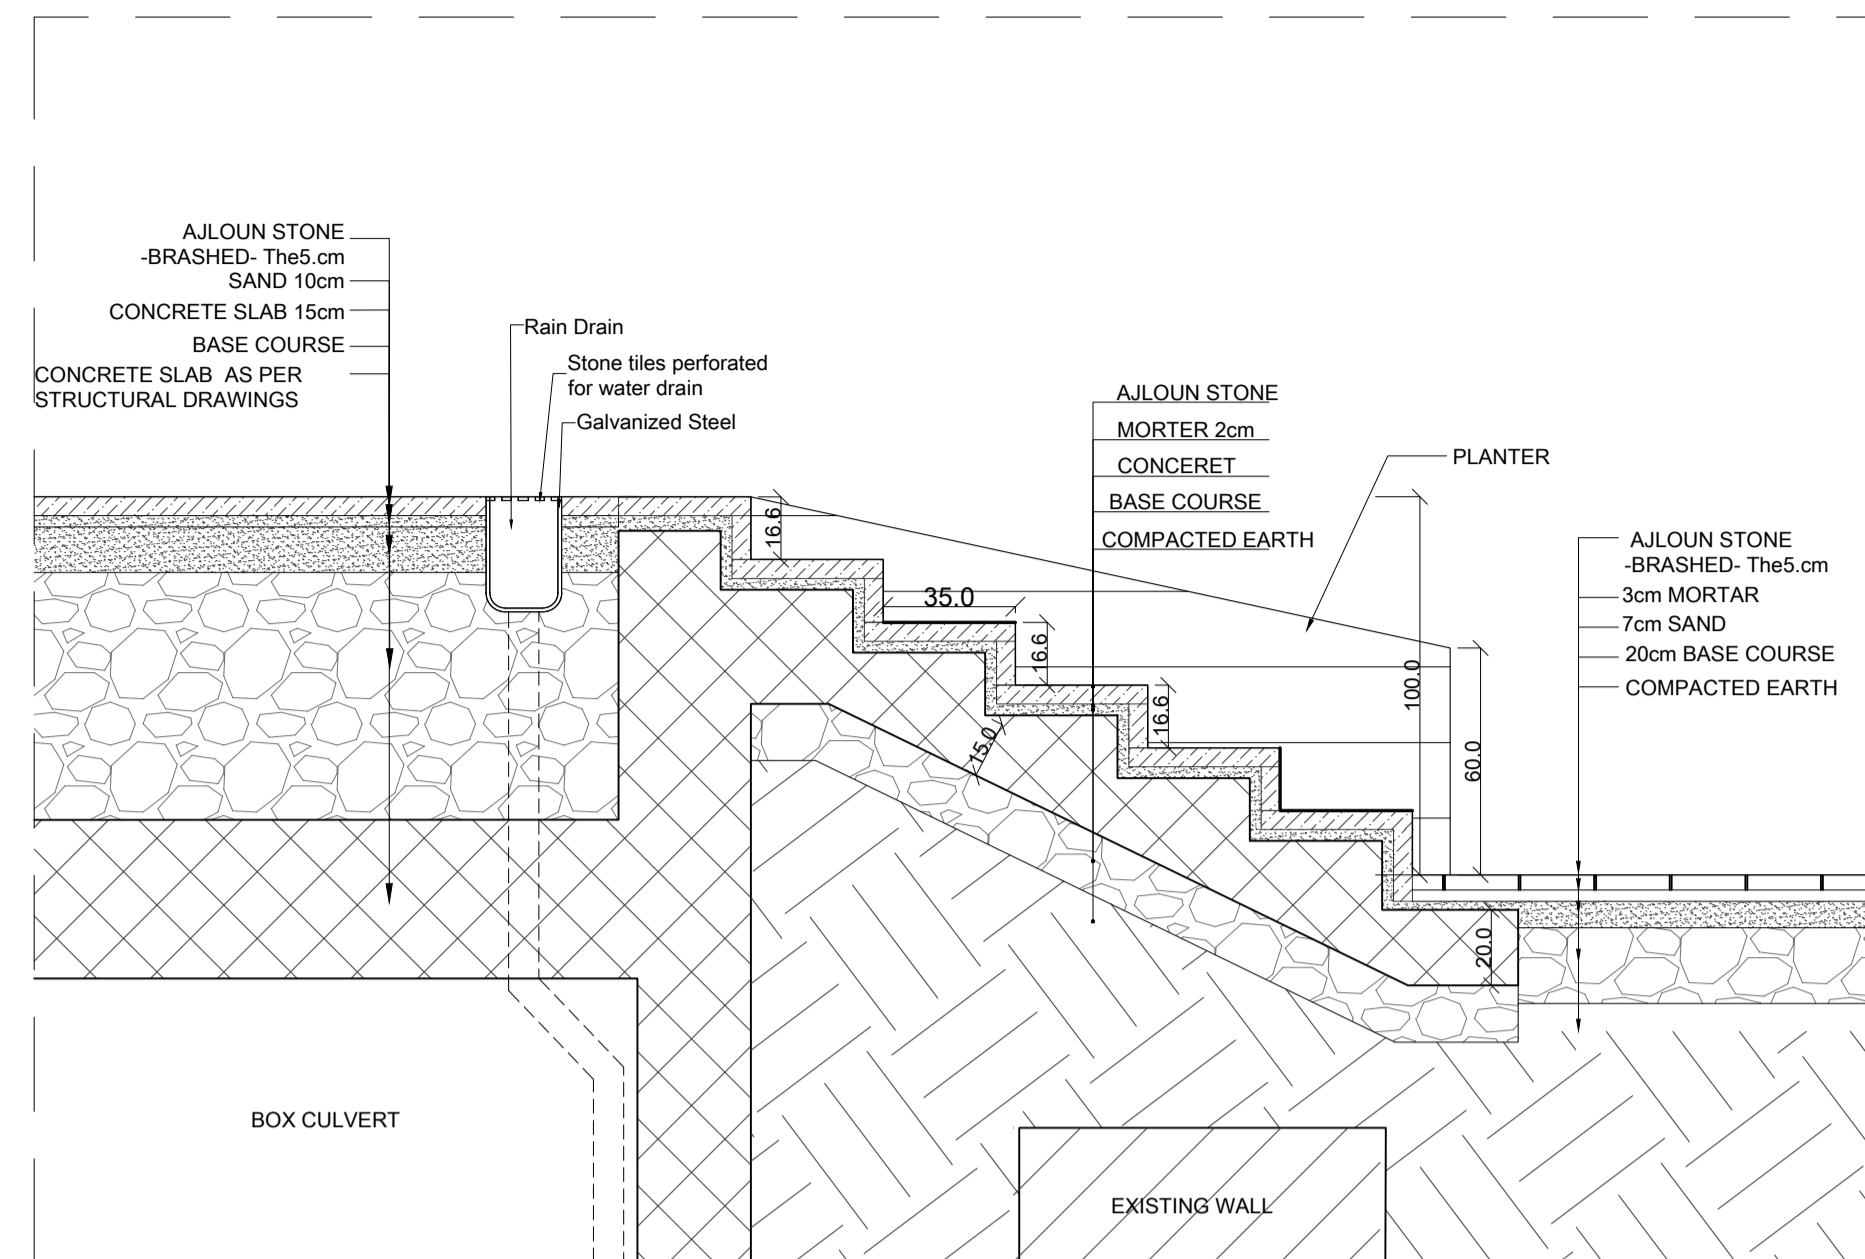


SECTION - S-13  
SCALE:1-20

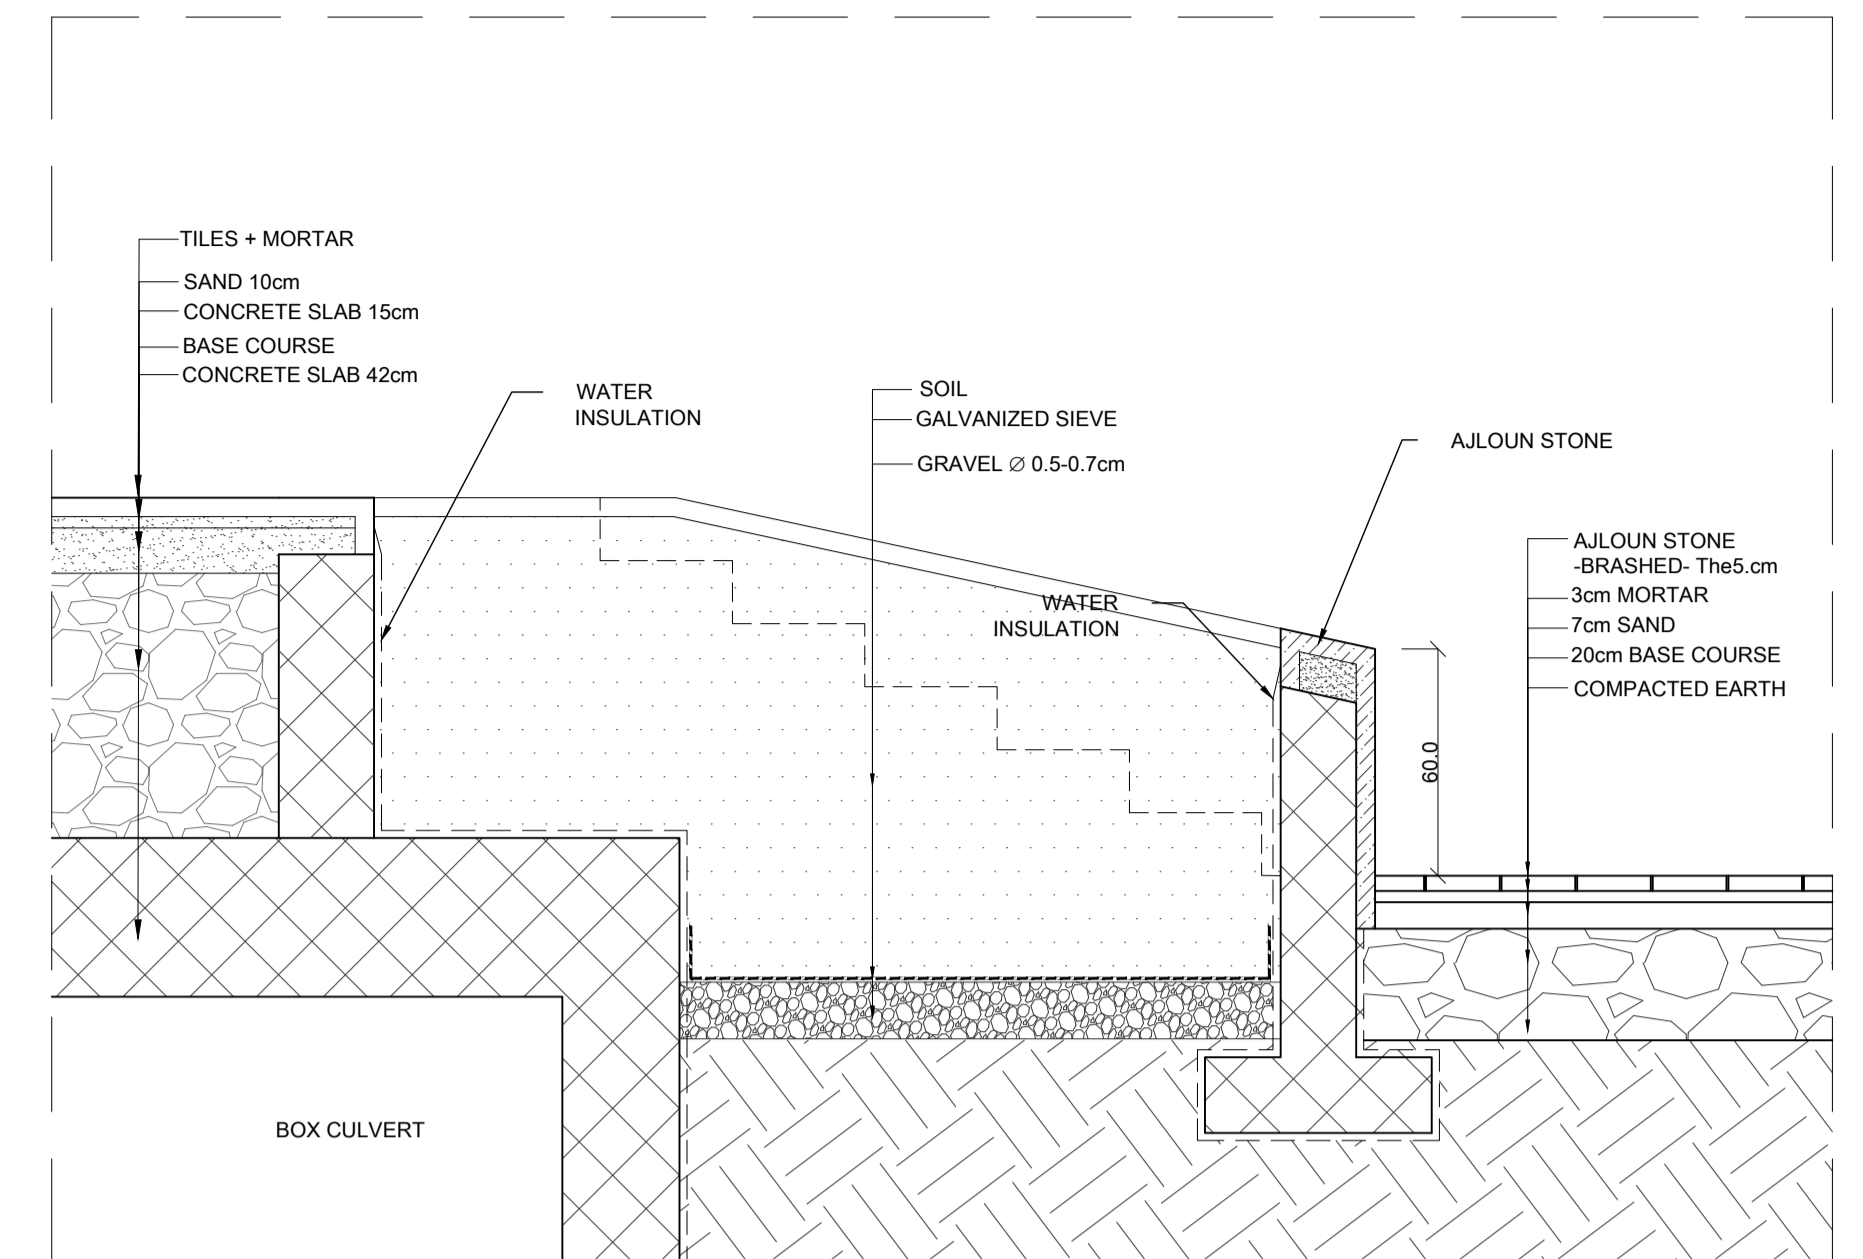


SECTION - S-14  
SCALE:1-20

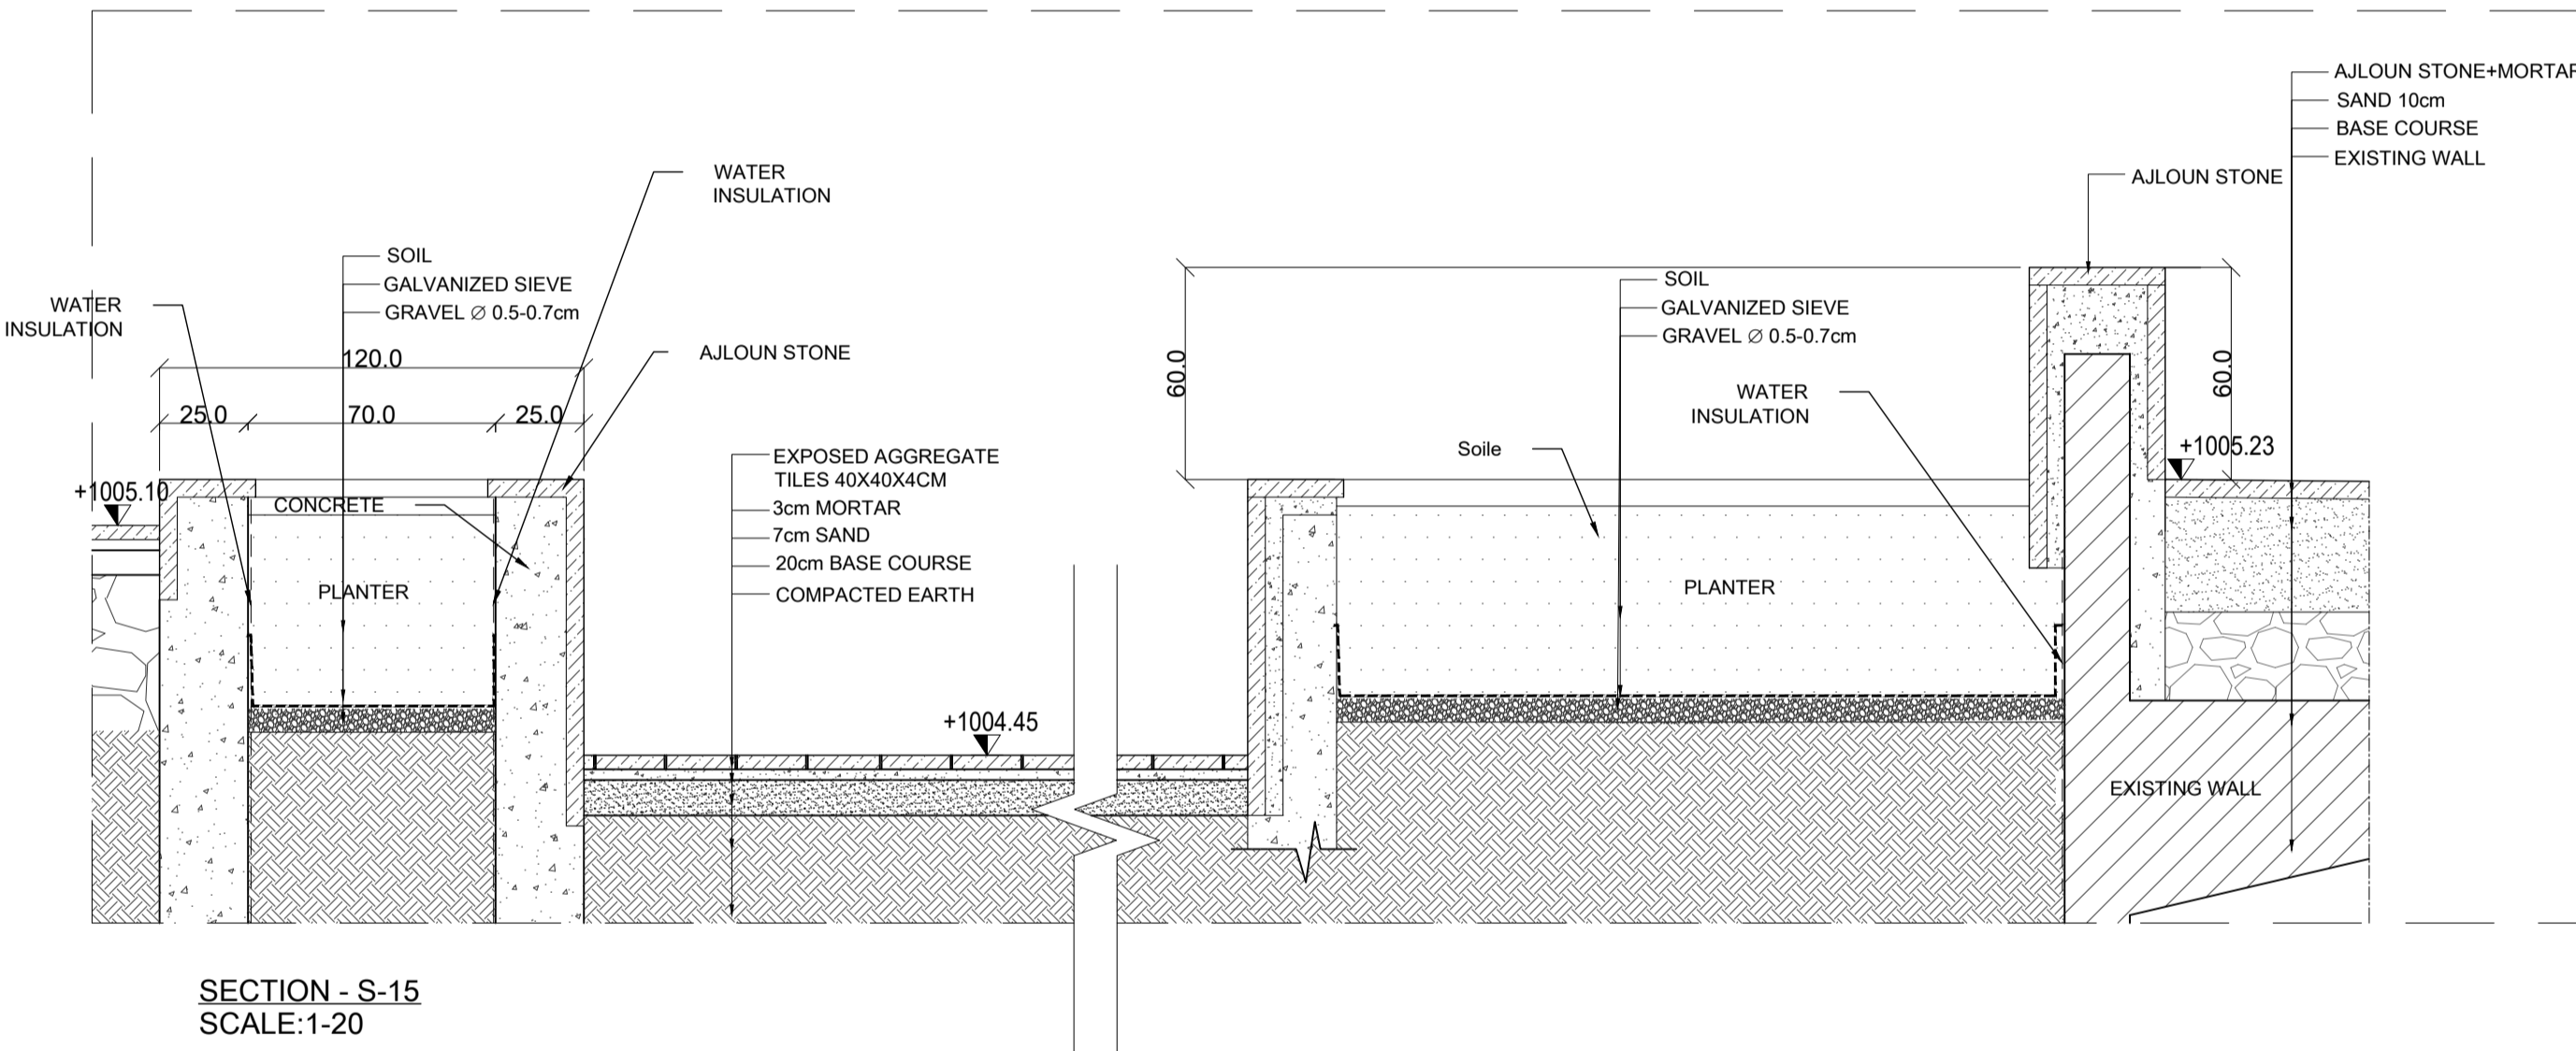


SECTION - S-15  
SCALE:1-20

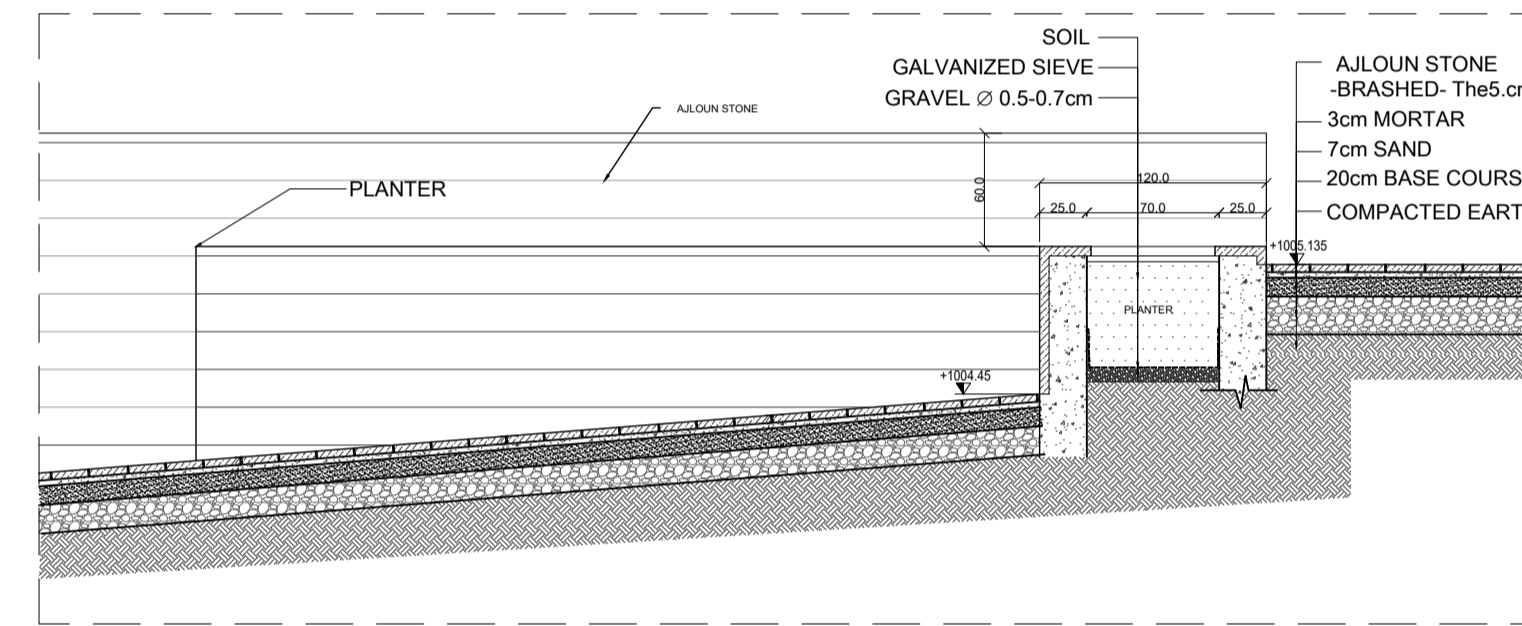


SECTION - S-16  
SCALE:1-50

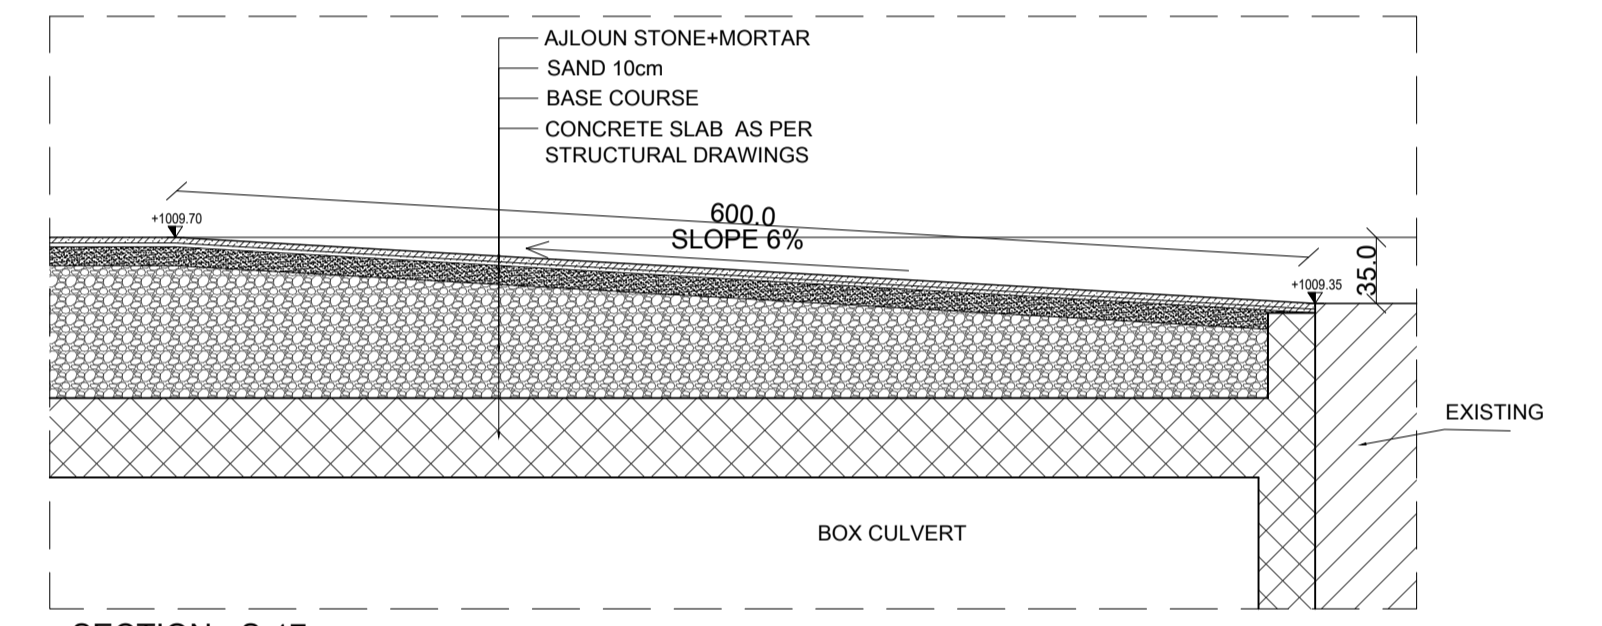


SECTION - S-17  
SCALE:1-50

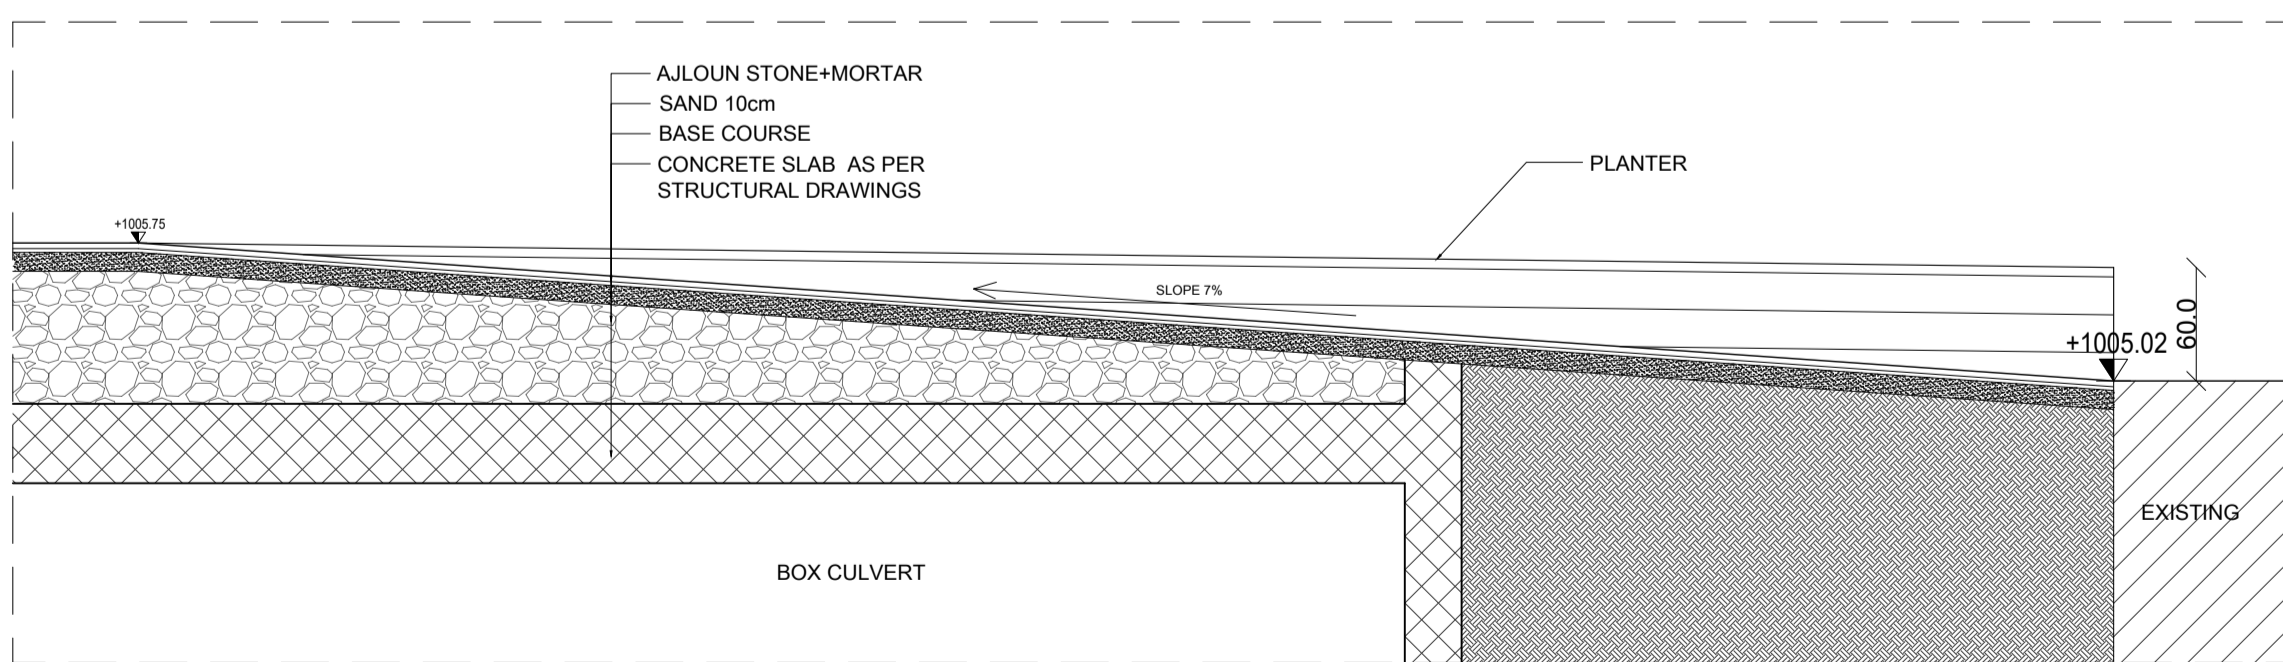


SECTION - S-18  
SCALE:1-50

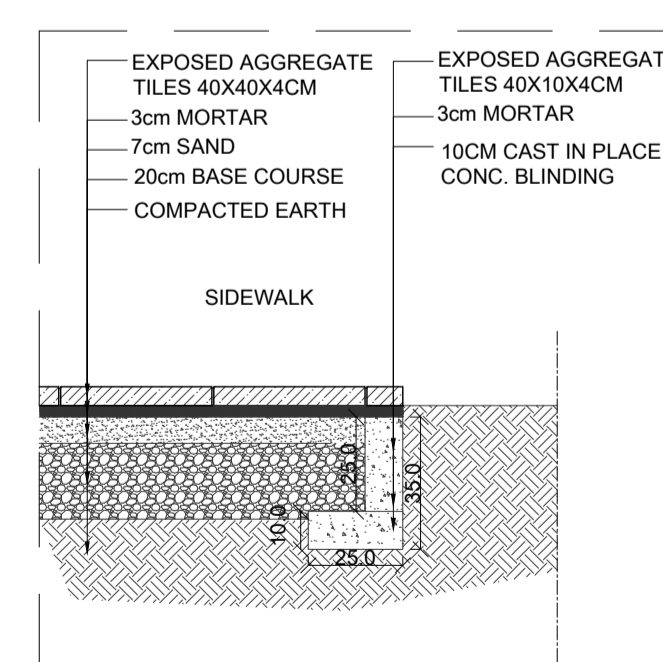

SECTION - S-19  
SCALE:1-20

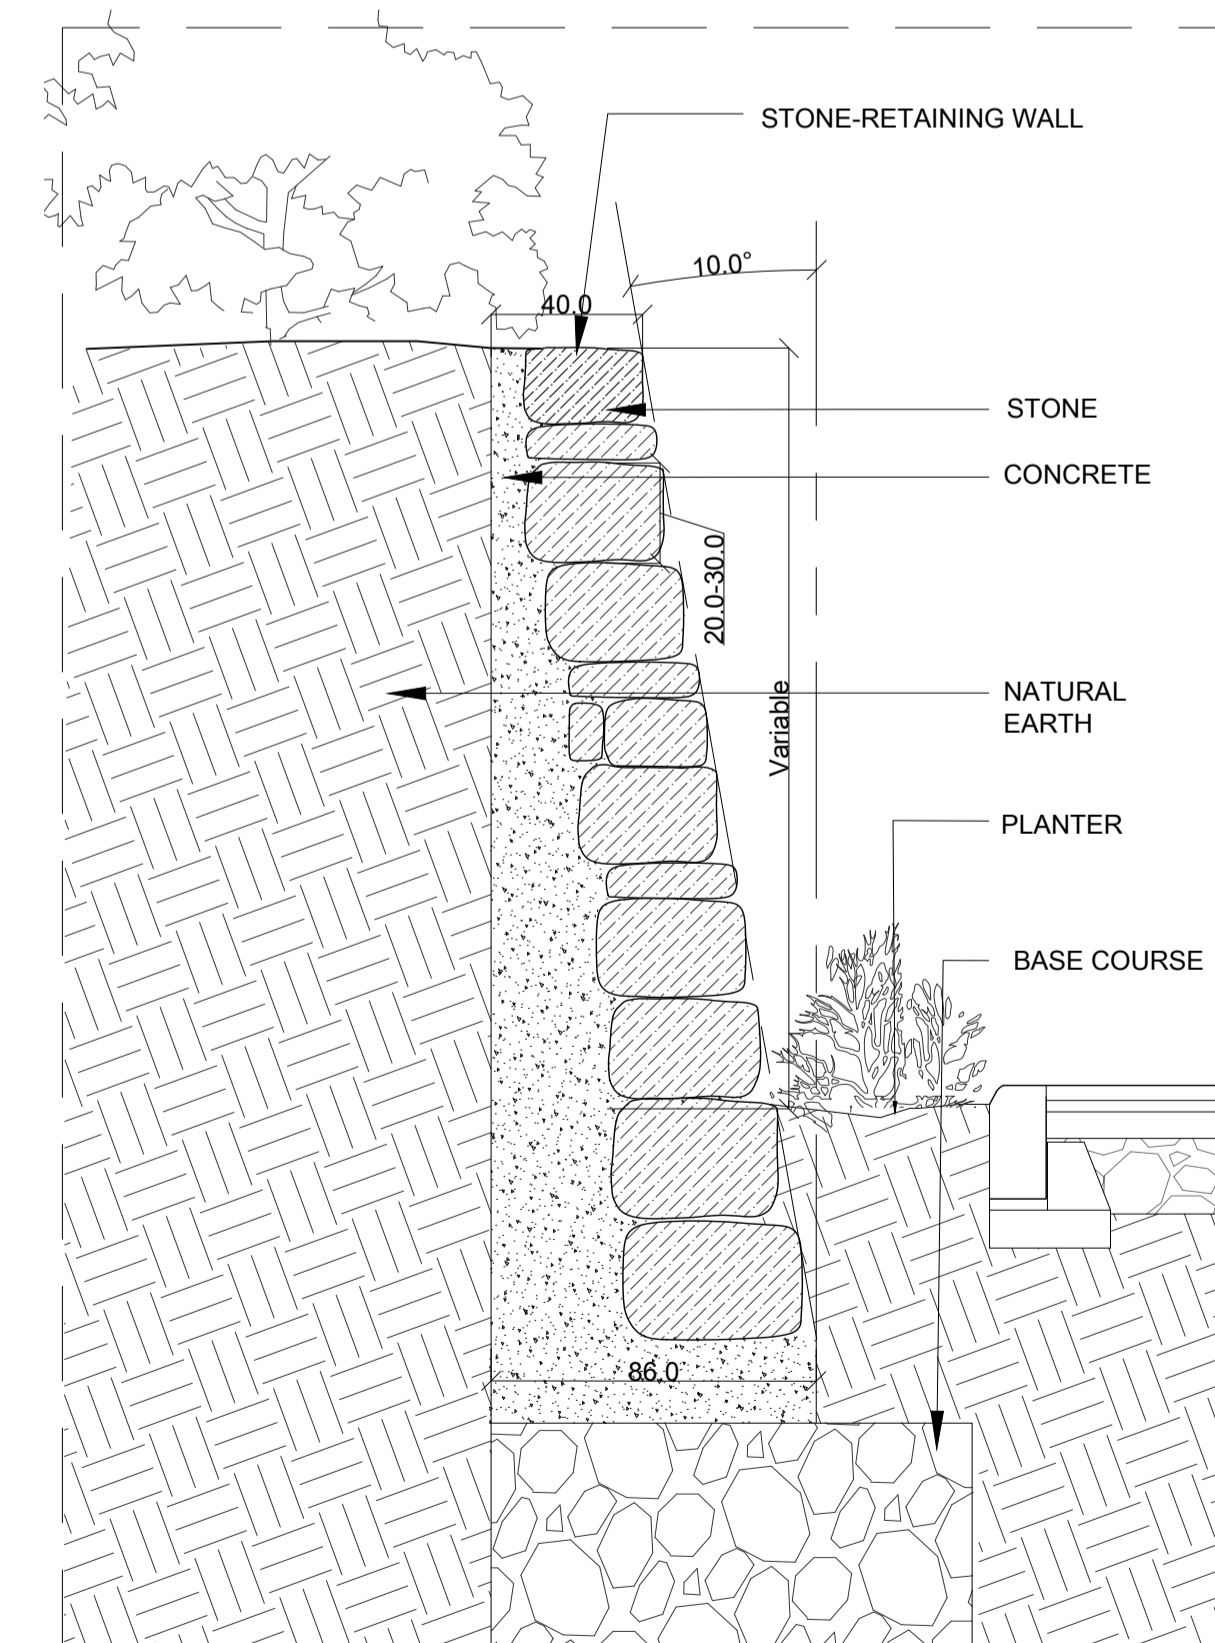

SECTION - S-20  
SCALE:1-20

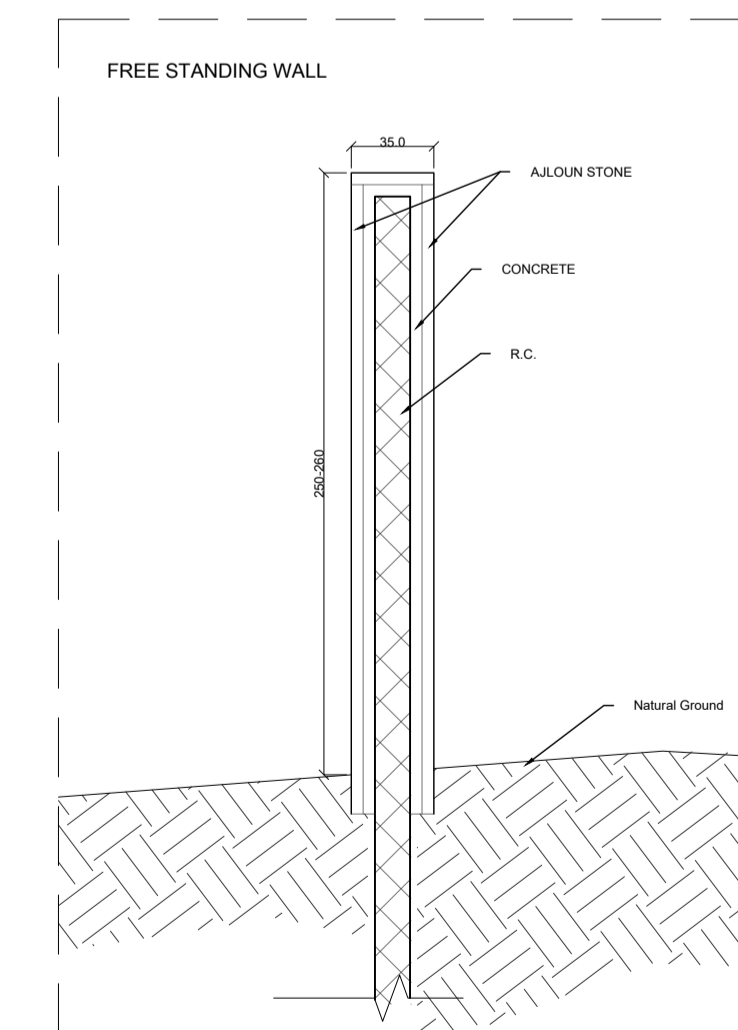


SECTION - S-21  
SCALE:1-20






**CODE :** TL-01

SPECIFICATION : AJLOUN STONE FLOORING  
 FINISH : HONED BRASHED  
 DIMENSION : 40cm x random, 30cm x random,  
 20cm x random, 10cm x random.  
 LOCATION :  
 PUBLIC PLAZA

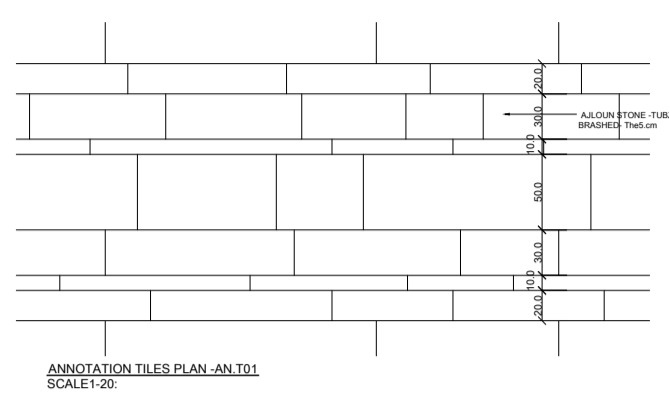


ANNOTATION TILES PLAN-AN.T01  
SCALE: 1/20

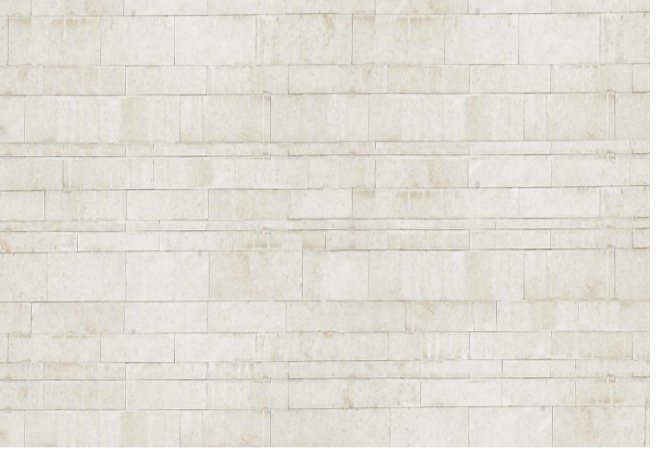

**CODE :** TL-02


SPECIFICATION : AJLOUN STONE FLOORING  
 FINISH : TUBZEH BRASHED  
 DIMENSION : 100\*50  
 LOCATION :  
 PUBLIC PLAZA

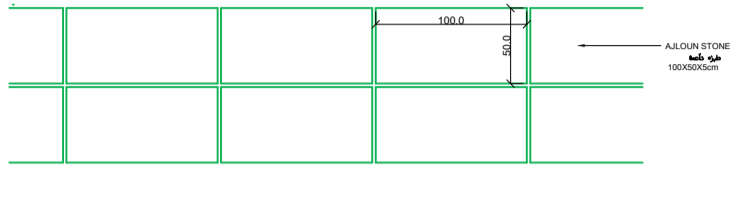

ANNOTATION TILES PLAN-AN.T02  
SCALE: 1/20

**CODE :** TL-03


SPECIFICATION : AJLOUN STONE FLOORING  
 FINISH : TUBZEH BRASHED  
 DIMENSION : 25\*50  
 LOCATION :  
 PUBLIC PLAZA

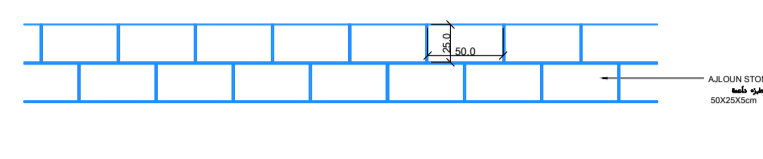


ANNOTATION TILES PLAN-AN.T03  
SCALE: 1/20

**CODE :** TL-04

SPECIFICATION :  
 INTERLOCK CONCRETE  
 DIMENSION : 15\*15\*10 CM  
 LOCATION :  
 ROAD


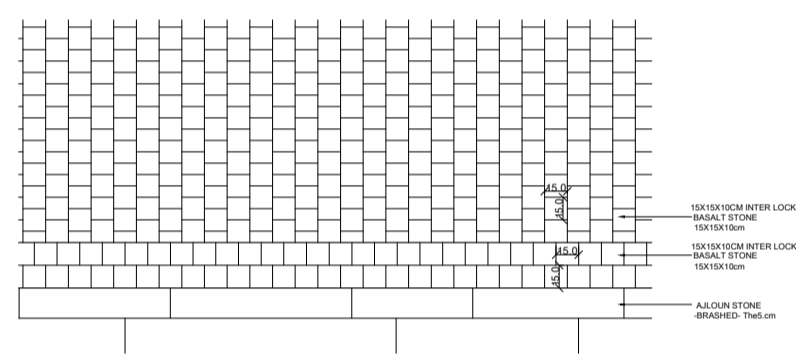


ANNOTATION TILES PLAN-AN.T04  
SCALE: 1/20

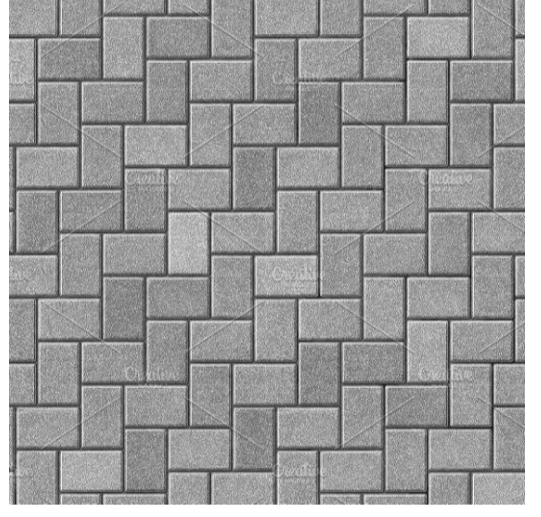

**CODE :** TL-05

SPECIFICATION :  
 EXPOSED AGGREGATE CONCRETE  
 FINISH : N 01  
 DIMENSION : 40\*40 CM  
 LOCATION :  
 PARKING -PAVEMENT

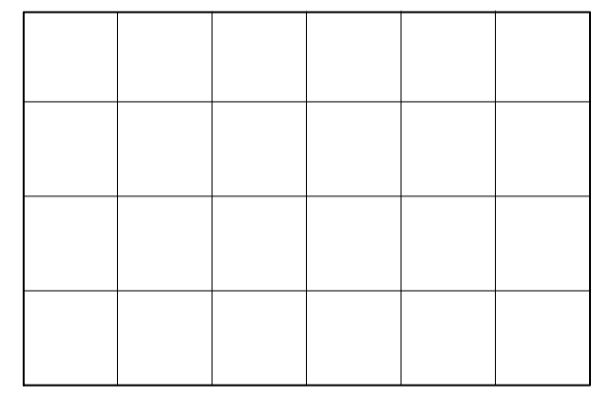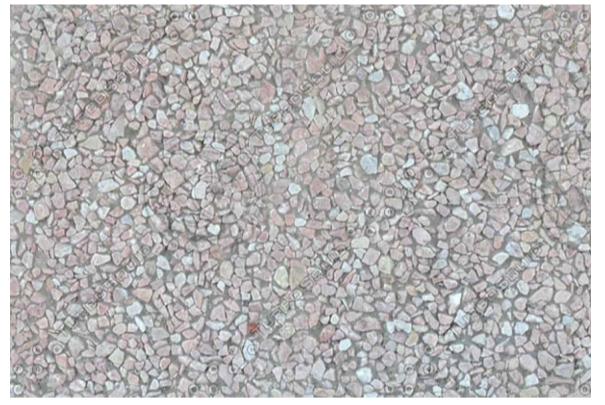
**CODE :** W.C-01

SPECIFICATION :  
 STEPPING STONE WALL ( AJLOUN STONE )  
 FINISH : حجر بيتون  
 DIMENSION : 20-35CM \*40 CM \* 50 CM




**CODE :** W.T-02

SPECIFICATION :  
 RETAINING WALL ( AJLOUN STONE )  
 FINISH : حجر بيتون  
 DIMENSION : (10 CM , 20 CM , 30 CM ) \* RANDOM





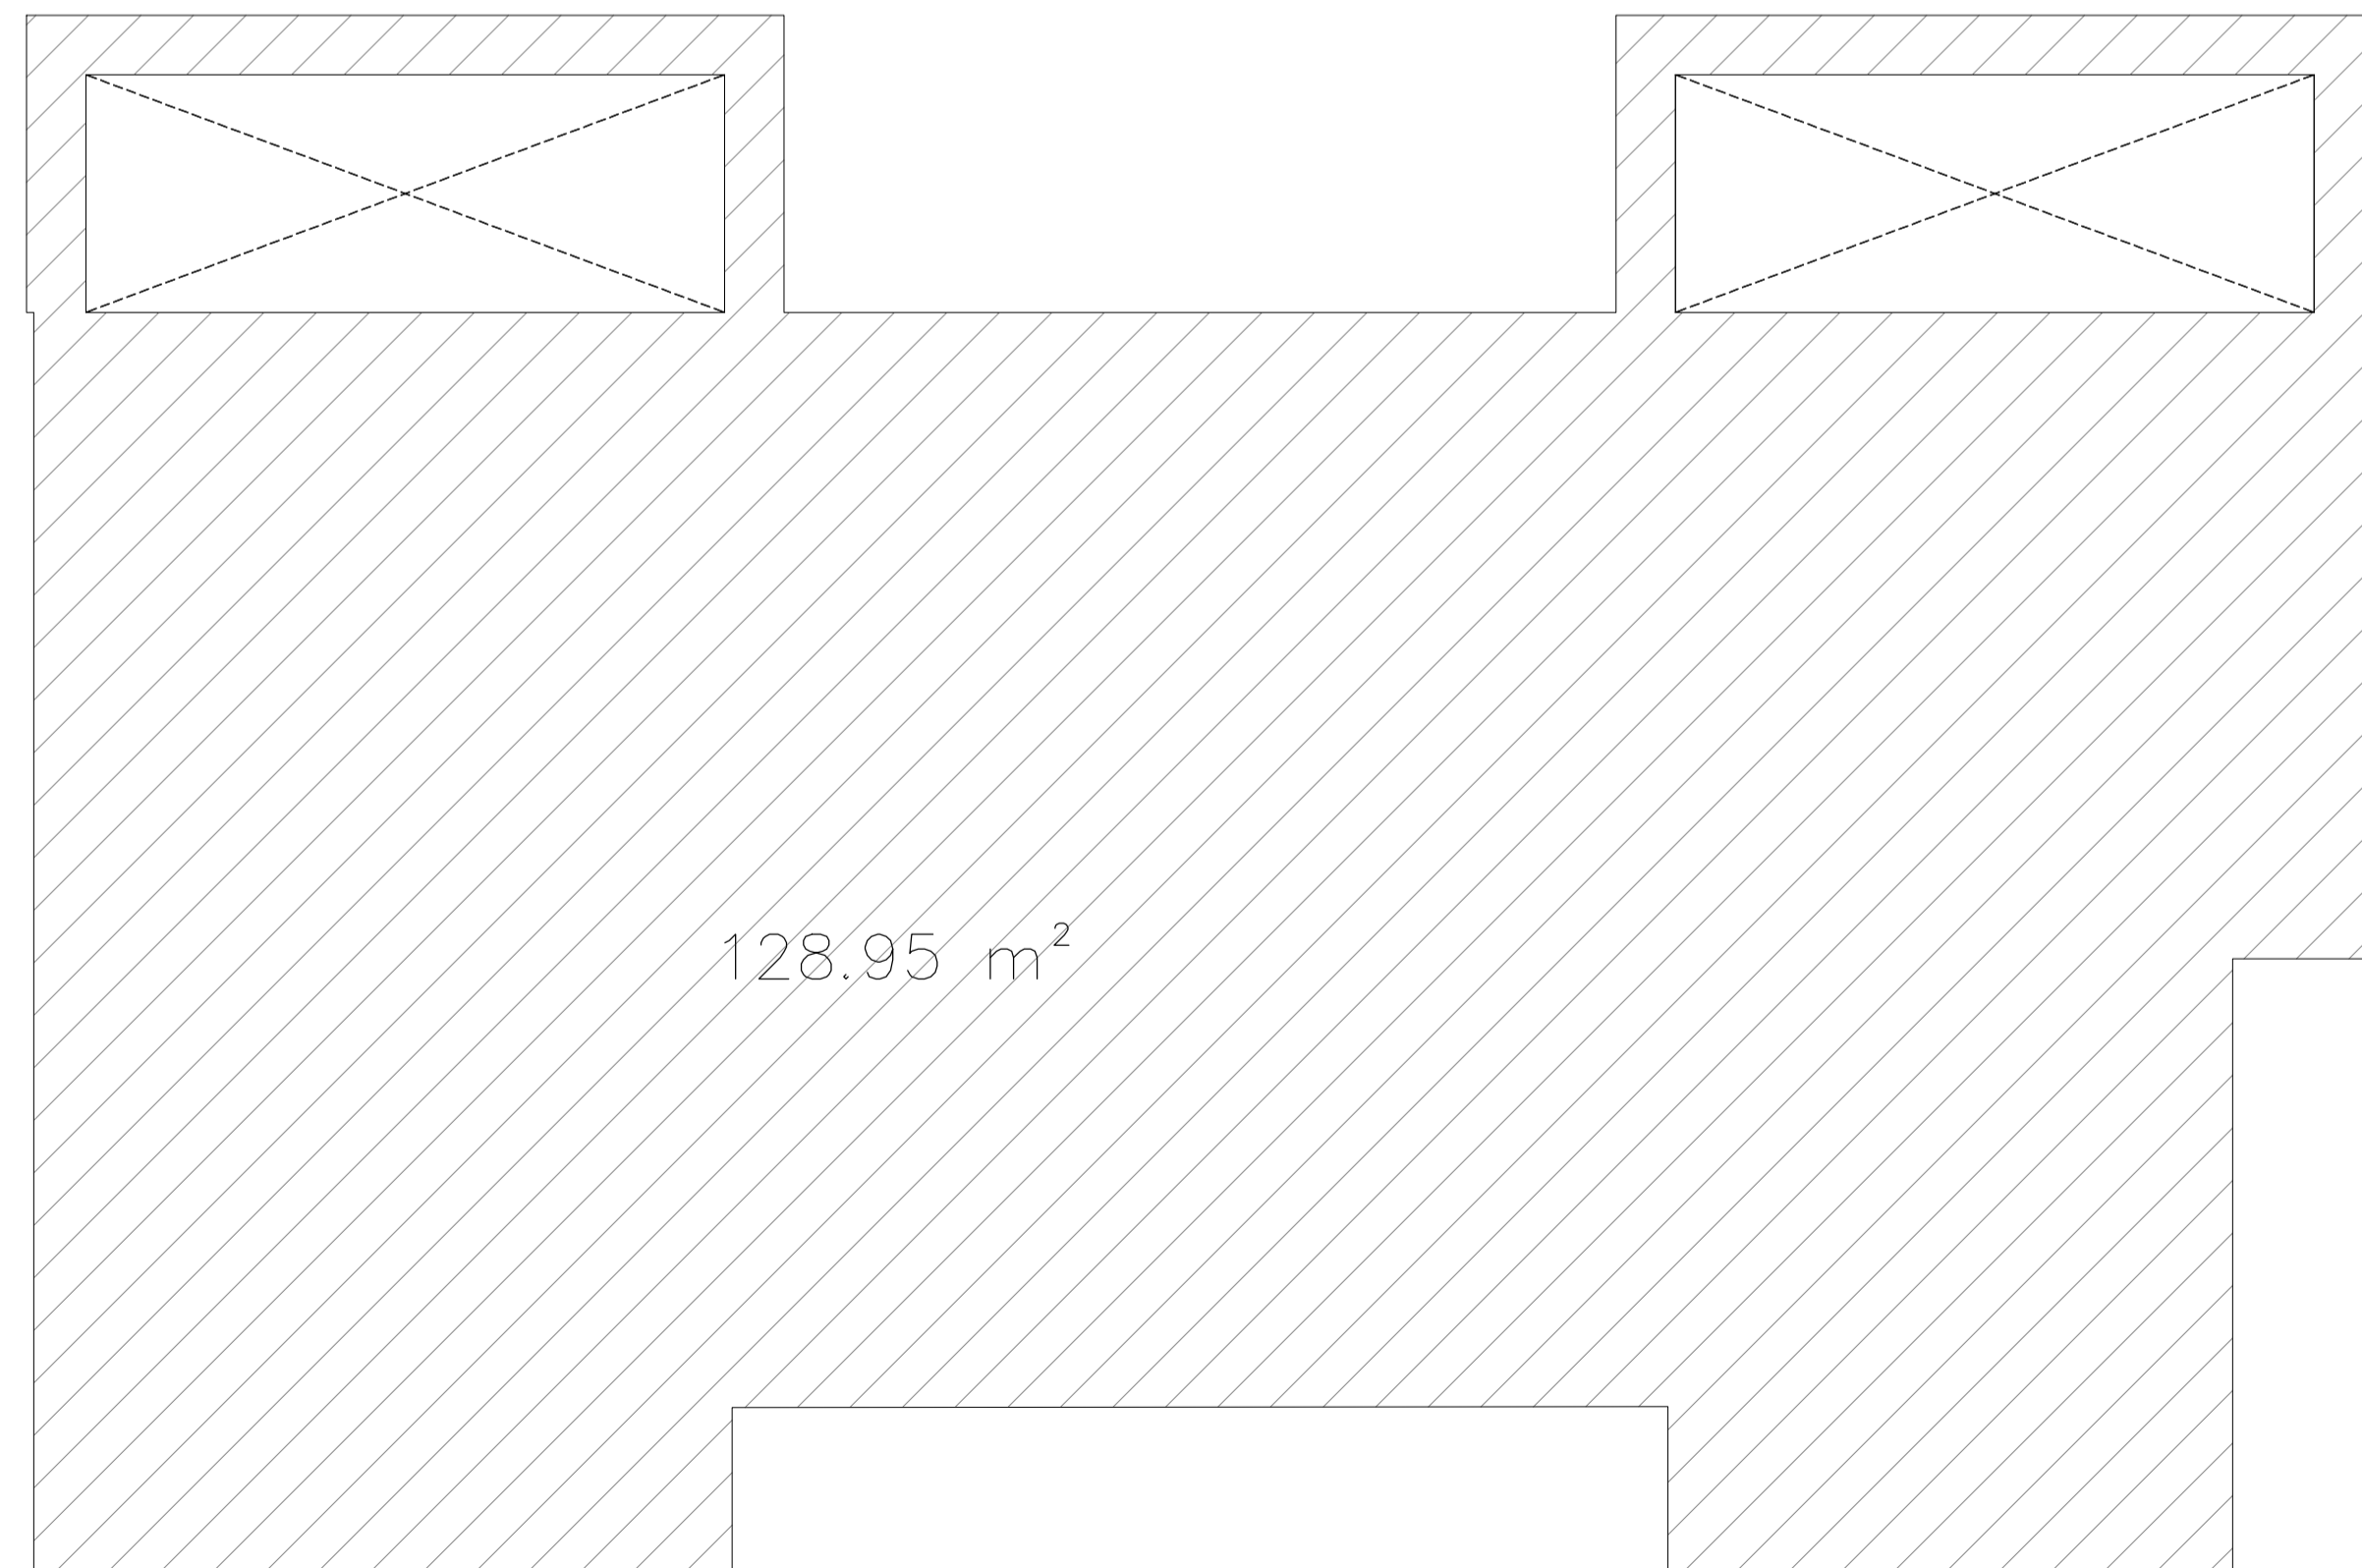


TABLE OF AREA CALCULATION

FLOOR	AREA/m <sup>2</sup>
GROUND FLOOR	128.95
Total Area :	128.9500 m <sup>2</sup>

GROUND FLOOR PLAN- PLAZA  
1:50

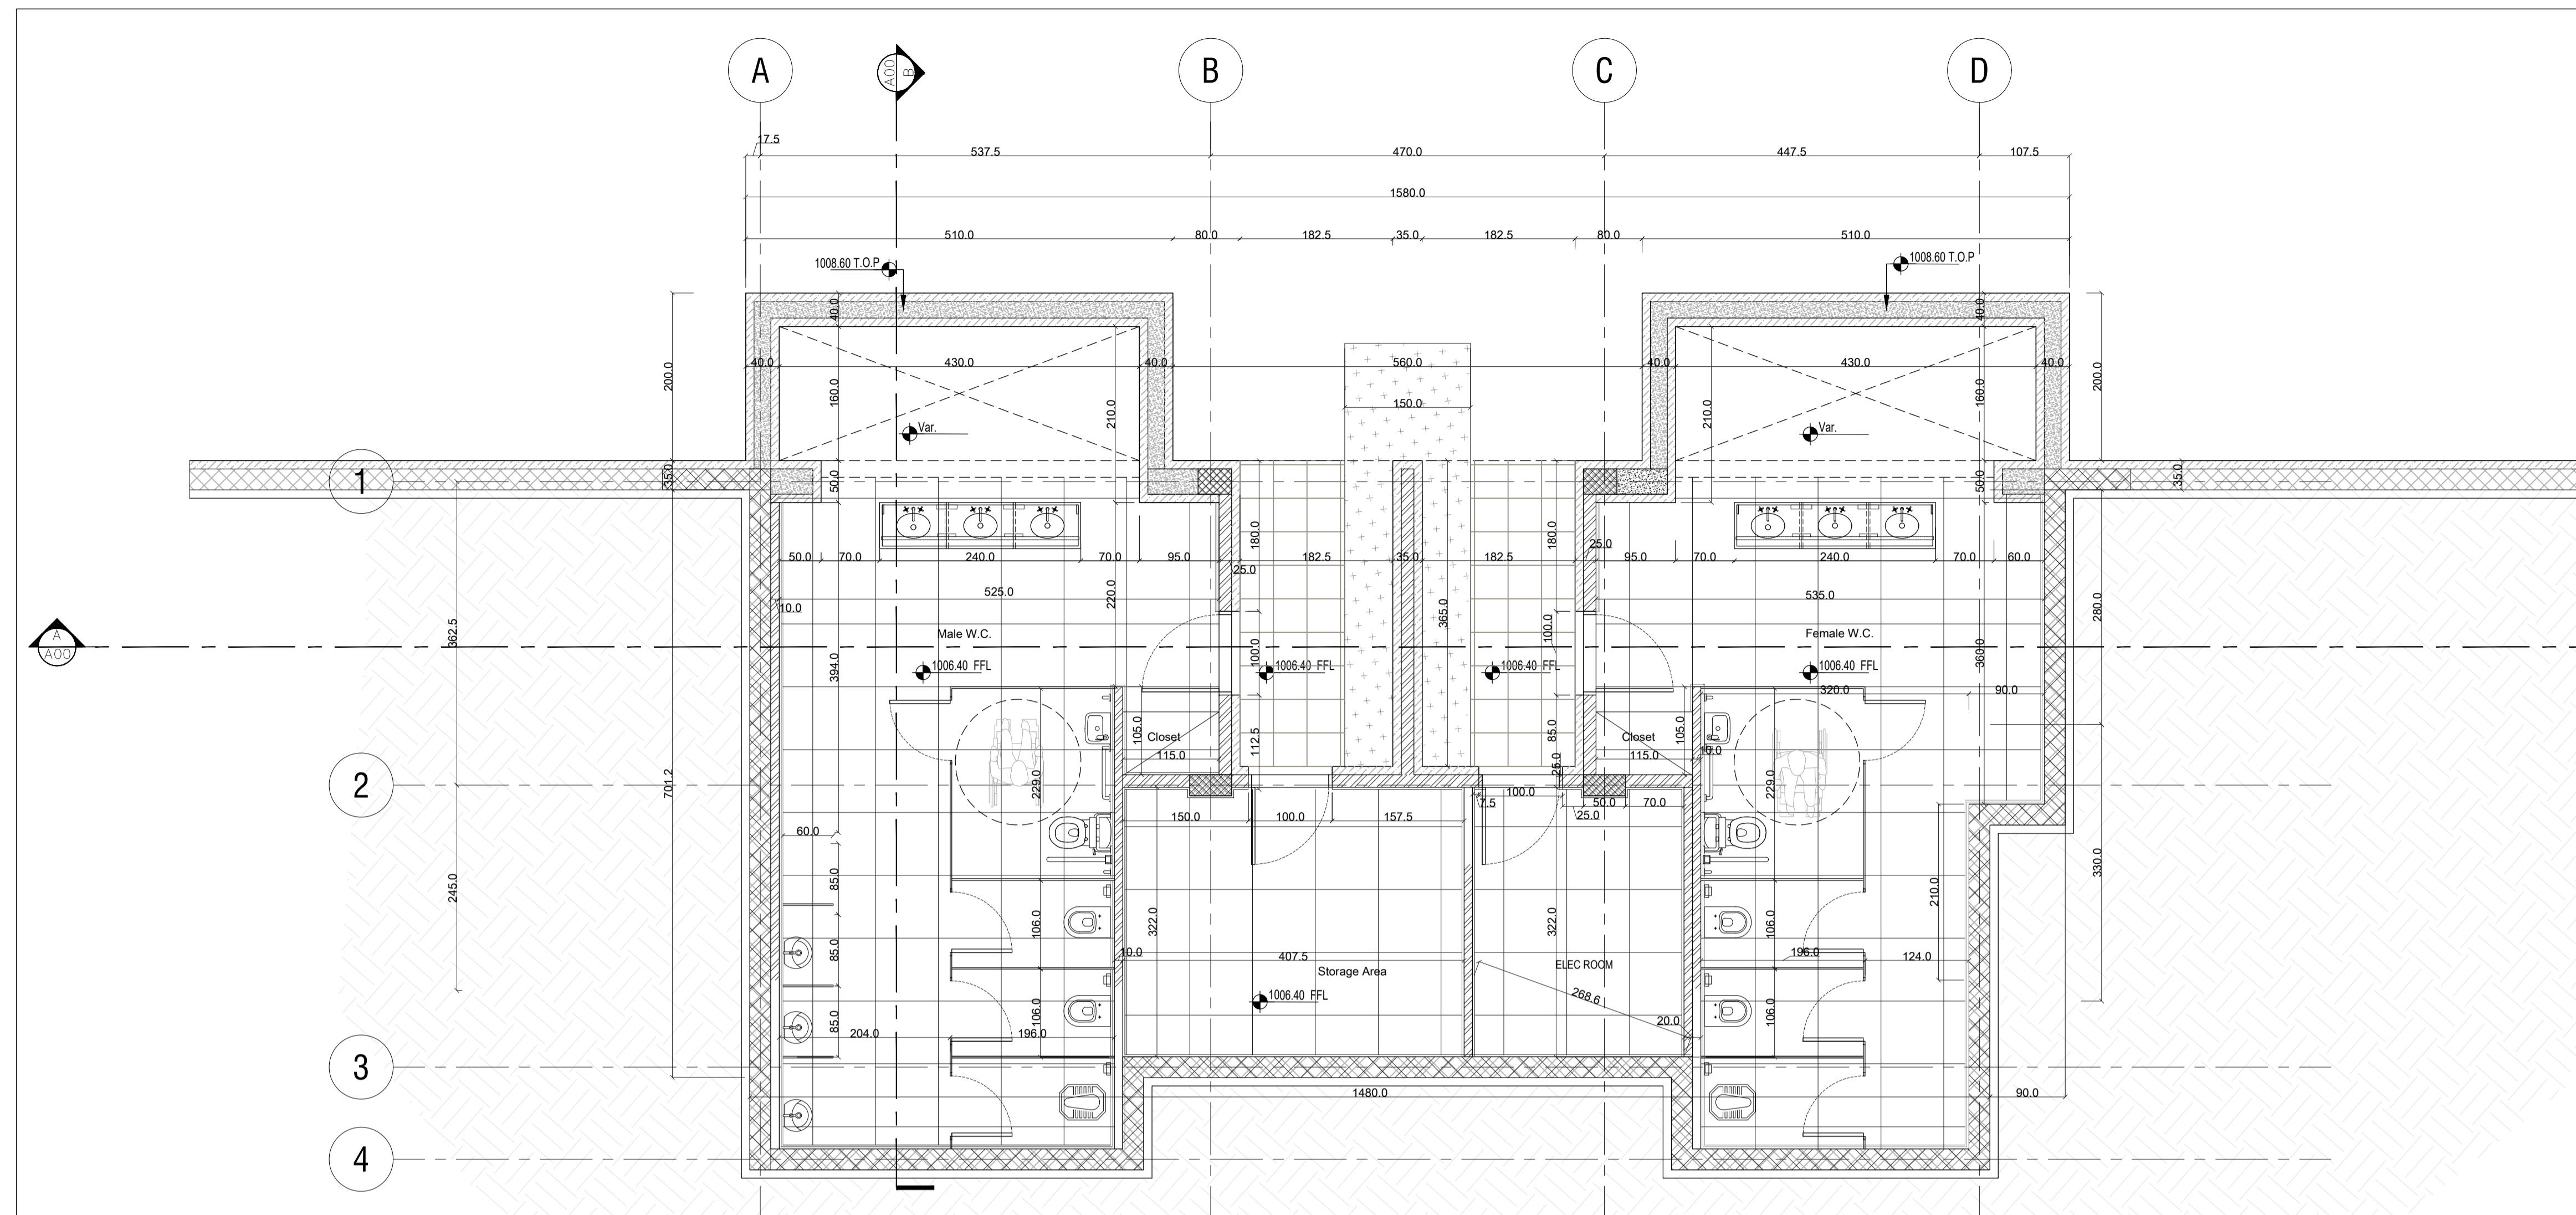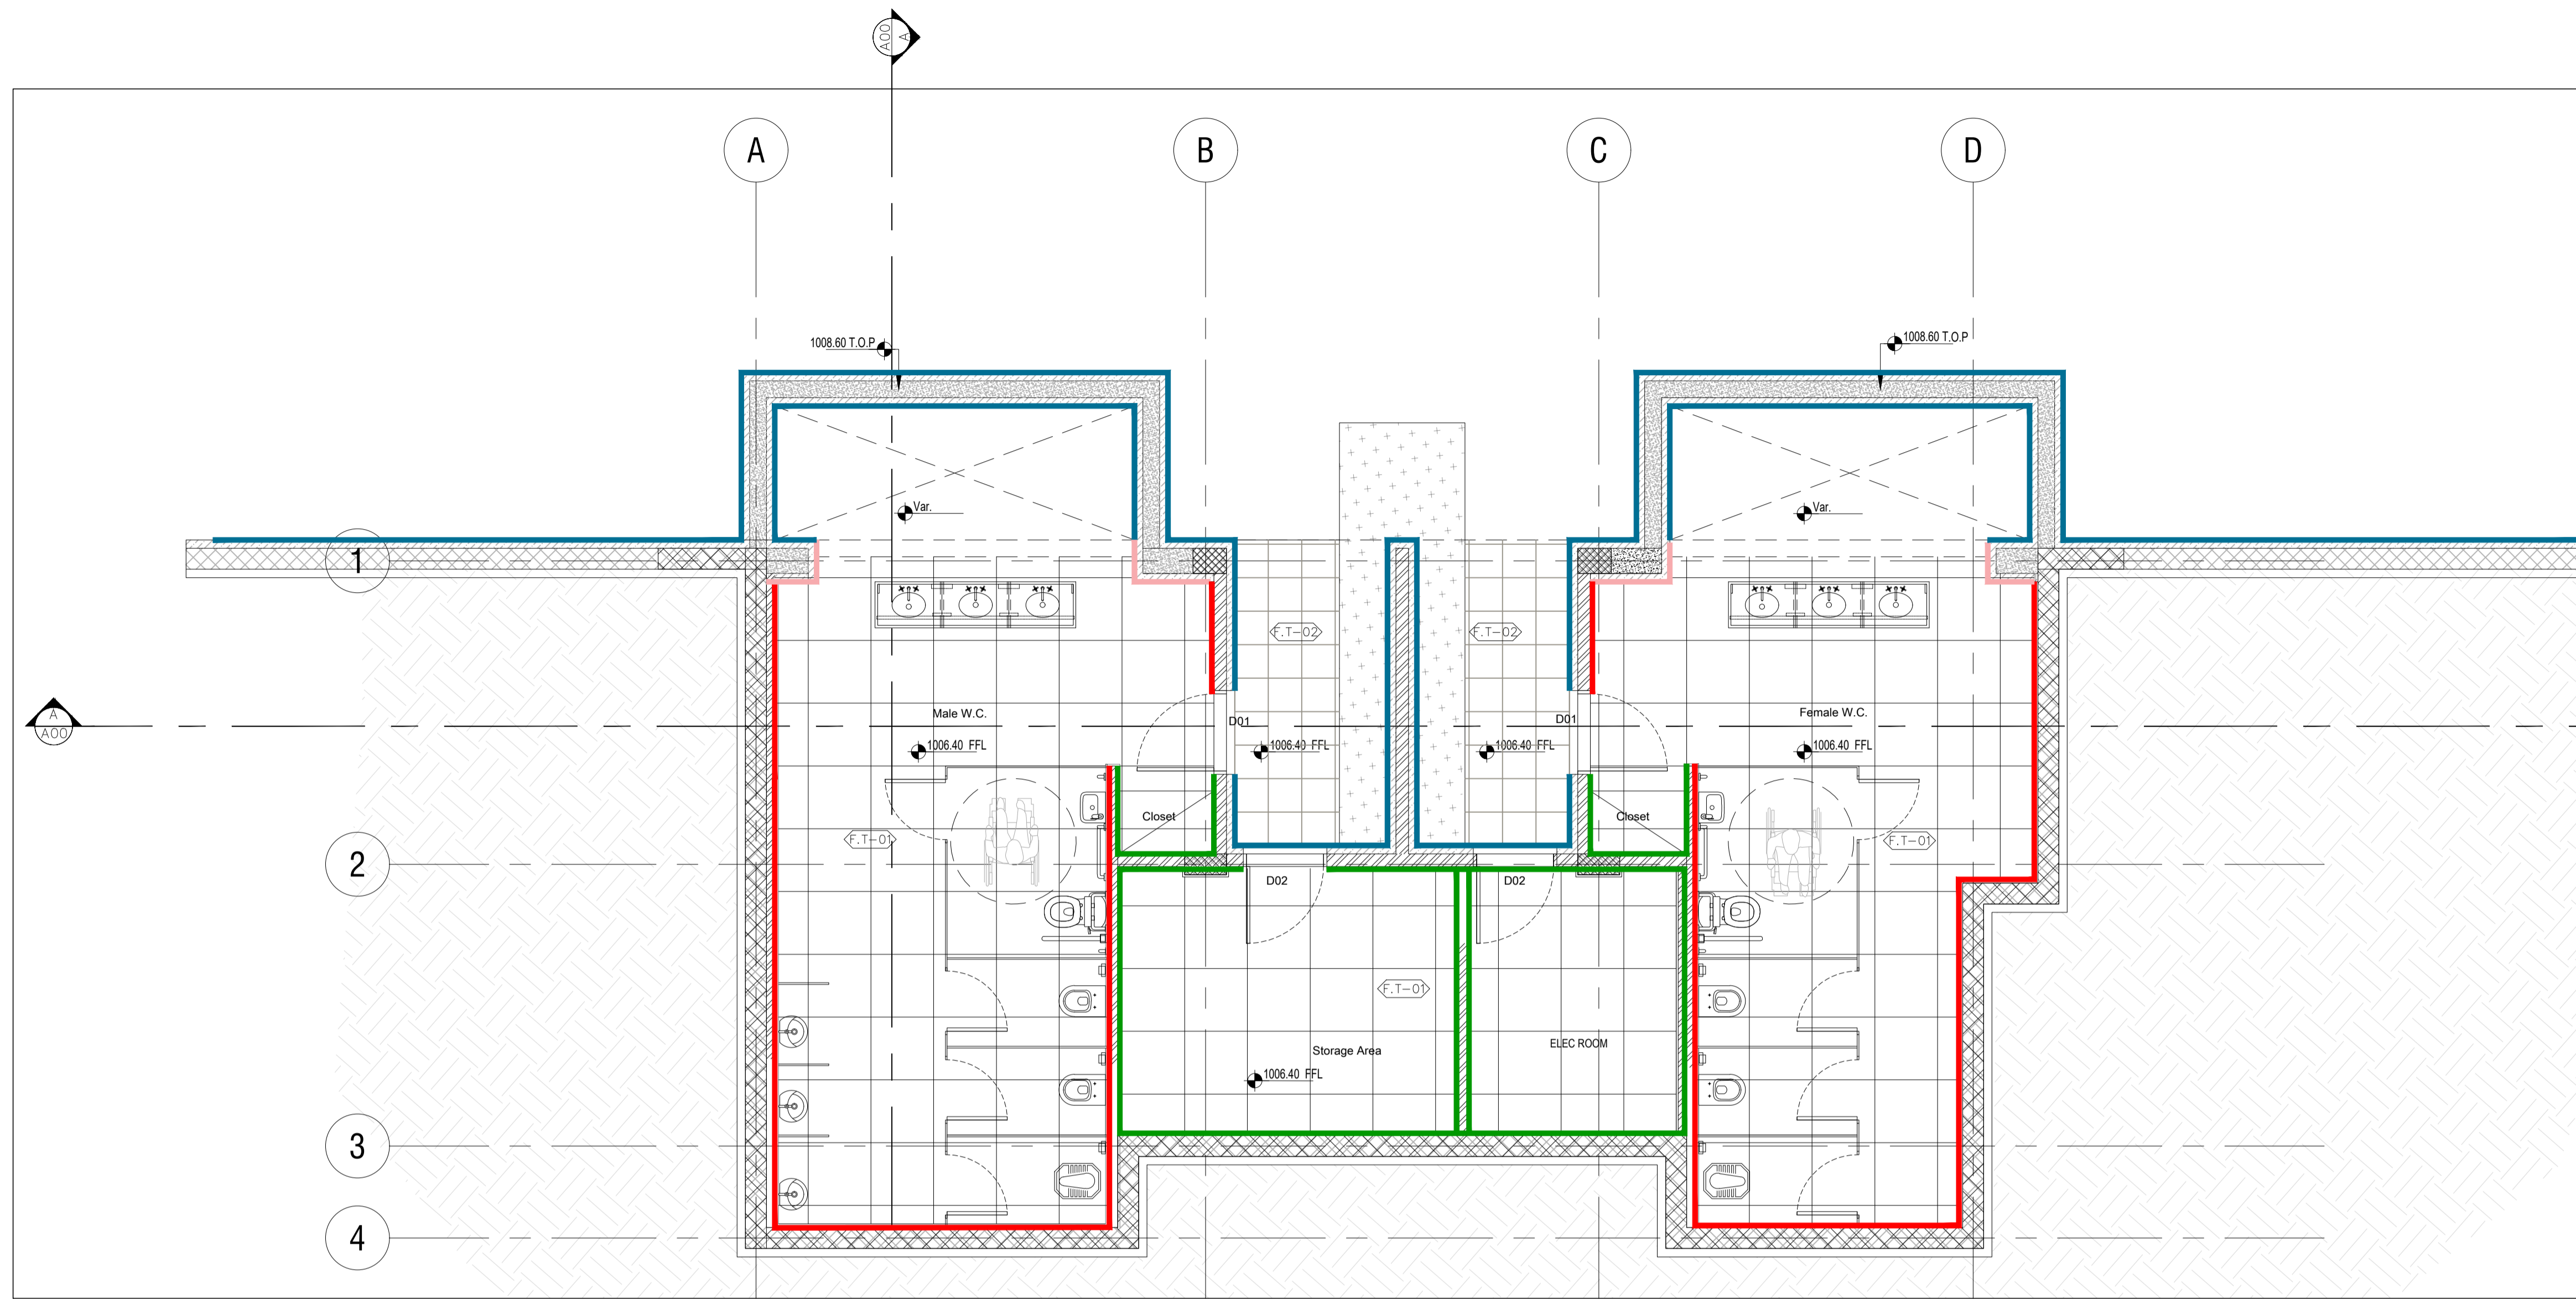

**WALLS FINISHING**


CODE	IMAGE	SPECS
W.T-01		DESERT COLOR/ SPANISH-PLAIN PORCELAIN SIZE : 75*75
W.T-02		AJLOUN STONE -MATABEH BRUSHED- THE10. CM
W.T-03		MATABEH STONE
W.T-04		PLASTER

**FLOOR FINISHING**


CODE	IMAGE	SPECS
F.T-01		DESERT COLOR/ SPANISH-PLAIN PORCELAIN FINISH : MATT SIZE : 75*75 LOCATION : Prayer Hall & Guard room & Ambulation
F.T-02		EXPOSED AGGREGATE TILES 40X40X4CM

**DOORS SCHEDULE**


TYPE	OPENING SIZE	LEAF TYPE	QUANTITY	TYPE	OPENING SIZE	LEAF TYPE	QUANTITY
WOOD DOOR	100cm W X 214cm H	HOLLOW CORE TIMBER DOOR	02	STEEL DOOR	100cm W X 214cm H	HOLLOW CORE STEEL DOOR WITH LOUVERS	01
			FEMALE WC, MALE WC.				STORE

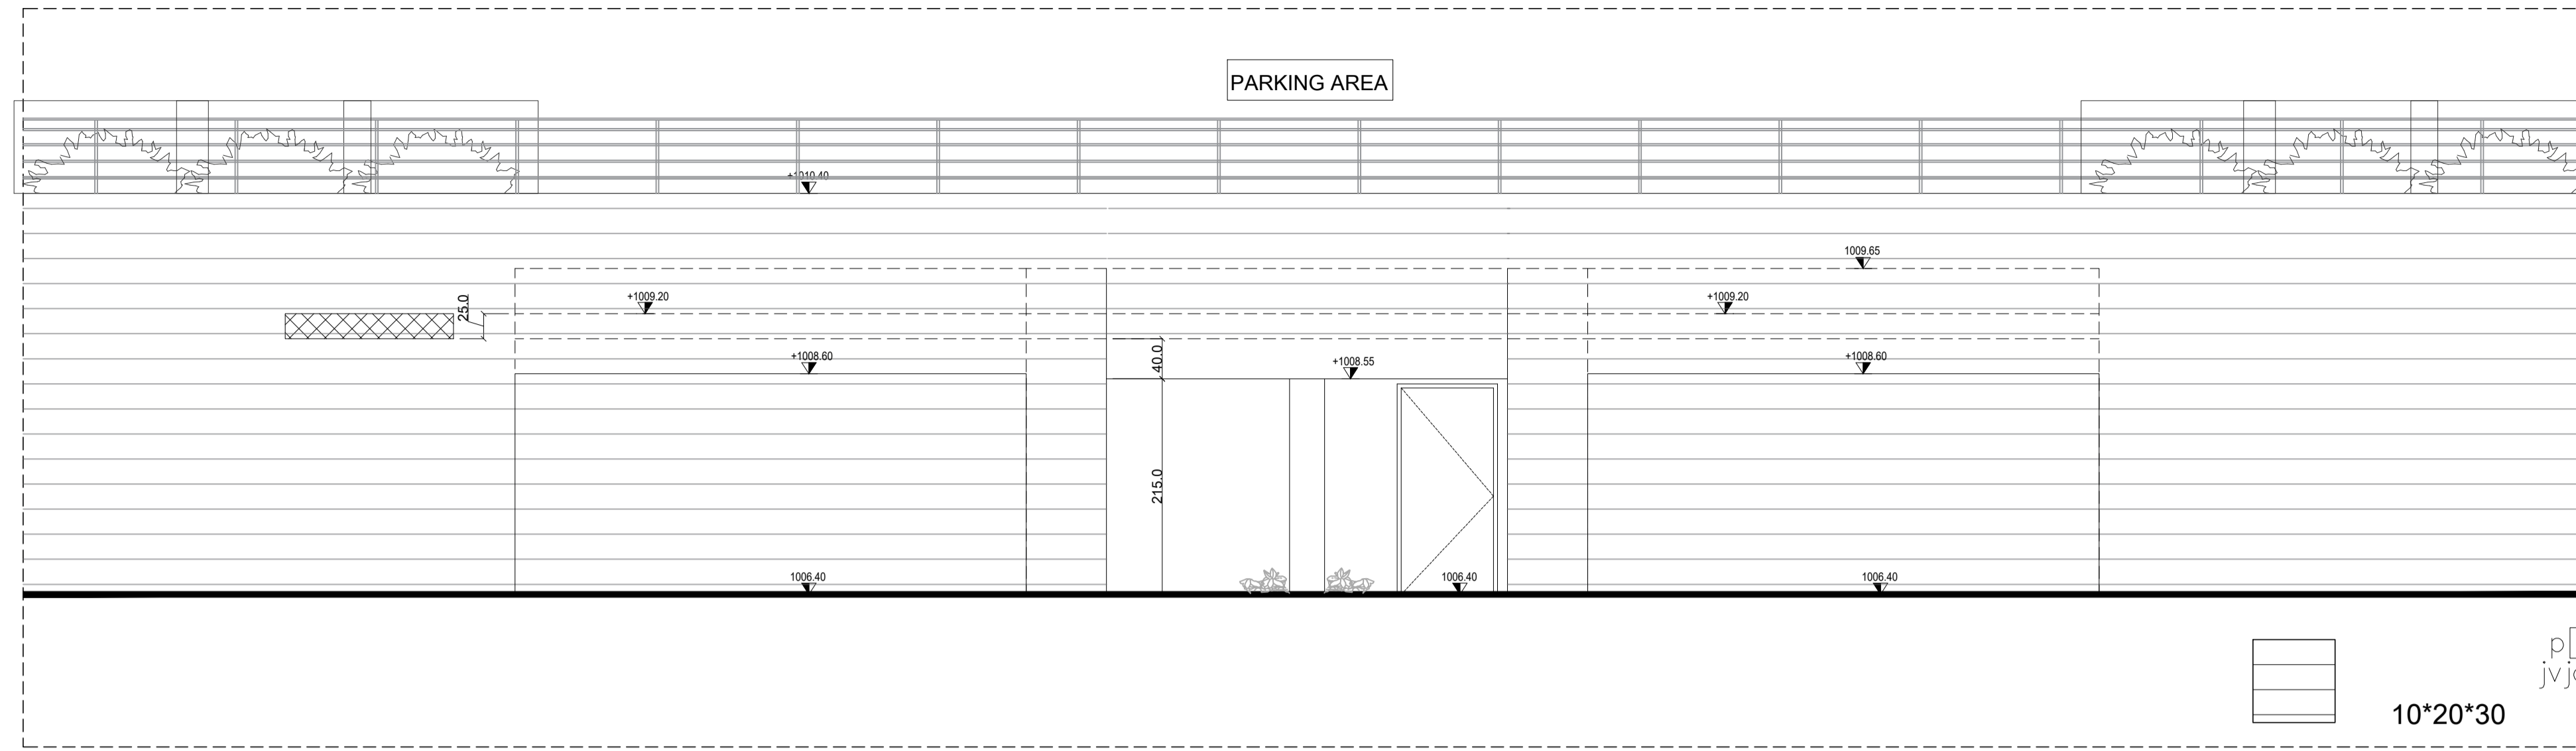


ELEVATION 01  
1:50

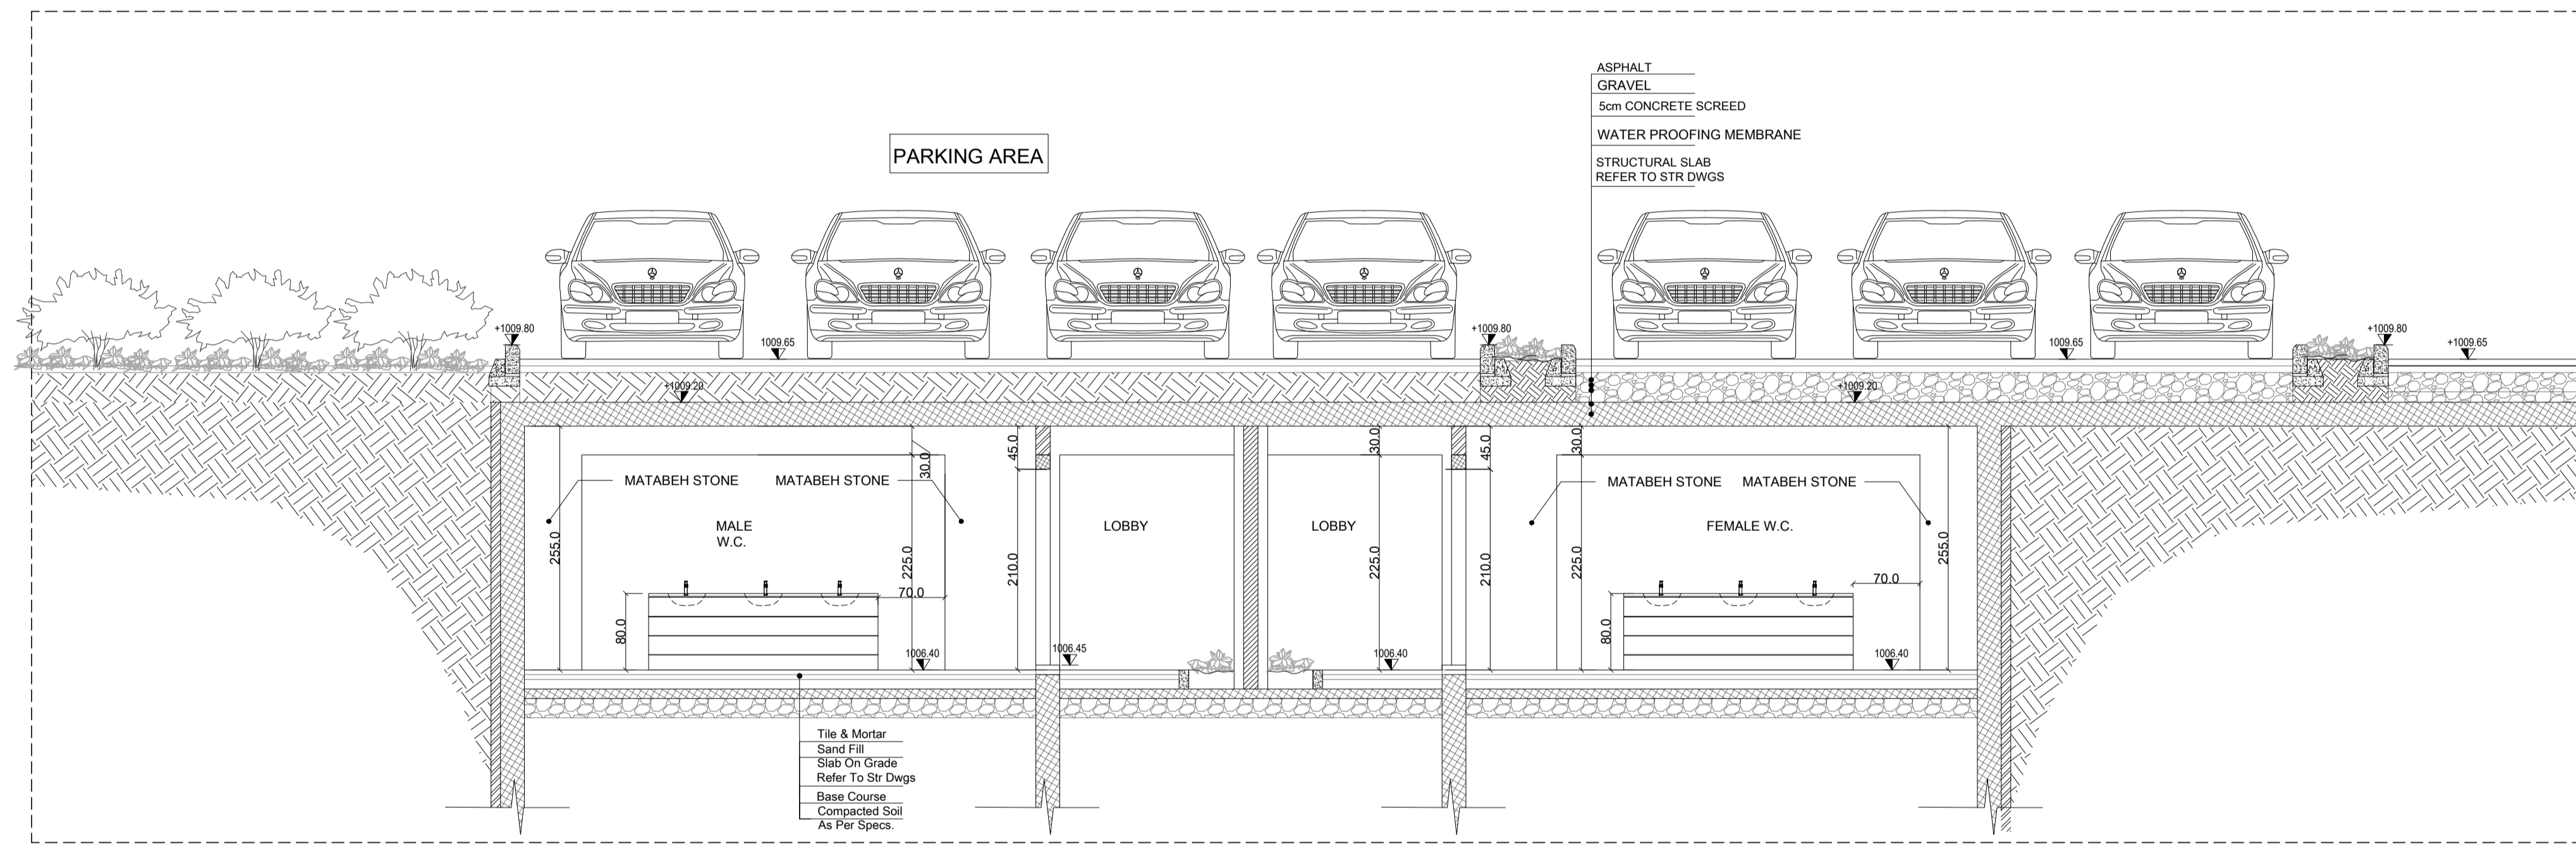



SECTION - A  
1:50

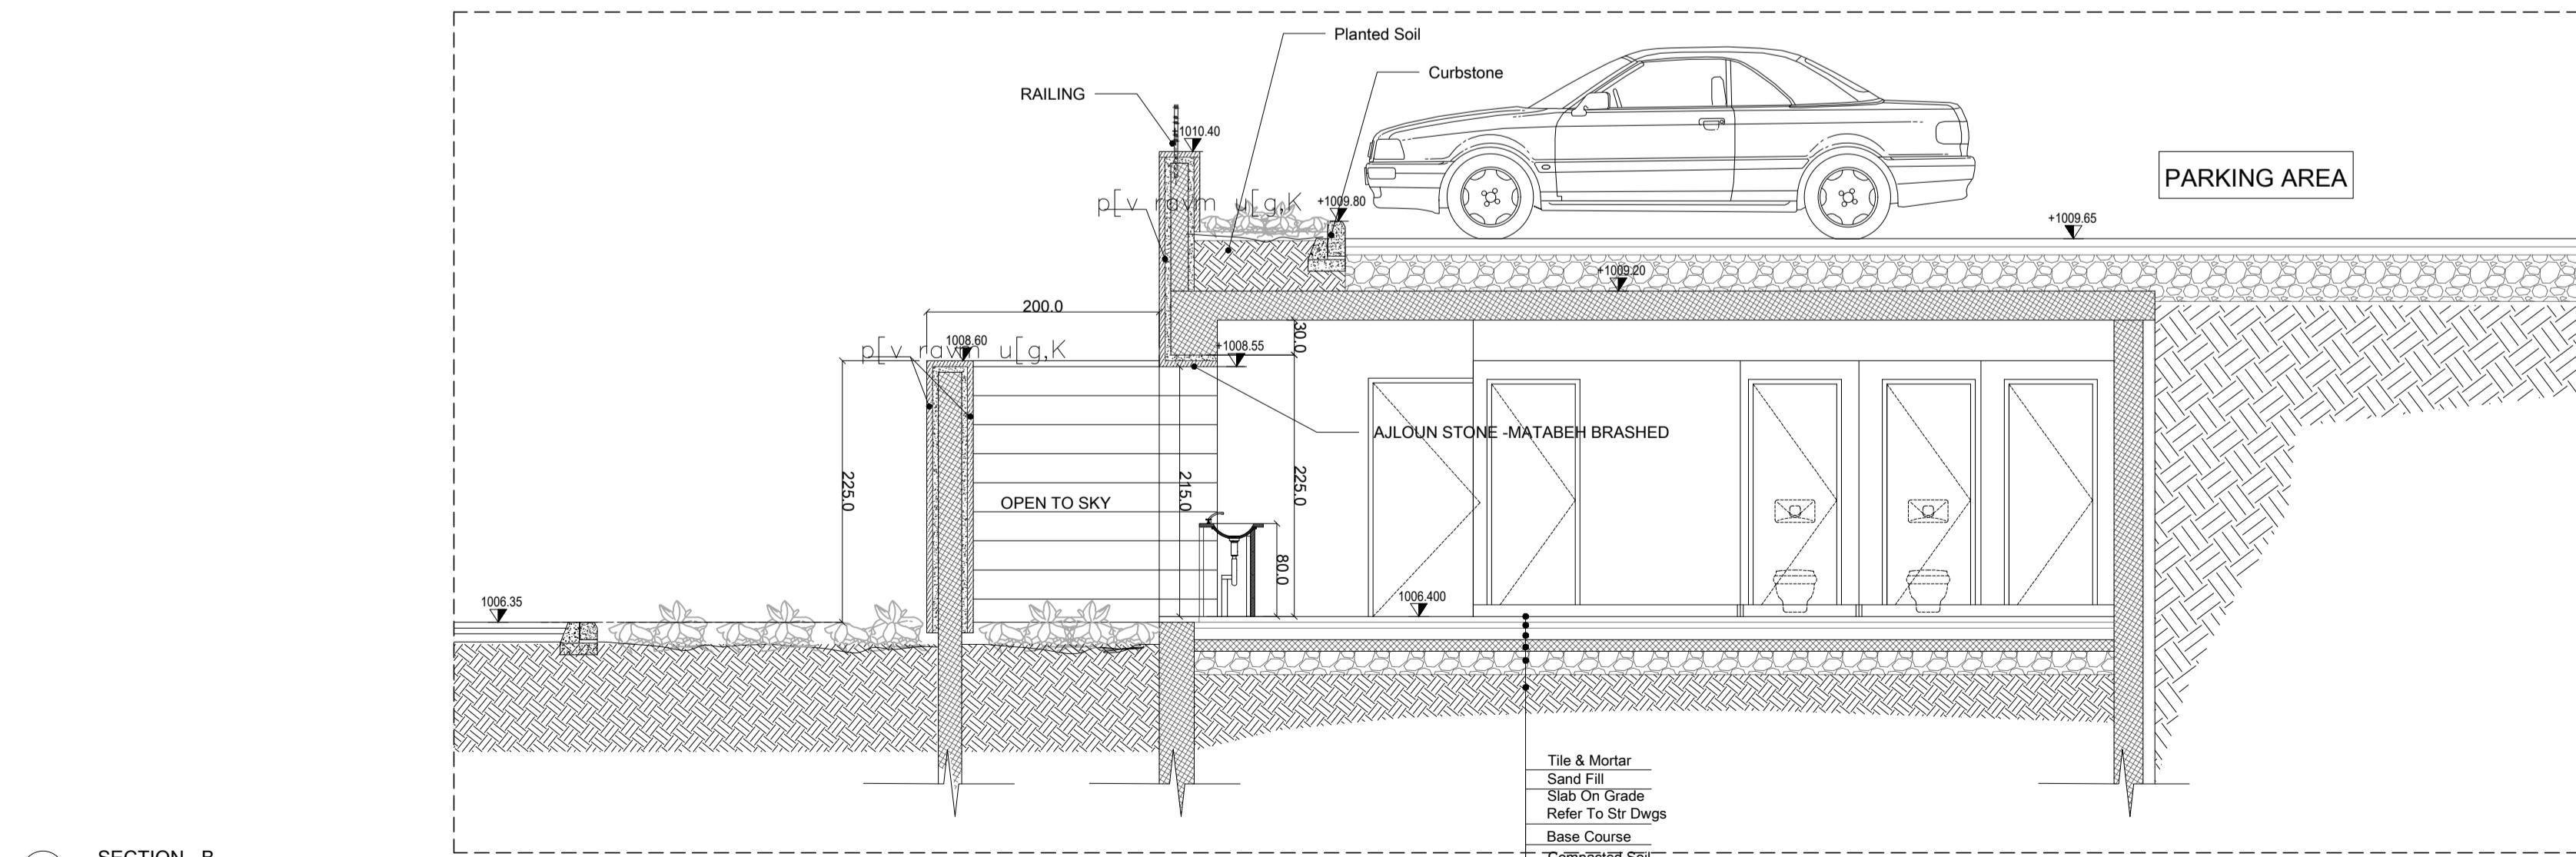

SECTION - B  
1:50

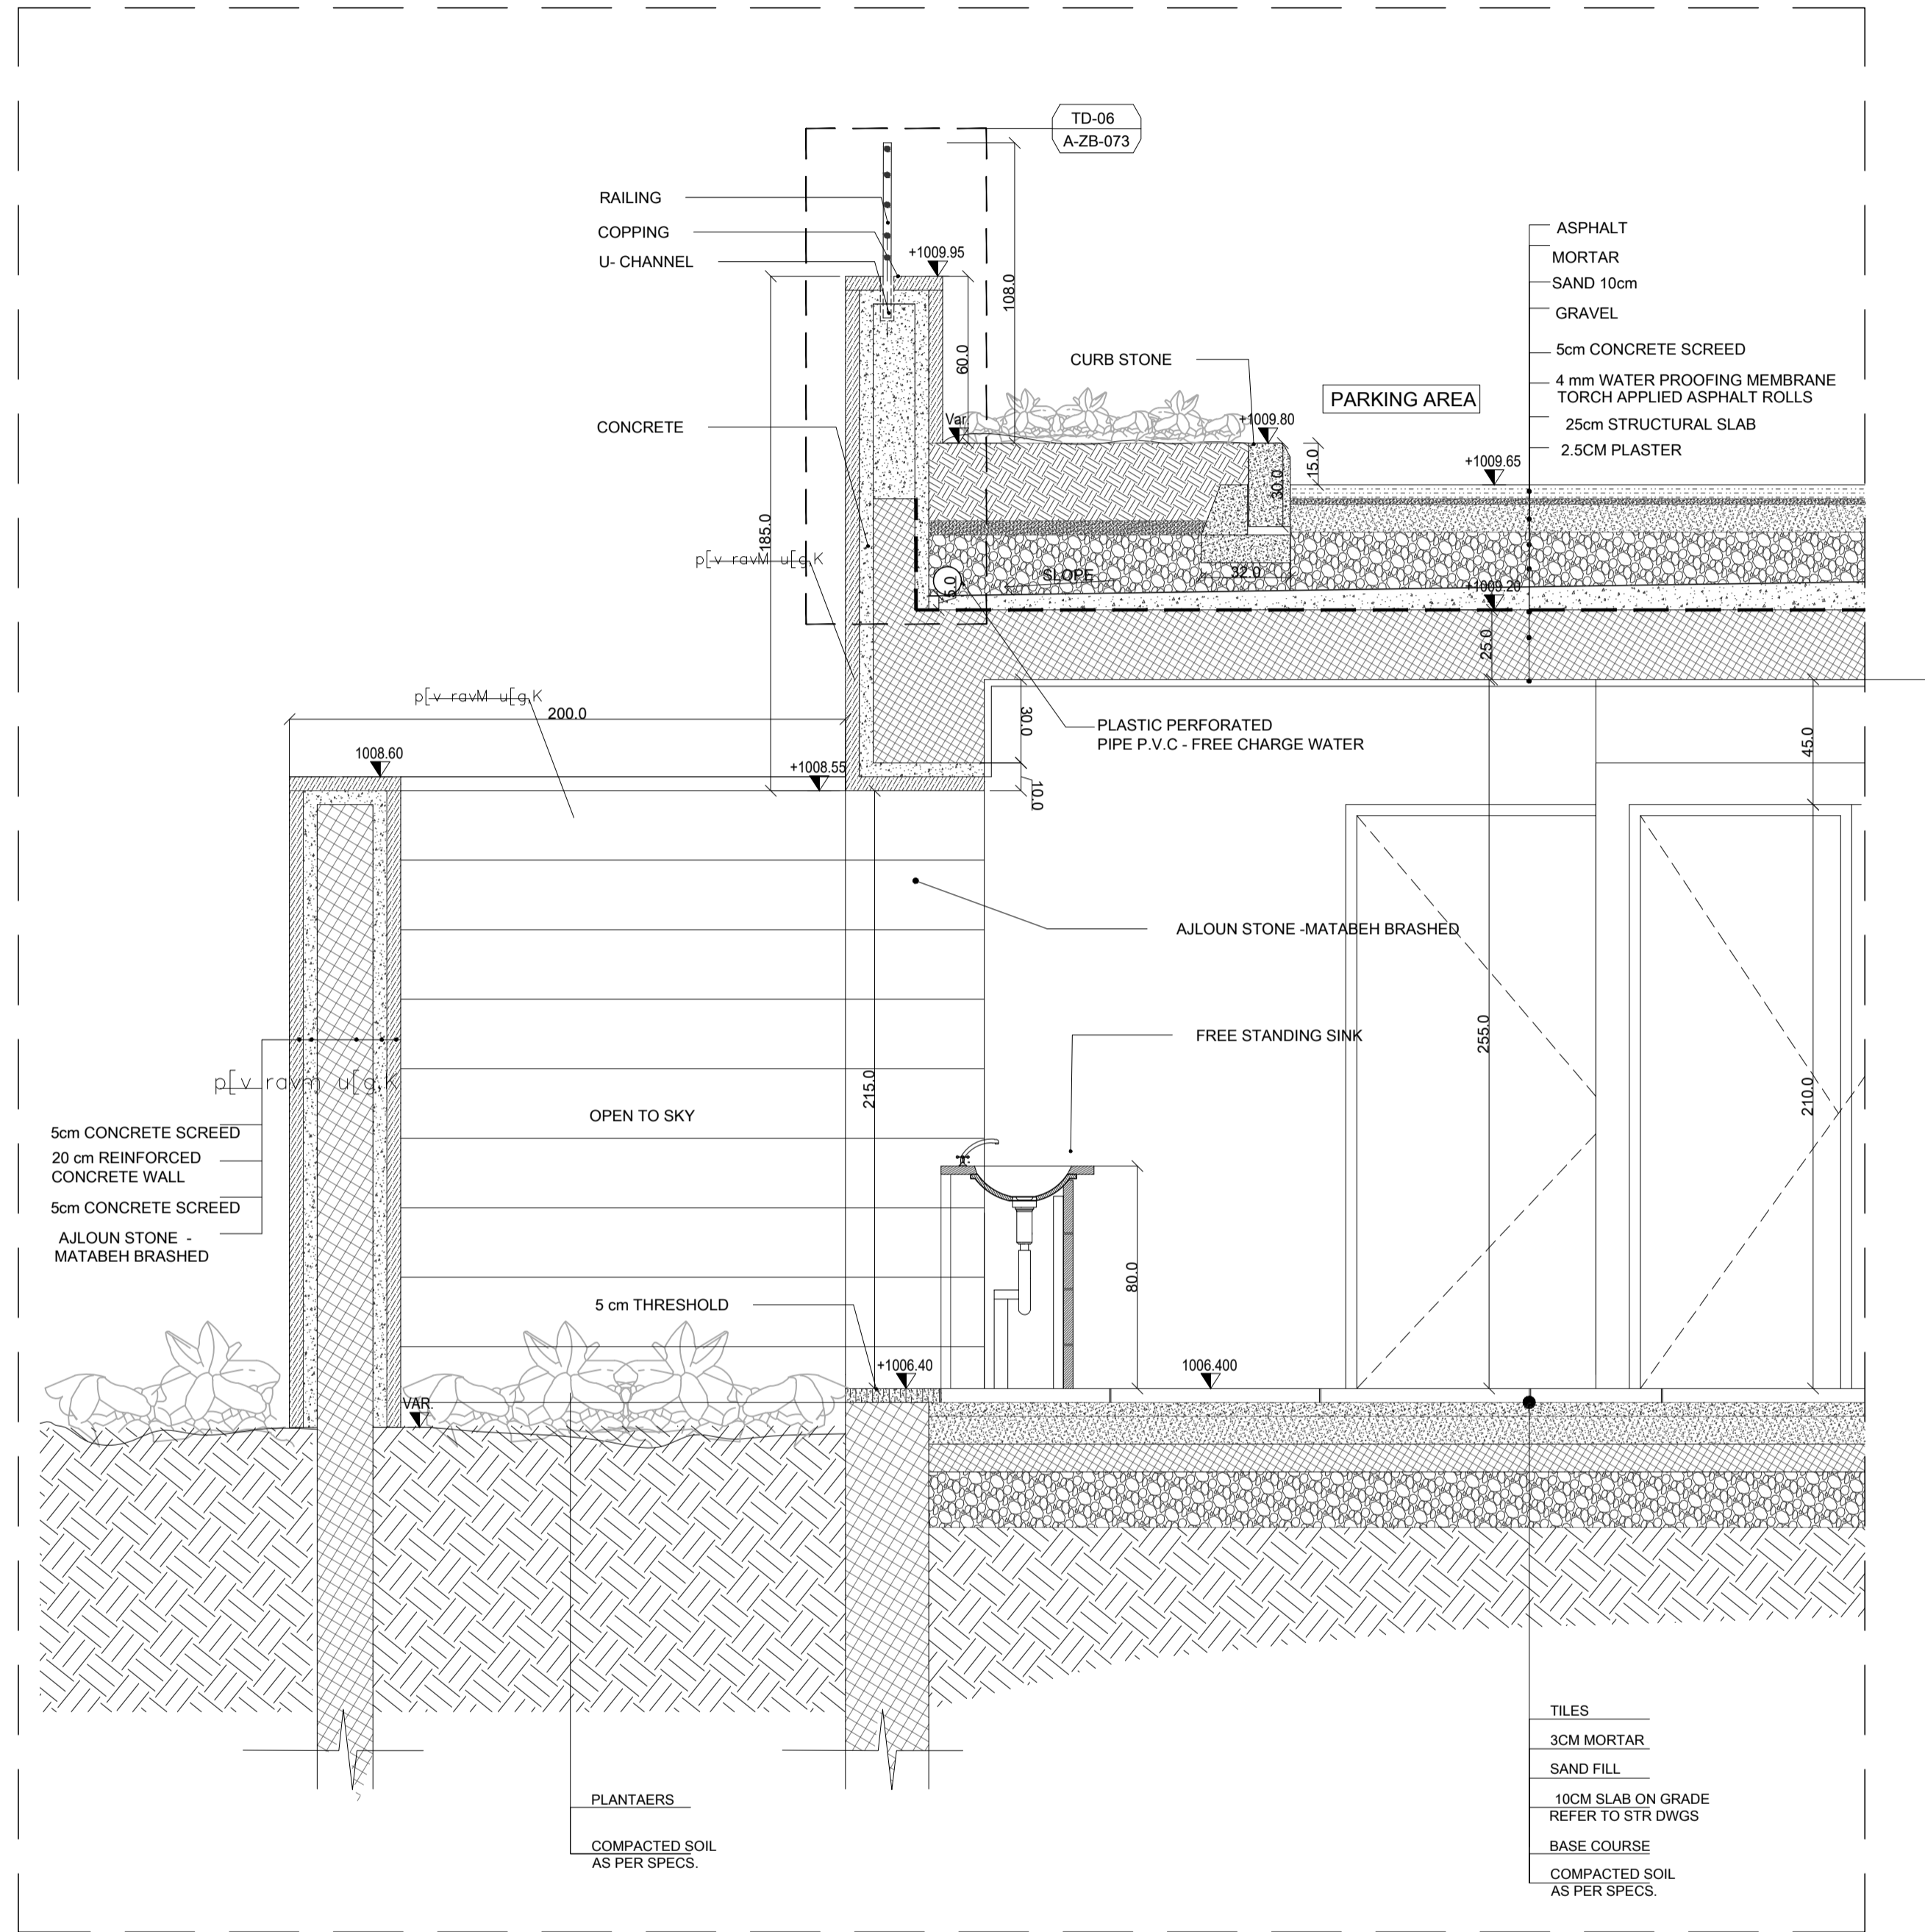

WALL SECTION 1  
1:20

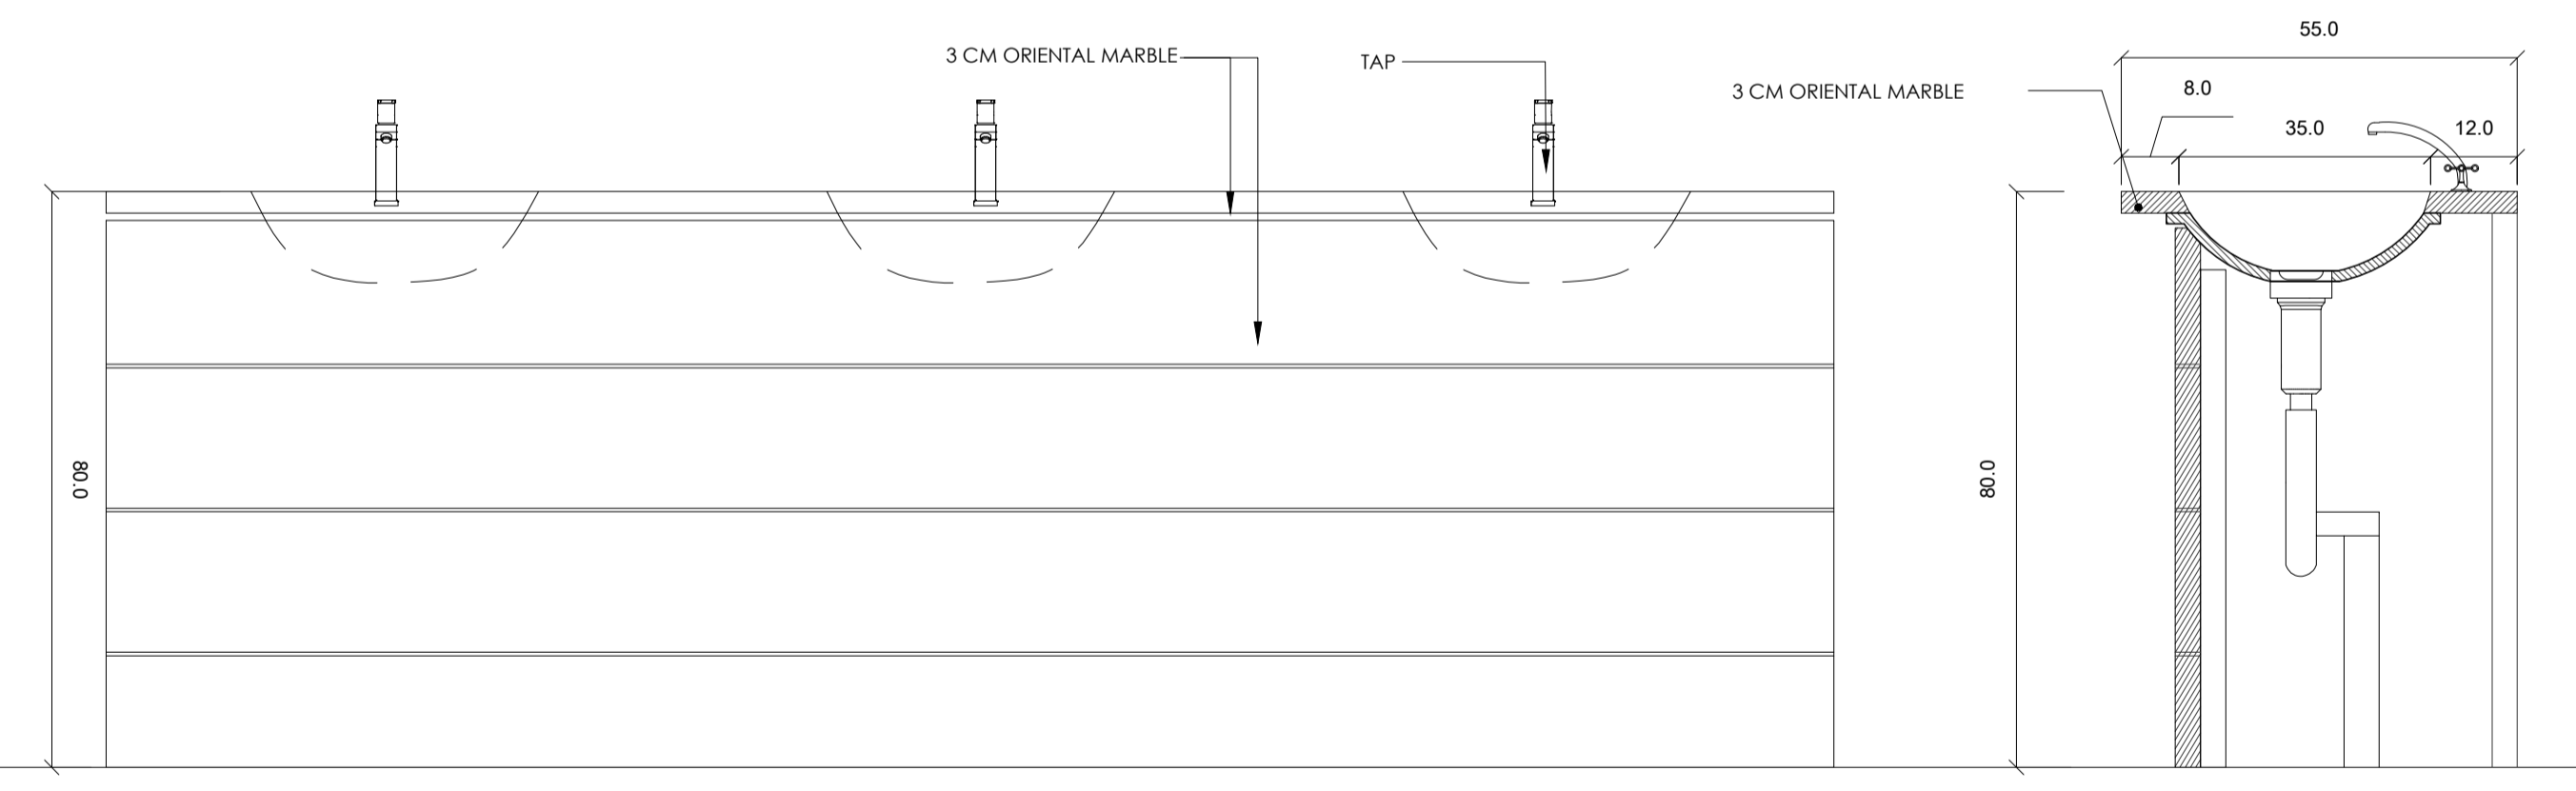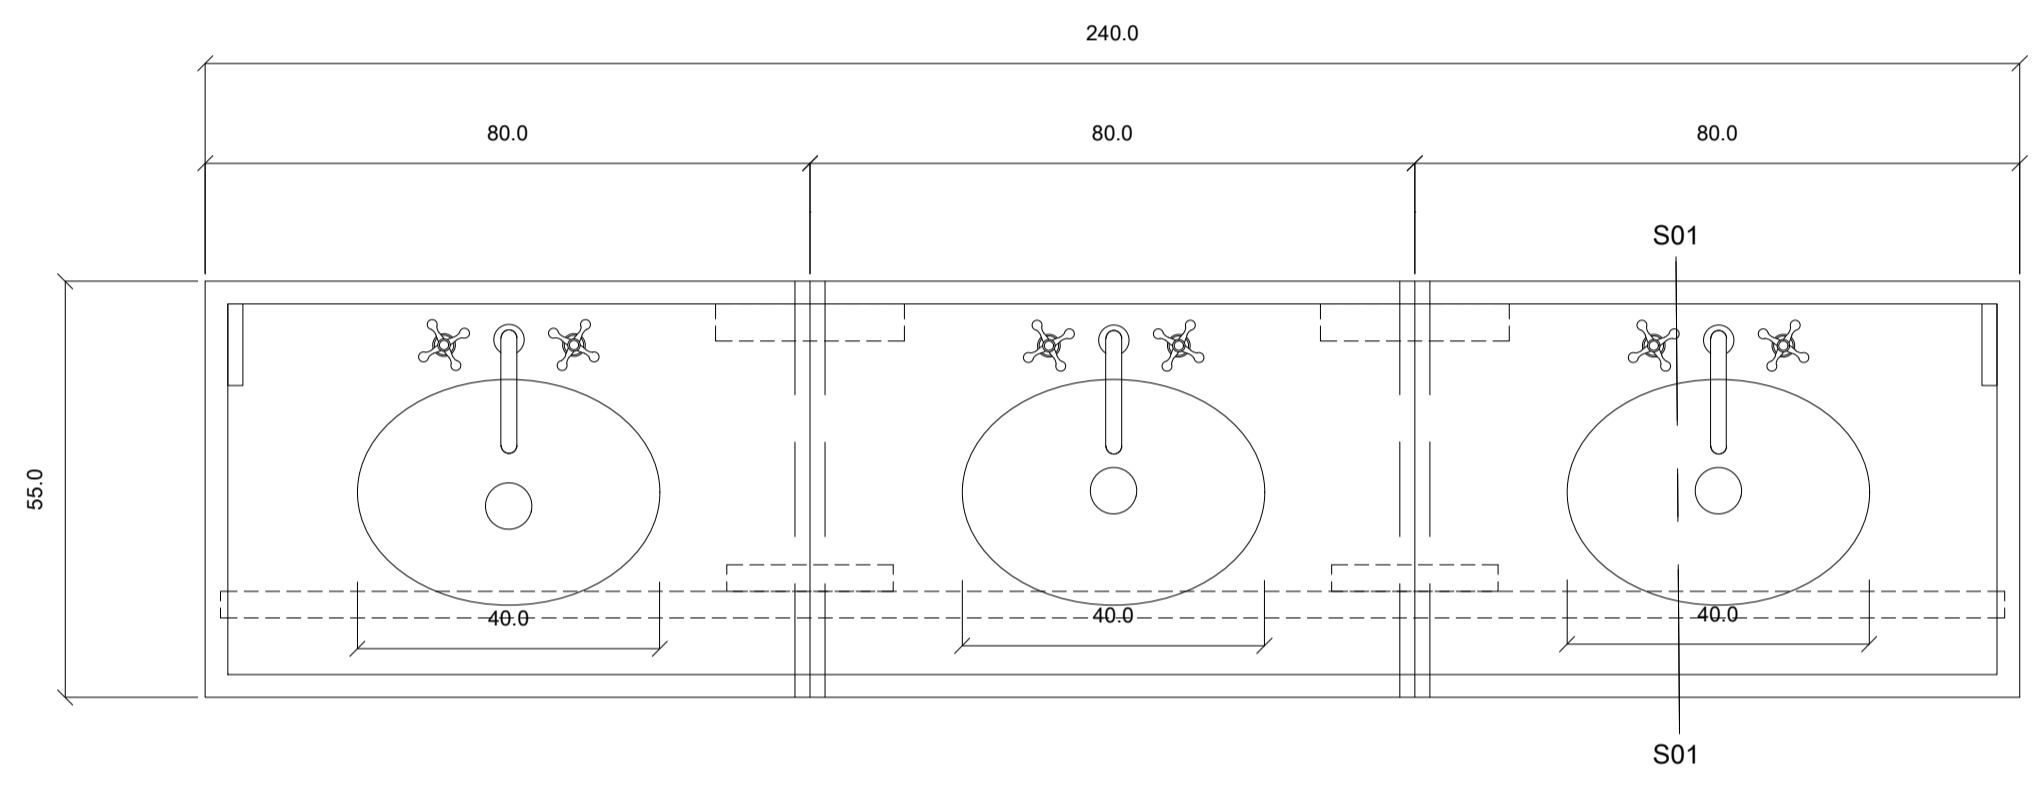

SINK DETAILS  
1:10



